


CONTINUED
DRG NO
667/F.231

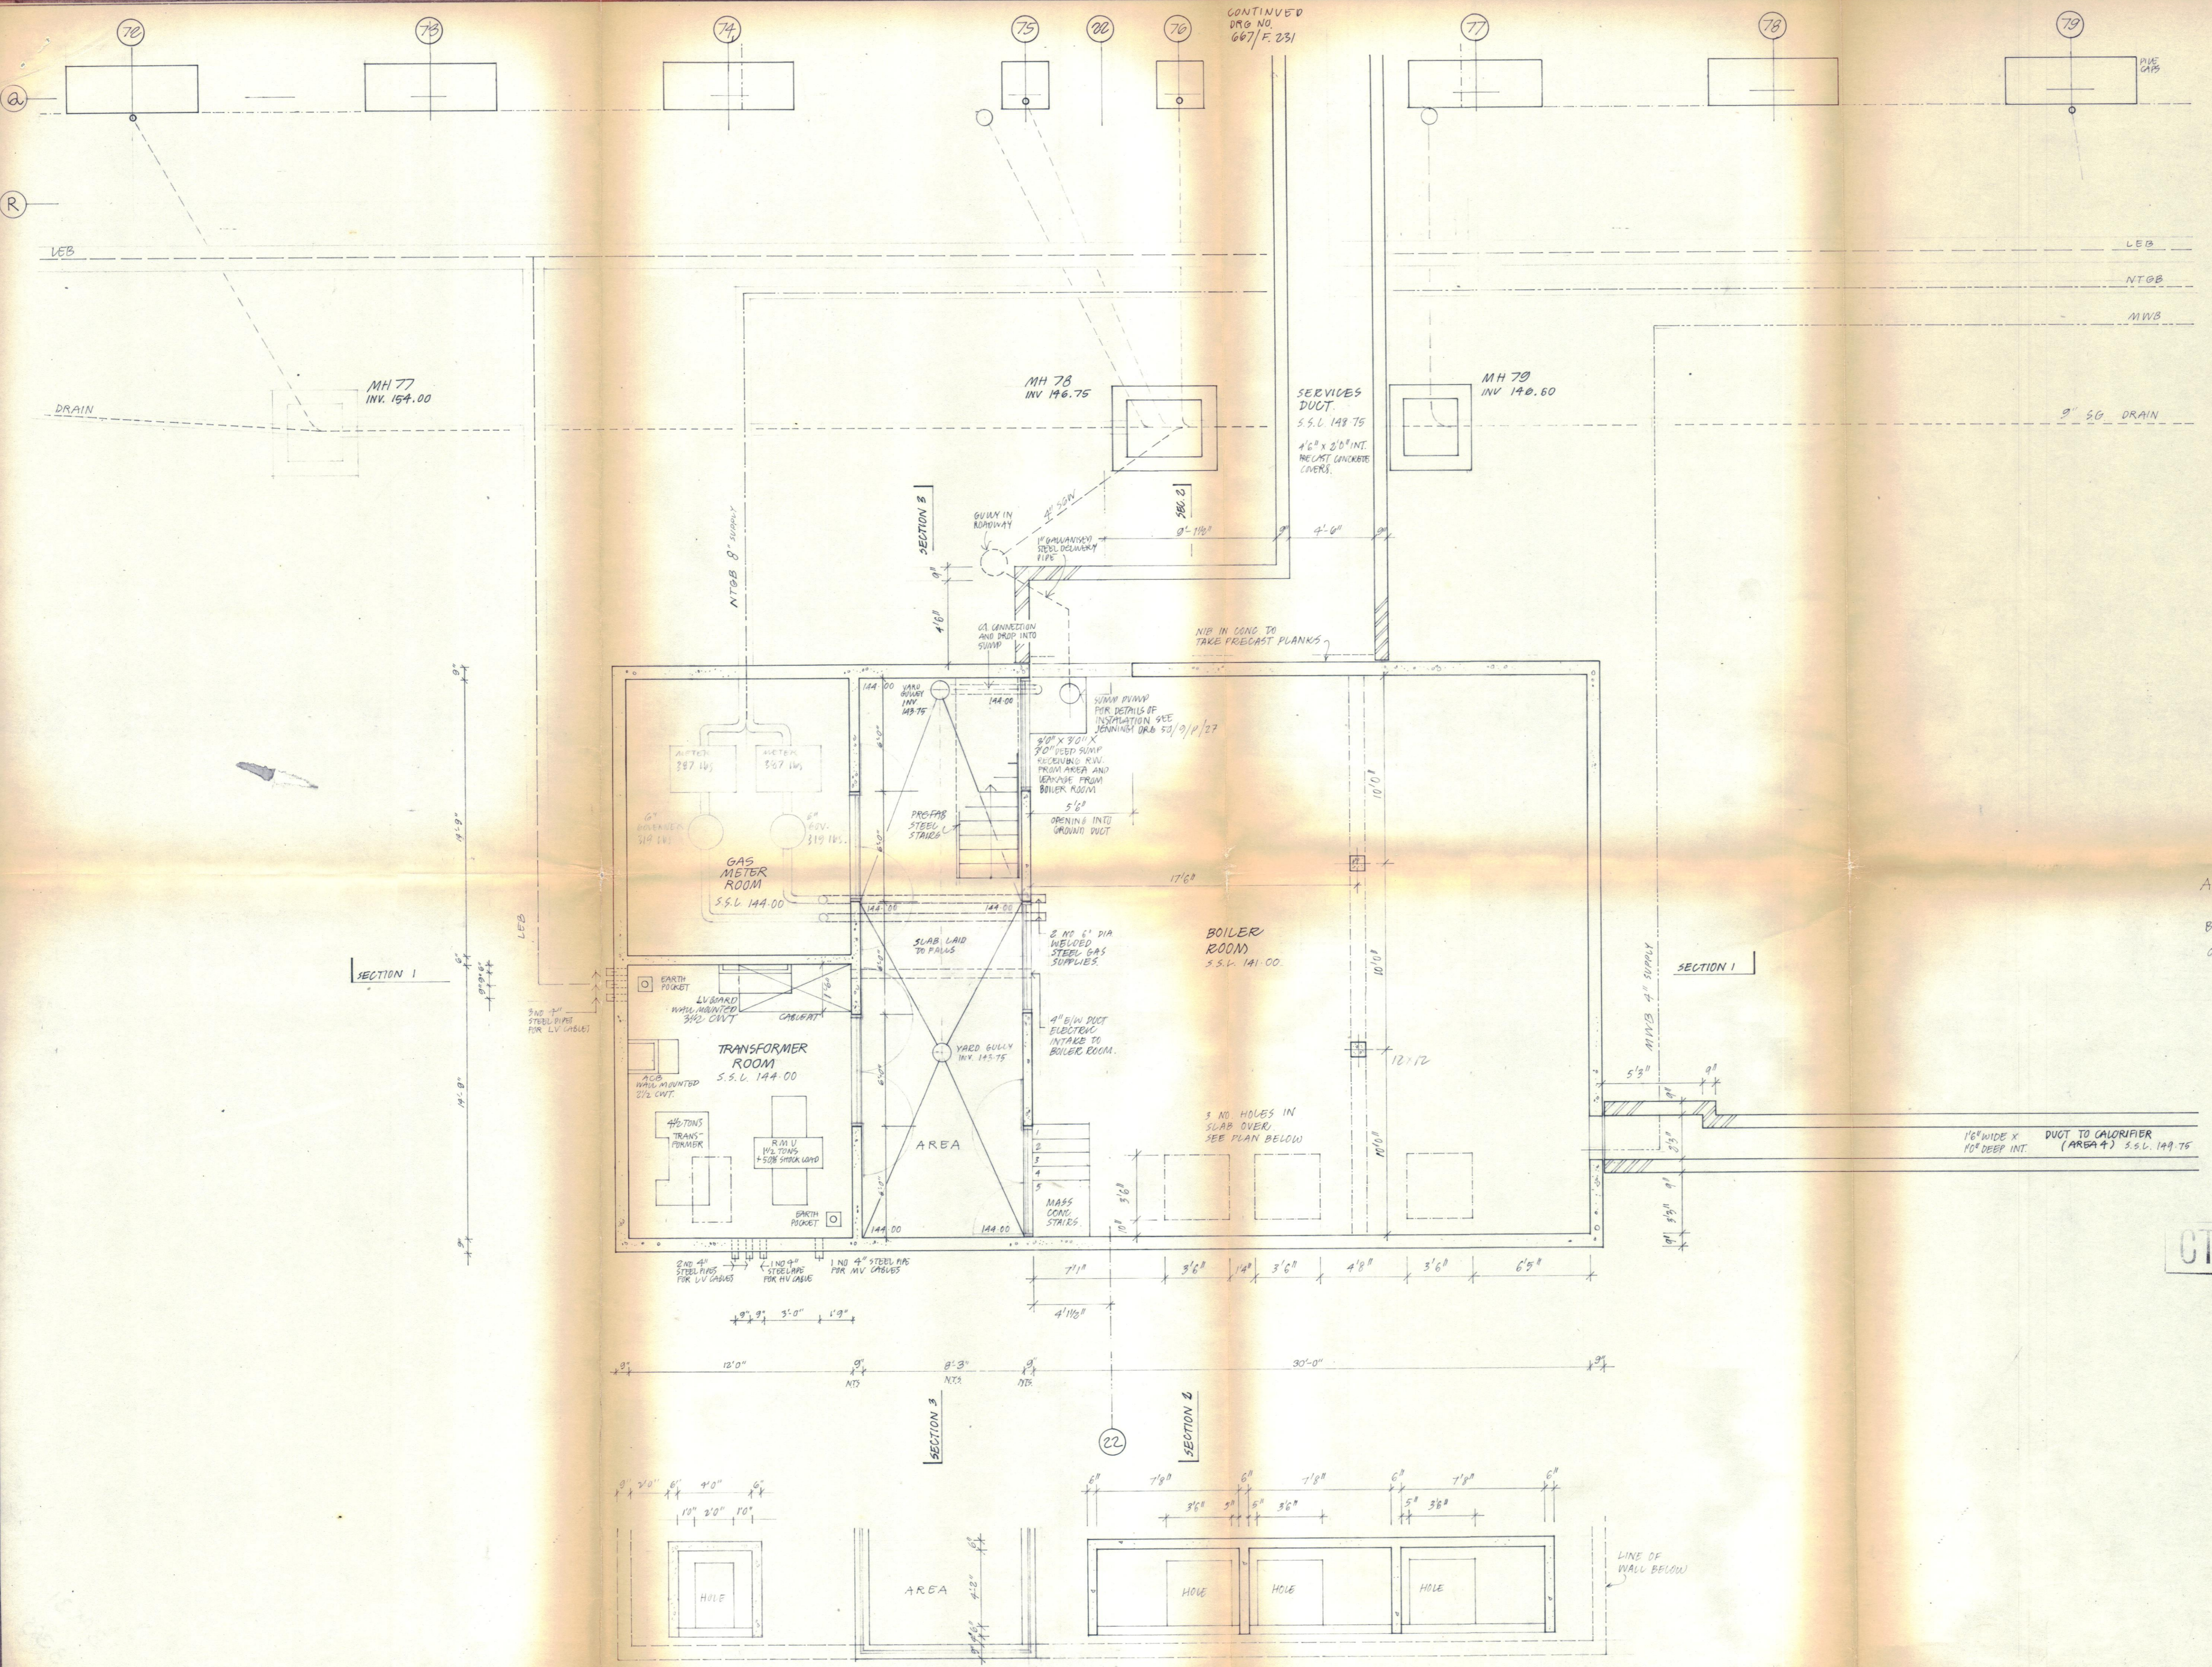

Notes
READ WITH DRGS
667/003 SERVICE DIVERSIONS
50/9/P/11 (NORMAN E. JENNINGS)
DRAINAGE LAYOUT
THIS DRAWING SUPERSEDES DRG 667/P70

Revisions
A 14 AUG 1970 GROUND DUCT ALIGNMENT INTO
BOILER HOUSE, PUMP POSITIONS, CONTROL PANEL,
SUMPS.
B 5 OCT 1970 GROUND DUCT ALIGNMENT INTO
BOILER HOUSE FROM PARTITION, MH 79 ELEVATION
C 18 DEC 1970 GENERAL REVISIONS TO
FLOW CHANGES TO DUCTED PIPES SYSTEM,
LEVELS DROPPED BY 10", CABLE INT. HOLE,
SUMPS PUMP REVERSE, GROUND DUCT ENTRY
MOVED

GTP/F10/2x1 / 1/6522

Contractors must verify all dimensions at the job
before starting any work or making any shop
drawings
No dimension is to be scaled from the drawings

BLOCK 7
PLAN (BELOW GROUND LEVEL)
BOILER ROOM
TRANSFORMER ROOM
GAS METER ROOM

scale 1/4" IN TO 1 FT date 5 JUNE 1970
drawn PCS

Gospel Oak
Heriot Place
Area (Areas 6&9)
for the London Borough of Camden

drawing number 41 - FEB 1971 A
667/ F. 701 B

Frederick MacManus & Partners
Chartered Architects Planning Consultants
41 Upper Montagu St London W1 ☎ 01-262-6651

PLAN OF BOILER OUTLETS AT LEVEL 154.50