



NOTES
 All dimensions to be confirmed on site and any discrepancy to be reported to the client office. All material is produced on behalf of Kier Specialist Services. Design and Business Services. All drawings are produced in conjunction with specification where applicable.
 © Kier Specialist Services, Design and Business Services

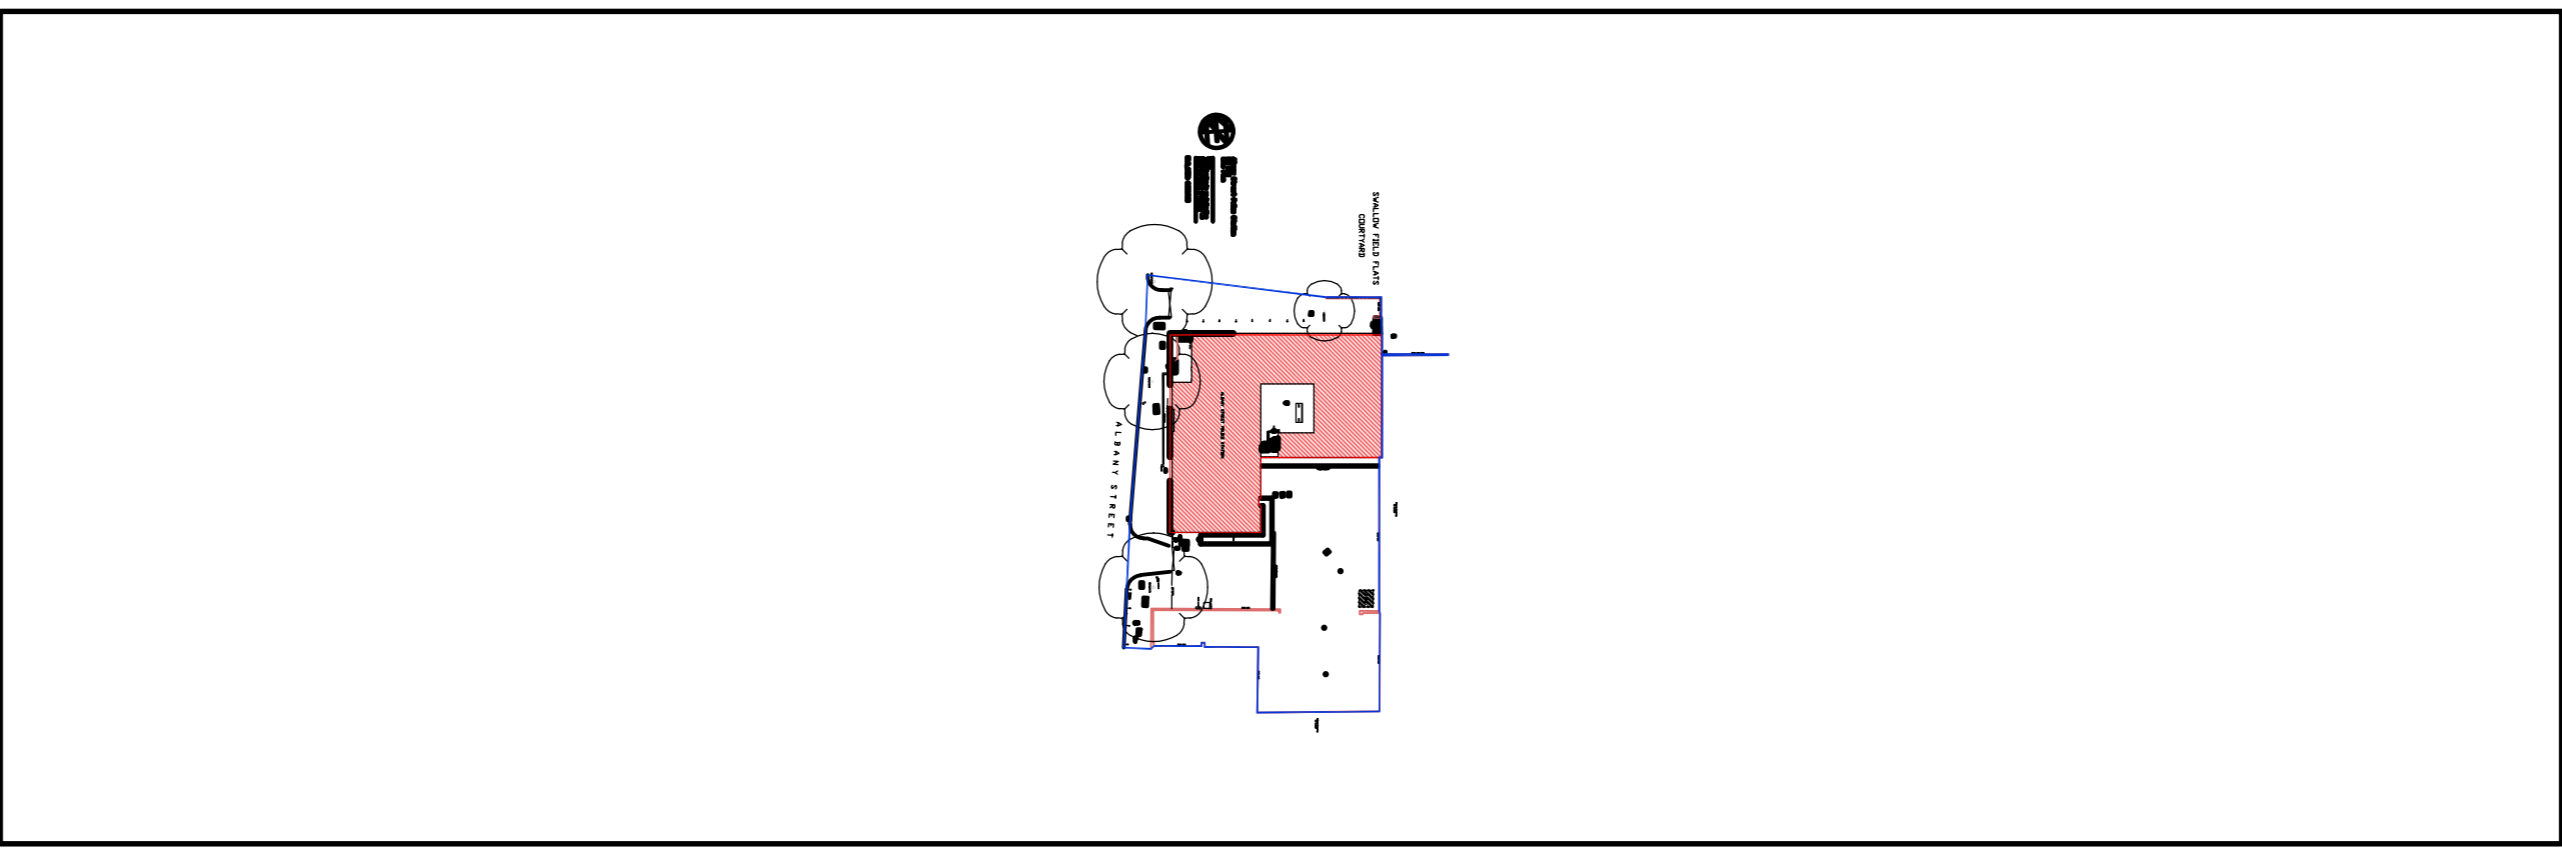

LOCATION PLAN Scale:- 1 / 1250
 Scale 1:1250

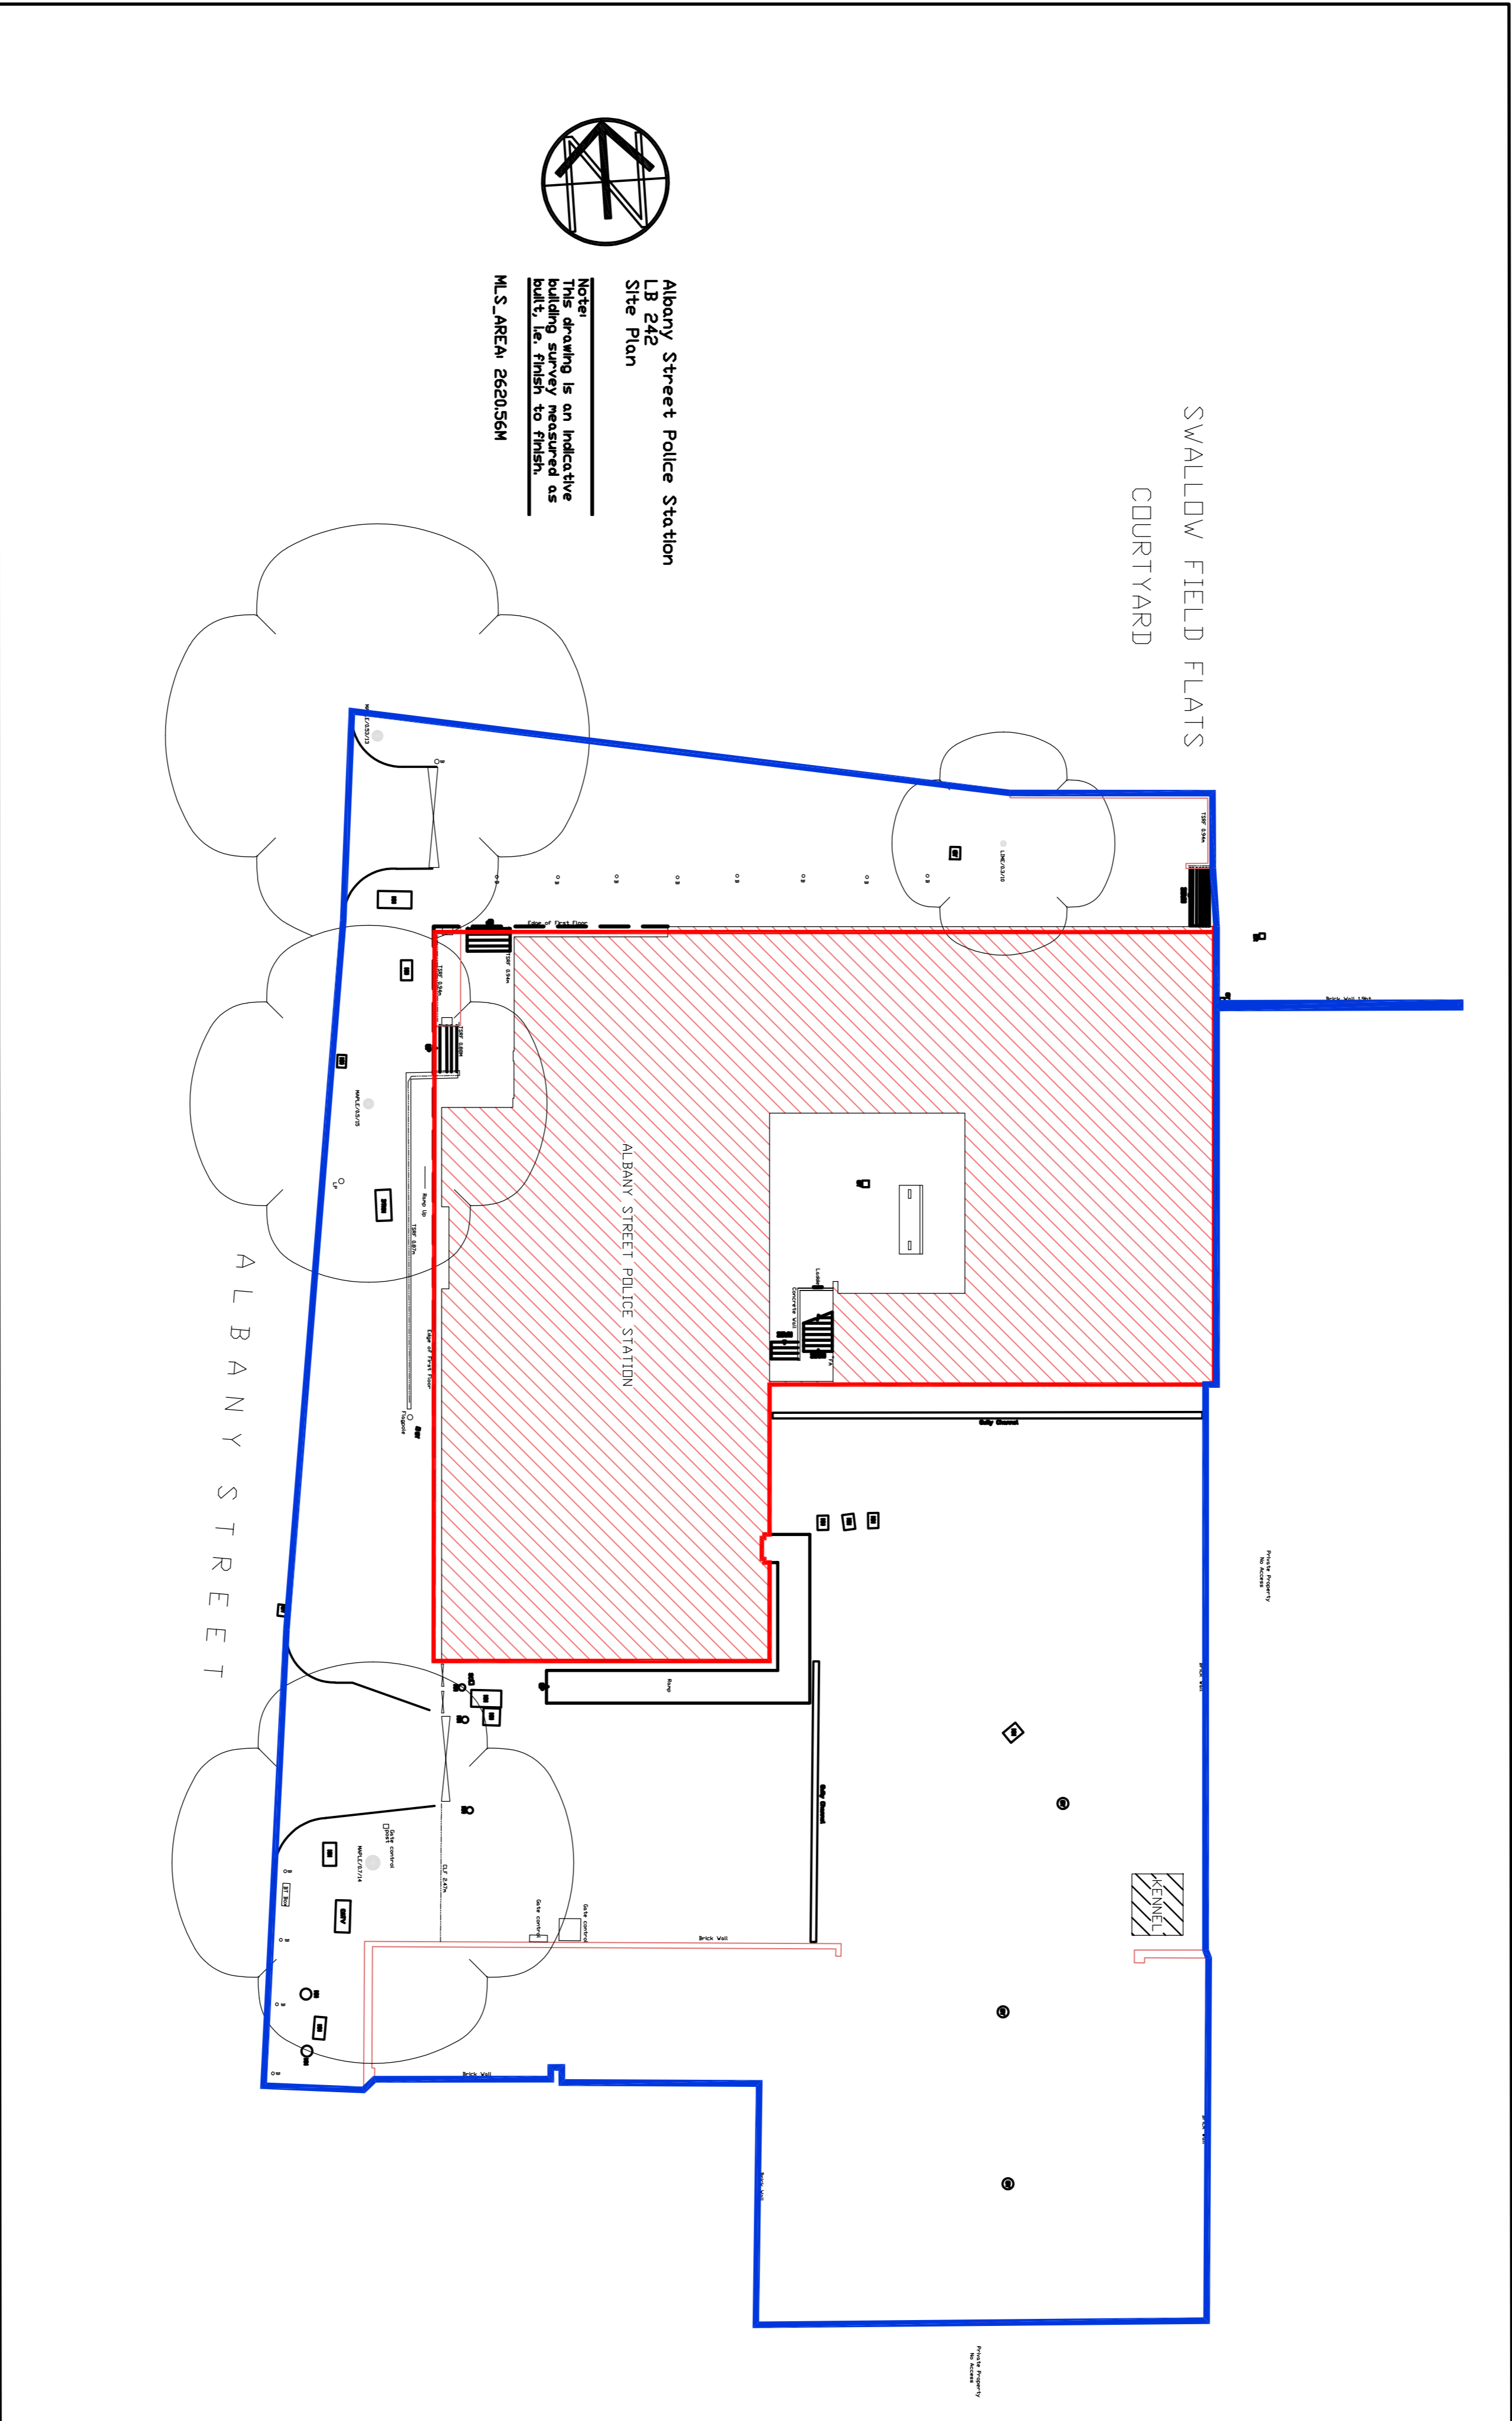

SITE PLAN Scale:- 1 / 200
 Scale 1:200

Revision	Description of Amendments	Drawn	Checked	Approved	Date
P01	DESCRIPTION OF ALTERATIONS	777	777	777	777
		777	777	777	777



Issued Date:	TEMPORARY	Telephone:	01767 398418
Project Reference:	0242		
Client:	M O P A C		
Project Name:	ALBANY STREET POLICE STATION WINDOW REPLACEMENT WORKS		
Project Title:	ALBANY STREET POLICE STATION WINDOW REPLACEMENT WORKS		
Scale:	Original Size	Final Stage	Approved
Author:	AT	HA	CH
Checker:	SM	HA	CH
Drawn:	SM	HA	CH
Checked:	SM	HA	CH
Approved:	SM	HA	CH
Project No:	024201-KBS-XZ-ZR-B-1102	Revision:	P01