

3 New Square, Lincoln's Inn, London WC2A 3RS		
JOB NO. 0721019/		
Drawing List		
Room No.	Drawing No	Title

EXISTING PLANS, SECTIONS AND ELEVATIONS				
General	Su08	Existing Plan	A2	1:50
General	Su06	Existing Services Plan	A3	1:100
FR01	Su20	Existing Room FR01	A3	1:50
FR02	Su10	Existing Room FR02	A3	1:50
FR03	Su18	Existing Room FR03	A3	1:50
FR04	Su19	Existing Room FR04	A3	1:50
FR05	Su23	Existing Room FR05	A3	1:50
FR10	Su25	Existing Room FR10	A3	1:25

Room FR01:
See Drawings No. 0721019/**Su20** and **Su21** for
existing plans, elevations and proposed demolition

Room FR02:
See Drawings No. 0721019/**Su10** and **Su22** for
existing plans, elevations and demolition drawing

Room FR03:
See Drawing No. 0721019/**Su18** for
existing plan and elevations

Room FR04:
See Drawing No. 0721019/**Su19** for
existing plan and elevations

Room FR05:
See Drawings No. 0721019/**Su23** and
Su24 for existing elevations and
drawing of proposed demolitions

Room FR10:
See Drawing No. 0721019/**Su25** for
existing plan and elevations

For Existing Lighting Plan,
See Drawing No. 0721019/**Su06**

For photographs as existing, please see
'Photographs of Existing Chambers'

EXISTING FIRST FLOOR PLAN

0 1m 5m 1 : 50

DO NOT SCALE. Check all dimensions on site.

3 New Square
Title: Existing First Floor Plan
Drawing No: 0721019/**Su08** Scale 1:50 @ A2
Butler Hegarty Architects
Unit 3.3, 159-163 Marlborough Road, London, N19 4NF
tel: 020 72638933 email: mail@butlerhegartyarchitects.co.uk

For Existing General Arrangement Plan,
See Drawing No. 0721019/Su01

For photographs as existing, please see
'Photographs of Existing Chambers'

KEY

- | | | | | | | | |
|---|-------------------------|---|--------------------|---|----------------------|---|-------------------------|
|  | Switch |  | Telephone Outlet |  | Fused Spur Socket |  | Alarm box |
|  | Surface Fixed Spotlight |  | Smoke Alarm |  | Double Socket Outlet |  | Electrical distribution |
|  | Pendant Light |  | Cat6 Network Point |  | Wall Lights |  | IT box |



EXISTING SERVICES PLAN

0 2m 10m

1 : 100




DO NOT SCALE. Check all dimensions on site.

3 New Square
Title: Existing Services Plan
Drawing No: 0721019/Su06 Scale 1:100 @ A3
Butler Hegarty Architects
Unit 3.3, 159-163 Marlborough Road, London, N19 4NF
tel: 020 72638933 email: mail@butlerhegartyarchitects.co.uk


For proposed Elevations, see Drawings No. 0721019/Sk22 and Sk23

For existing Elevation 3 showing proposed alterations, see Drawing No. 0721019/Su21


For photographs as existing, please see 'Photographs of Existing Chambers'

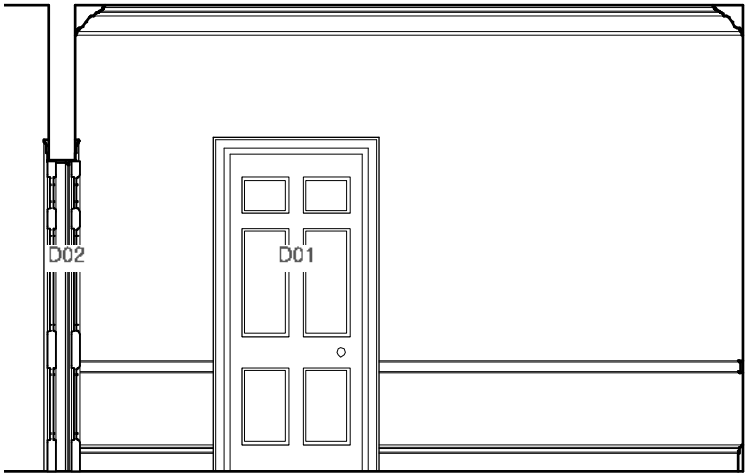

ELEVATION 1

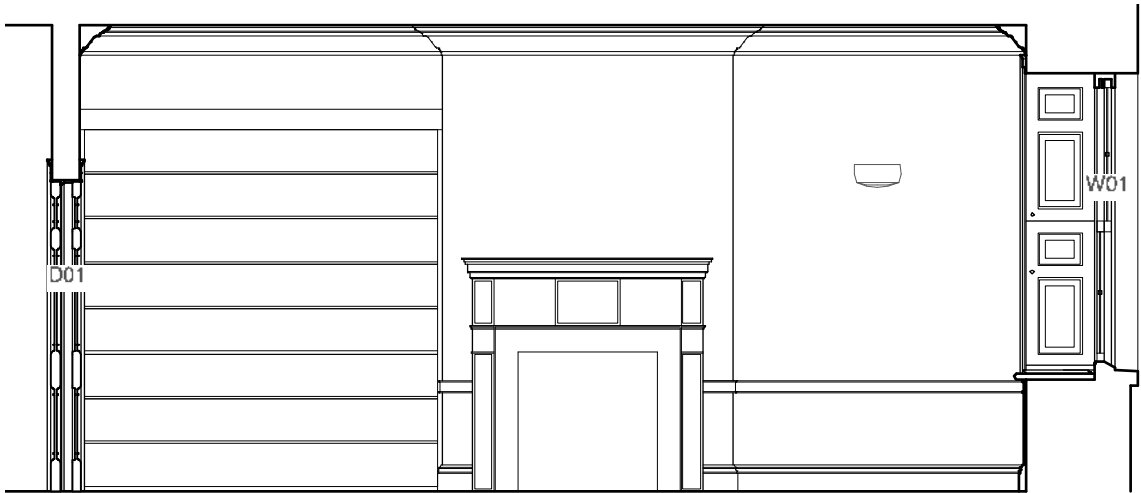


ELEVATION 2

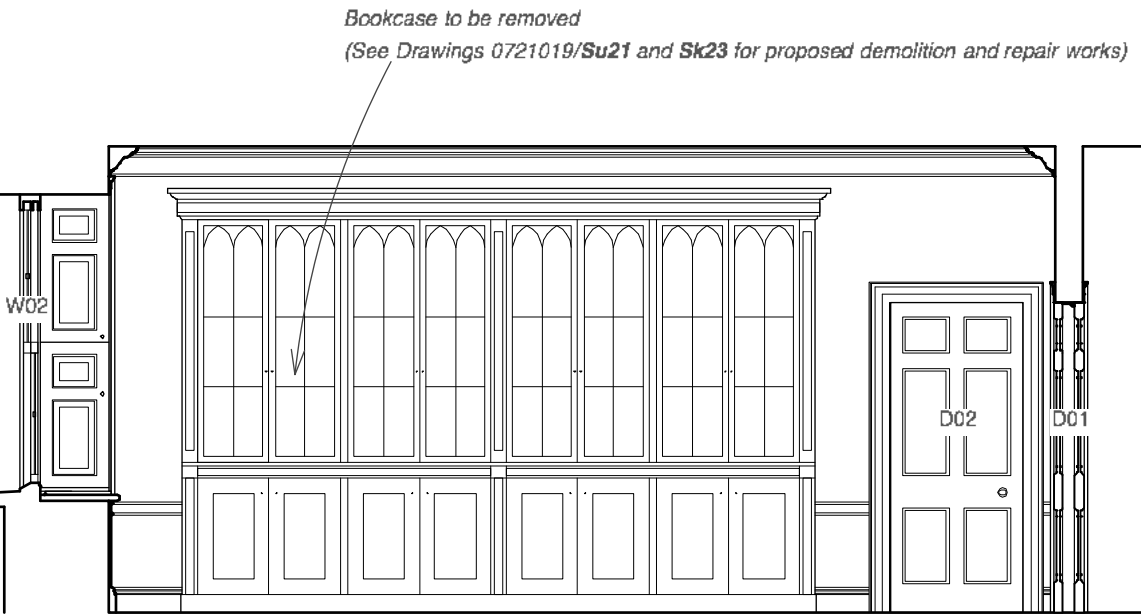

ELEVATION 3



ELEVATION 4

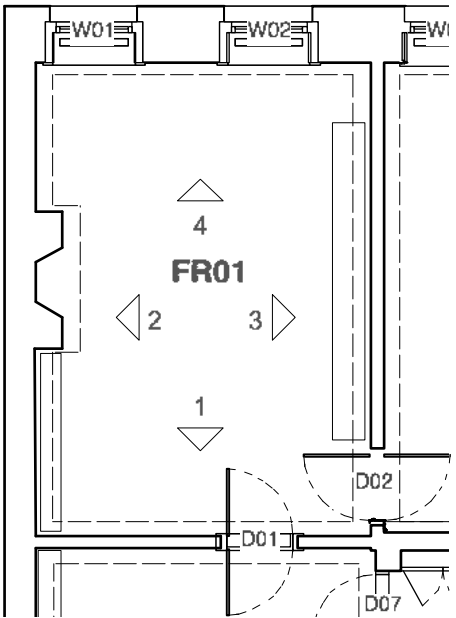

PART PLAN @ 1:100

EXISTING ELEVATIONS ROOM FR01

0 1m 5m

1 : 50


DO NOT SCALE. Check all dimensions on site.

3 New Square
Title: Elevation of Existing Room FR01
Drawing No: 0721019/Su20 Scale 1:50 @ A3
Butler Hegarty Architects
Unit 3.3, 159-163 Marlborough Road, London, N19 4NF
tel: 020 72638933 email: mail@butlerhegartyarchitects.co.uk

For proposed Plans, Elevations and Detail drawings, see Drawings No. 0721019/Sk04, Sk24 and Sk25


For existing Elevation 1 showing proposed alterations, see Drawing No. 0721019/Su22

For photographs as existing, please see 'Photographs of Existing Chambers'

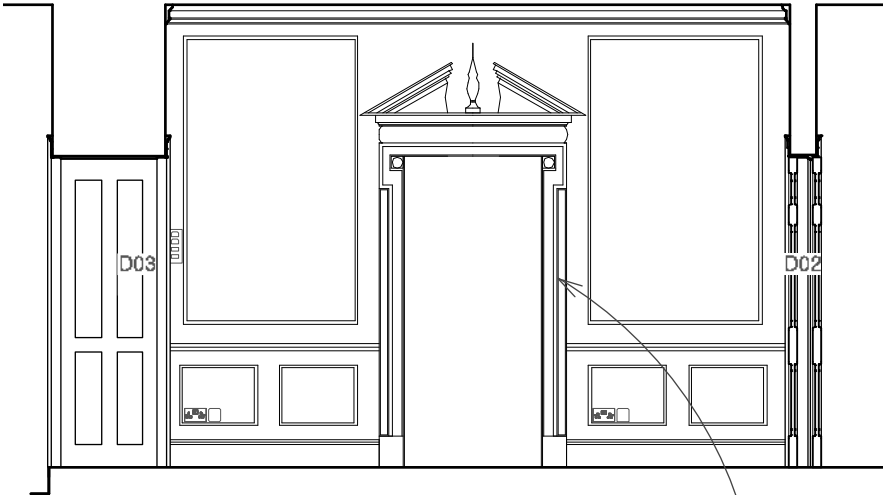

ELEVATION 1

See Drawing No. 0721019/Su22 for proposed demolitions

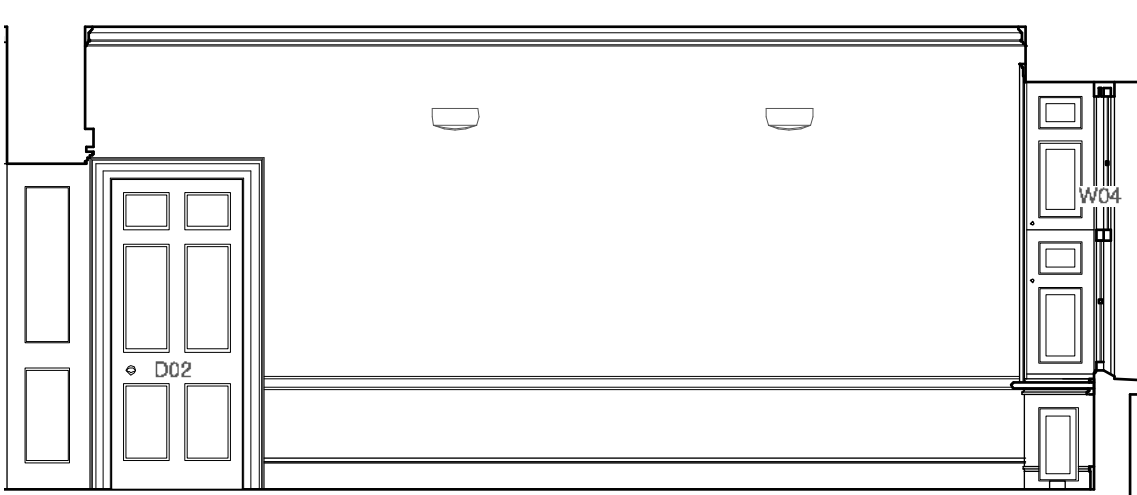


ELEVATION 2



ELEVATION 3



ELEVATION 4

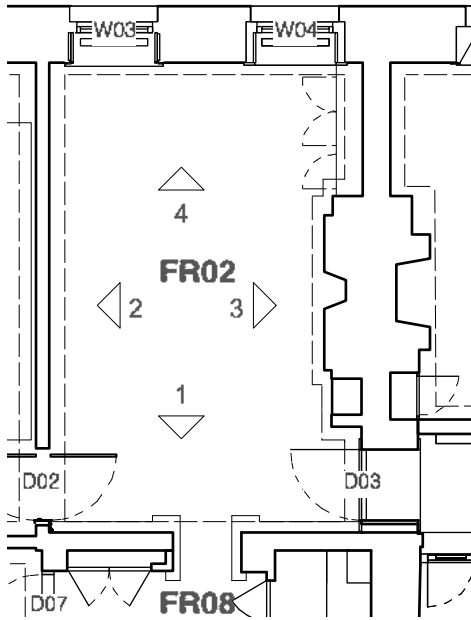

PART PLAN @ 1:100

EXISTING ELEVATIONS ROOM FR02

0 1m 5m

1 : 50

DO NOT SCALE. Check all dimensions on site.


3 New Square
Title: Existing Elevation Room FR02
Drawing No: 0721019/Su10 Scale 1:50 @ A3
Butler Hegarty Architects
Unit 3.3, 159-163 Marlborough Road, London, N19 4NF
tel: 020 72638933 email: mail@butlerhegartyarchitects.co.uk

For proposed Plan and Elevations, see Drawing No. 0721019/**Sk10**

For details of proposed radiator cover, see '**Three New Square Radiator Grills**' by Nicola Lovell Design




ELEVATION 1

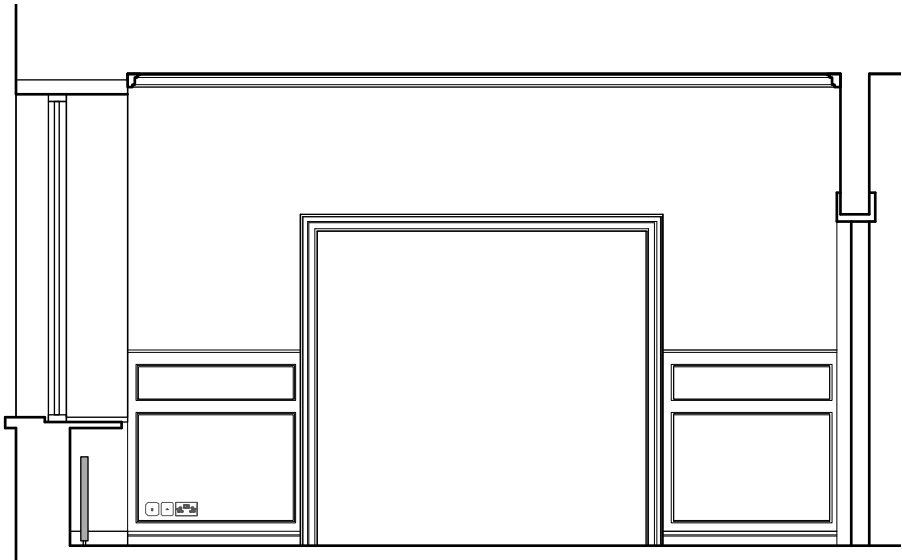


ELEVATION 2


See Drawing No. 0721019/**Sk10** and '**Three New Square Radiator Grills**'
for proposed new radiator covers

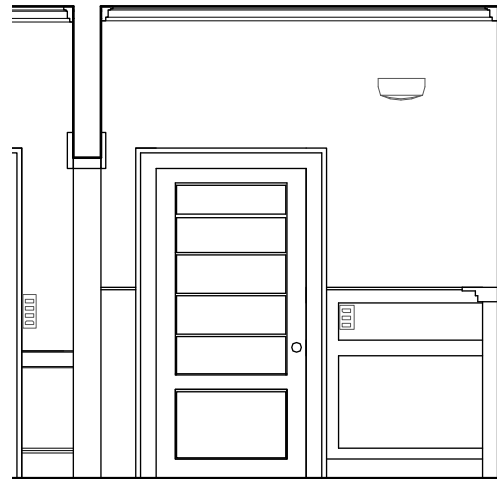

ELEVATION 3

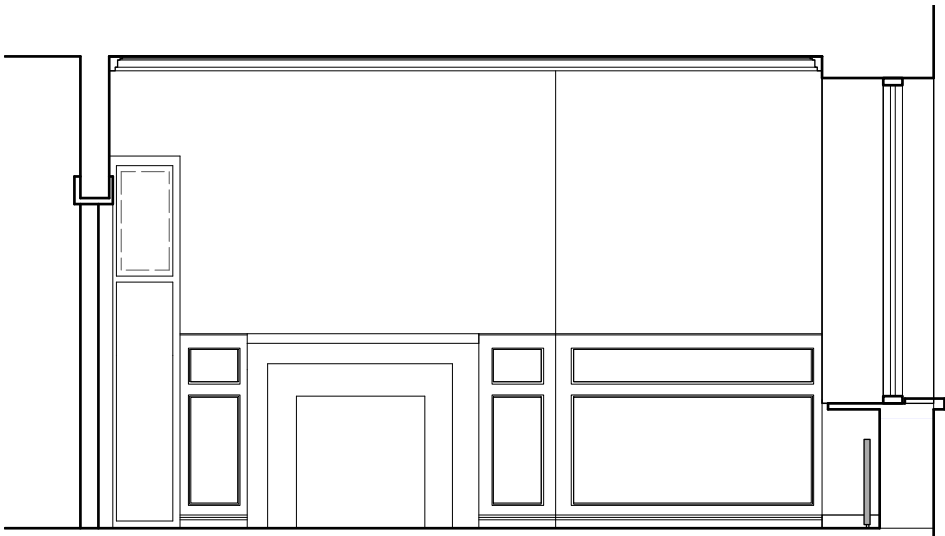

ELEVATION 4

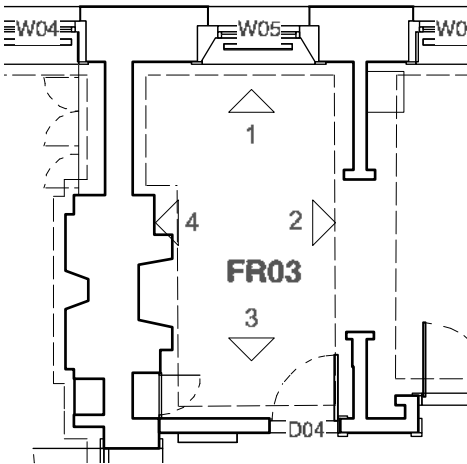

PART PLAN @ 1:100

EXISTING ELEVATIONS ROOM FR03



1 : 50

DO NOT SCALE. Check all dimensions on site.


3 New Square
Title: Existing Elevations Room FR03
Drawing No: 0721019/**Su18** Scale 1:50 @ A3
Butler Hegarty Architects
Unit 3.3, 159-163 Marlborough Road, London, N19 4NF
tel: 020 72638933 email: mail@butlerhegartyarchitects.co.uk

For proposed Elevations, see Drawing No. 0721019/Sk06


For photographs as existing, please see 'Photographs of Existing Chambers'




ELEVATION 1

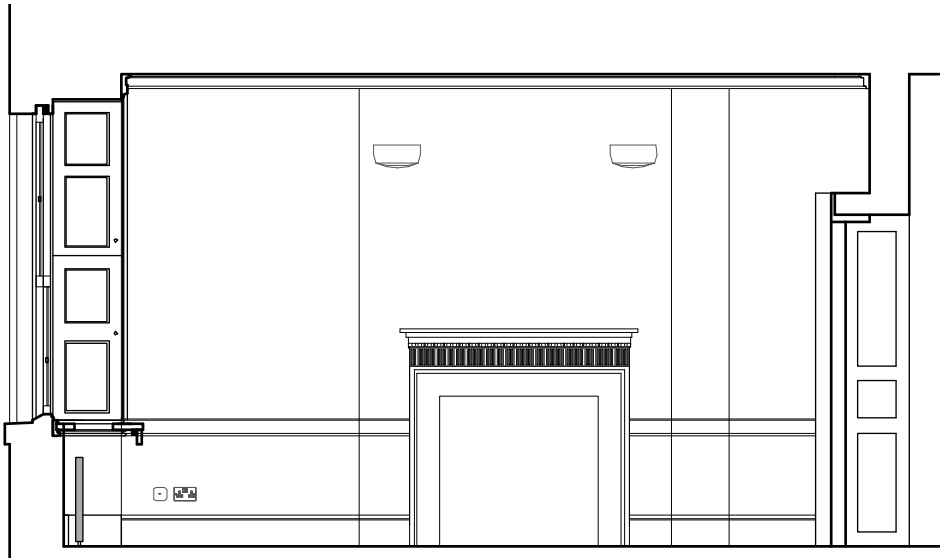


ELEVATION 2

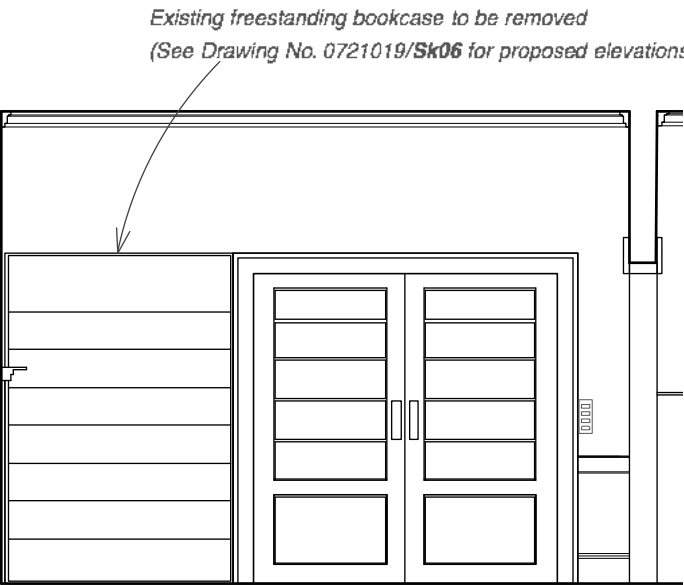

ELEVATION 3

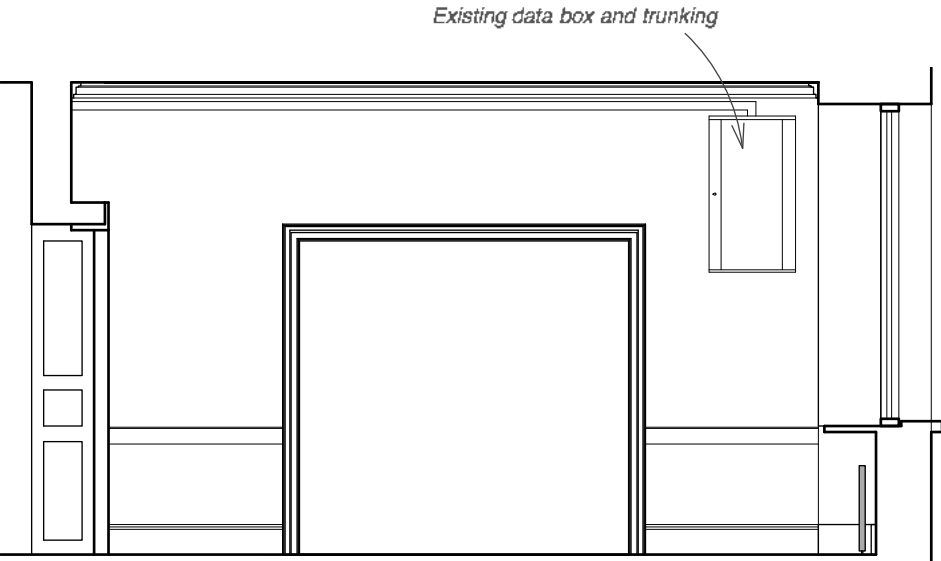

ELEVATION 4

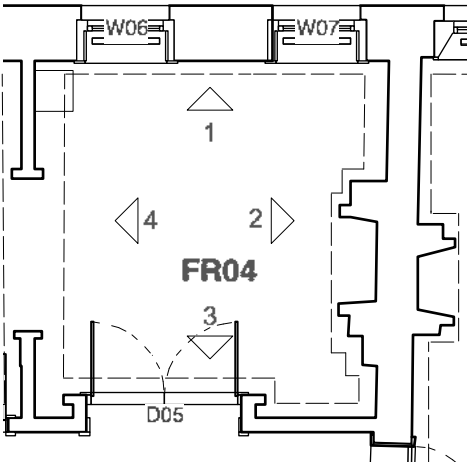

PART PLAN @ 1:100

EXISTING ELEVATIONS ROOM FR04

0 1m 5m

1 : 50

DO NOT SCALE. Check all dimensions on site.

3 New Square
Title: Existing Elevations Room FR04
Drawing No: 0721019/Su19 Scale 1:50 @ A3
Butler Hegarty Architects
Unit 3.3, 159-163 Marlborough Road, London, N19 4NF
tel: 020 72638933 email: mail@butlerhegartyarchitects.co.uk


For proposed Plans and Elevations , see Drawings No. 0721019/**Sk21** and **SK26**

For existing Elevation 3 showing proposed alterations, see Drawing No. 0721019/**Su24**


For photographs as existing, please see '**Photographs of Existing Chambers**'




ELEVATION 1

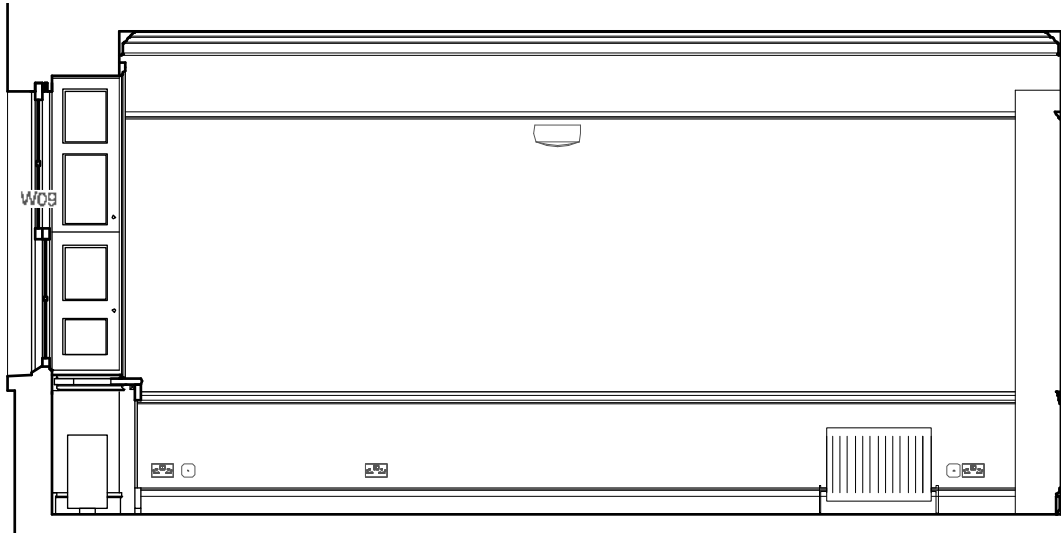


ELEVATION 2

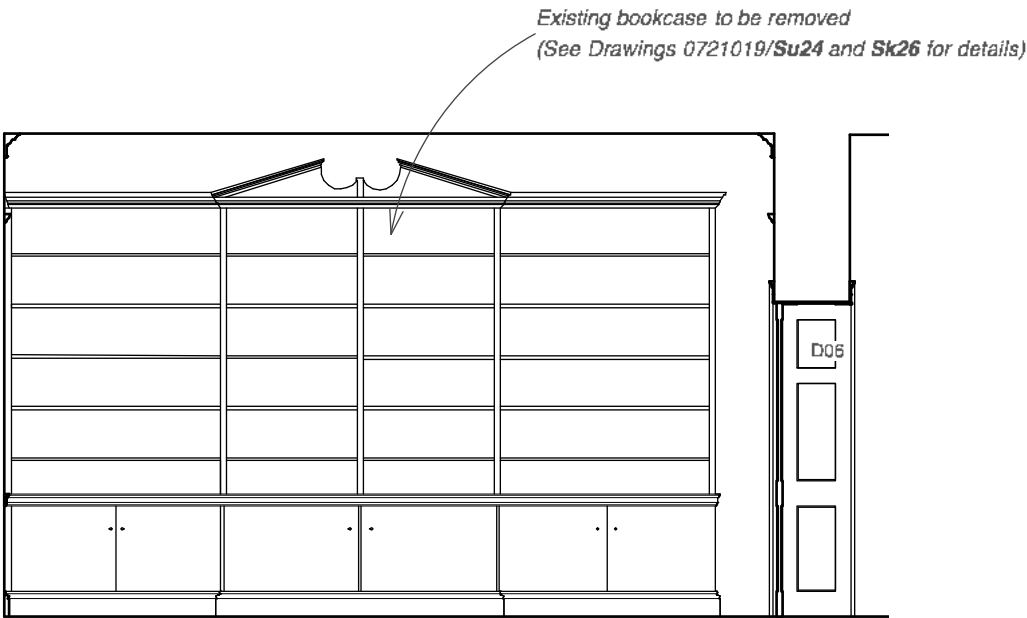

ELEVATION 3

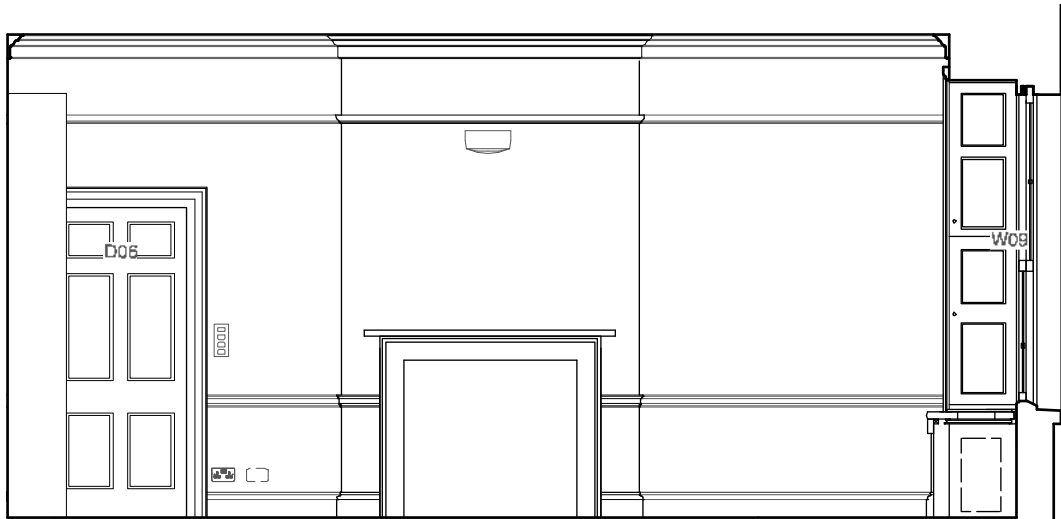

ELEVATION 4

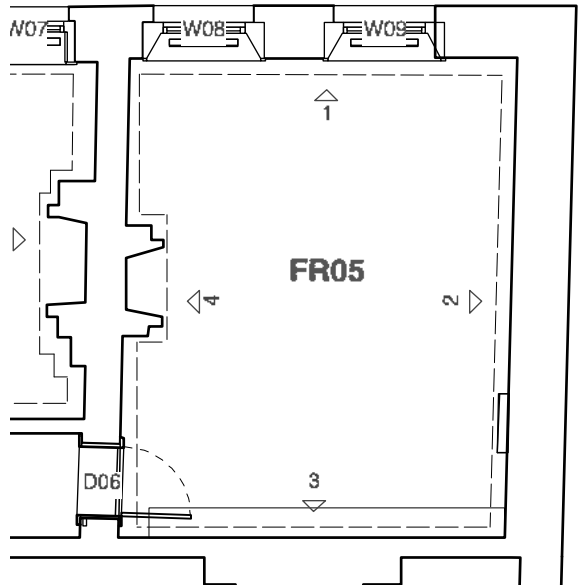

PLAN @ 1:100


EXISTING ELEVATIONS ROOM FR05

0 1m 5m

1 : 50

DO NOT SCALE. Check all dimensions on site.


3 New Square
Title: Existing Elevation Room FR05
Drawing No: 0721019/**Su23** Scale 1:50 @ A3
Butler Hegarty Architects
Unit 3.3, 159-163 Marlborough Road, London, N19 4NF
tel: 020 72638933 email: mail@butlerhegartyarchitects.co.uk

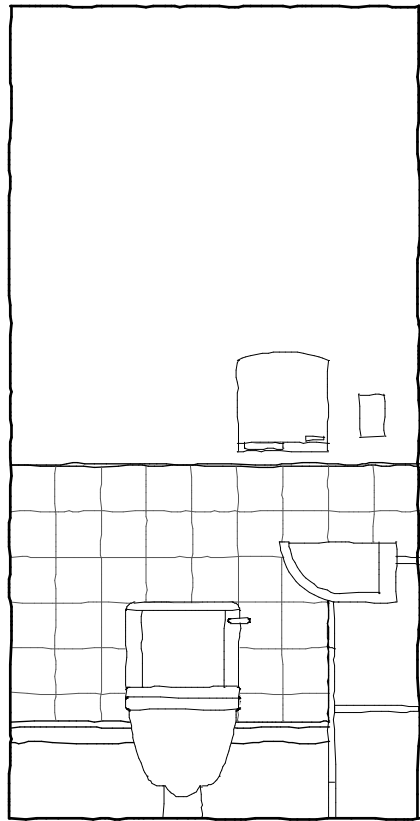


ELEVATION 1




ELEVATION 2

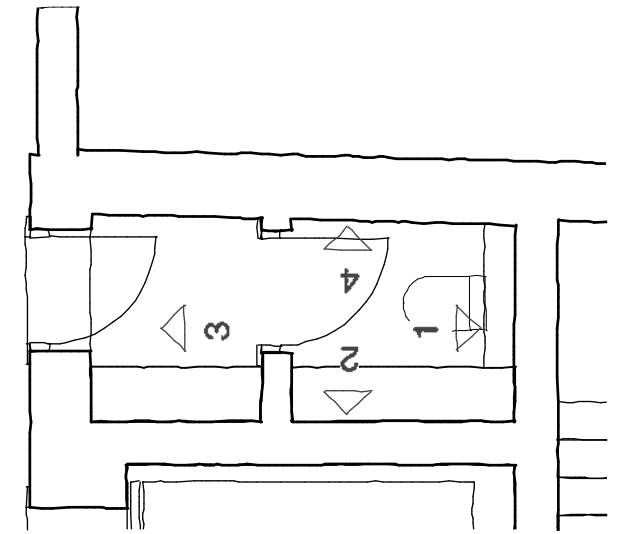

PLAN FR10 @ 1:50

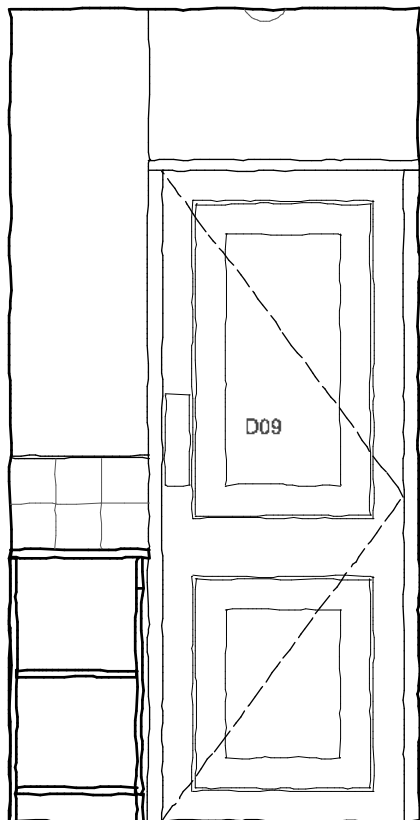

ELEVATION 3

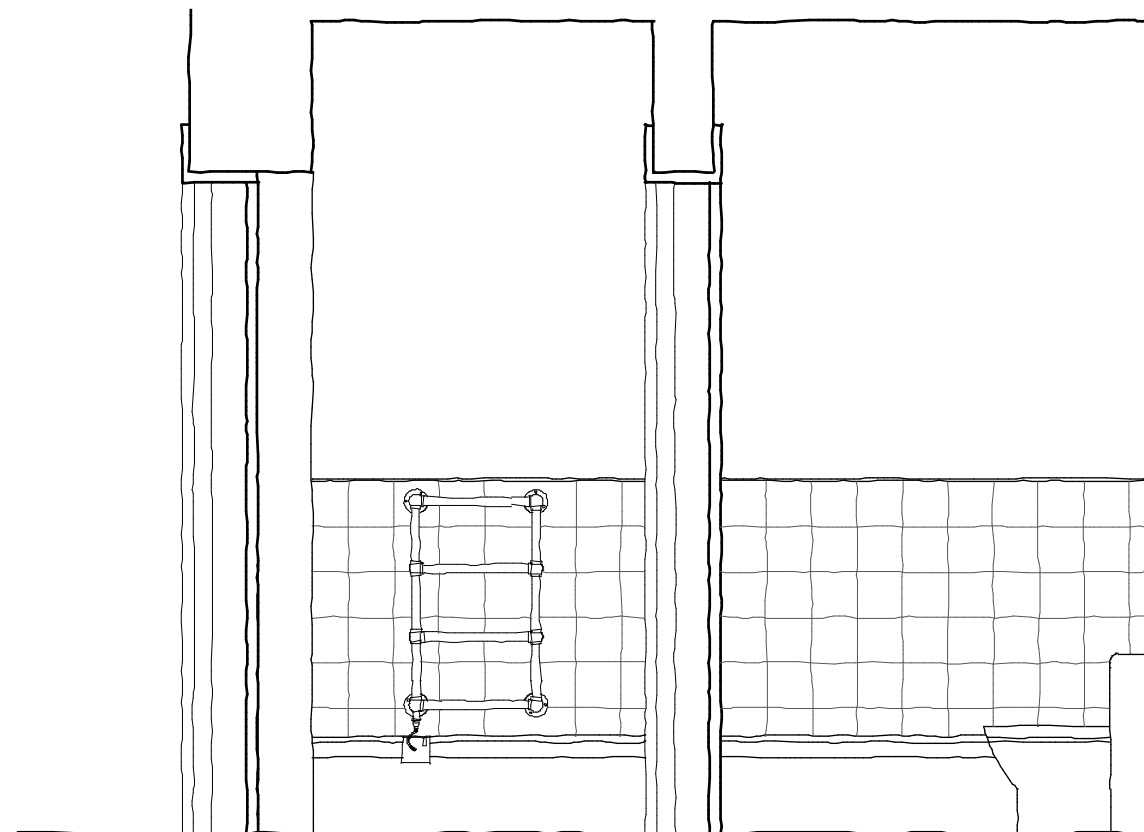

ELEVATION 4

See Drawing No. 0721019/Sk17 for Proposed WC Elevations

For photographs as existing, please see 'Photographs of Existing Chambers'

EXISTING WC ELEVATIONS ROOM FR10

0 0.5m 2.5m

1 : 25

DO NOT SCALE. Check all dimensions on site.

3 New Square
Title: Existing WC Elevations
Drawing No: 0721019/Su25 Scale 1:25 @ A3
Butler Hegarty Architects
Unit 3.3, 159-163 Marlborough Road, London, N19 4NF
tel: 020 72638933 email: mail@butlerhegartyarchitects.co.uk