

3 New Square, Lincoln's Inn, London WC2A 3RS		
JOB NO. 0721019/		
Drawing List		
Room No.	Drawing No	Title

PROPOSED PLANS, SECTIONS AND ELEVATIONS				
General	Sk03	Proposed Plan	A2	1:50
General	Sk27	Proposed Alterations	A2	1:50
General	Sk11	Proposed Light Fittings	A3	1:100
FR01	Sk22	Proposed Room FR01	A3	1:50
	Su21	Proposed Demolitions Room FR01 Elevation 3	A3	1:20
	Sk23	Proposed Room FR01 Elevation 3 / Details	A3	1:20/1:2
FR02	Sk04	Proposed Room FR02	A3	1:50
	Su22	Proposed Demolitions Room FR02 Elevation 1	A3	1:20
	Sk24	Proposed Room FR02 Elevation 1 / Details	A3	1:20/1:2
	Sk25	Proposed Room FR02 Details	A3	1:10/1:2
FR03	Sk10	Proposed Room FR03	A3	1:50
FR04	Sk06	Proposed Room FR04	A3	1:50
FR05	Sk21	Proposed Room FR05	A3	1:50
	Su24	Proposed Demolitions Room FR05 Elevation 3	A3	1:20
	Sk26	Proposed Room FR05 Elevation 3	A3	1:50
FR08	Sk18	Proposed Kitchen FR08	A3	1:25
FR10	Sk17	Proposed WC FR10	A3	1:25
General		Three New Square Radiator Grills (Nicola Lovell Design)	A4	1:20

Room FR01:
See Drawings No. 0721019/Sk22 and Sk23 for proposed plans, elevations and detail drawings

Radiator Covers (Rooms FR01, FR02, FR03):
See Drawing 'Three New Square Radiator Covers' for proposed plan, elevation and detail section

Room FR03:
See Drawing No. 0721019/Sk10

Room FR04:
See Drawing No. 0721019/Sk06

Room FR05:
See Drawings No. 0721019/Sk21 and Sk26 for proposed elevations

Room FR02:
See Drawings No. 0721019/Sk04, Sk24 and Sk25 for proposed plans, elevations and detail drawings

Room FR08:
See Drawing No. 0721019/Sk18 for proposed plan and elevations

Room FR10:
See Drawing No. 0721019/Sk17 for proposed plan and elevations

For Proposed Lighting Plan, see Drawing No. 0721019/Sk11

For Proposed Alterations Plan, see Drawing No. 0721019/Sk27

PROPOSED FIRST FLOOR PLAN

0 1m 5m 1 : 50

DO NOT SCALE. Check all dimensions on site.

3 New Square
Title: Proposed First Floor Plan
Drawing No: 0721019/Sk03 Scale 1:50 @ A2
Butler Hegarty Architects
Unit 3.3, 159-163 Marlborough Road, London, N19 4NF
tel: 020 72638933 email: mail@butlerhegartyarchitects.co.uk

Remove large bookcase
(See Drawing No. 0721019/Sk23)

Remove freestanding bookcase
(See Drawing No. 0721019/Sk06 and Su19)

Remove large freestanding bookcase
(See Drawing No. 0721019/Sk26)

Remove 20th century opening surround and mirrors
(See Drawing No. 0721019/Sk24)

Remove current Kitchen unit and cupboards
and replace with new proposed kitchen unit
(See Drawing No. 0721019/Sk18)

New proposed WC
(See Drawing No. 0721019/Sk17)

For Proposed Lighting Plan,
See Drawing No. 0721019/Sk11

PROPOSED ALTERATIONS


















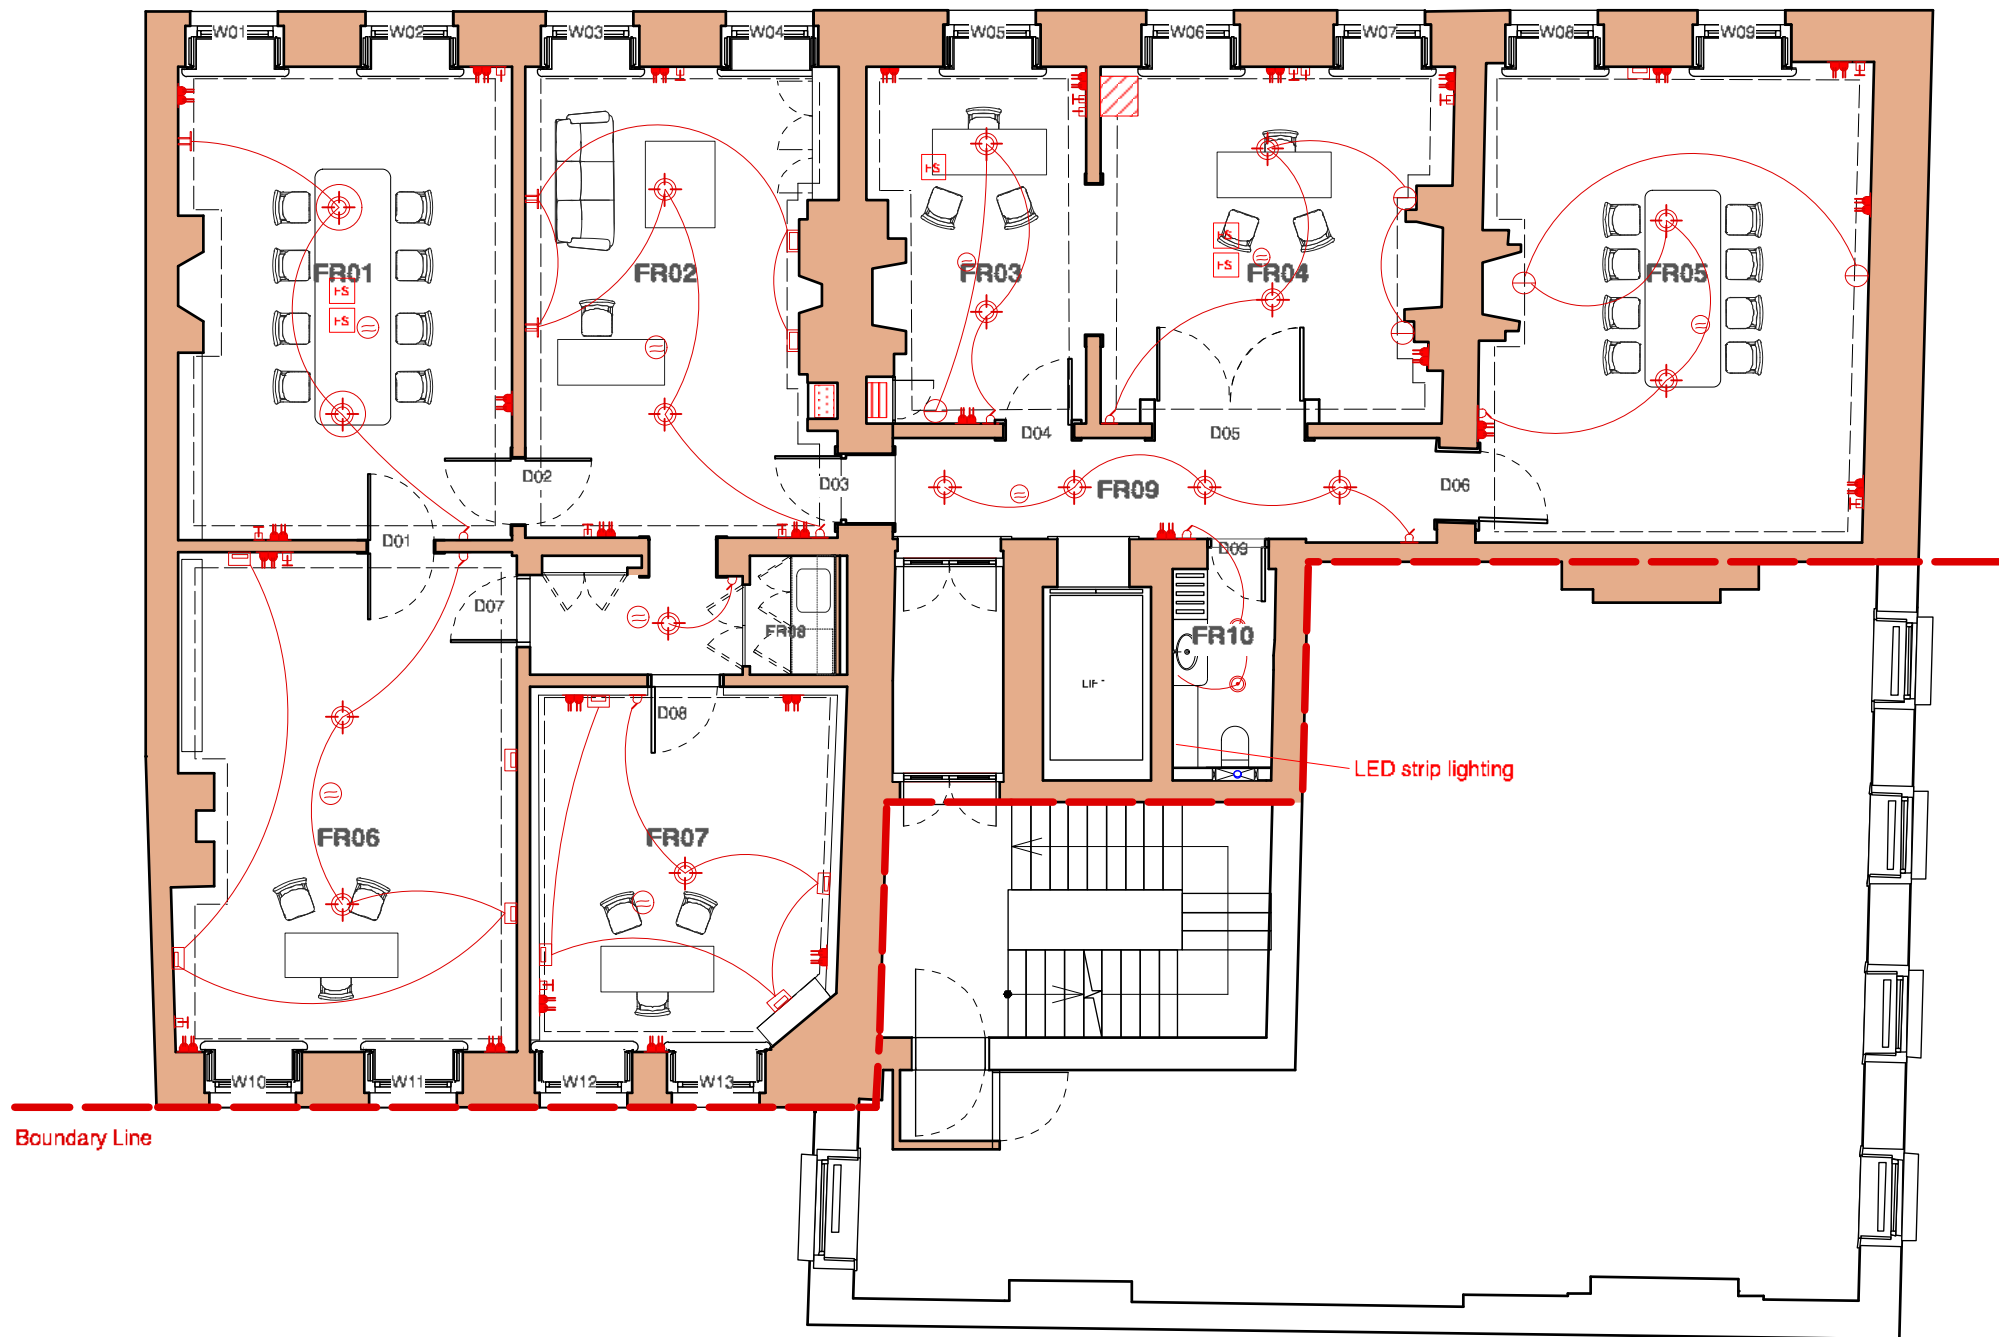
3 New Square
Title: Proposed First Floor Plan Alterations
Drawing No: 0721019/Sk27 Scale 1:50 @ A2
Butler Hegarty Architects
Unit 3.3, 159-163 Marlborough Road, London, N19 4NF
tel: 020 72638933 email: mail@butlerhegartyarchitects.co.uk

For General Arrangement Plan,
See Drawing No. 0721019/Sk02

N.B. Rooms FR05, FR06, FR07
and FR09 lighting as existing

KEY

- | | | | | | |
|---|-------------------------|---|--------------------|---|-------------------------------------|
|  | Switch |  | Telephone Outlet |  | Recessed Down Light |
|  | Surface Fixed Spotlight |  | Heater and Cooler |  | 5 Amp Single Socket Outlets |
|  | Pendant Light |  | Smoke Alarm |  | Fused Spur Socket |
|  | TV monitor |  | Cat6 Network Point |  | Double Socket Outlet |
|  | Floor Socket Outlet |  | Wall Lights |  | Alarm box / electrical distribution |



Room FR01



Room FR02



Room FR03



Room FR04



Room FR08



PROPOSED LIGHTING PLAN

0 2m 10m

1 : 100




DO NOT SCALE. Check all dimensions on site.

3 New Square
Title: Existing Services Plan with proposed light fittings
Drawing No: 0721019/Sk11 Scale 1:100 @ A3
Butler Hegarty Architects
Unit 3.3, 159-163 Marlborough Road, London, N19 4NF
tel: 020 72638933 email: mail@butlerhegartyarchitects.co.uk

For existing Elevations, see Drawings No. 0721019/**Su20** and **Su21**

For details of proposed Elevation 3, see Drawing No. 0721019/**Sk23**


For proposed radiator grills, see Drawing '**Three New Square Radiator Grills**'

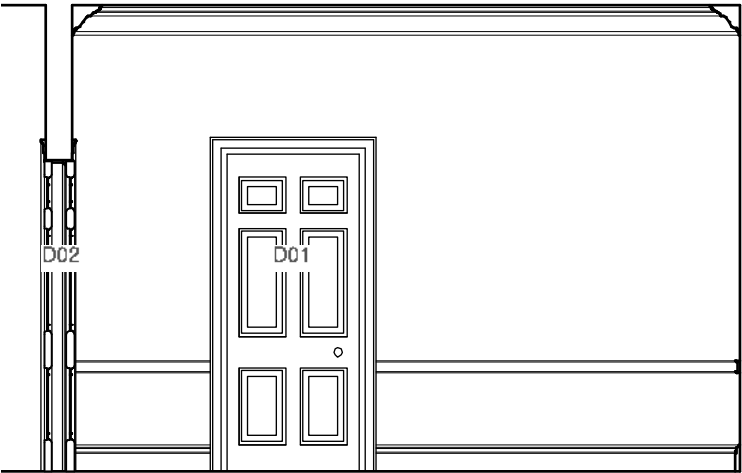

ELEVATION 1




ELEVATION 2

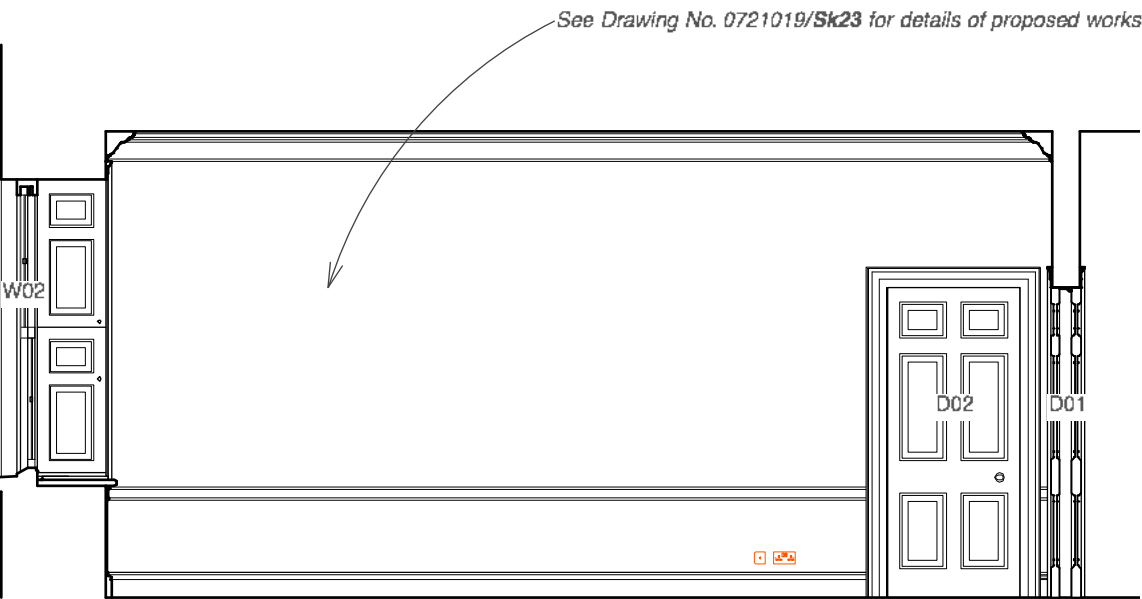

ELEVATION 3



ELEVATION 4

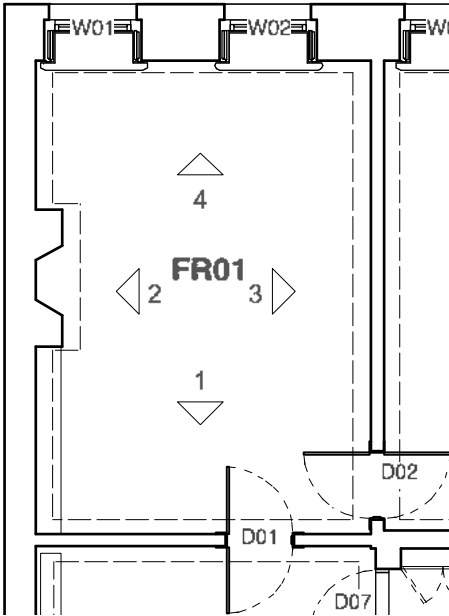

PART PLAN @ 1:100

Proposed elements

New radiator covers
(See Drawing '**Three New Square Radiator Grills**' for details)

PROPOSED ELEVATIONS ROOM FR01

0 1m 5m

1 : 50

DO NOT SCALE. Check all dimensions on site.


3 New Square
Title: Elevation of Proposed Room FR01
Drawing No: 0721019/**Sk22** Scale 1:50 @ A3
Butler Hegarty Architects
Unit 3.3, 159-163 Marlborough Road, London, N19 4NF
tel: 020 72638933 email: mail@butlerhegartyarchitects.co.uk

For proposed Elevations and details, see Drawings No. 0721019/Sk22 and Sk23

For existing Plan and Elevations 1-4, see Drawing No. 0721019/Su20

For photographs as existing, please see 'Photographs of Existing Chambers'

Remove large bookcase
(See Drawing No. 0721019/Sk23 for details of proposed repairs)

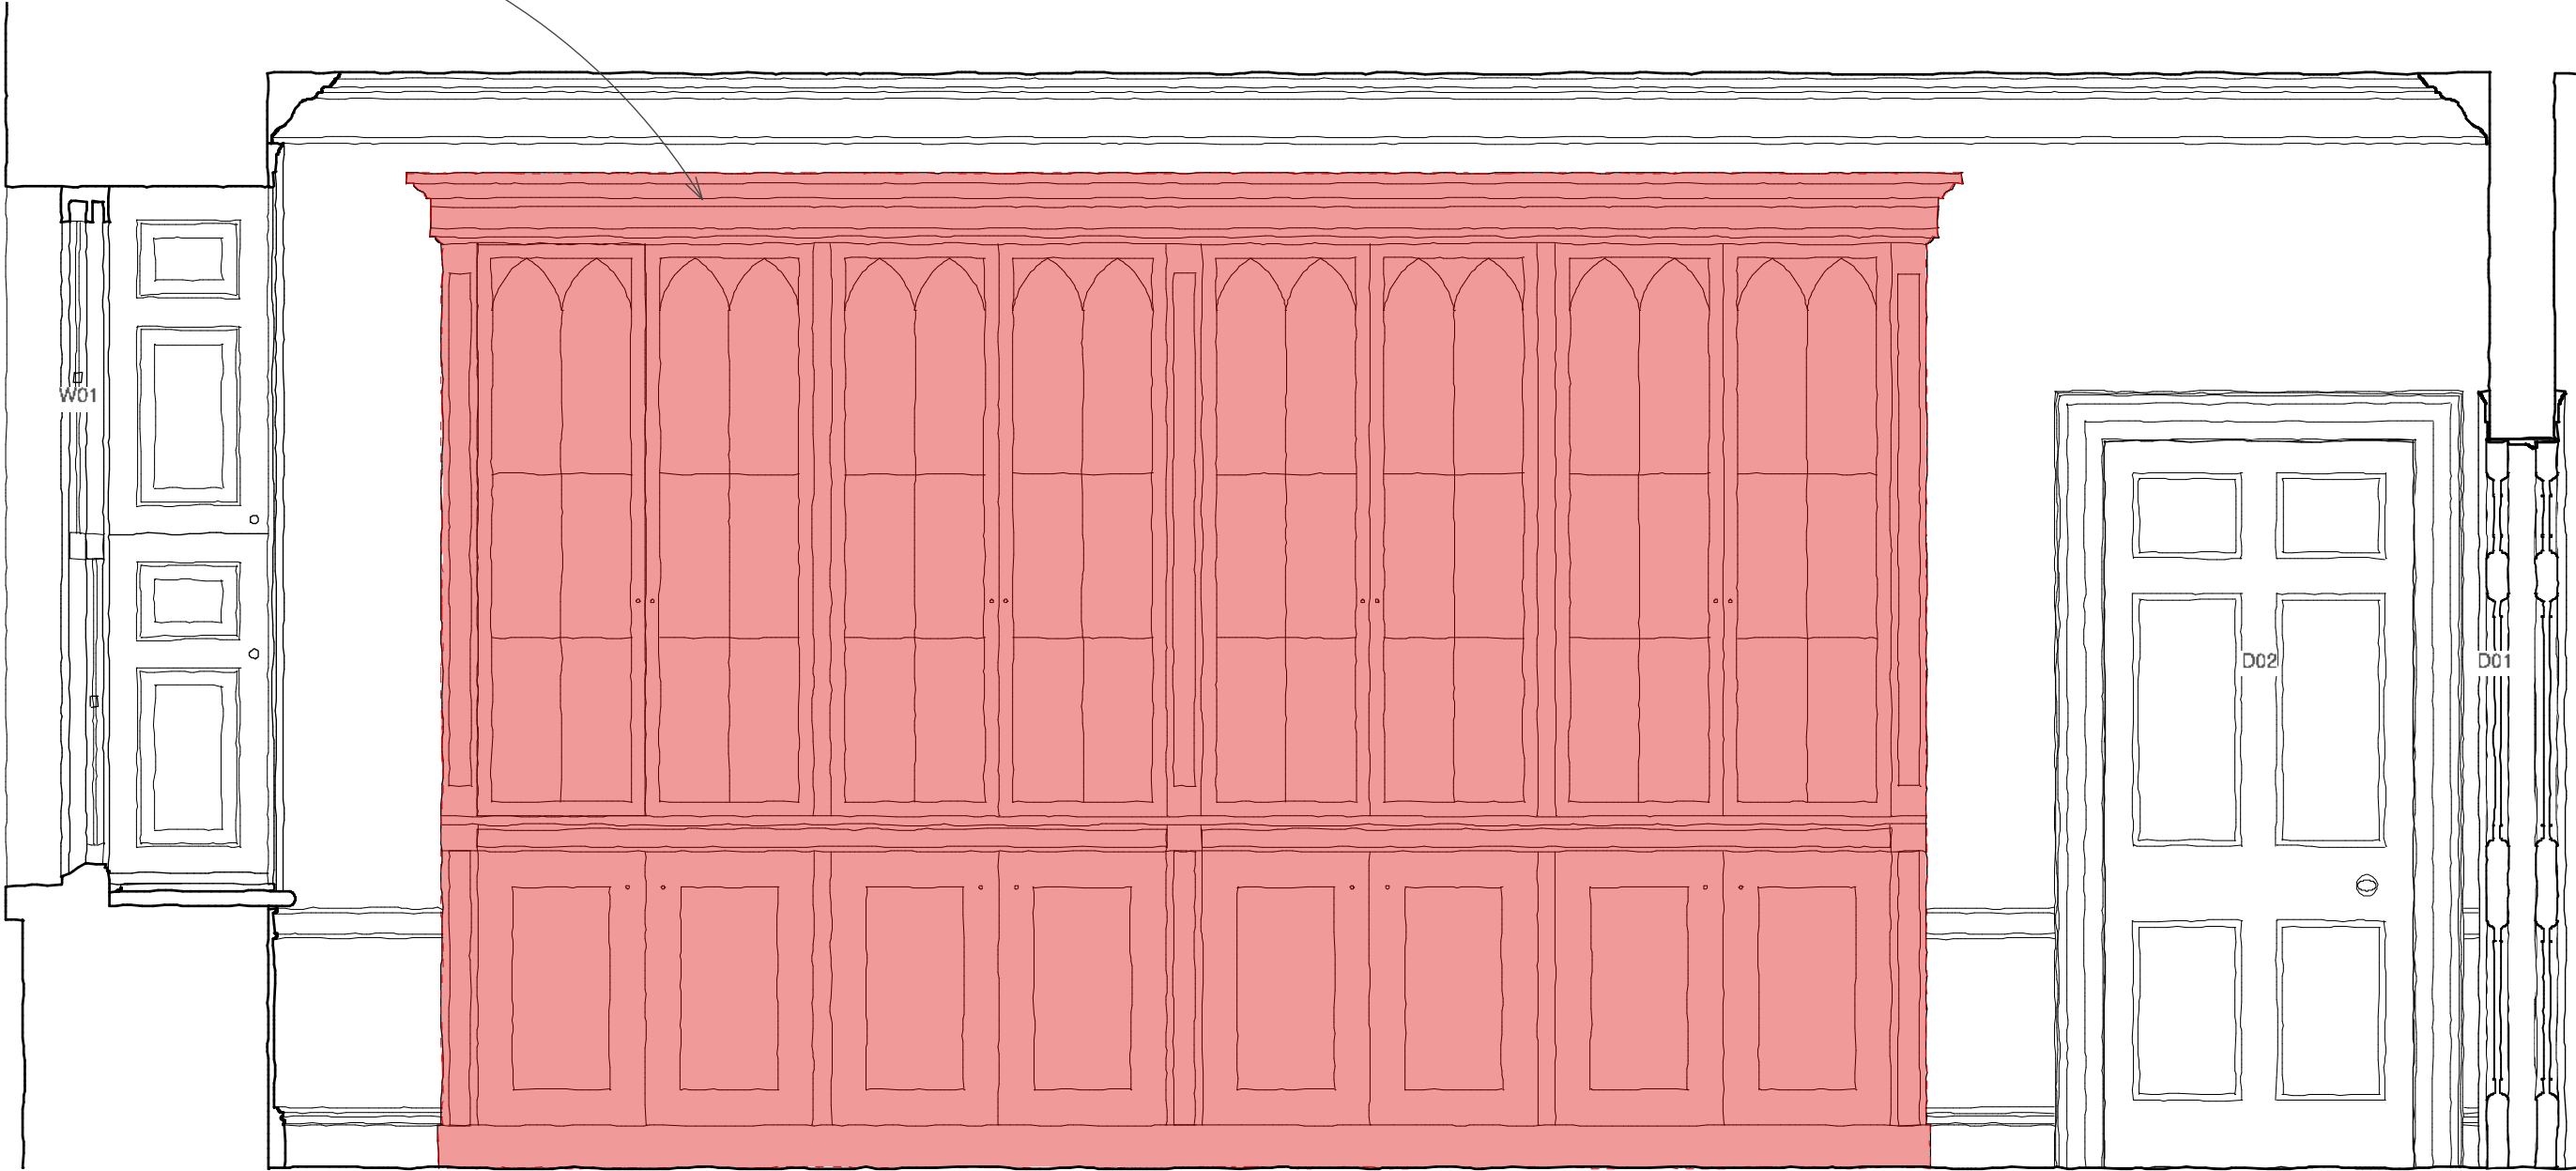

ELEVATION 3

Elements to be removed

DEMOLITIONS ROOM FR01 ELEVATION 3


0 1m 2m

1 : 20

DO NOT SCALE. Check all dimensions on site.

3 New Square
Title: Elevation 3 of Proposed Removals Room FR01
Drawing No: 0721019/Su21 Scale 1:20 @ A3
Butler Hegarty Architects
Unit 3.3, 159-163 Marlborough Road, London, N19 4NF
tel: 020 72638933 email: mail@butlerhegartyarchitects.co.uk

For existing Elevations, see Drawings No. 0721019/**Su20** and **Su21**
For proposed Plan and Elevations 1-4, see Drawing No. 0721019/**Sk22**

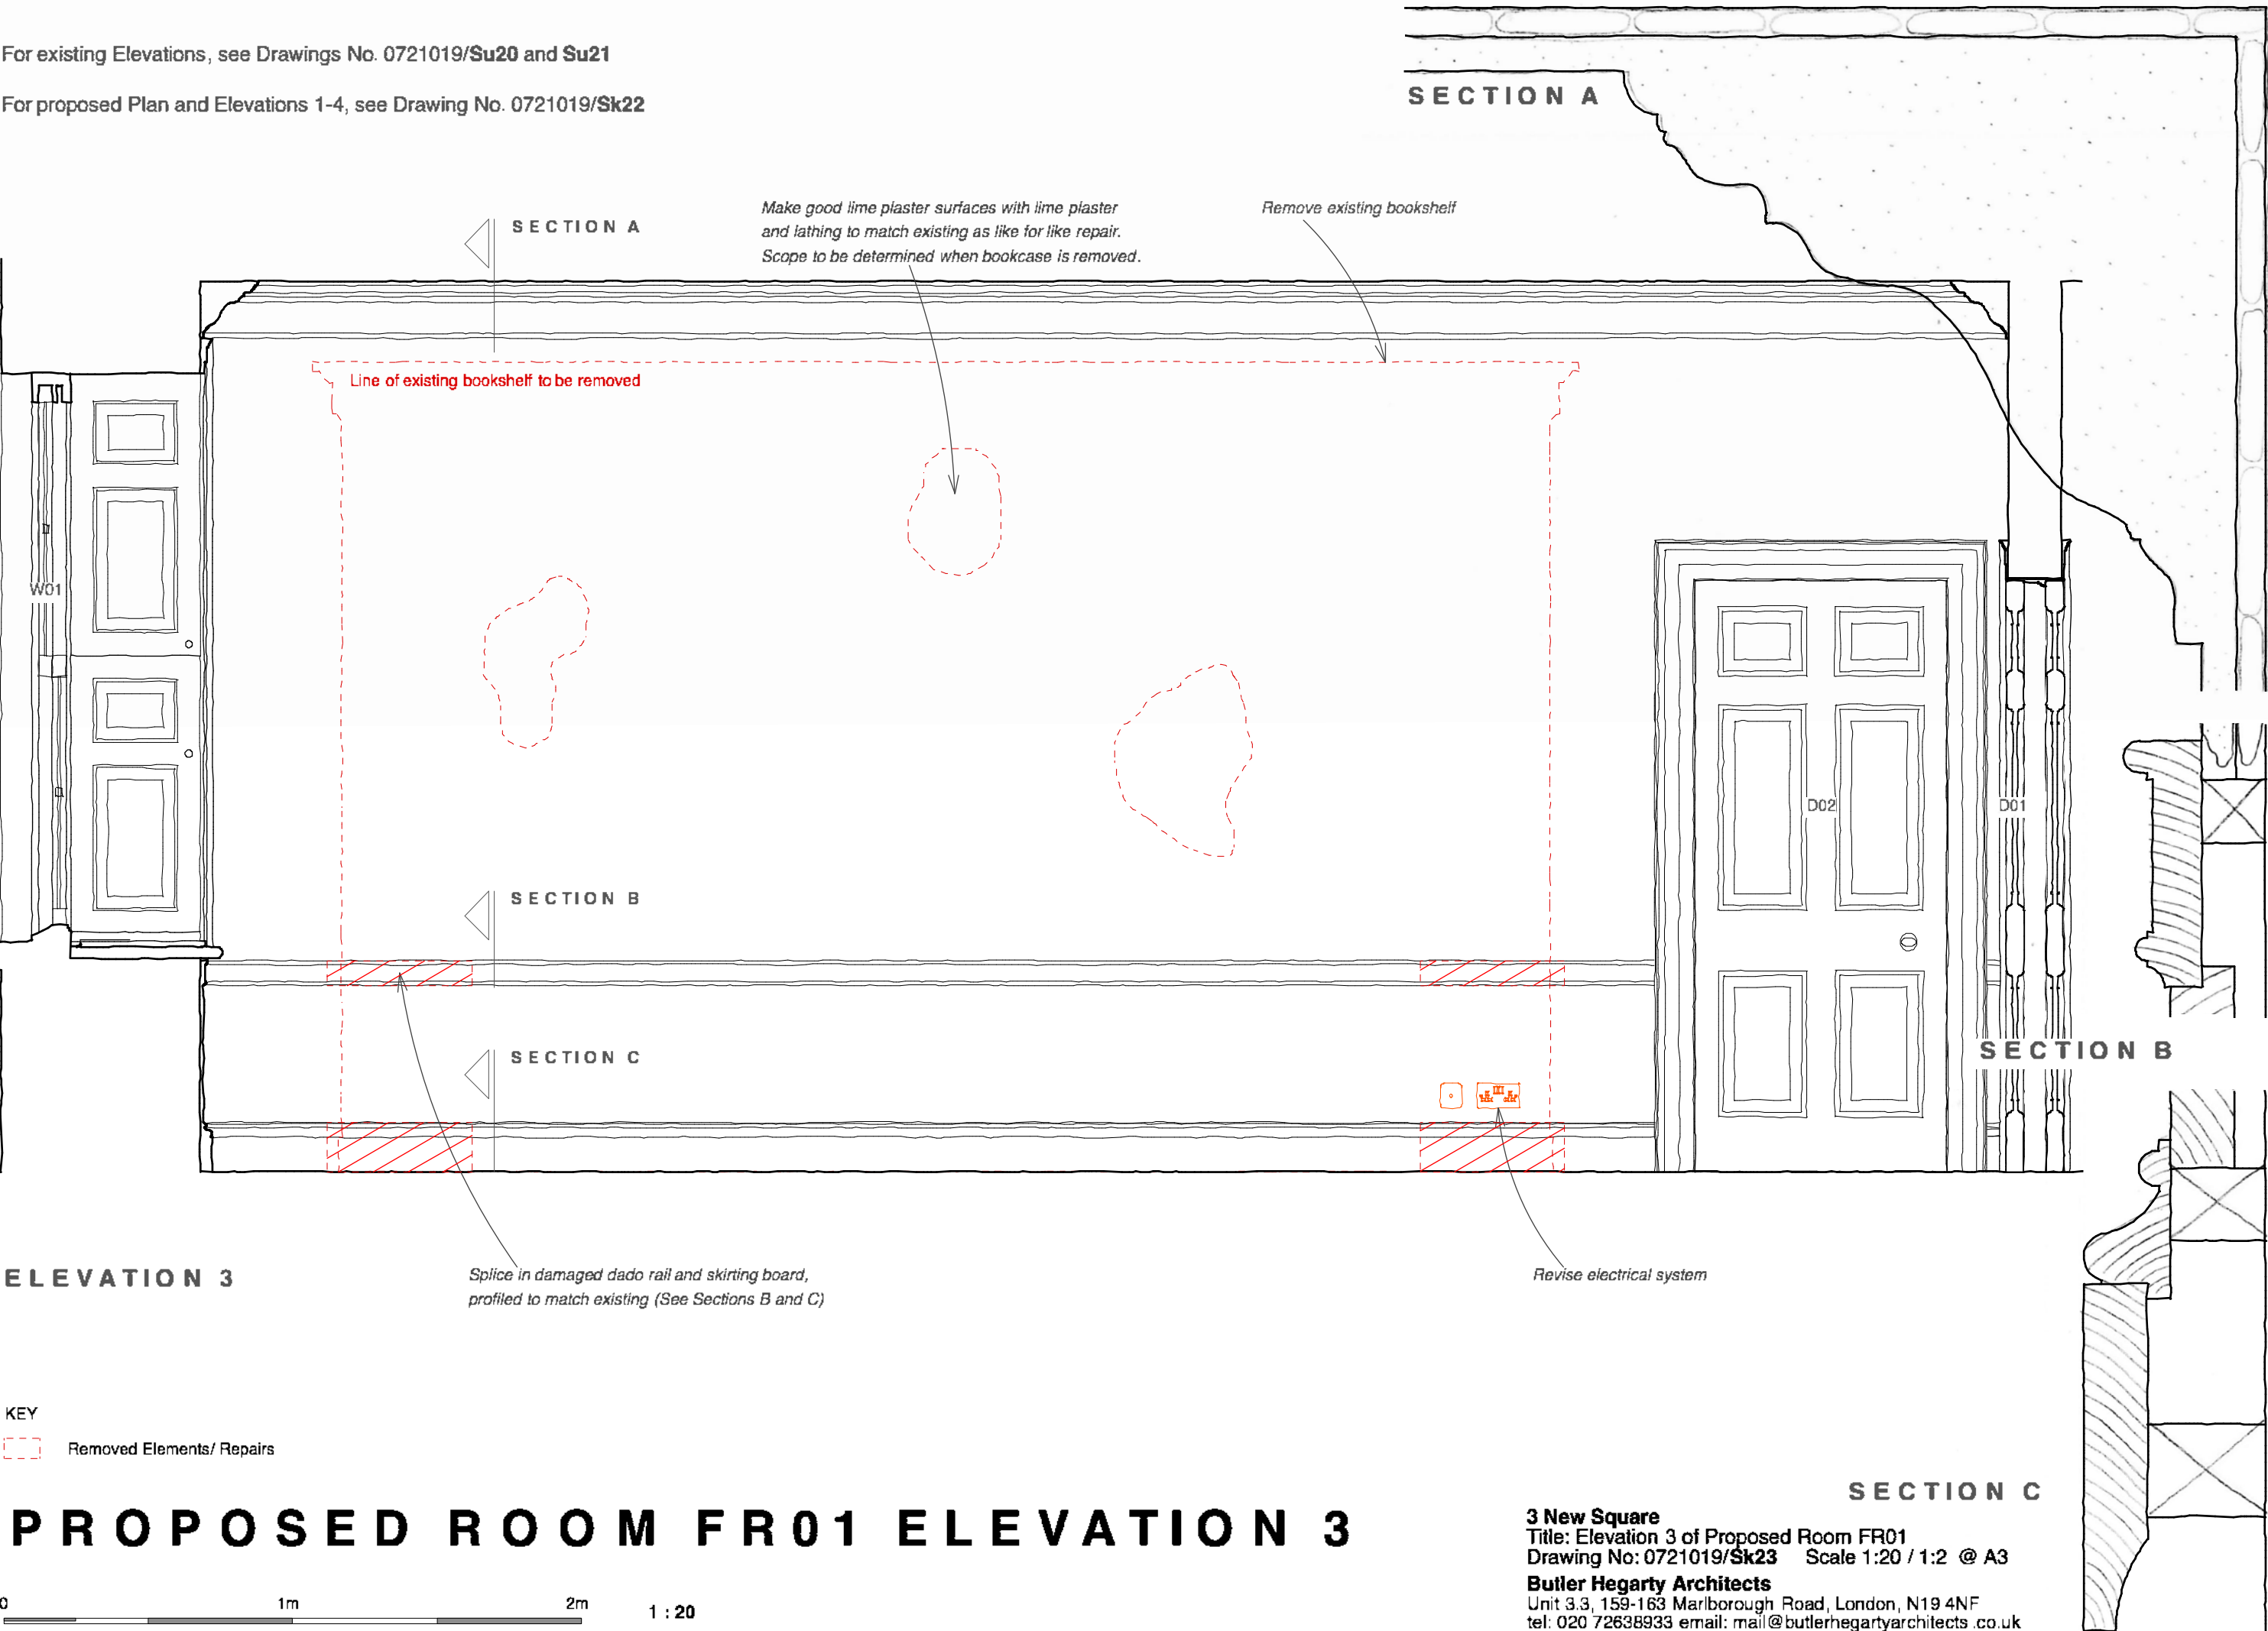

For existing Elevations, see Drawings No. 0721019/Su10 and Su22

For proposed Elevation 1 and detail drawings, see Drawings No. 0721019/Sk24 and Sk25

For proposed radiator grills, see Drawing 'Three New Square Radiator Grills'

Opening with new architrave to match existing door D02 (see Drawing no. 0721019/Sk25 for details)

Run lime plaster cornice to match existing profiles (see Drawing no. 0721019/Sk24 for details)

New lime plaster on riven chestnut lathing (see Drawing no. 0721019/Sk24 for detail)

Replacement dado and skirting to match existing (see Drawing no. 0721019/Sk24 for profile)

ELEVATION 1

Opening with new architrave to match existing door D02 (see Drawing No. 0721019/Sk25)

Proposed new lighting (See Drawing No. 0721019/Sk11 for new light fittings)


ELEVATION 2

Proposed new lighting (See Drawing No. 0721019/Sk11 for new light fittings)




ELEVATION 3

New radiator covers (See Drawing 'Three New Square Radiator Grills' for details)

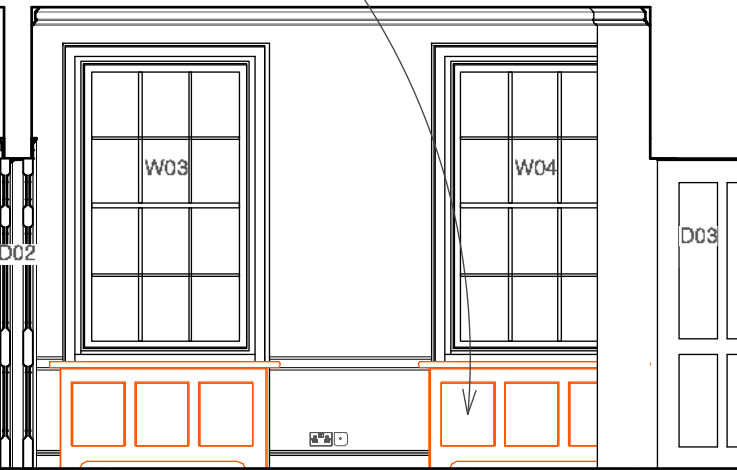

ELEVATION 4

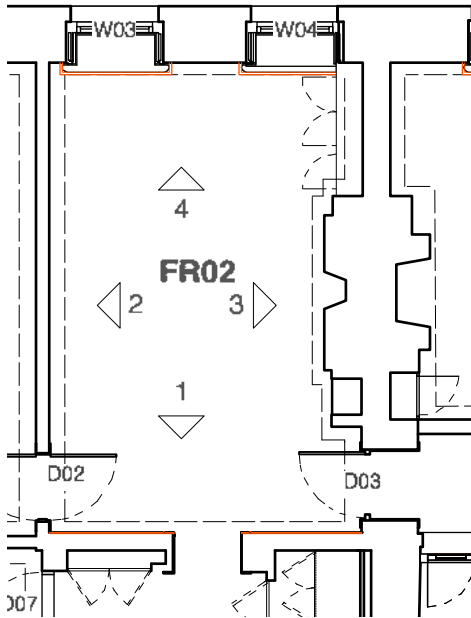

PART PLAN @ 1:100

Proposed elements

PROPOSED ELEVATIONS ROOM FR02

0 1m 5m

1 : 50


DO NOT SCALE. Check all dimensions on site.

3 New Square
Title: Proposed Room FR02 Elevation
Drawing No: 0721019/Sk04 Scale 1:50 @ A3
Butler Hegarty Architects
Unit 3.3, 159-163 Marlborough Road, London, N19 4NF
tel: 020 72638933 email: mail@butlerhegartyarchitects.co.uk

For proposed Plans, Elevations and Detail drawings, see Drawings No. 0721019/Sk04, Sk24 and Sk25

For existing Plan and Elevations 1-4, see Drawing No. 0721019/Su10

For photographs as existing, please see 'Photographs of Existing Chambers'

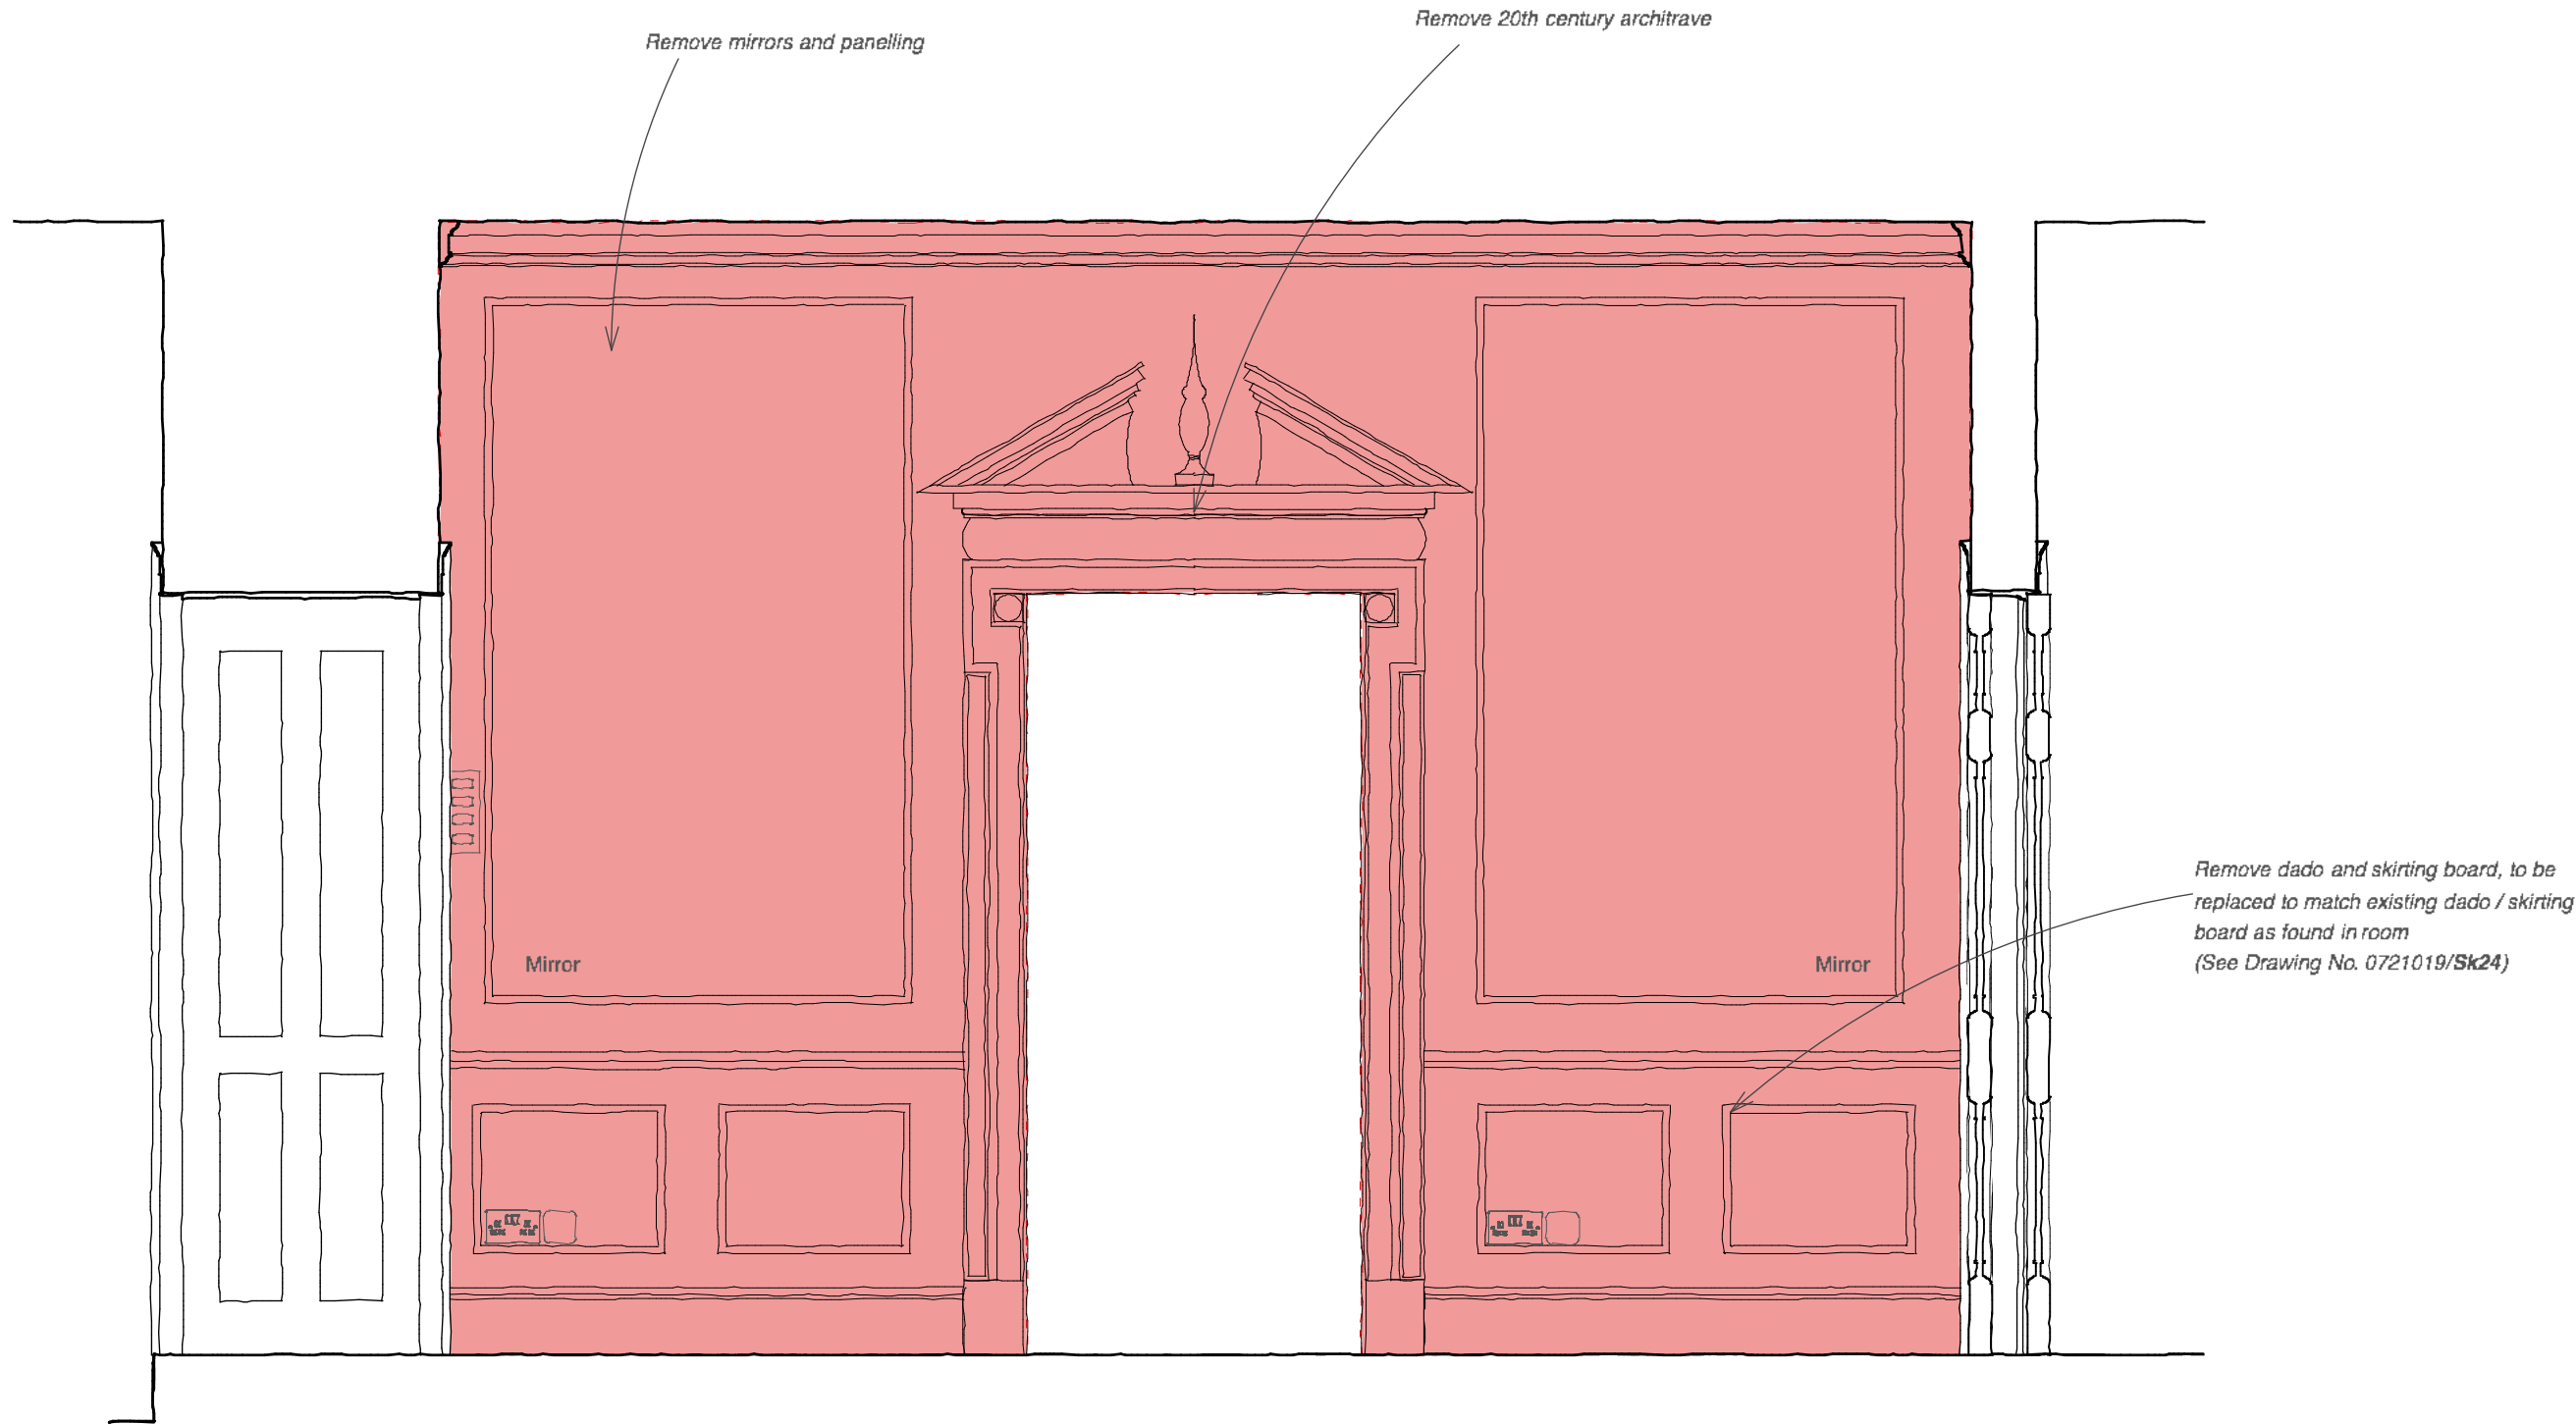

ELEVATION 1

Elements to be removed

DEMOLITIONS ROOM FR02 ELEVATION 1

0 1m 2m

1 : 20


DO NOT SCALE. Check all dimensions on site.

3 New Square
Title: Elevation of Proposed Removals Room FR02
Drawing No: 0721019/Su22 Scale 1:20 @ A3
Butler Hegarty Architects
Unit 3.3, 159-163 Marlborough Road, London, N19 4NF
tel: 020 72638933 email: mail@butlerhegartyarchitects.co.uk

For existing Elevations, see Drawings No. 0721019/**Su10** and **Su22**


For proposed Plan and Elevations 1-4, see Drawing No. 0721019/**Sk04**

For details of proposed architrave, see Drawing No. 0721019/**Sk25**

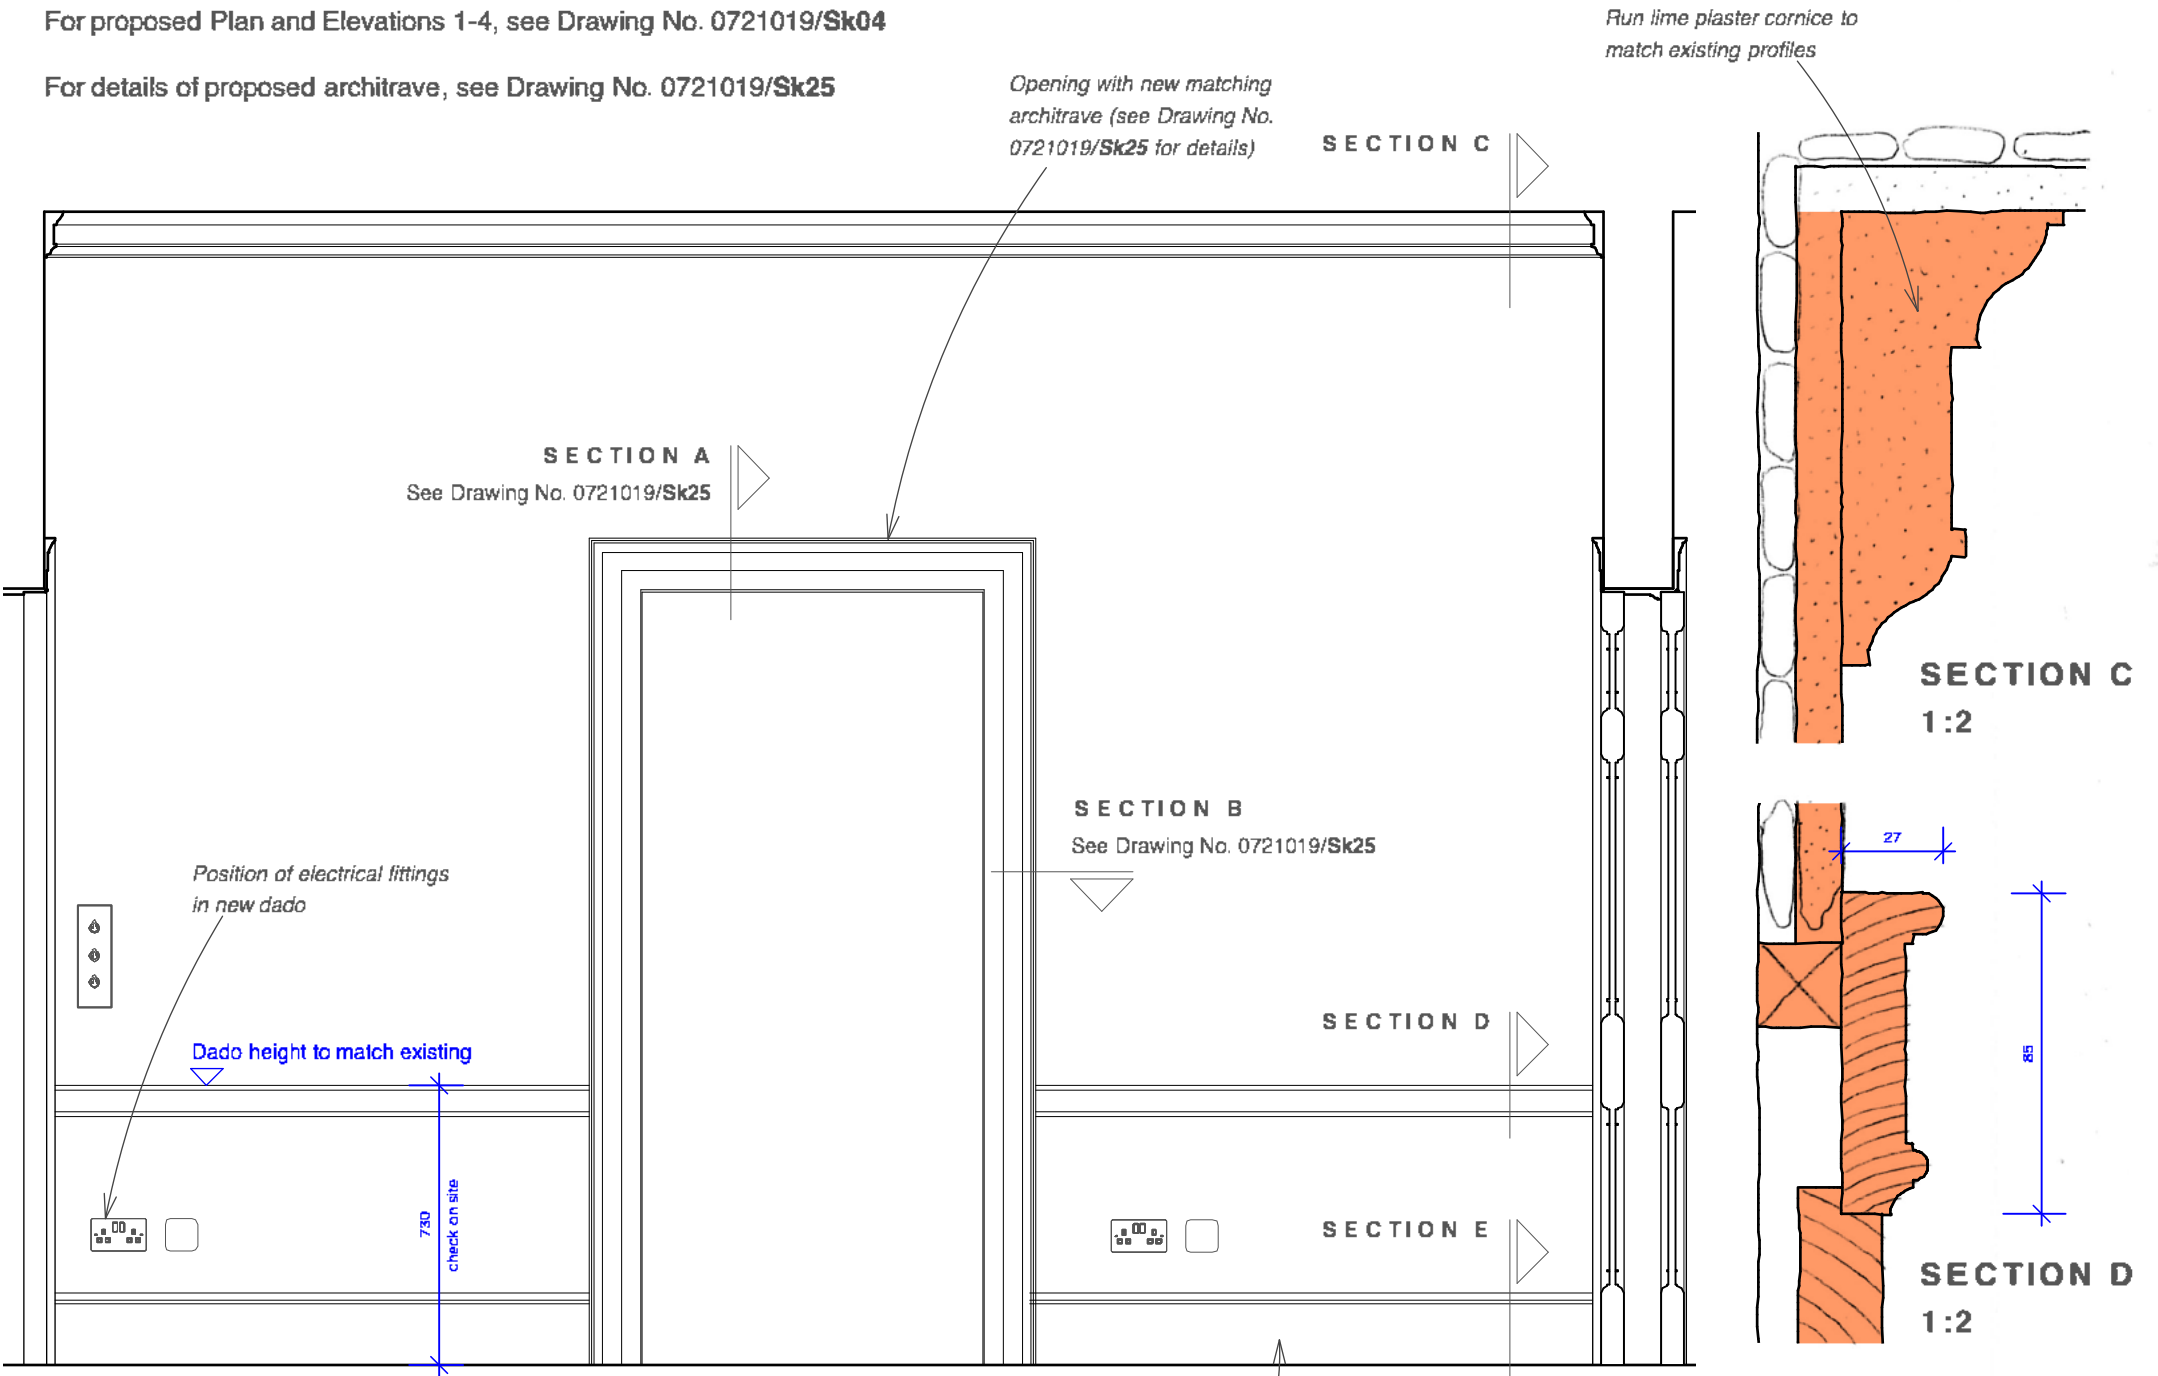


PROPOSED ELEVATION 1 1:20

Kitchenette
(See Drawing No. 0721019/**Sk18**)

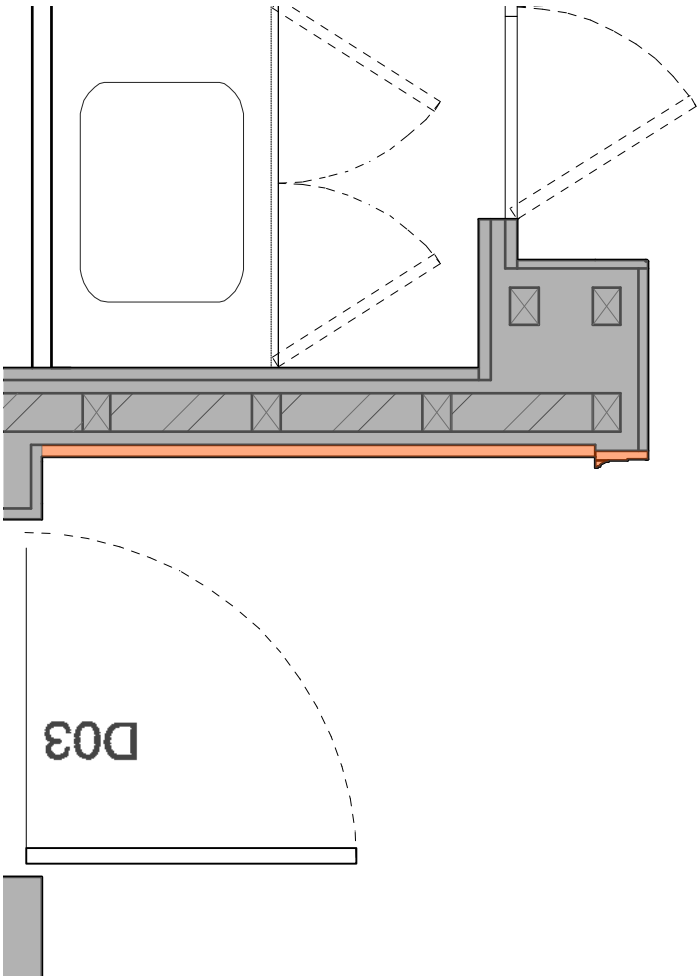

PART PLAN 1:20

Proposed architrave and plaster wall surface

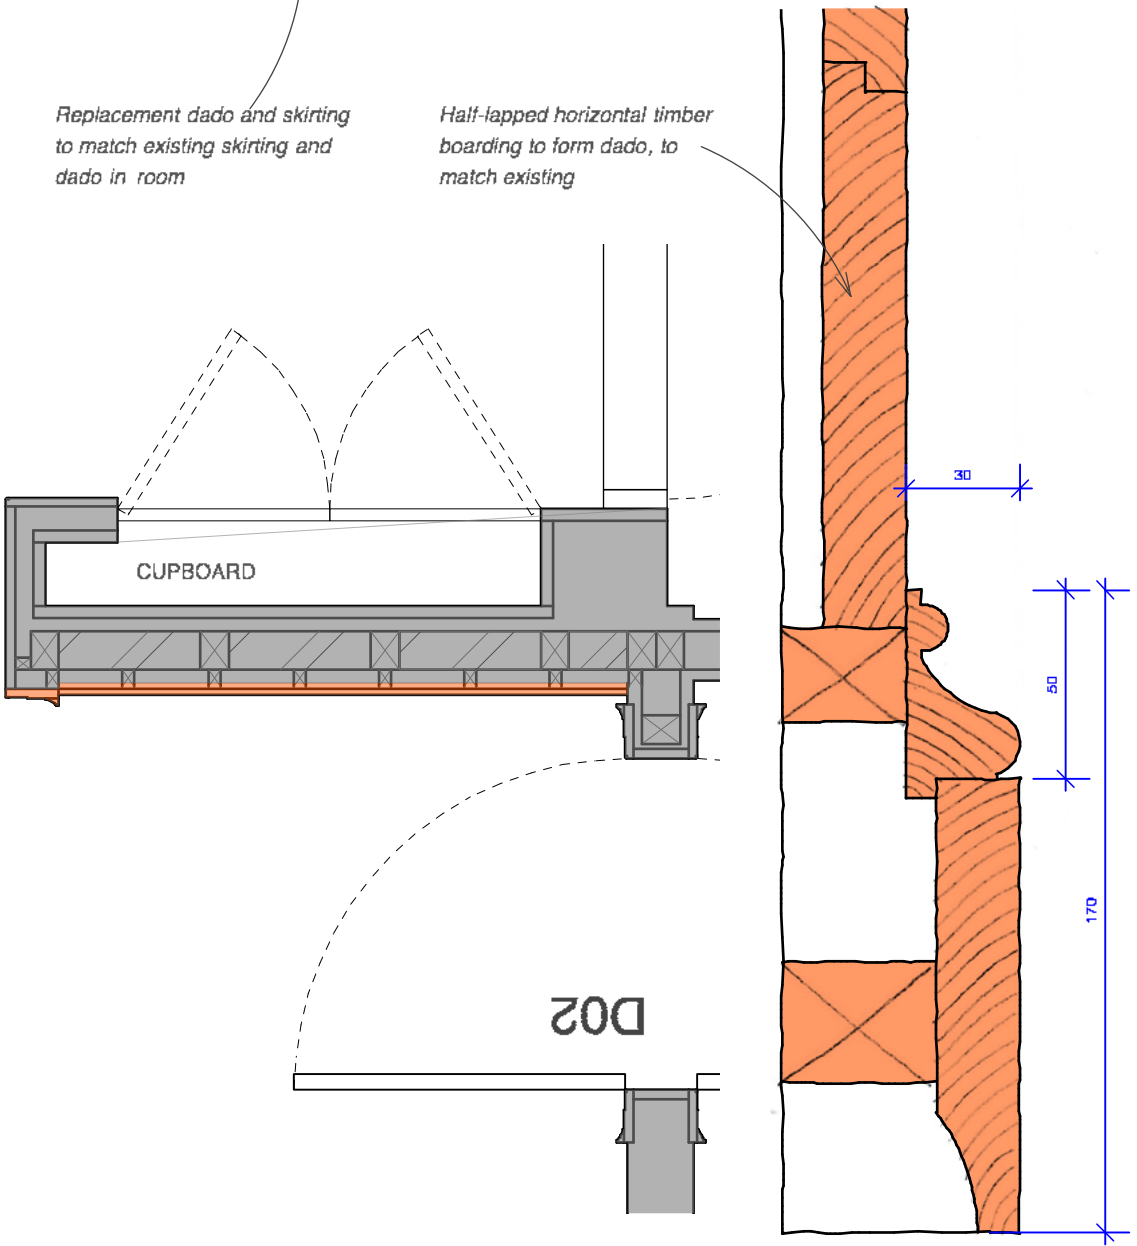


PROPOSED ROOM FR02

0 1m 2m

1 : 20


DO NOT SCALE. Check all dimensions on site.

3 New Square
Title: Proposed Room FR02 Elevation 1, Panelling Details
Drawing No: 0721019/**Sk24** Scale 1:20 / 1:2 @ A3
Butler Hegarty Architects
Unit 3.3, 159-163 Marlborough Road, London, N19 4NF
tel: 020 72638933 email: mail@butlerhegartyarchitects.co.uk

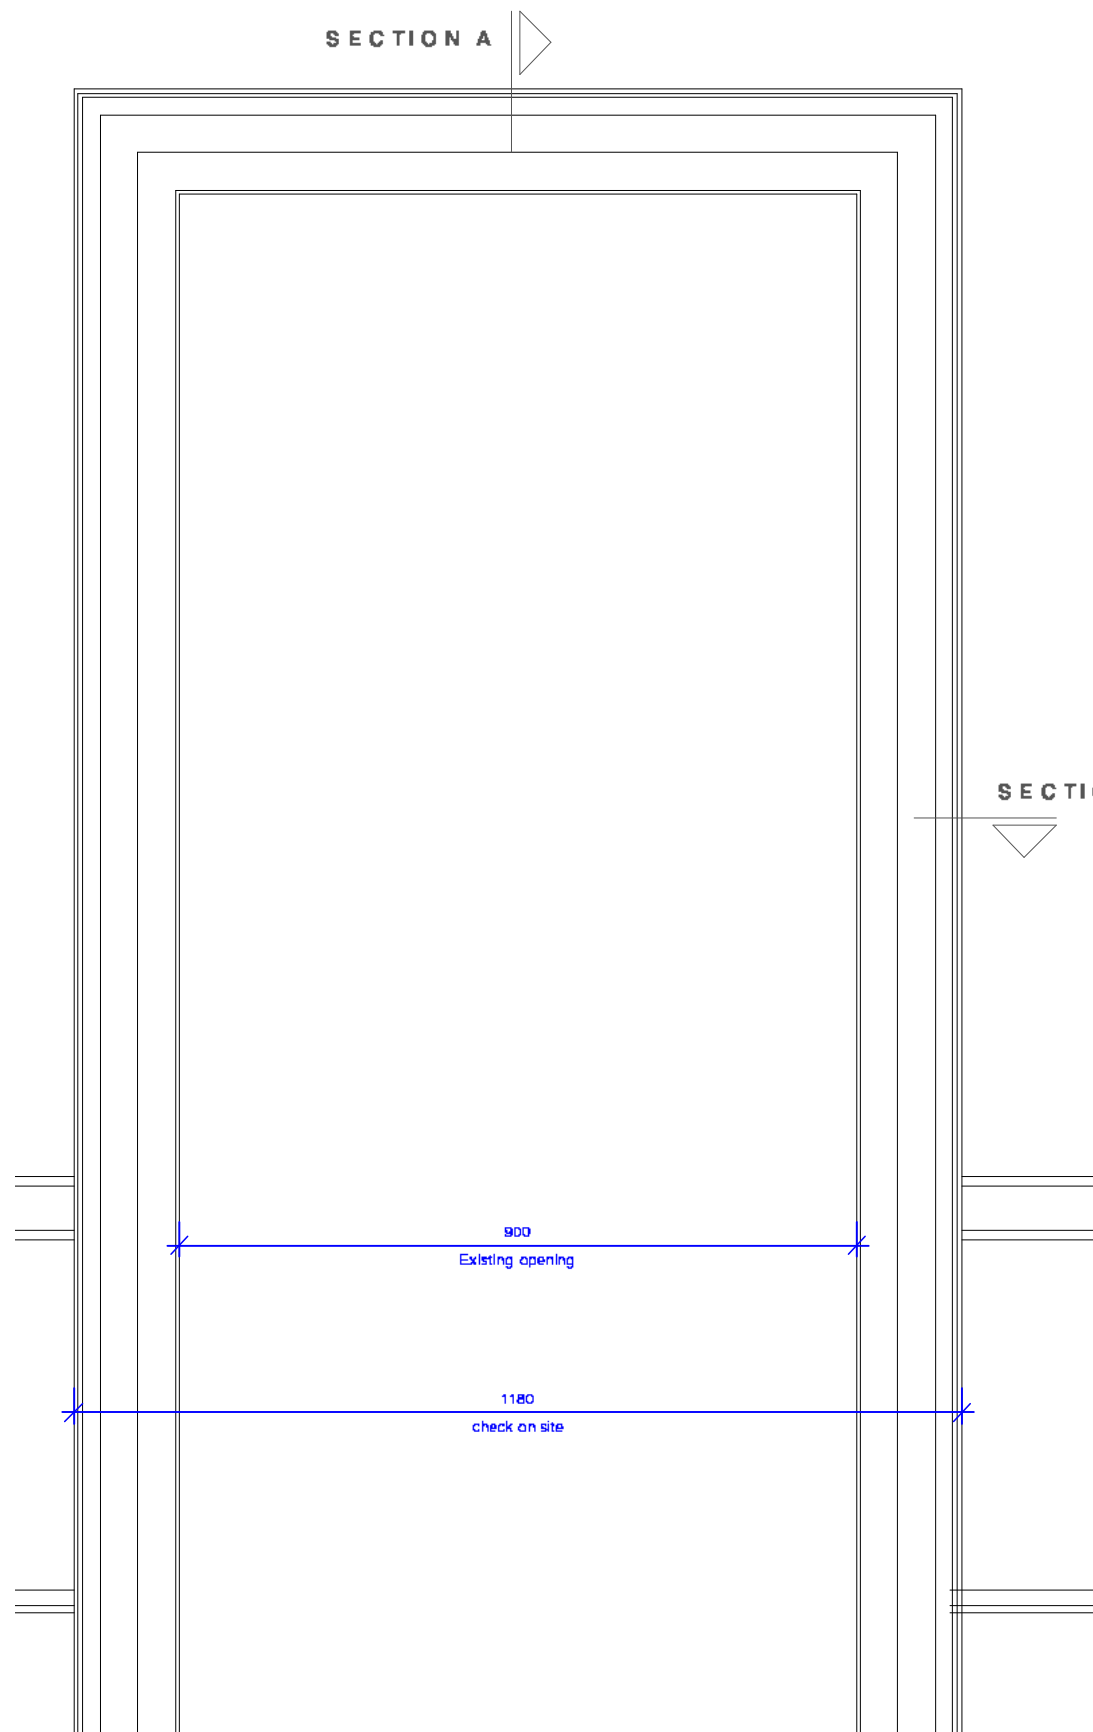


ELEVATION 1:10

 PROPOSED FR02 DETAILS




DO NOT SCALE. Check all dimensions on site.

1:10

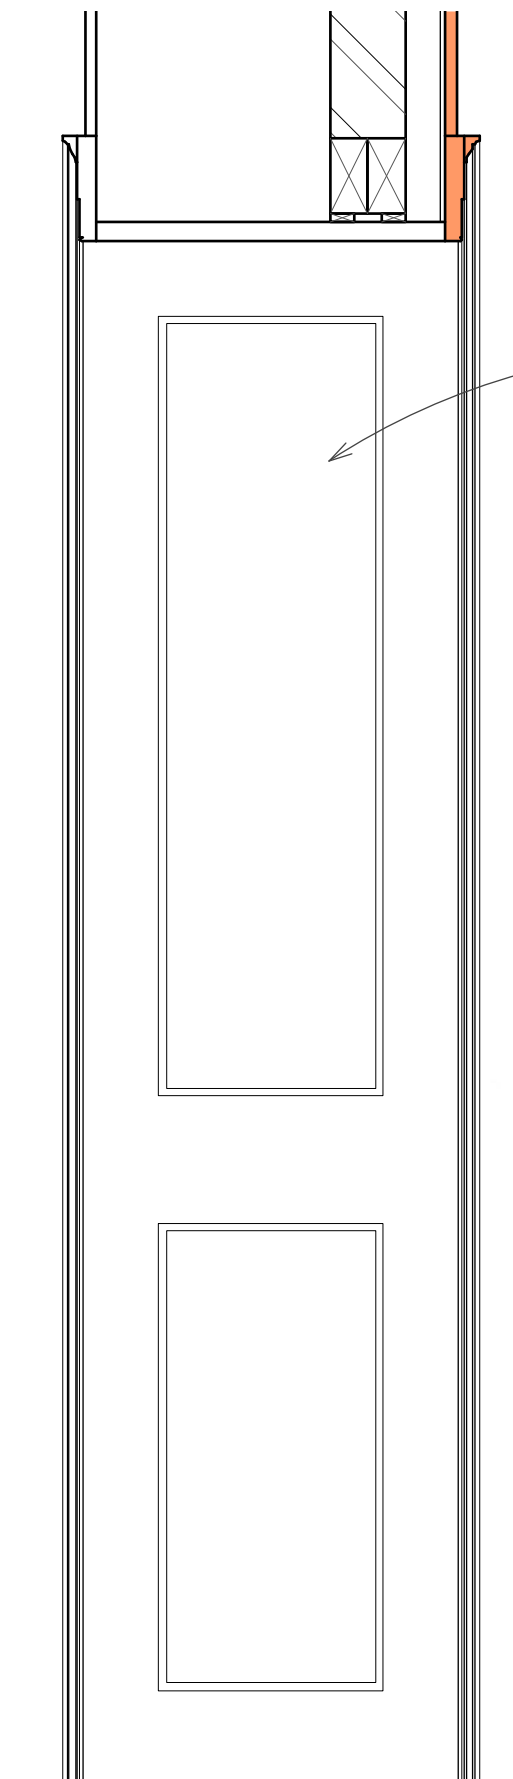

SECTION A 1:10

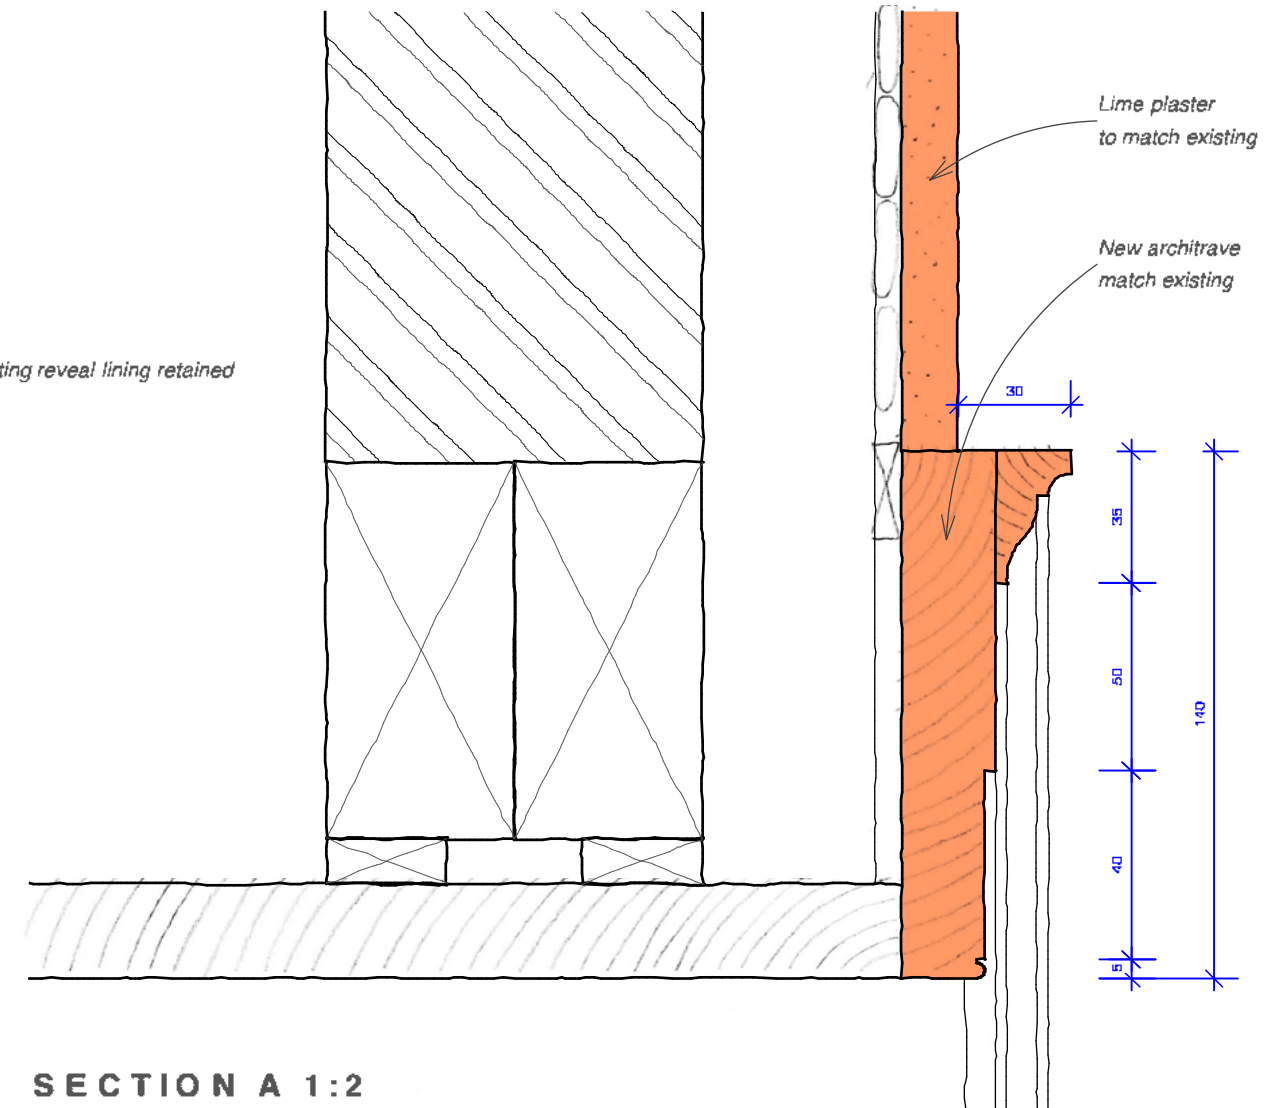

SECTION A 1:2



SECTION B 1:2


Proposed architrave and plaster wall surface

3 New Square
 Title: Proposed Room FR02 Elevation 1 Details
 Drawing No: 0721019/Sk25 Scale 1:10 / 1:2 @ A3
Butler Hegarty Architects
 Unit 3.3, 159-163 Marlborough Road, London, N19 4NF
 tel: 020 72638933 email: mail@butlerhegartyarchitects.co.uk

For existing Elevations, see Drawings No. 0721019/Su10 and Su22
 For proposed Plan and Elevations 1-4, see Drawing No. 0721019/Sk04
 For details of cornice, dado and skirting board, see Drawing No. 0721019/Sk24


For existing Elevations, see Drawing No. 0721019/Su18

For details of proposed radiator cover, see 'Three New Square Radiator Grills' by Nicola Lovell Design

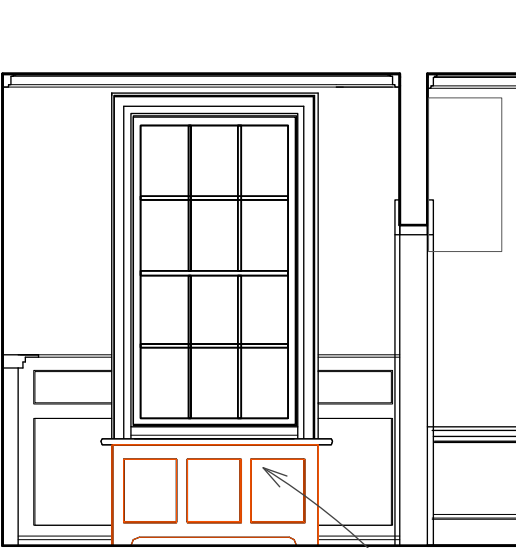


ELEVATION 1

New radiator cover
(See Drawing 'Three New Square Radiator Grills' for details)

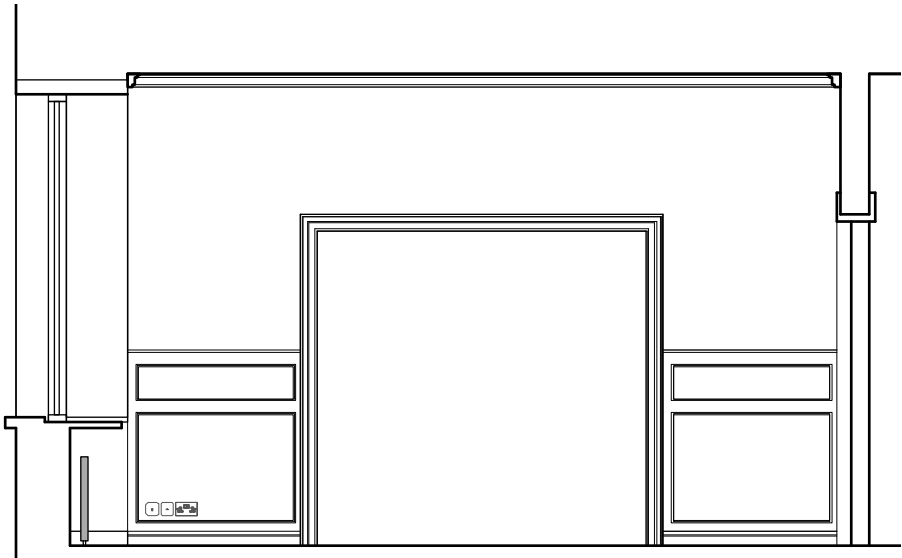


ELEVATION 2

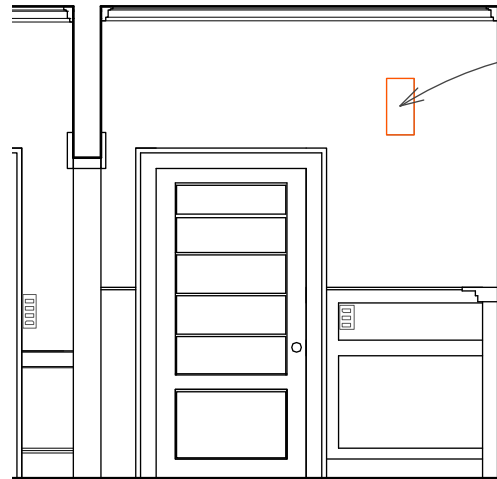


ELEVATION 3

New light fitting
(See Drawing No. 0721019/Sk11 for details)

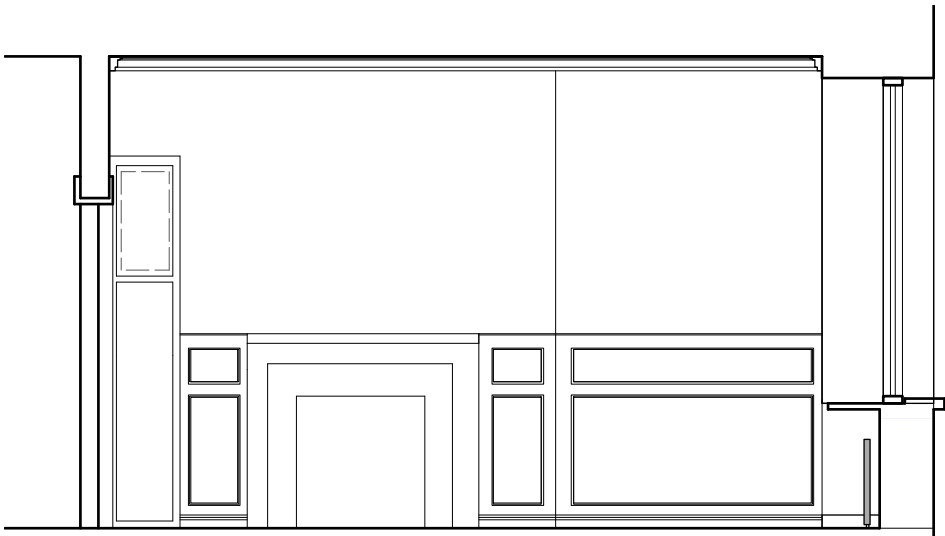

ELEVATION 4

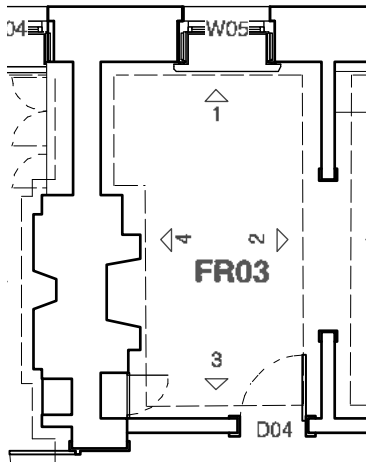

PART PLAN @ 1:100

PROPOSED ELEVATIONS ROOM FR03



1 : 50


DO NOT SCALE. Check all dimensions on site.

3 New Square
Title: Proposed Elevations Room FR03
Drawing No: 0721019/Sk10 Scale 1:50 @ A3
Butler Hegarty Architects
Unit 3.3, 159-163 Marlborough Road, London, N19 4NF
tel: 020 72638933 email: mail@butlerhegartyarchitects.co.uk


For existing Elevations, see Drawing No. 0721019/Su19




ELEVATION 1

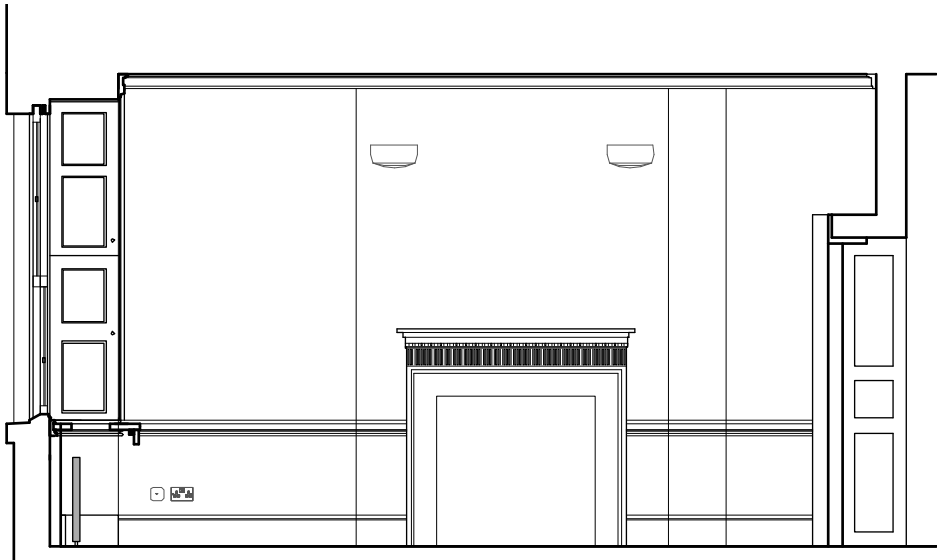


ELEVATION 2

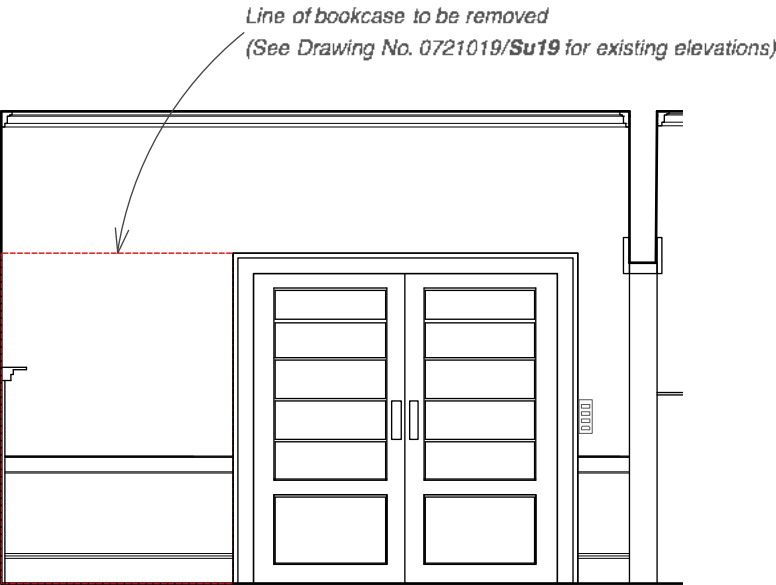

ELEVATION 3

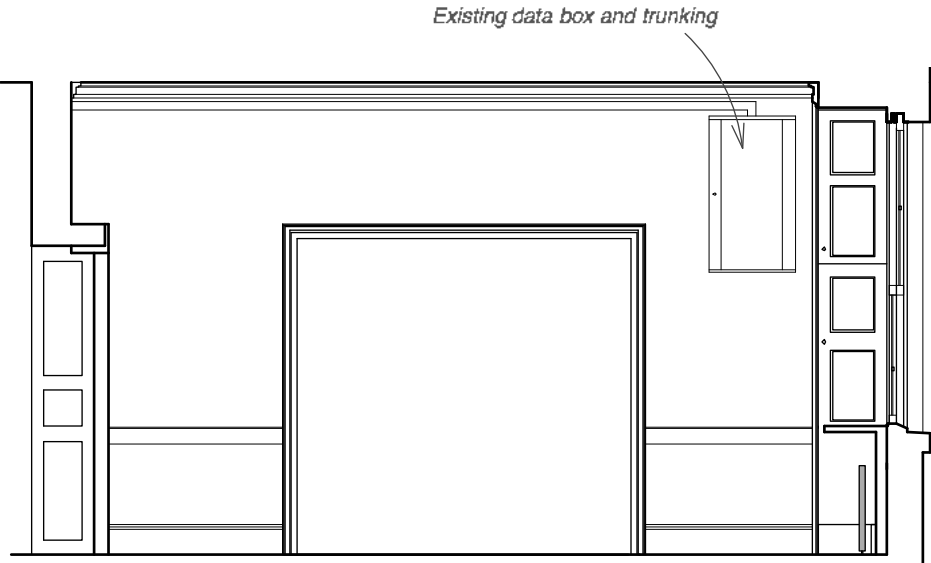

ELEVATION 4

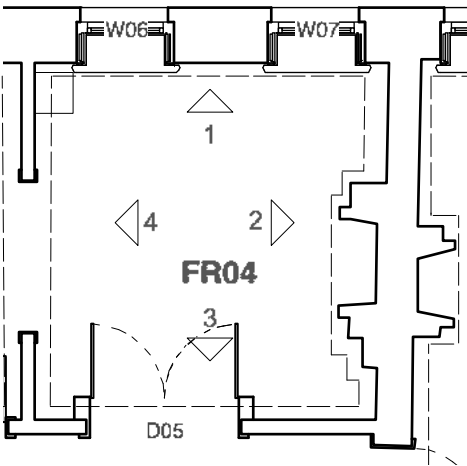

PART PLAN @ 1:100

PROPOSED ELEVATIONS ROOM FR04

0 1m 5m

1 : 50

DO NOT SCALE. Check all dimensions on site.


3 New Square
Title: Proposed Room FR04 Elevations
Drawing No: 0721019/Sk06 Scale 1:50 @ A3
Butler Hegarty Architects
Unit 3.3, 159-163 Marlborough Road, London, N19 4NF
tel: 020 72638933 email: mail@butlerhegartyarchitects.co.uk

For existing Elevations, see Drawings No. 0721019/**Su23** and **Su24**


For proposed Elevation 3, see Drawing No. 0721019/**Sk26**




ELEVATION 1

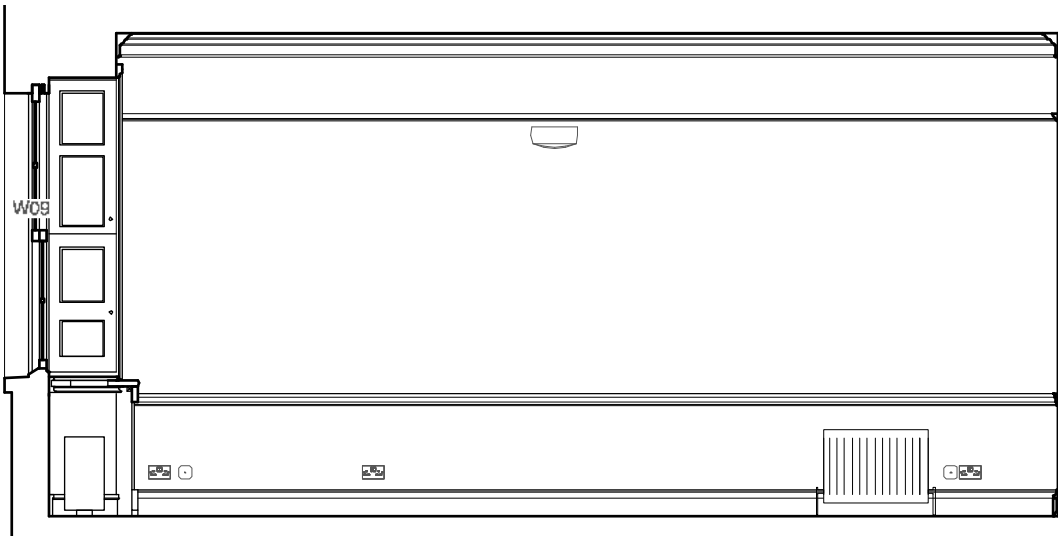


ELEVATION 2

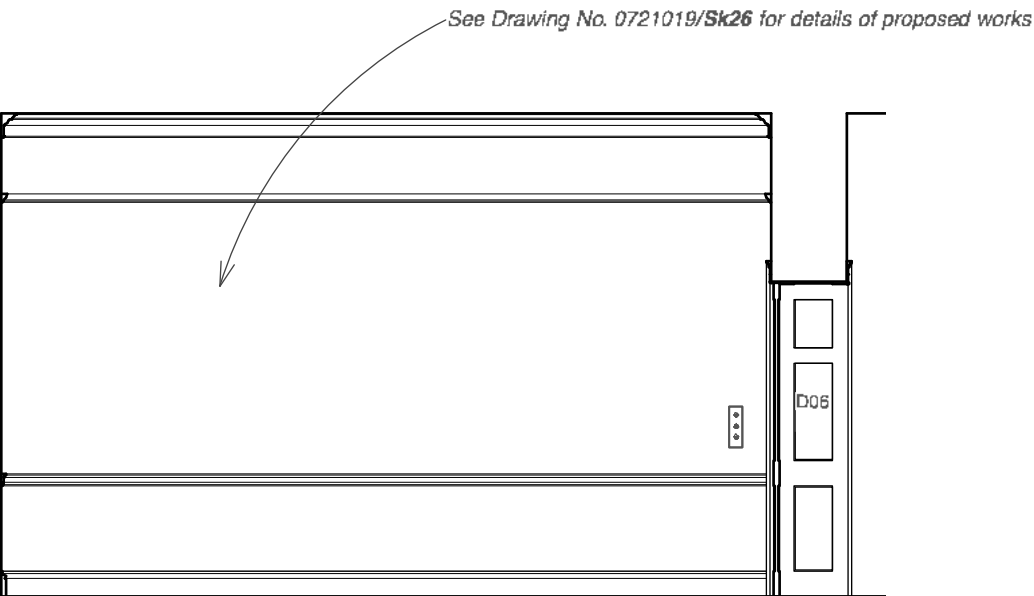

ELEVATION 3

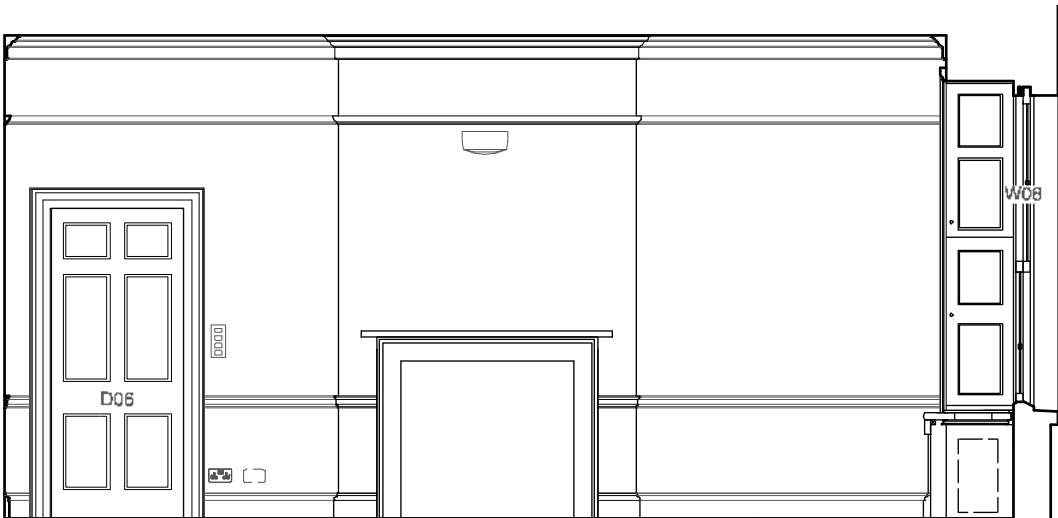

ELEVATION 4

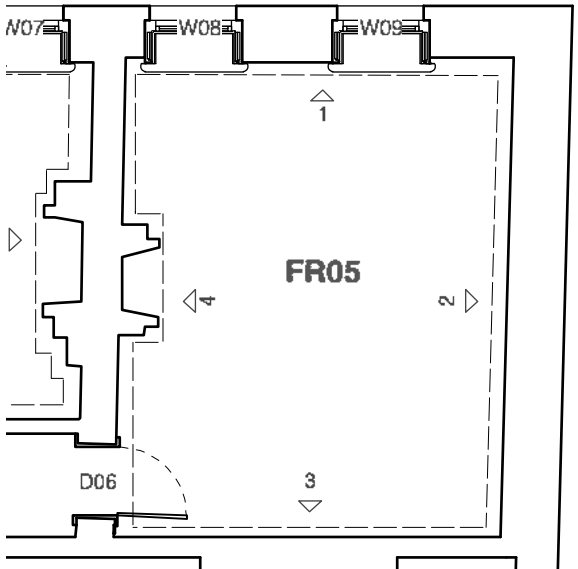

PLAN FR05 @ 1:100

PROPOSED ELEVATIONS ROOM FR05

0 1m 5m

1 : 50


DO NOT SCALE. Check all dimensions on site.

3 New Square
Title: Proposed Room FR05 Elevation
Drawing No: 0721019/**Sk21** Scale 1:50 @ A3
Butler Hegarty Architects
Unit 3.3, 159-163 Marlborough Road, London, N19 4NF
tel: 020 72638933 email: mail@butlerhegartyarchitects.co.uk

For proposed Plans and Elevations , see Drawings No. 0721019/**Sk21** and **SK26**

For existing plan and Elevations 1-4, see Drawing No. 0721019/**Su23**


For photographs as existing, please see '**Photographs of Existing Chambers**'

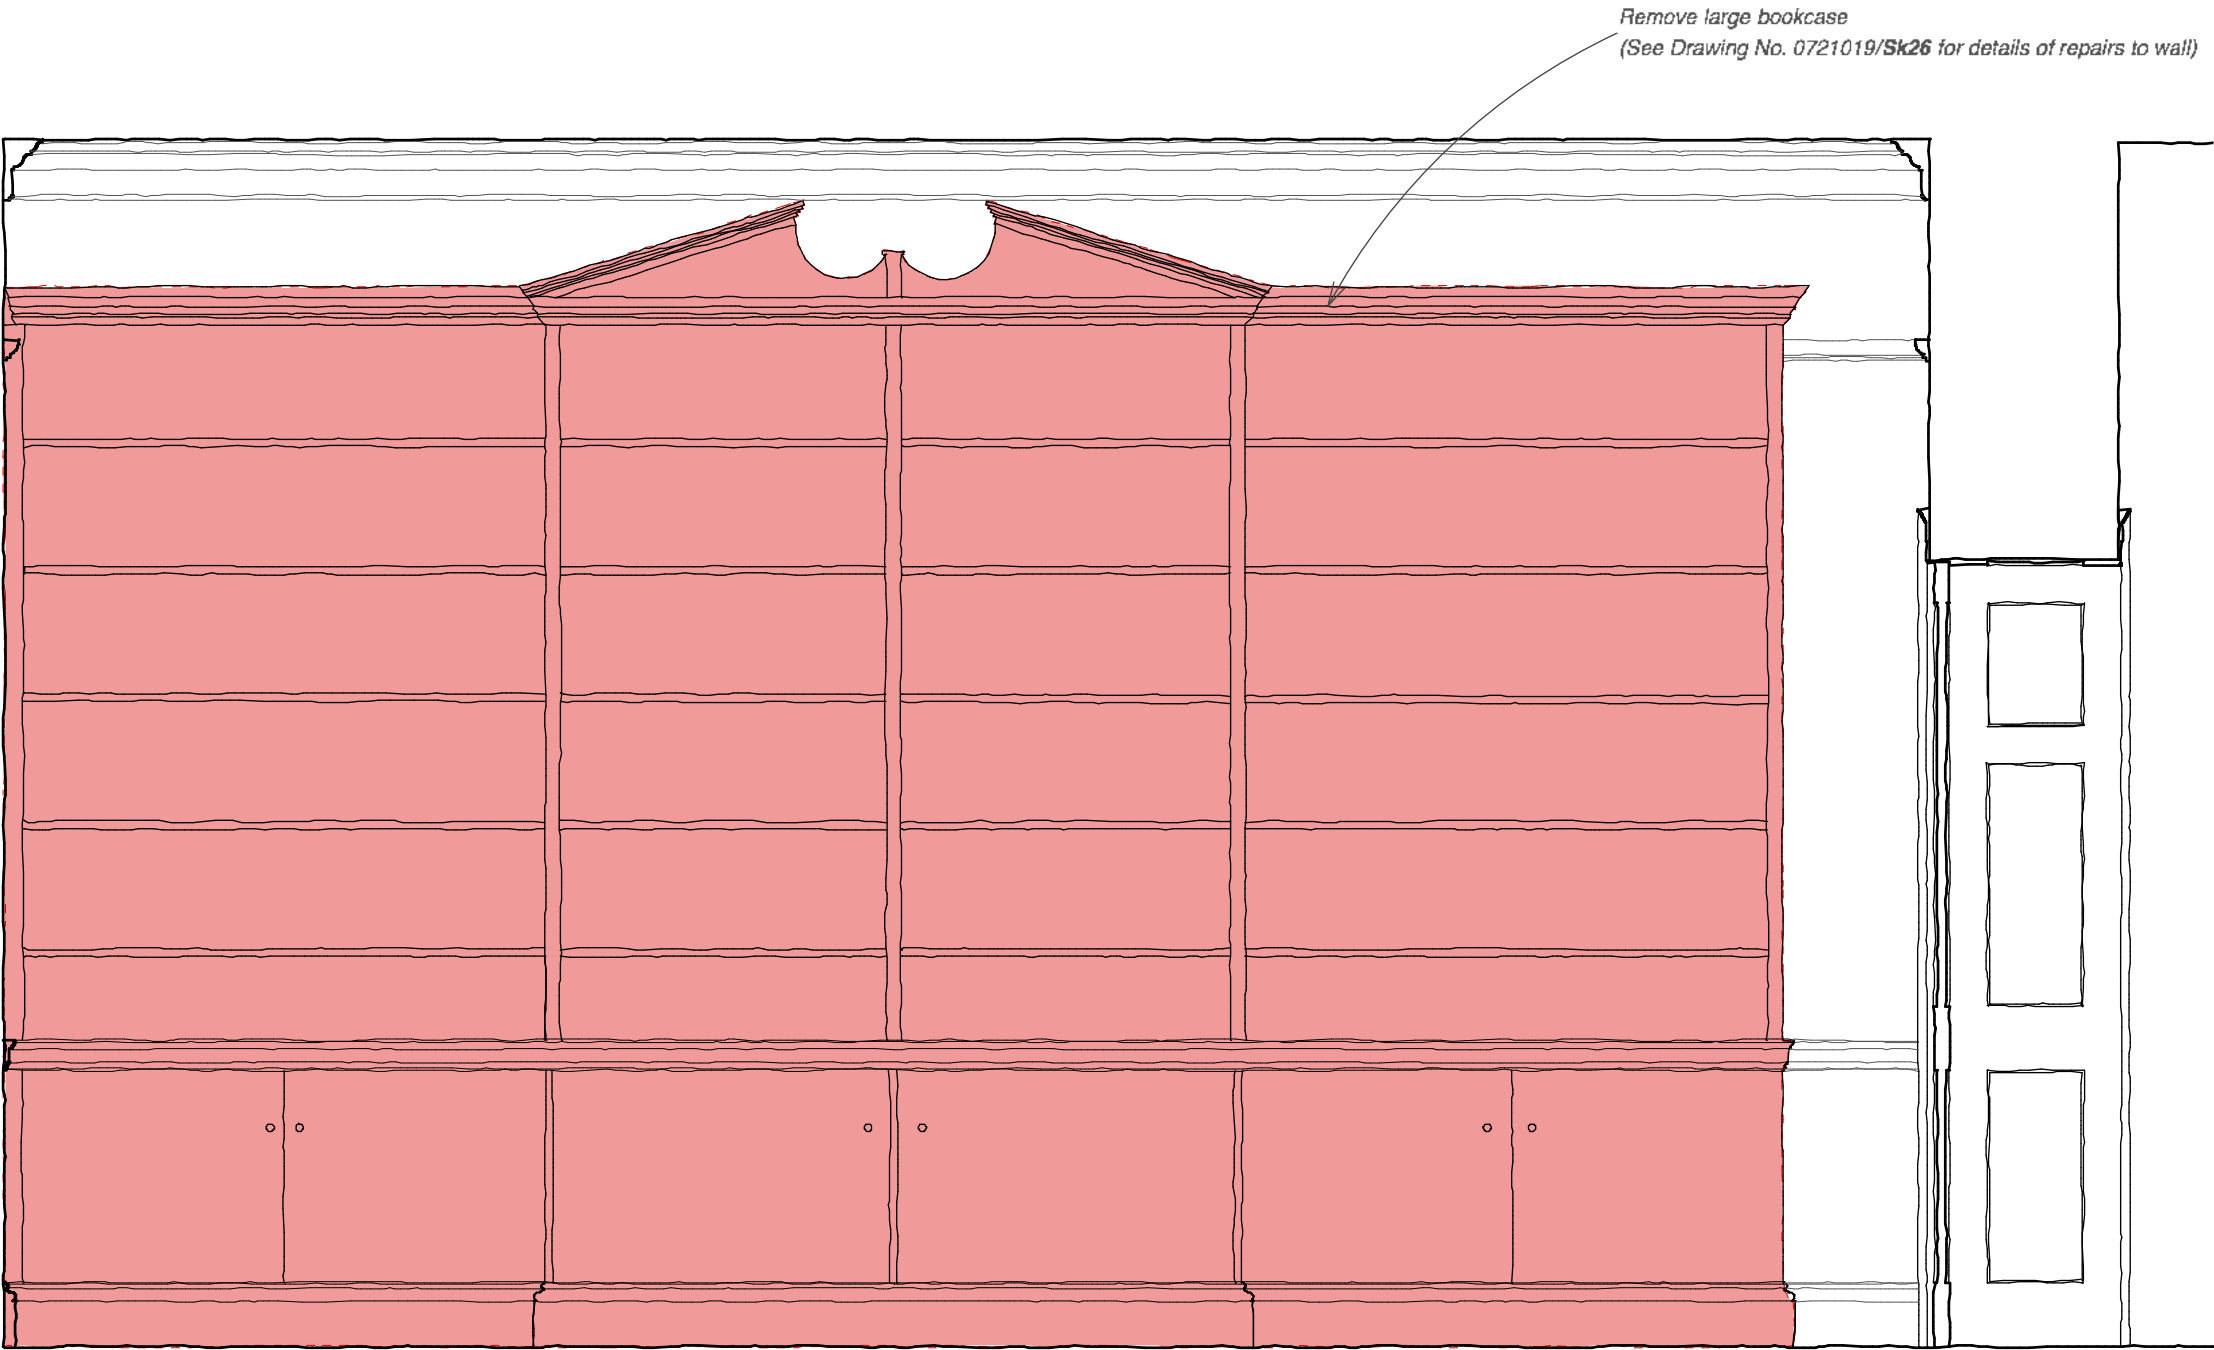

ELEVATION 3

Elements to be removed

 DEMOLITIONS ROOM FR05 ELEVATION 3




1 : 20

DO NOT SCALE. Check all dimensions on site.

3 New Square
Title: Elevation 3 of Proposed Removals Room FR05
Drawing No: 0721019/**Su24** Scale 1:20 @ A3
Butler Hegarty Architects
Unit 3.3, 159-163 Marlborough Road, London, N19 4NF
tel: 020 72638933 email: mail@butlerhegartyarchitects.co.uk

For existing Elevations, see Drawings No. 0721019/**Su23** and **Su24**

For proposed Plan and Elevations 1-4, see Drawing No. 0721019/**Sk21**

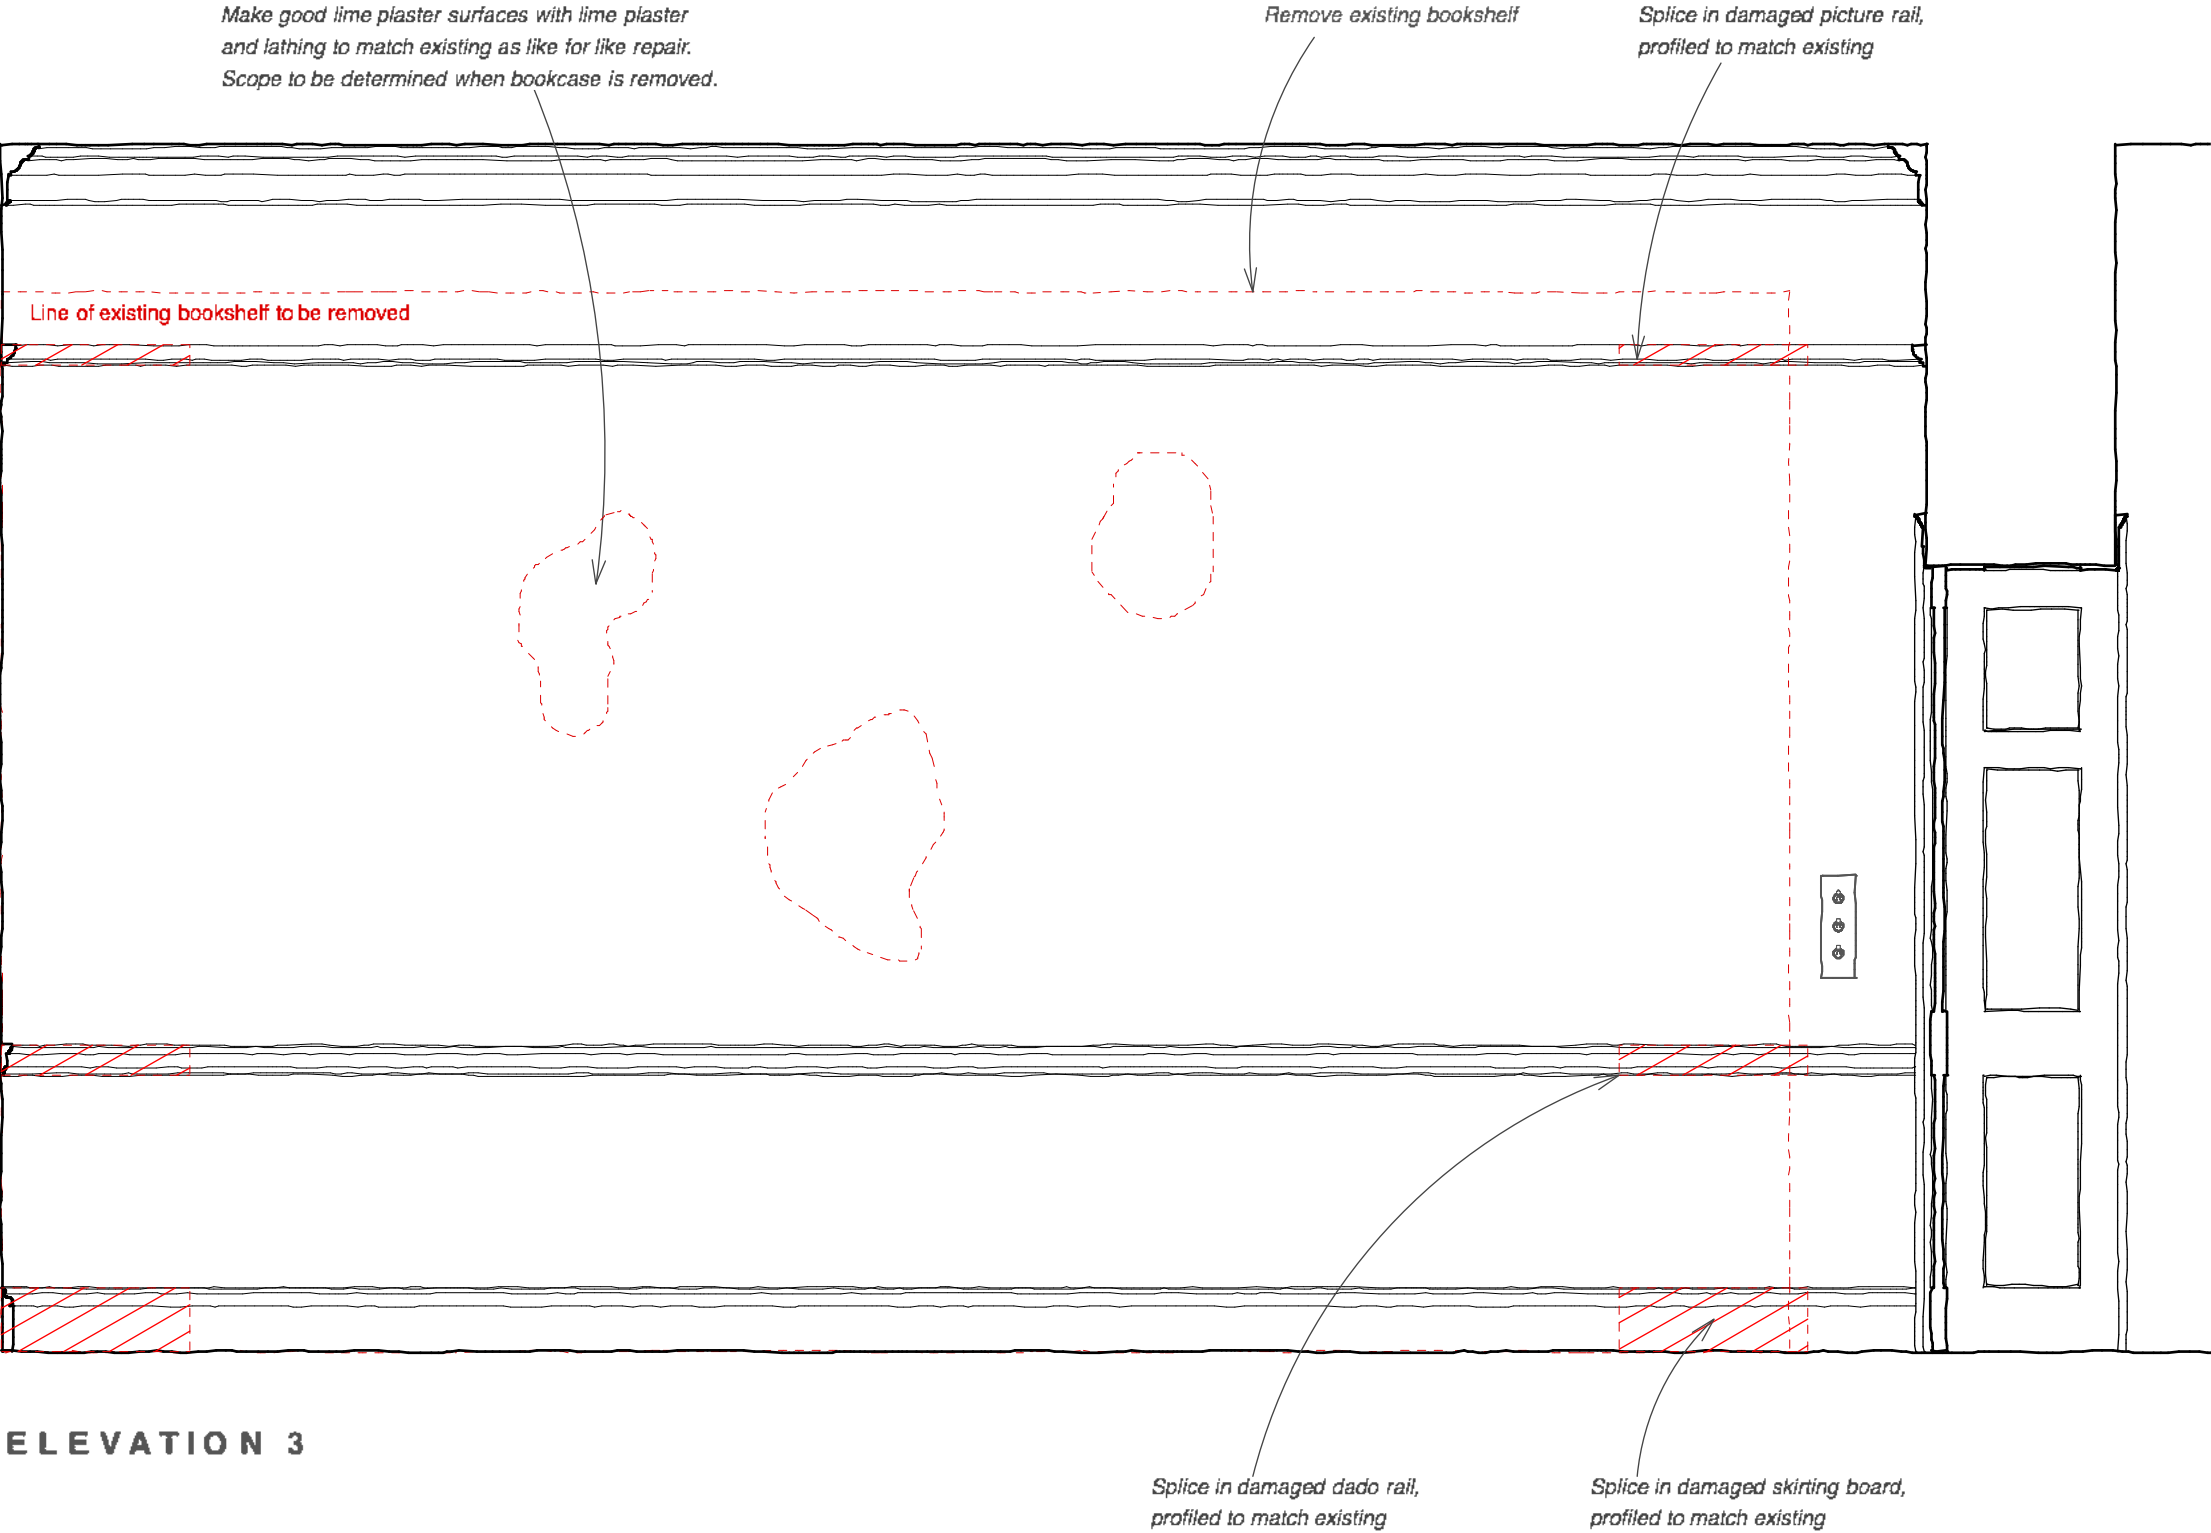


KEY

Removed Elements/ Repairs


PROPOSED ROOM FR05 ELEVATION 3




3 New Square
Title: Proposed Room FR05 Elevation 3
Drawing No: 0721019/**Sk26** Scale 1:20 @ A3
Butler Hegarty Architects
Unit 3.3, 159-163 Marlborough Road, London, N19 4NF
tel: 020 72638933 email: mail@butlerhegartyarchitects.co.uk

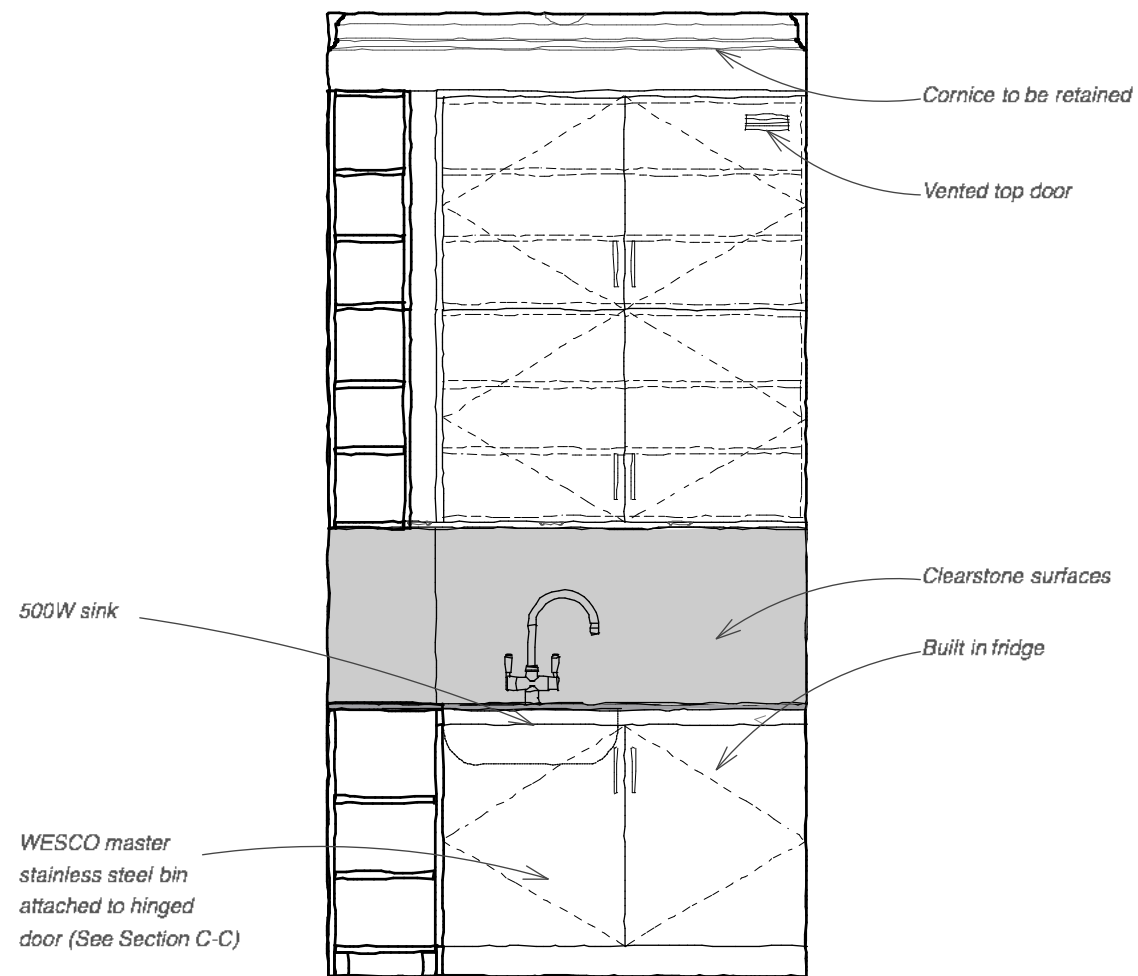


SECTION A-A

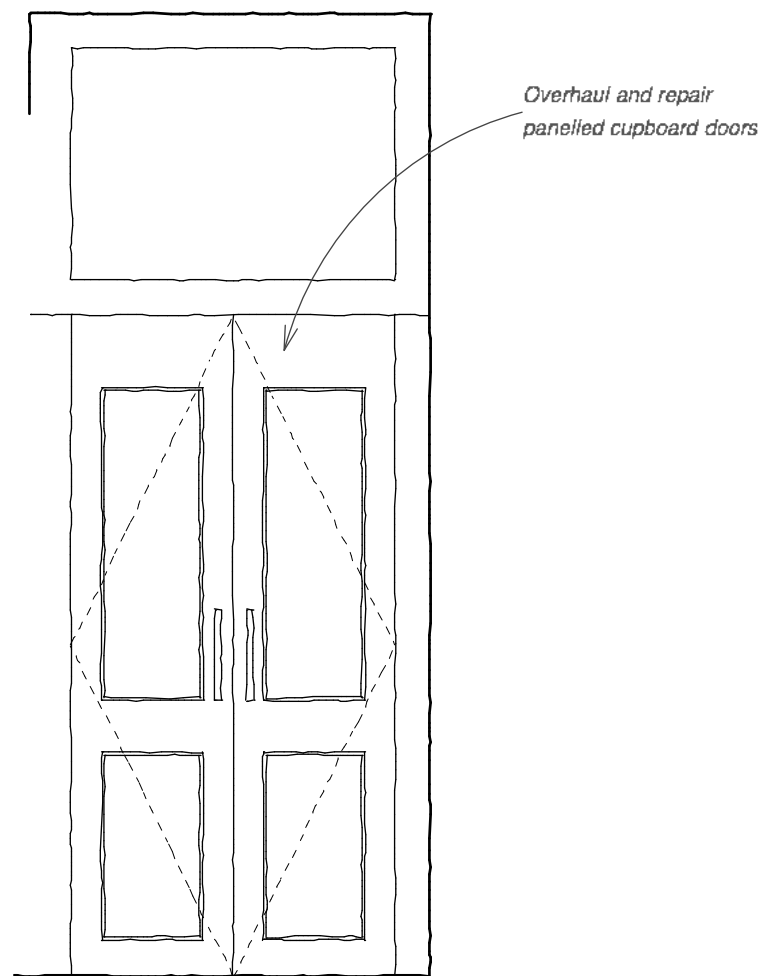

SECTION B-B

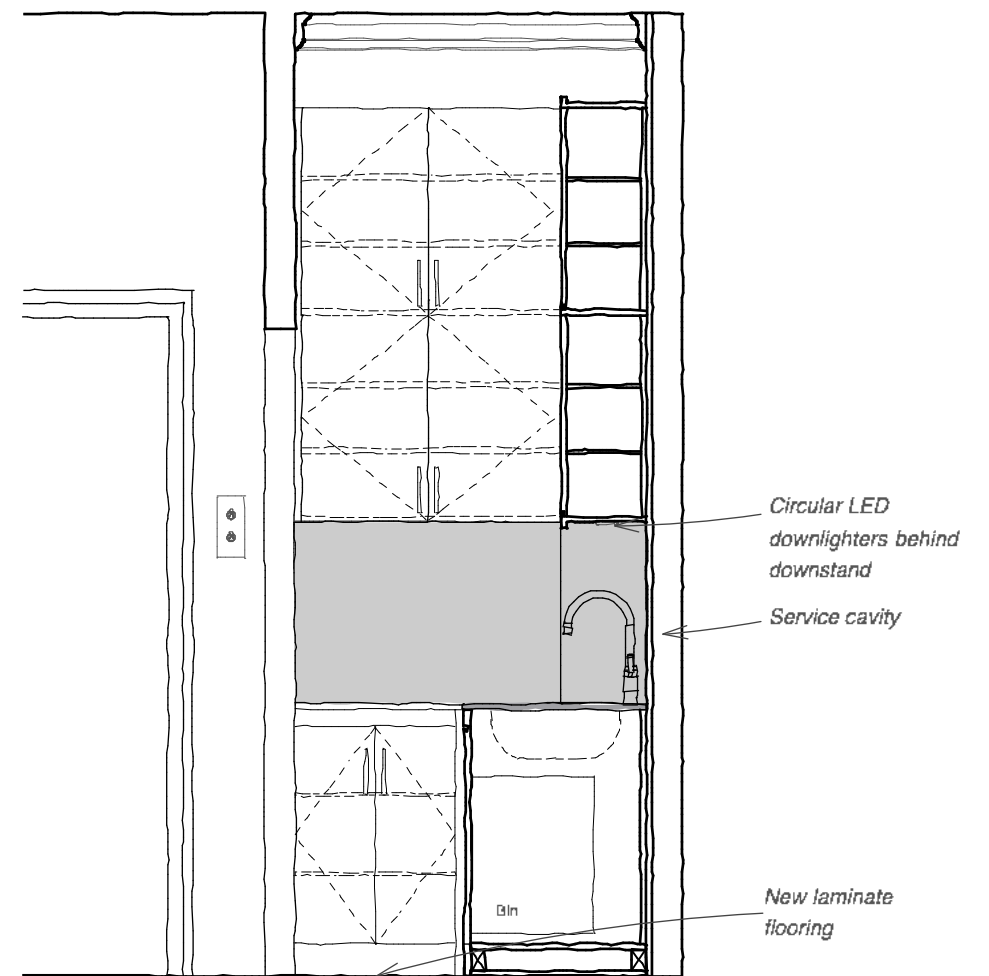

SECTION C-C

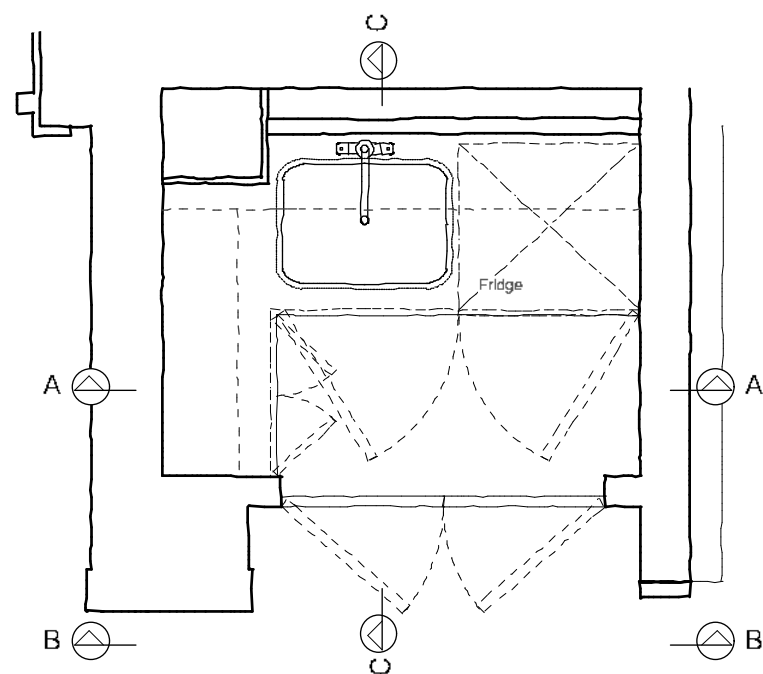

PROPOSED KITCHENETTE ROOM FR08


0 0.5m 2.5m
DO NOT SCALE. Check all dimensions on site.

1 : 25


See Drawing No. 0721019/Sk11 for new light fittings

For photographs as existing, please see 'Photographs of Existing Chambers'


3 New Square
Title: Proposed Kitchenette
Drawing No: 0721019/Sk18 Scale 1:25 @ A3
Butler Hegarty Architects
Unit 3.3, 159-163 Marlborough Road, London, N19 4NF
tel: 020 72638933 email: mail@butlerhegartyarchitects.co.uk

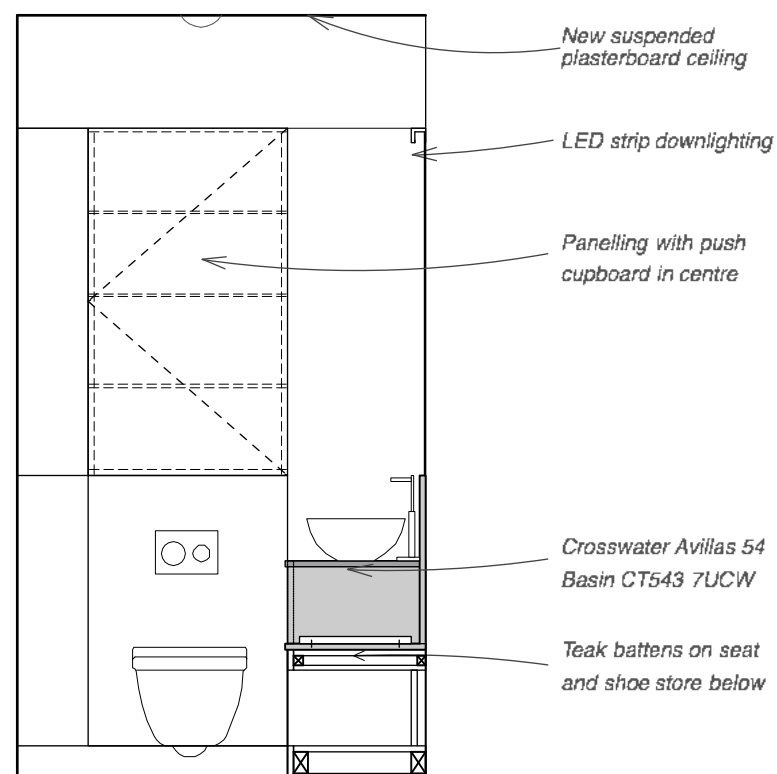


ELEVATION 1

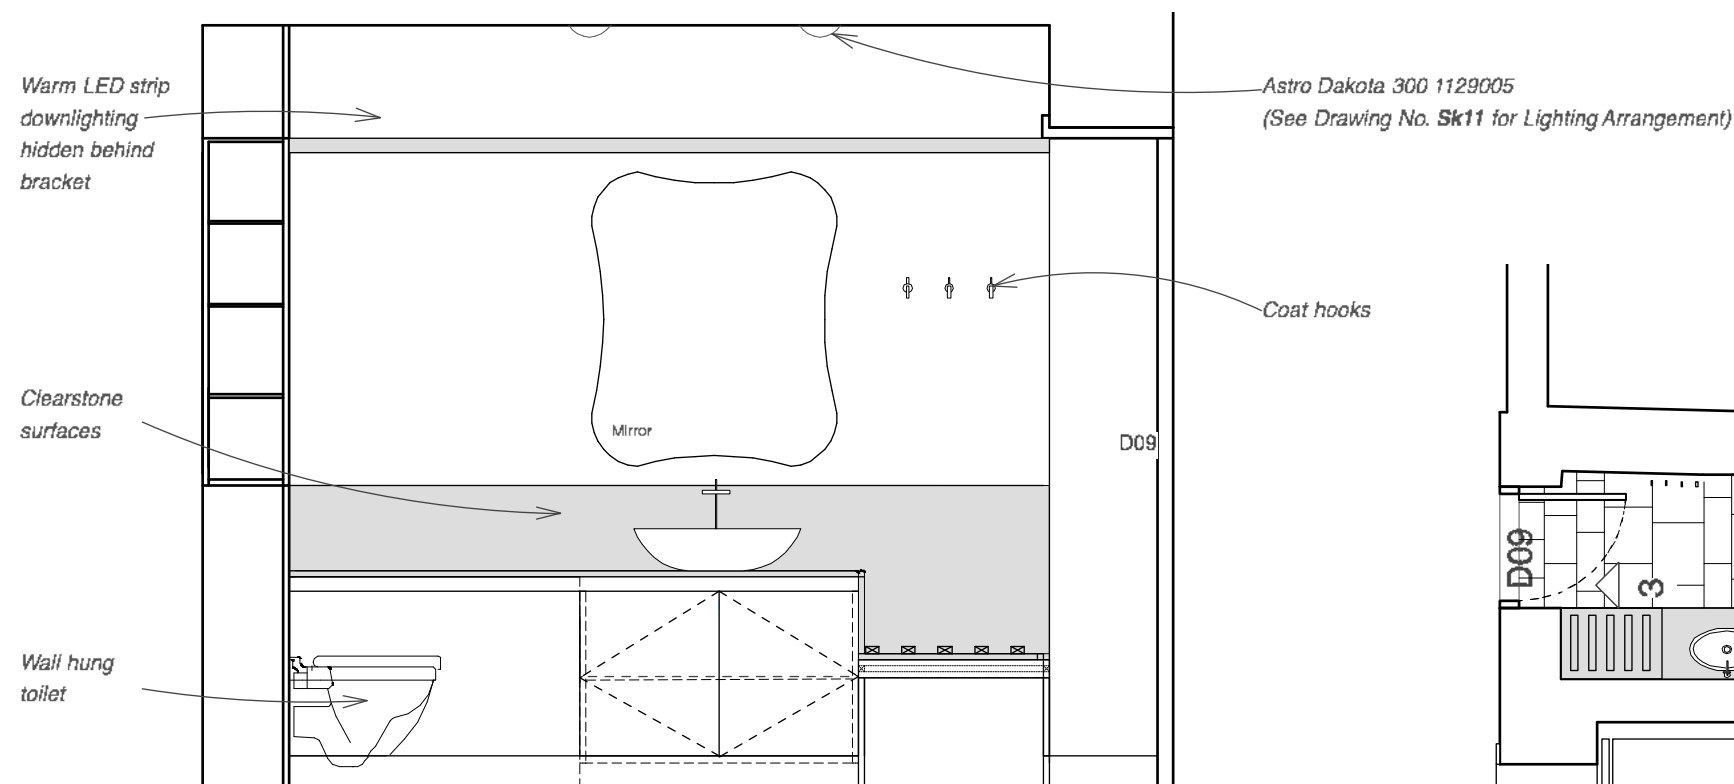


ELEVATION 2

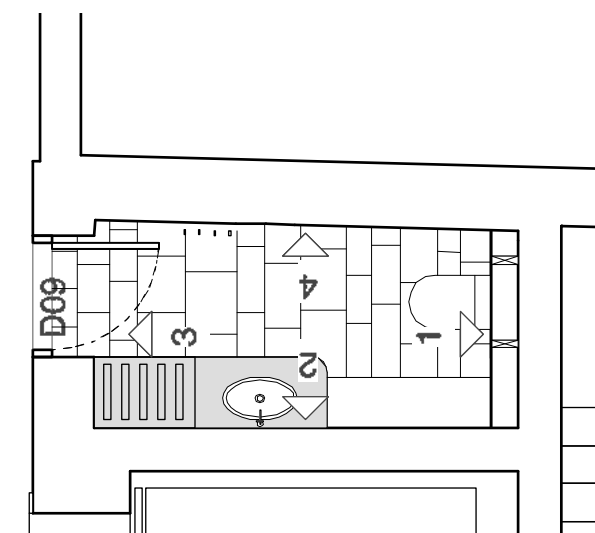

PLAN FR10 @ 1:50

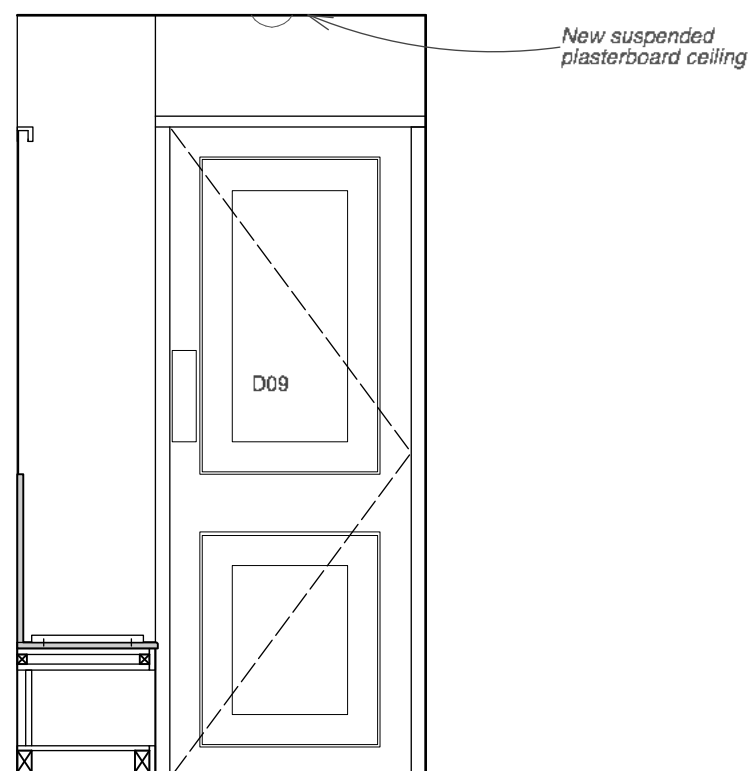

ELEVATION 3

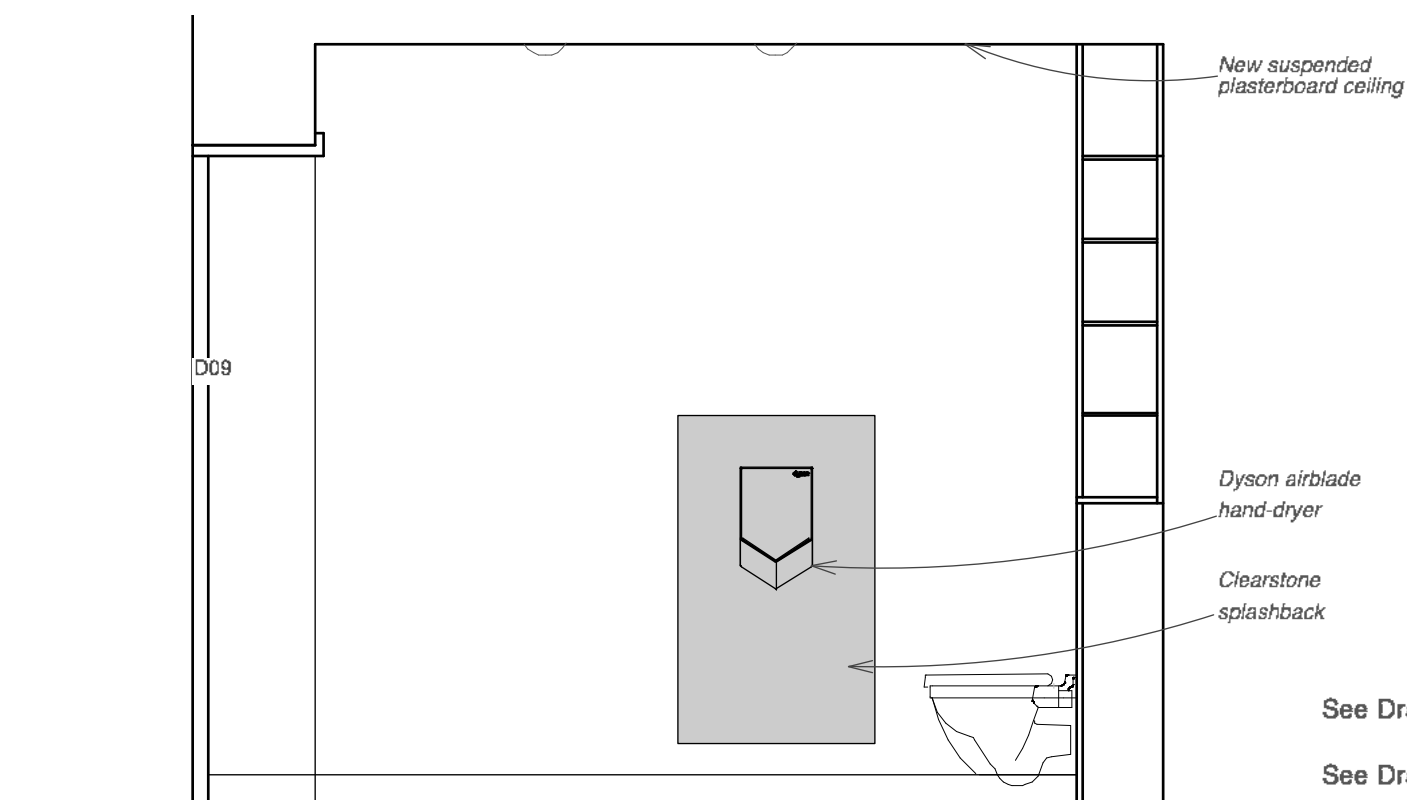

ELEVATION 4

See Drawing No. 0721019/Su25 for existing elevations

See Drawing No. 0721019/Sk11 for new light fittings


For photographs as existing, please see 'Photographs of Existing Chambers'

PROPOSED WC ELEVATIONS ROOM FR10


0 0.5m 2.5m
DO NOT SCALE. Check all dimensions on site.

1 : 25

3 New Square
Title: Proposed WC Elevations
Drawing No: 0721019/Sk17 Scale 1:25 @ A3
Butler Hegarty Architects
Unit 3.3, 159-163 Marlborough Road, London, N19 4NF
tel: 020 72638933 email: mail@butlerhegartyarchitects.co.uk

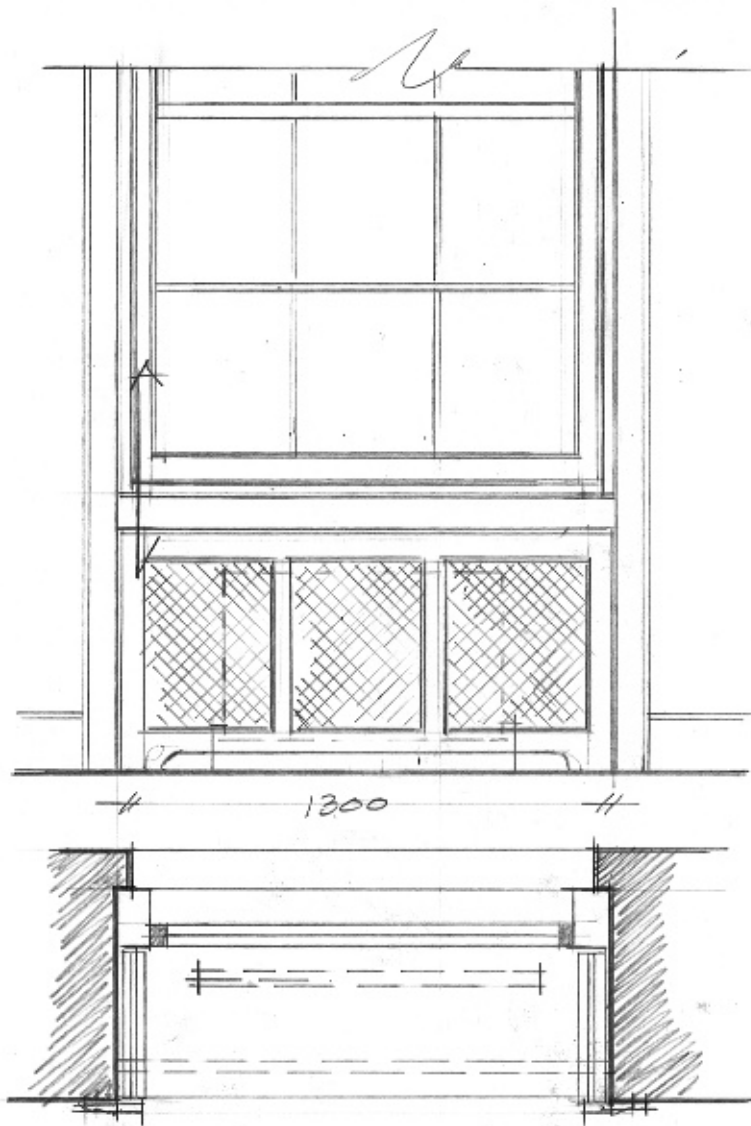

PLAN & ELEVATION

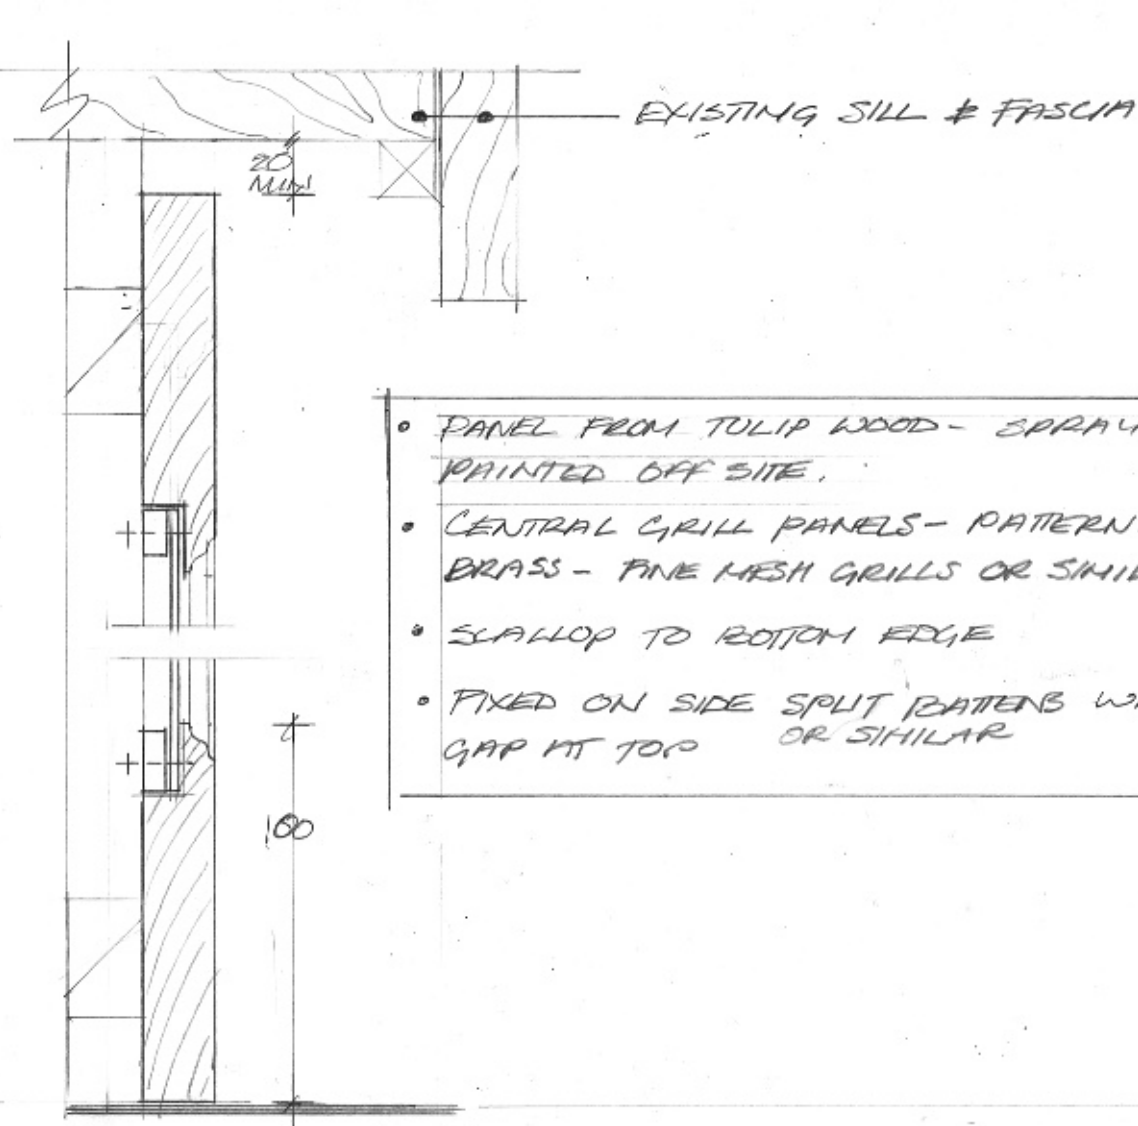

SECTION A 1:20 @ A4

- PANEL FROM TULIP WOOD - SPRAY PAINTED OFF SITE.
- CENTRAL GRILL PANELS - PATTERN - OXLEY BRASS - FINE MESH GRILLS OR SIMILAR
- SCALLOP TO BOTTOM EDGE
- FIXED ON SIDE SPLIT PATENS WITH AIR GAP AT TOP OR SIMILAR

Nicola LOVELL
INTERIOR DESIGN CONSULTANT

PROJECT THREE NEW SQUARE
RADIATOR GRILLS

DRAWING DETAILS SCALE 1:20 @ A4

Do not scale from drawings. All dimensions to be checked on site.