
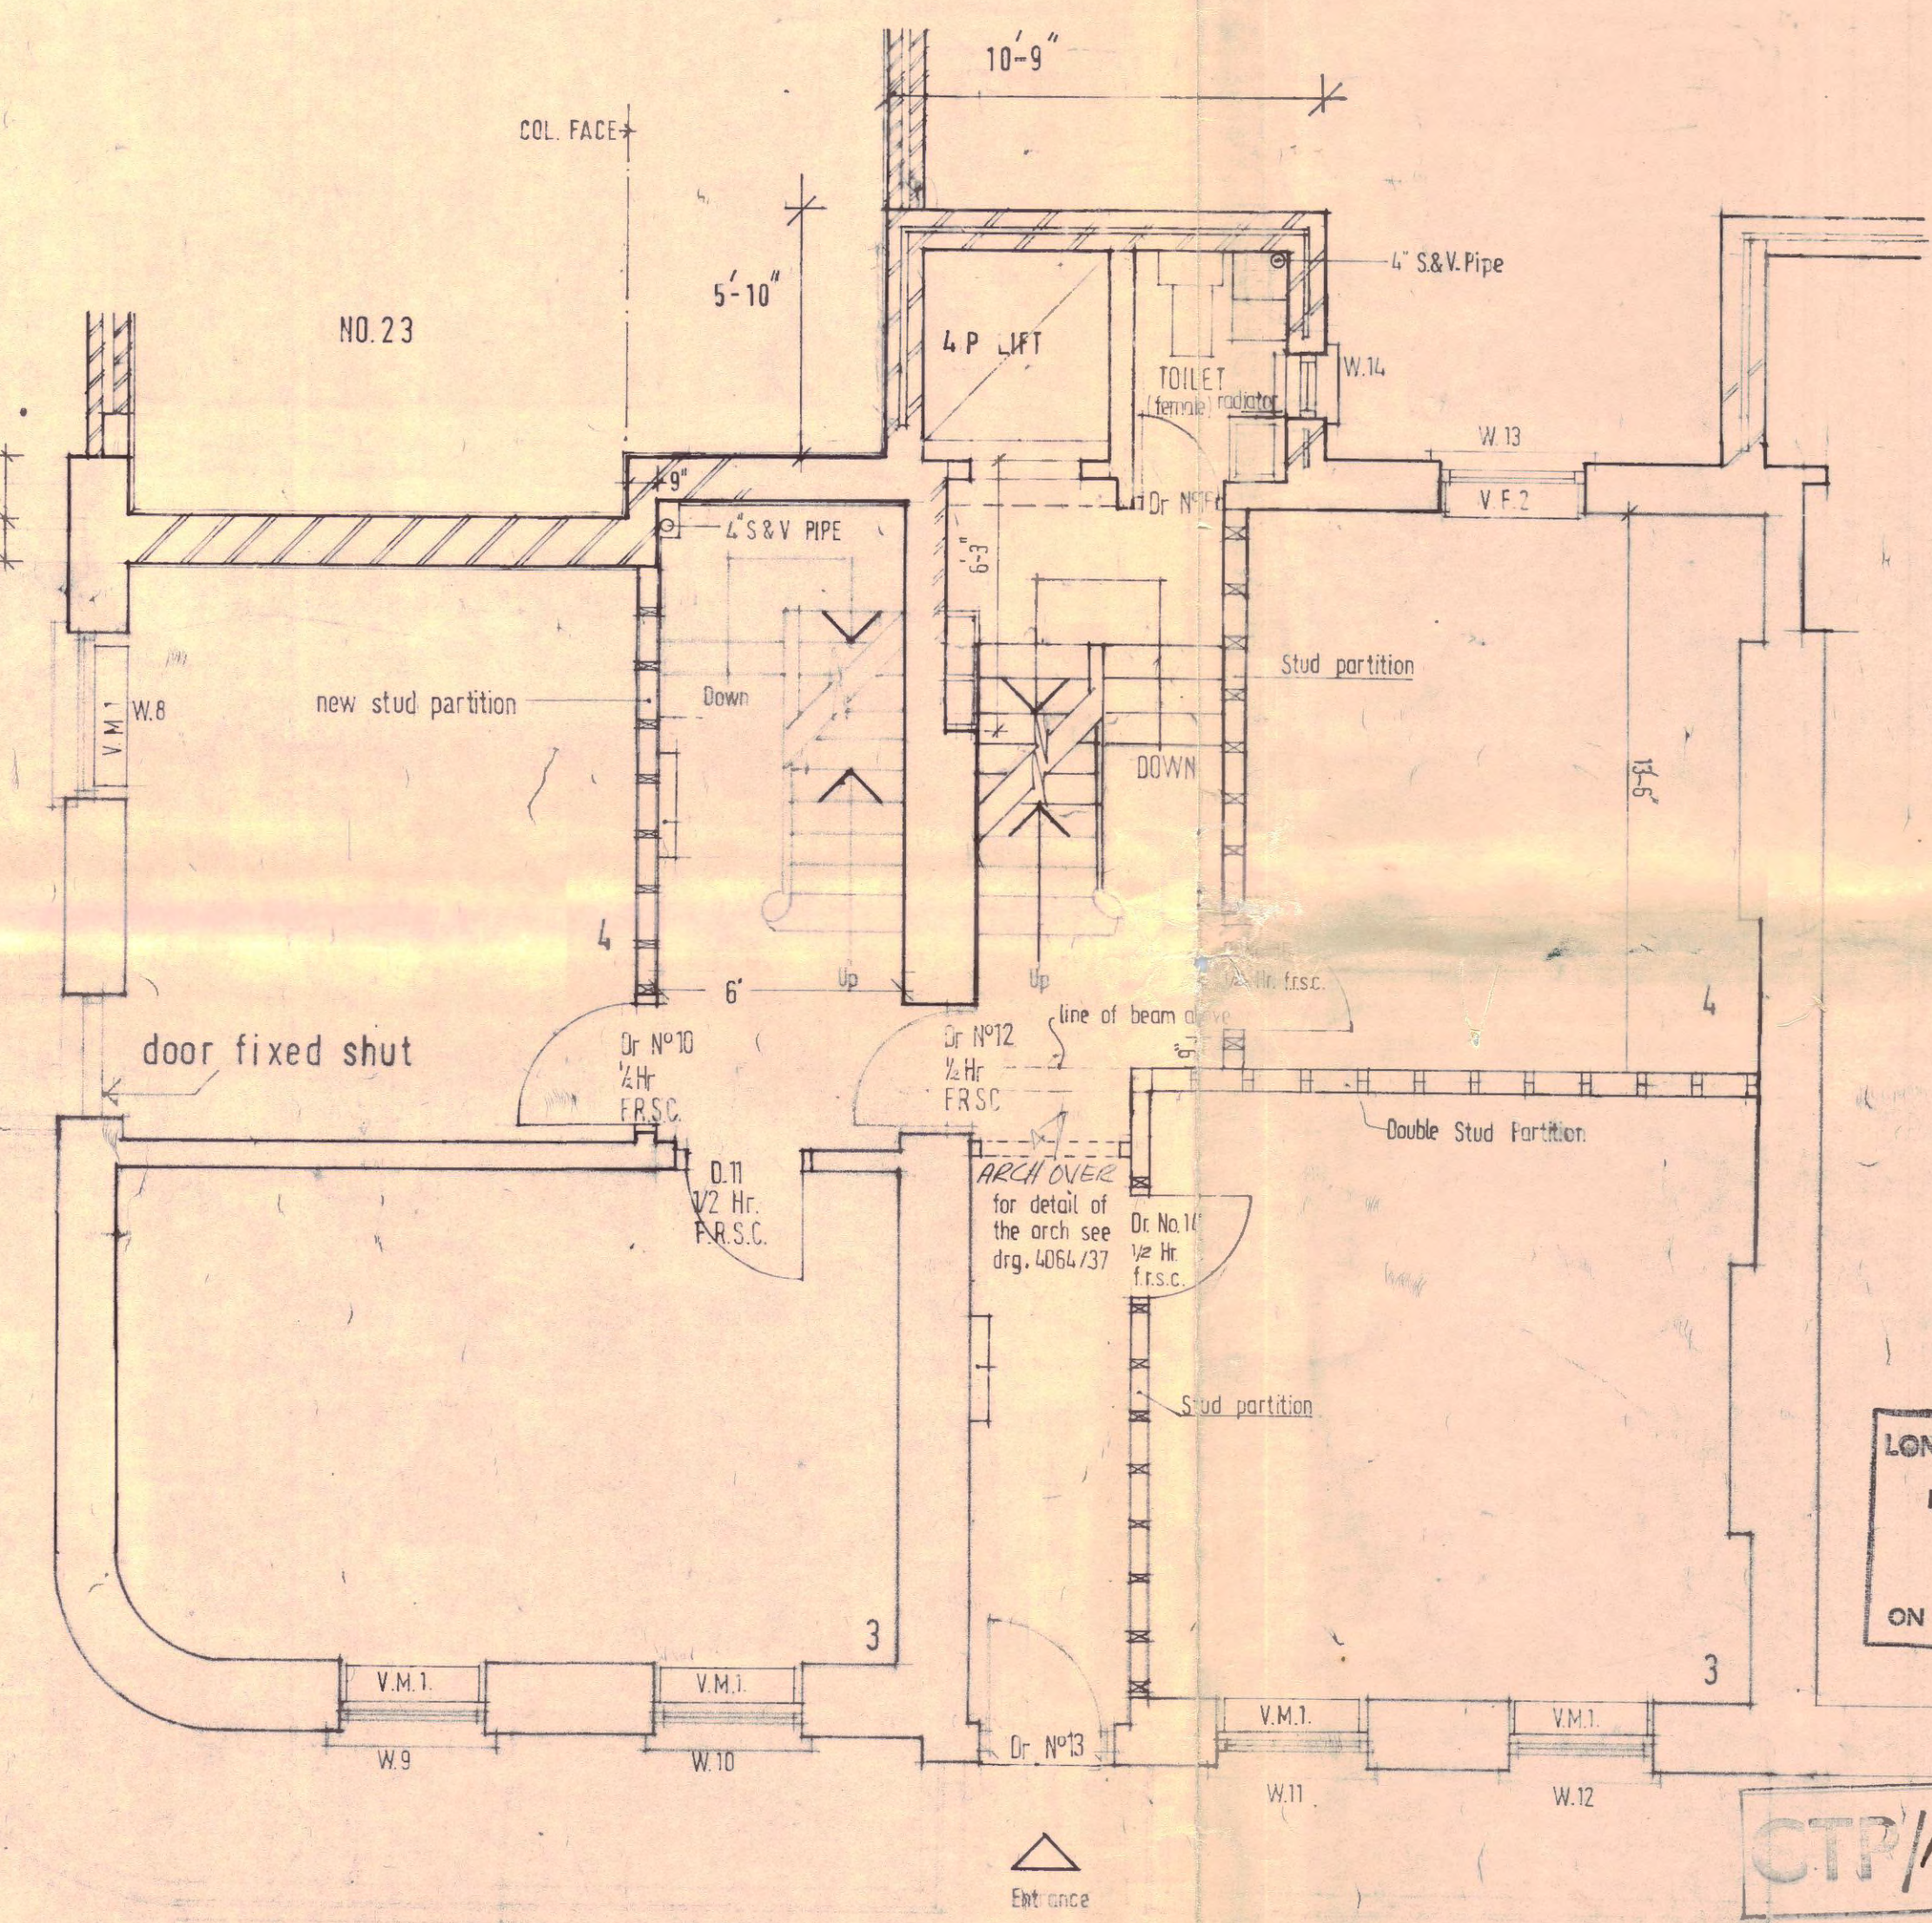


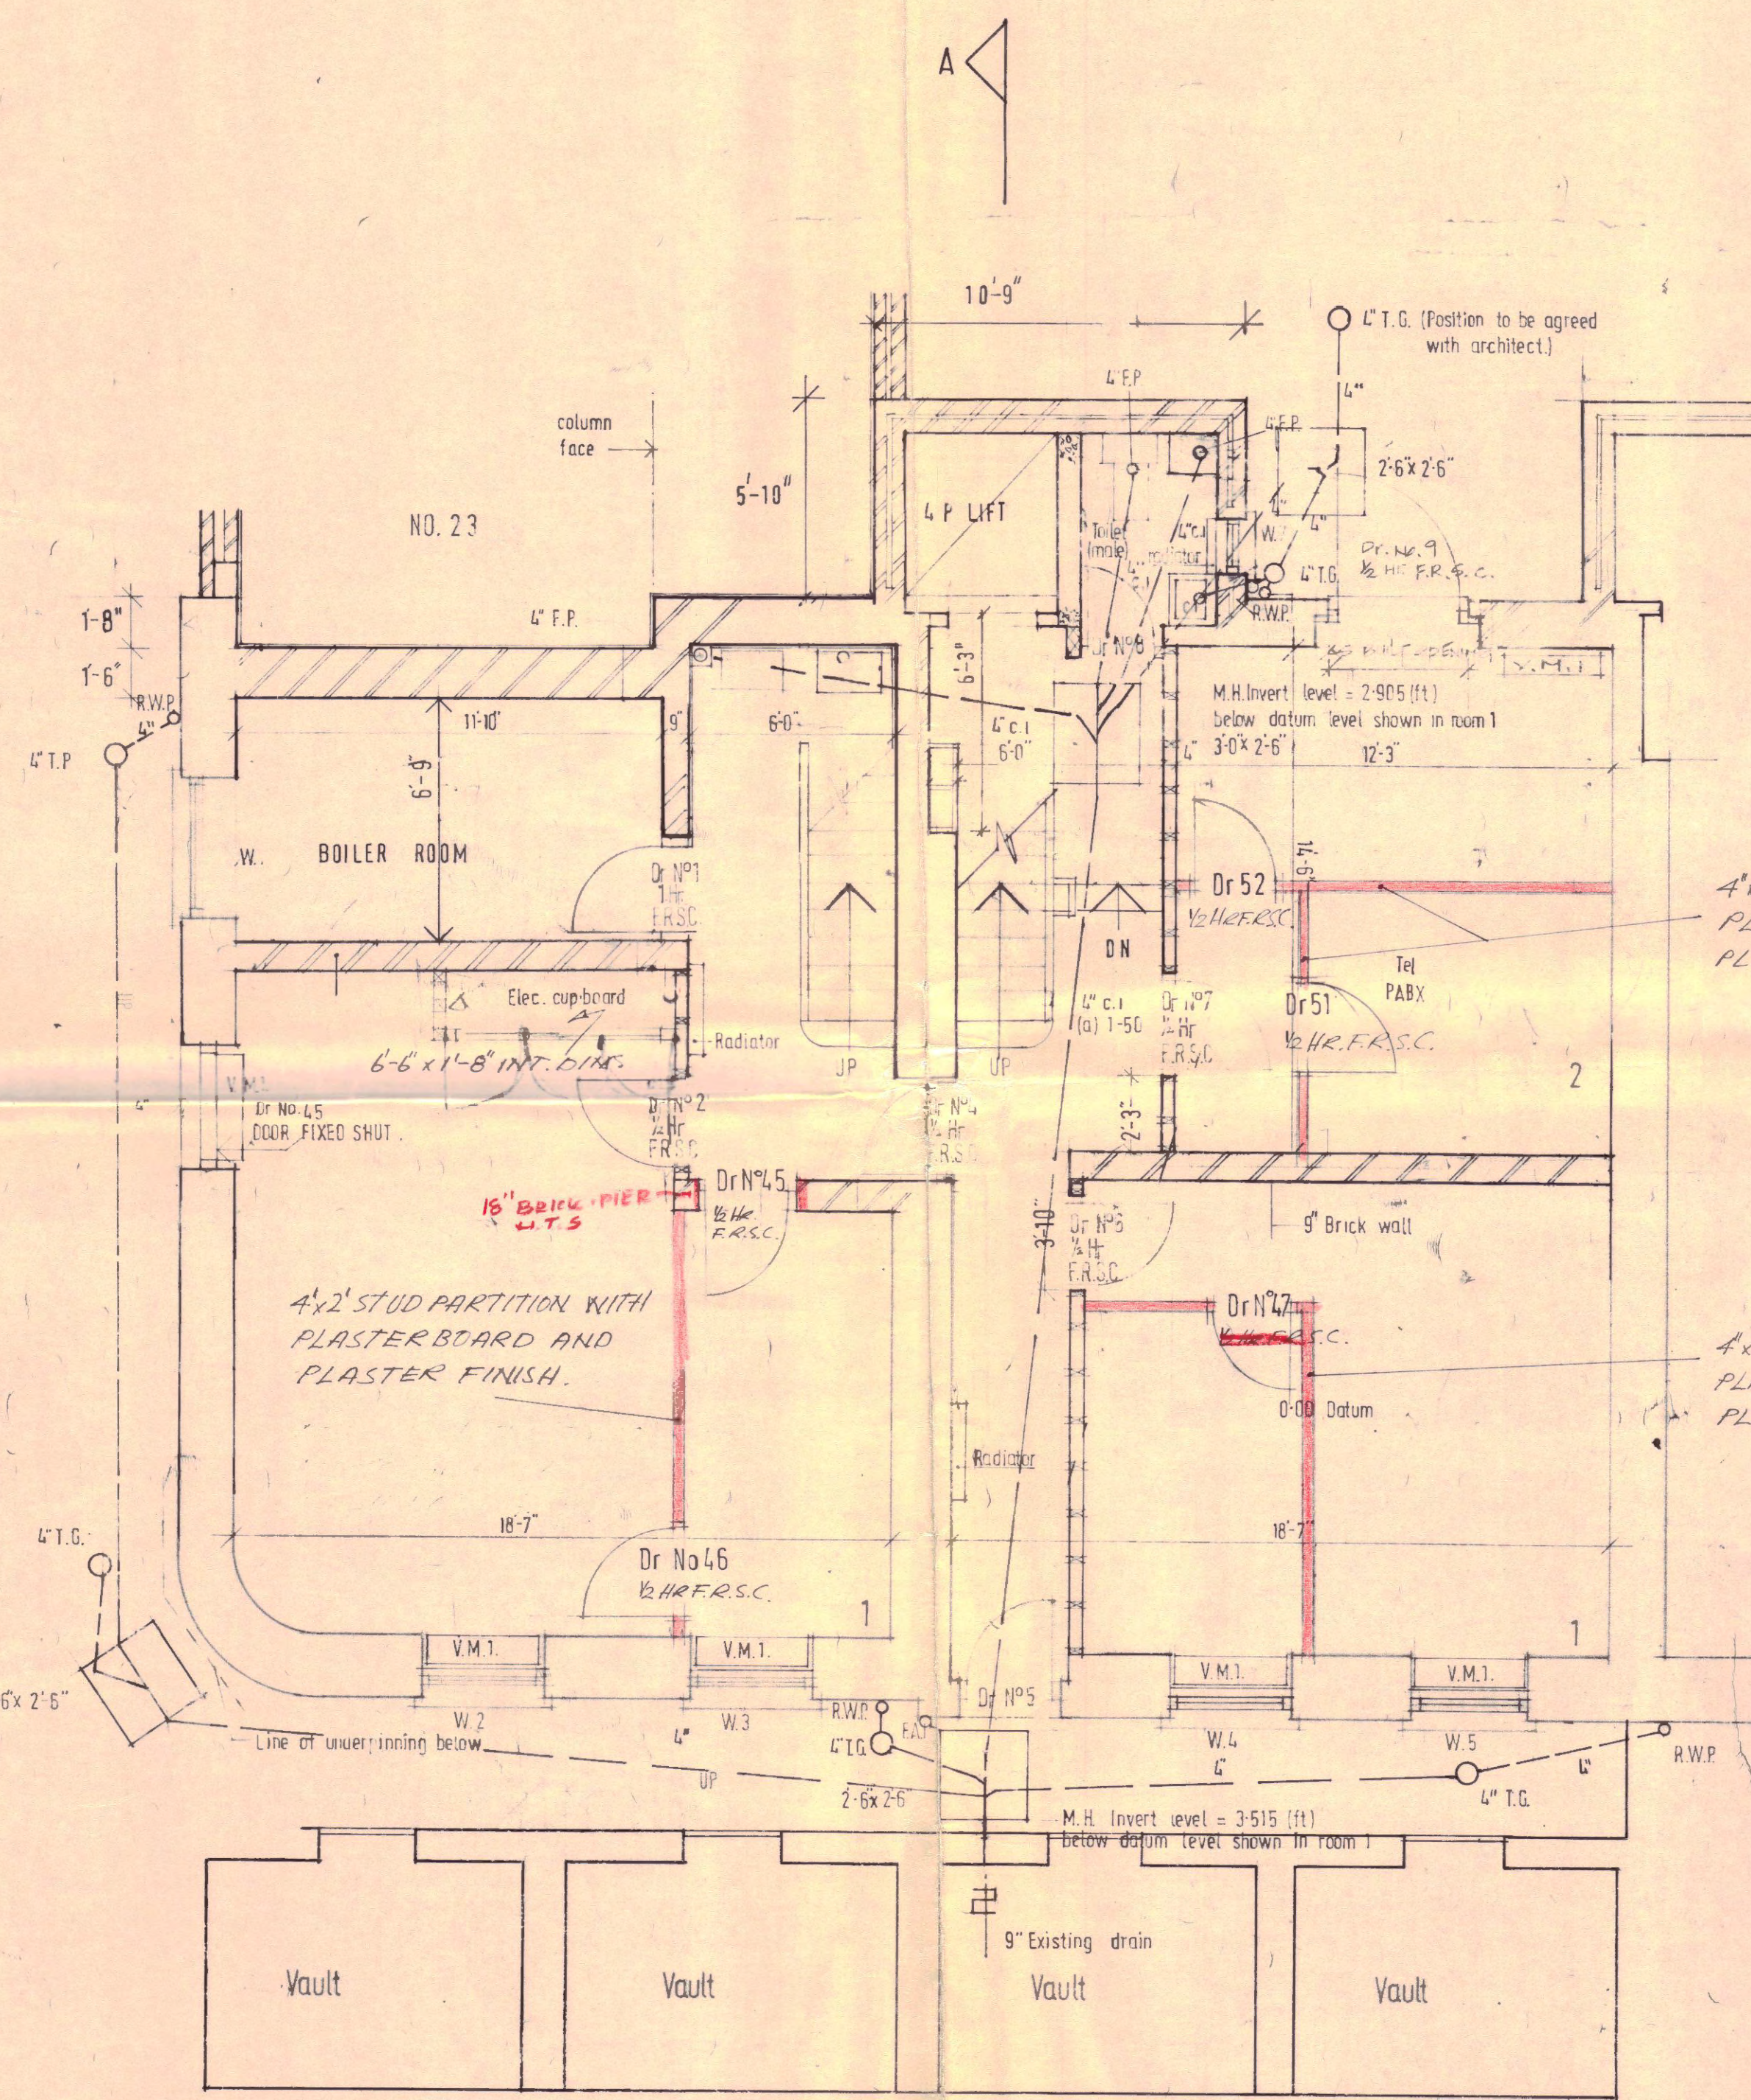

LONDON BOROUGH OF CAMDEN
PLANS APPROVED
14 OCT 1975
ON BEHALF OF THE COUNCIL

CTP/N14/29 E/20301
1/11/75 1061

Ground Floor Plans

LEGEND
1/2 Hr. F.R.S.C. - 1/2 Hour Fire Resisting Self Closing Door.
ALL WALLS EXISTING UNLESS OTHERWISE INDICATED.

Door No. 3 omitted. Sink added in basement of No. 46.	R.P.	23-10-74
Male and female toilets indicated. Duct in party wall amended.	R.P.	9-10-74
Mimhole adjacent to door No. 5 amended.	R.P.	2-10-74
Party wall between No. 23 revised	K.C.	19-9-74
Drainage layout revised	R.P.	11-9-74
Soil & Vent pipe positioned in rear wall	R.P.	10-9-74
Drainage layout indicated	R.P.	4-9-74
Soil & Vent pipe indicated	R.P.	30-8-74
Duct added	R.P.	20-8-74
Extra dimensions added. Air conditioning units indicated. Dimensions revised.	R.P.	19-7-74
Stud partitions dimensioned	R.P.	27-6-74
Toilet layout revised	R.P.	31-5-74
Lift, toilet & staircase amended.	R.P.	25-4-74
REVISION	BY	DATE

P NEW STUD PARTITIONS ADDED TO BASEMENT
O Positions of door 14 & 15 revised. Arch detail redrawn on drg. 4064/37
N Partition between offices 3 & 4 to be double stud partition 20-1-75
N Electrical cupboard arch to grd. flr. indicated 6-1-74
M V.M.I. H.R.M. & RELOCATED
DIMENSIONS ADDED TO BASEMENT PLAN 18-2-74
M Dr. No. 3 RELOCATED & REVISED
WINDOW W. 6 OMITTED 11-2-74

contract title	drawing title	scale	date
46-47 Bloomsbury Square	Basement and Ground Floor Plans	1/4" = 1'-0"	JAN 74
TP Bennett & Son Chartered Architects 246 High Holborn WC1V 7DU Telephone 01 405 9277	contract number	drawing number	revision
4064	2		P