


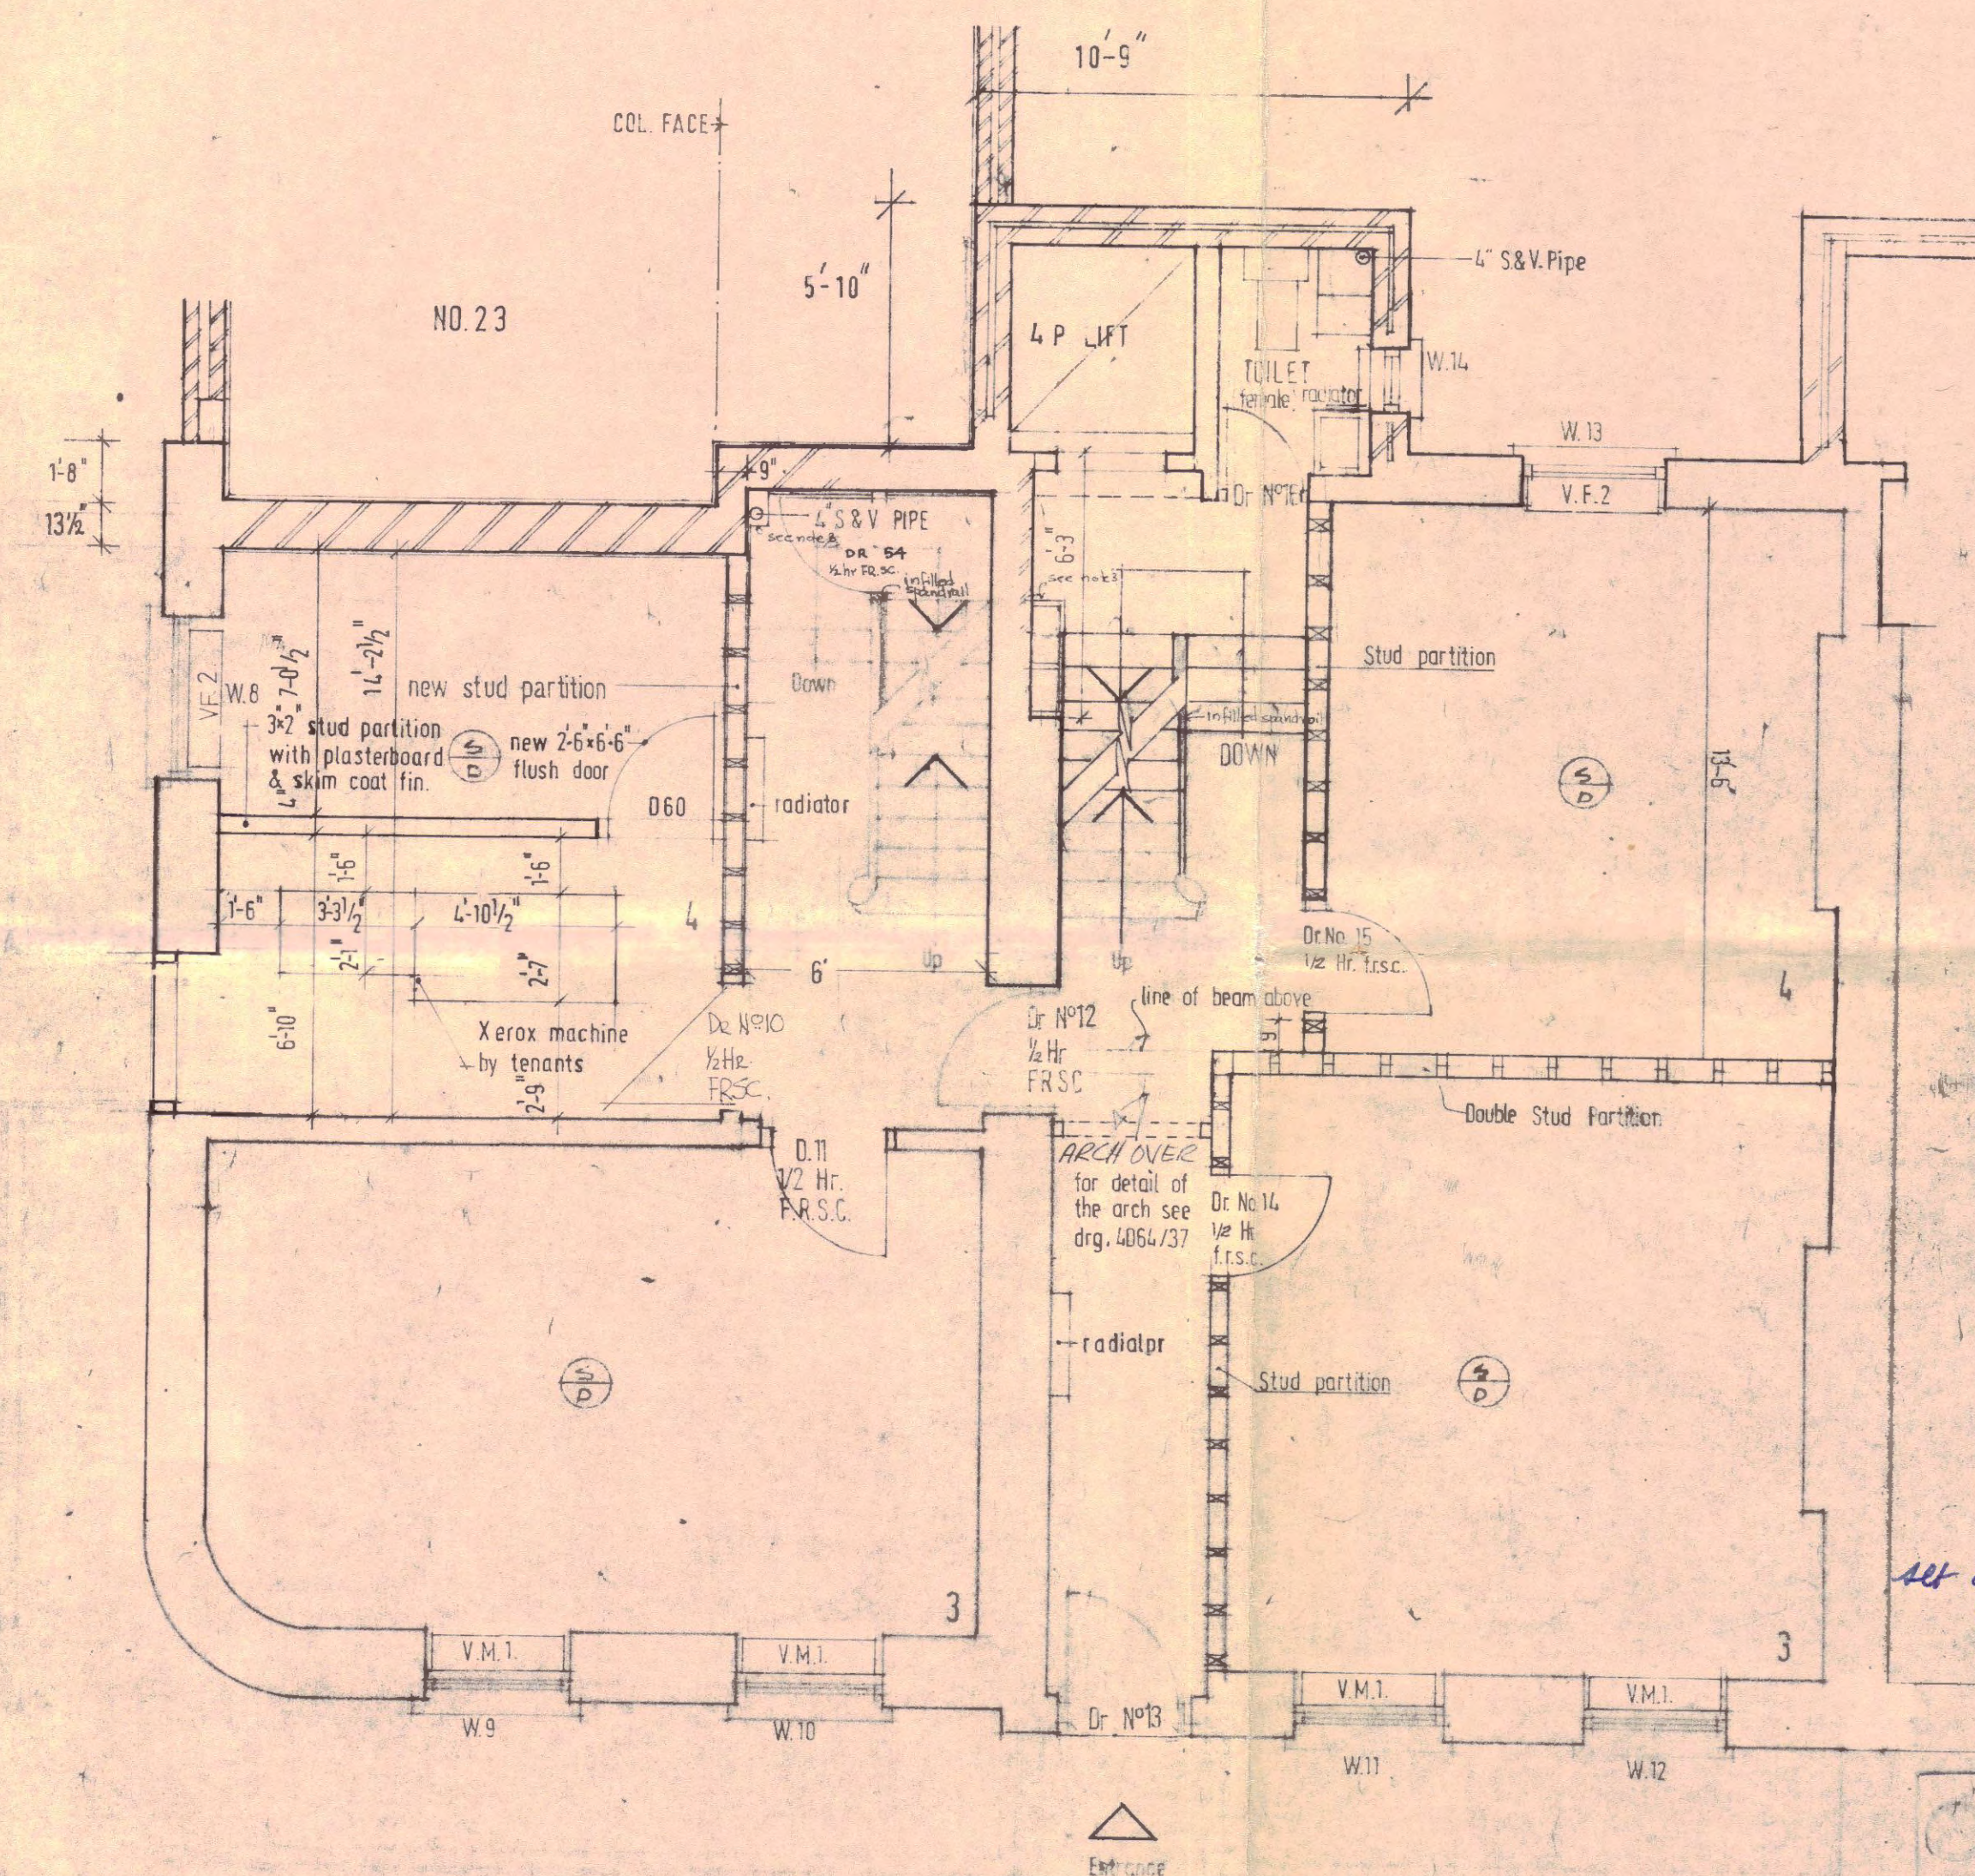

LONDON BOROUGH OF CAMDEN
TOWN AND COUNTRY PLANNING ACT
28 OCT 1975
PLANS APPROVED
ON BEHALF OF THE COUNCIL

CT / N14 / 23 / E / HB1143

Ground Floor Plans

	Door No.3 omitted, Sink added in basement of No.46.	R.P.	23-10
L	Male and female toilets indicated. Duct in party wall amended. Manhole adjacent to door No.5 amended	R.P.	9-10-74
		R.P.	2-10-74
J	Party wall between HQ 23 revised	K.C.	19-9-74
H	Drainage layout revised. Soil & Vent pipe positioned in rear wall.	R.P.	11-9-74
	Drainage layout indicated.	R.P.	16-5-74
G	Soil & Vent pipe indicated.	R.P.	4-9-74
F	Duct added	R.P.	30-8-74
E	Extra dimensions added. Air conditioning units indicated. Dimensions revised.	R.P.	20-6-74
D	Stud partitions dimensioned.	R.P.	13-7-74
C	Toilet layout revised.	R.P.	27-6-74
B	Life toilet & staircase amended.	R.P.	31-5-74
675		R.P.	26-4-74

S	new partition & door D60 added in RM 4, no 46	K.C.	5-67
	Smoke detector indicated.		
	Door Nos. 57 & 58 added on ground floor Note added.	R.P.	12-3-74
R	Access corridor in Southampton Place.		
	Q Stud partition in room 2 on basement repositioned.	R.P.	27-2-74
P	NEW STUD PARTITIONS ADDED TO BASEMENT		
O	Positions of door 12 & 15 revised. Arch detail redrawn on dry 12-3-75		
	Partition between offices 3 & 6 to be double stud partition 20-1-75		
N	Electrical cupboard arch to grd. flr. indicated	5-1-74	R.P.
	V.M.F.I.H.R.M. 2x RELOCATED		K.C.
	DIMENSIONS ADDED TO EXISTING FLOOR	12-2-74	R.P.
M	DR NO. 1 RELOCATED & VISBY + WINDOW WQ IMPROVED	11-2-74	K.C.

REVISION	contract title	drawing title	BY	DATE
3-75	46-47 Bloomsbury Square	Basement and Ground Floor Plans	JAN 75	SCALE
2-75				DATE
P.C.	T P Bennett & Son Chartered Architects 246 High Holborn WC1V 7DU Telephone 01 405 9277	contract	drawing number	REVISION
P.		4064	2	
P.				
C.				S

LEGEND

- 1 1/2 Hr.F.R.S.C. - 1/2 Hour Fire Resisting Self Closing Door.
ALL WALLS EXISTING UNLESS OTHERWISE INDICATED.
- 2 12"x6" CLEAR GEORGIAN WIRE GLASS (5mm) VISION PANEL TO BE FORMED
ON DOOR Nos.46,47,48,50.
- 3 ALL SERVICE DUCTS IN STAIRCASE WELL MUST BE OF
1/2 HOUR FIRE RESISTANT CONSTRUCTION AND WITHOUT OPENING.
- 4 SECONDARY LIGHTING WILL BE INSTALLED IN ALL INTERNAL STAIRCASE WELLS.

⑤ SMOKE DETECTORS