






 

 
 

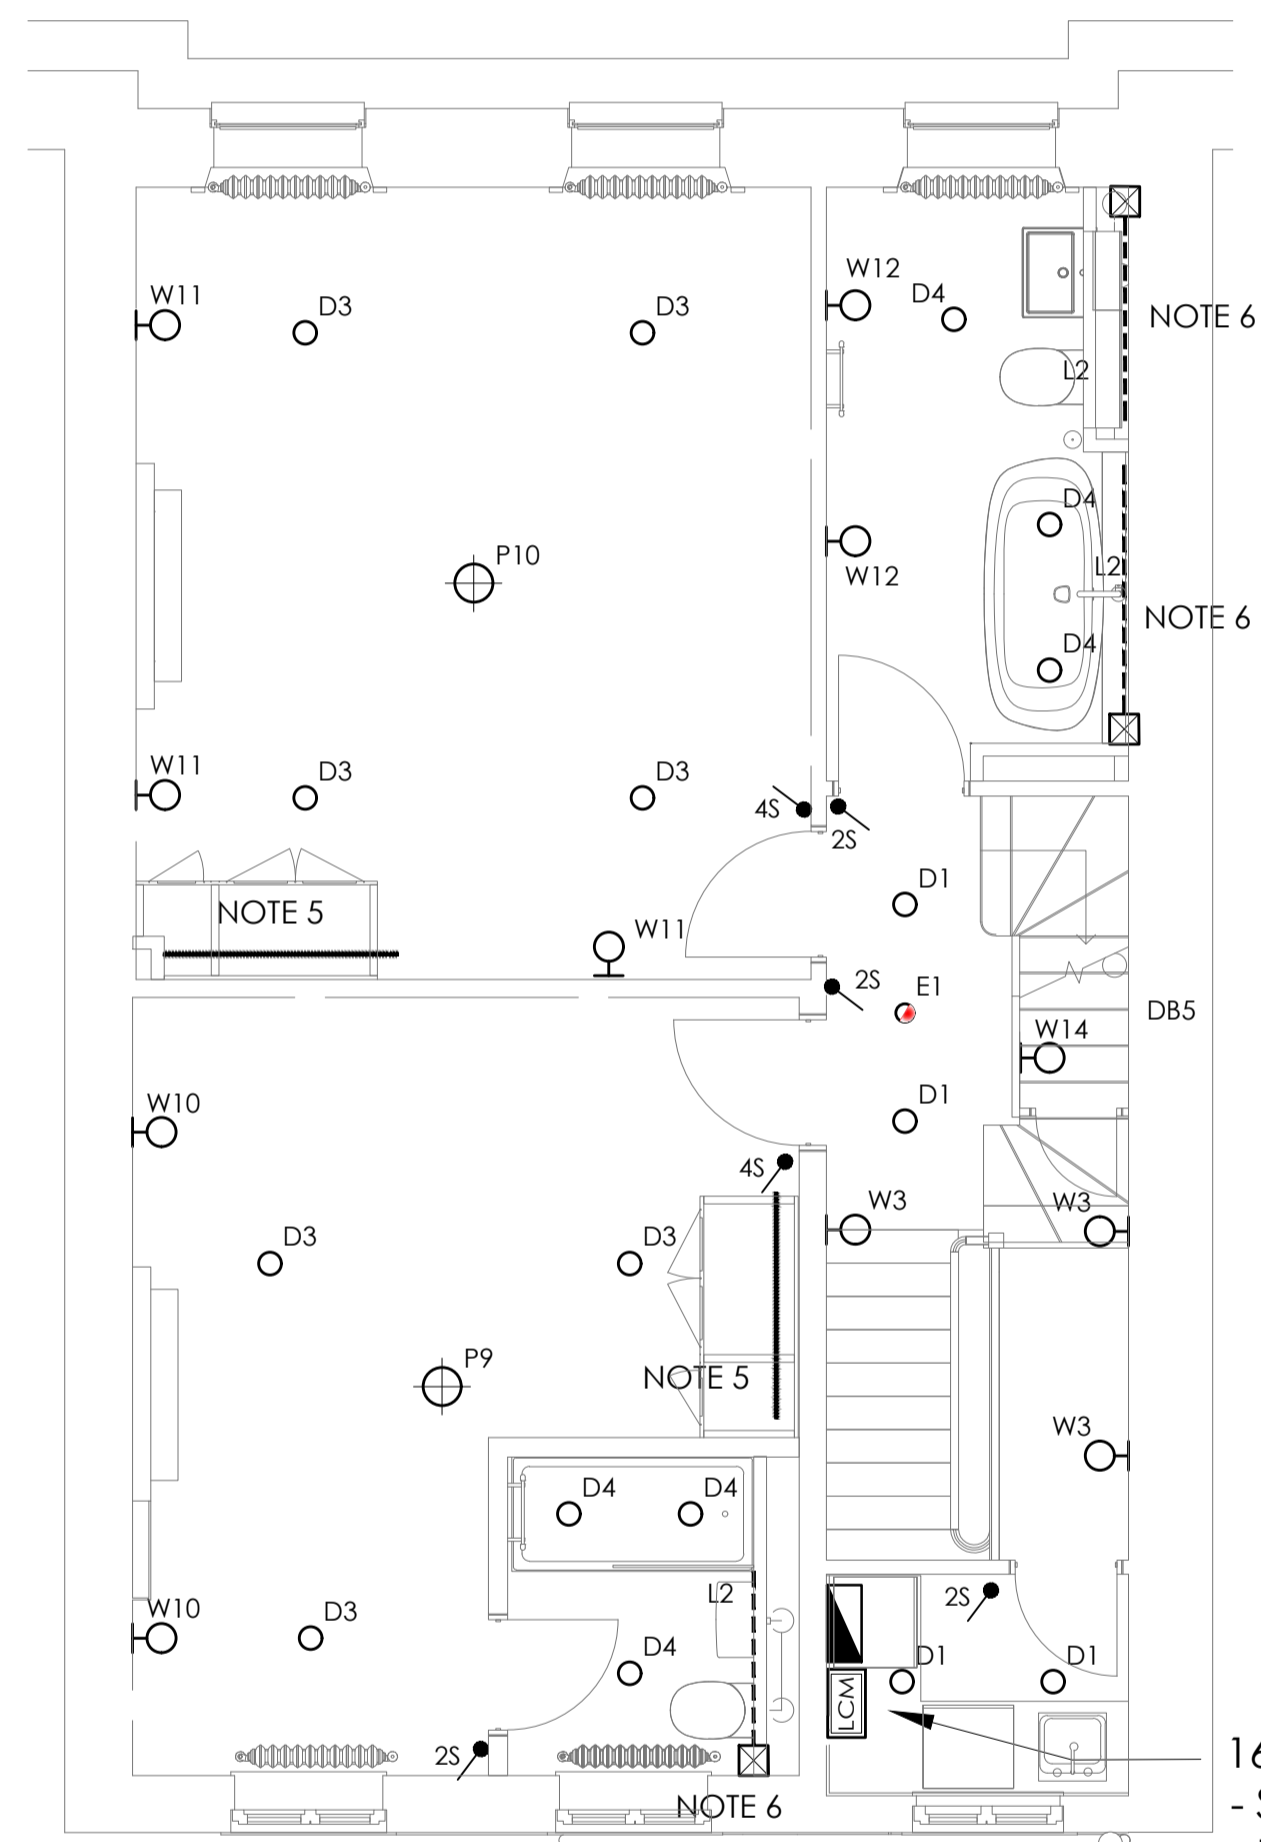


Notes

1. Drawing to be read in conjunction with all relevant consultants drawings and specifications.
2. Any dimensions detailed in this drawing are to be in millimeters.
3. Do not scale from this drawing.
4. This drawing is protected by copyright
5. Wardrobe lighting shall be supplied and installed by joinery contractor. - Allow for the power supply via a fused connection unit fed from the local lighting circuit
6. The electrical contractor to supply and install LED tape to shelving and under cabinet joinery. Tape to be concealed in a aluminum profile with opal cover, fixed securely by clips. Refer to the Architects joinery drawings for details and quantities.


Legend

-  Distribution Board
-  Lighting Control Panel
-  DALI/Mains phase dimmer unit  
Osram HII DALI 315 Dim or equivalent
-  Conventional wall light switch
-  Lutron 4 button scene plate  
Palladium range with satin brass finish
-  Lutron 4 button PICO Wireless scene plate with black insert & satin brass face plate
-  Lutron 4 button PICO Wireless scene plate in white finish
-  5A Lighting socket
-  W1-6 Wall Mounted Light fitting
-  D1-5 Downlighters
-  P1-11 Pendant Light Fittings
-  Track Light  
L1



16 WAY TP&N DISTRIBUTION BOARD  
 - SPLIT METERED /LIGHTING / POWER  
 - RESIDENTIAL FLOORS 1/2/3/4  
 - REF: DB5

+ LIGHTING CONTROL PANEL

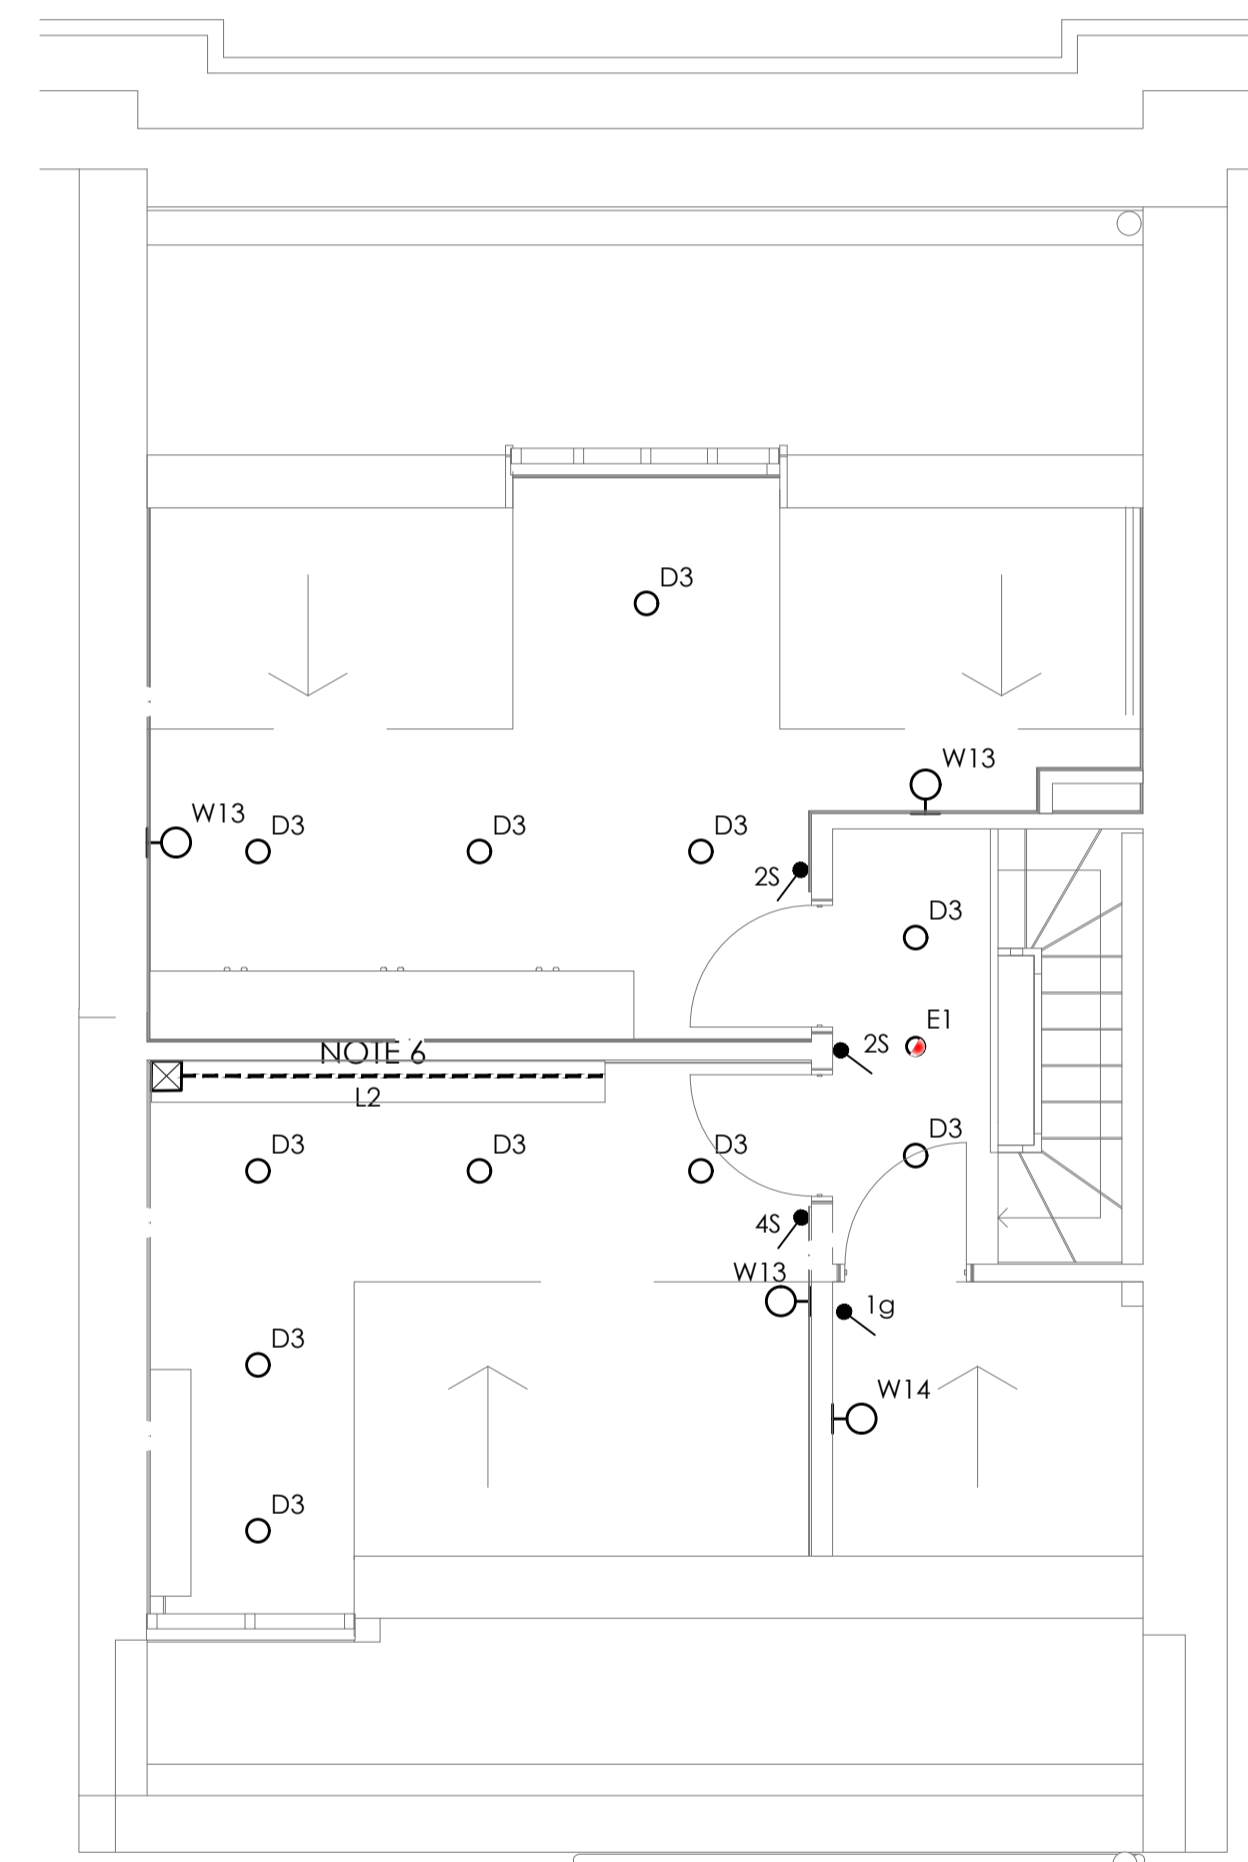

C	27-08-20	PLANNING ISSUE	LB	LB
B	25-08-20	PLANNING ISSUE	LB	LB
T1	21-08-20	TENDER ISSUE	LB	LB
A	24-07-20	ISSUED FOR INFORMATION	LB	LB
Rev	Date	Description	Drwn	Chkd

The Anslow Partnership  
 Consulting Engineers



1st Floor  
 John Stow House  
 18 Bevis Marks  
 London, EC3A 7JB  
 Telephone: (020) 7553 2050  
 email: initialsurname@anslowconsulting.co.uk

Project	14 ENDSLEIGH STREET
Client	
Architect	

Title  
 ELECTRICAL SERVICES  
 THIRD AND FOURTH FLOOR  
 PROPOSED LIGHTING LAYOUT

Drawn	Checked	Verified
JT	LB	DA
Issue	Date	Scale
PLANNING	JULY 2020	1:50
Drawing Number	Revision	
220039/E/2102	C	

