




Remove modern partition and make good where appropriate.

DISCLAIMER NOTES:

- THIS DOCUMENT IS COPYRIGHT OF THE ORIGINATOR AND MUST BE TREATED AS CONFIDENTIAL. IT MUST NOT BE ALTERED, REPRODUCED OR DISTRIBUTED WITHOUT PRIOR WRITTEN CONSENT OF THE ORIGINATOR.
- THIS DOCUMENT MUST NOT BE ALTERED. THE ORIGINATOR ACCEPTS NO RESPONSIBILITY FOR ANY DISCREPANCIES ARISING AS A RESULT OF THE ORIGINATOR'S INFORMATION.
- ANY DISCREPANCY MUST BE REPORTED TO THE ORIGINATOR.
- DO NOT SCALE THIS DOCUMENT - USE DIMENSIONS ONLY.
- ALL DIMENSIONS MUST BE CHECKED ON SITE PRIOR TO COMMENCEMENT OF ANY RELATED WORK.
- THIS DOCUMENT MUST BE READ IN CONJUNCTION WITH ALL SUPPORTING DOCUMENTS PRODUCED BY THE ORIGINATOR AND OTHER PROJECT DISCIPLINES.
- THE ORIGINATOR ACCEPTS NO RESPONSIBILITY FOR THE ACCURACY OF BACKGROUND INFORMATION PROVIDED BY THIRD PARTIES. THIS MUST BE TREATED AS INDICATIVE ONLY.
- USERS OF THIS DOCUMENT ARE RESPONSIBLE FOR CHECKING WHICH REVISIONS CONCERN THEIR STATUS INFORMATION OR REGULATORY AND POLICE THAT THE DRAWINGS FOR REFERENCE PURPOSES ONLY. THE ORIGINATOR WILL ACCEPT NO RESPONSIBILITY FOR THE COMPLETENESS OF INFORMATION UNDER THIS STATUS.
- THE DOCUMENT STATUS 'RECORD' OR 'AS BUILT' HAS BEEN REMOVED. IN PART BASED ON THE ORIGINATOR'S ASSUMES NO RESPONSIBILITY FOR THE ACCURACY OF THIS 'RECORD' OR 'AS BUILT' DOCUMENT FOR ANY ERRORS OR OMISSIONS THAT MAY HAVE BEEN INCORPORATED INTO IT AS A RESULT OF INCOMPLETE INFORMATION PROVIDED TO THE ORIGINATOR.
- ADVISORY TO OBTAIN INDEPENDENT VERIFICATION OF ITS ACCURACY.

DRAWING NOTES:

COM REGULATIONS 2015
 SIGNIFICANT FROM DIMENSIONS RISES AND FALLS WHICH ARE CRITICAL TO THE WORK. THESE ARE SHOWN WITH DIMENSION LINES AND DIMENSIONS TO THE RIGHT WITH BRIEF ACCOMPANYING TEXT FOR FURTHER DETAILS OF THE RISKS IDENTIFIED BY DESIGNERS. REFERENCE SHOULD BE MADE TO COM HAZARD REGISTER AND CONTAINMENT TO BE INSTALLED IN A NEXT AND TOP FASHION TO BE APPROACHED IN LINE WITH THE BUILDINGS HISTORICAL INTEREST AND WITH THE HERITAGE OFFICERS AGREEMENT PRIOR TO ANY WORK BEING CARRIED OUT. THESE ARE TO BE INSTALLED WITHIN CEILING VOIDS OR BUNGIES IN THE CORNER OF ROOMS ETC.

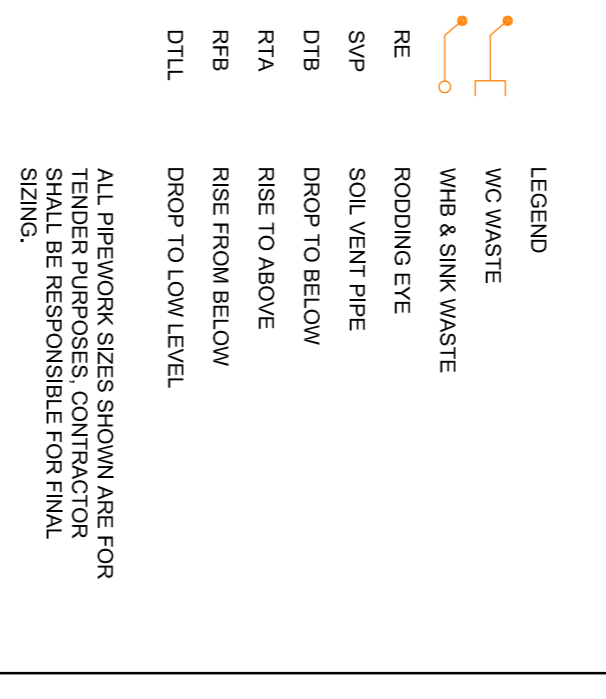

REV	DESCRIPTION	DATE	BY	CHKD
0	Updated General Arrangement	24/04/19	FL	SM
1	Client's top amended	08/04/19	FL	FL
2	Updates as per new architectural layout	07/11/18	MF	SM

ORIGINATOR:



EBEN OFFICE PARK
 HAVY GREEN
 BRISTOL, BS20 0DD
 TEL: 01275 819500
 WWW.RIDGE.CO.UK



CLIENT:
 Department for Education

PROJECT:
 Abacus Belize Primary School
 Hampstead, London

TITLE:
 Mechanical Services
 Proposed Above ground Drainage Layout
 Ground Floor

DRAWING NO.: MF SCALE: 1:100 @ A1

CHECKED BY: SM DATE: 05/09/2018

STATUS: TENDER

DRAWING NO.	PROJECT	ORIG.	ZONE	ELEV.	TYPE	ROLE	NUMBER	REV.
50047713	RDG	XX	00	PL	IM	4501	C	

