







 




Electrical & Heating Key

-  Thermostat
-  Radiator
-  Radiator - new or relocated
-  Wall Light Type
-  Low Level Wall Light
-  Directional downlight
-  Joinery Light
-  Under Cupboard Lights
-  Spike Light



ROOF PLAN

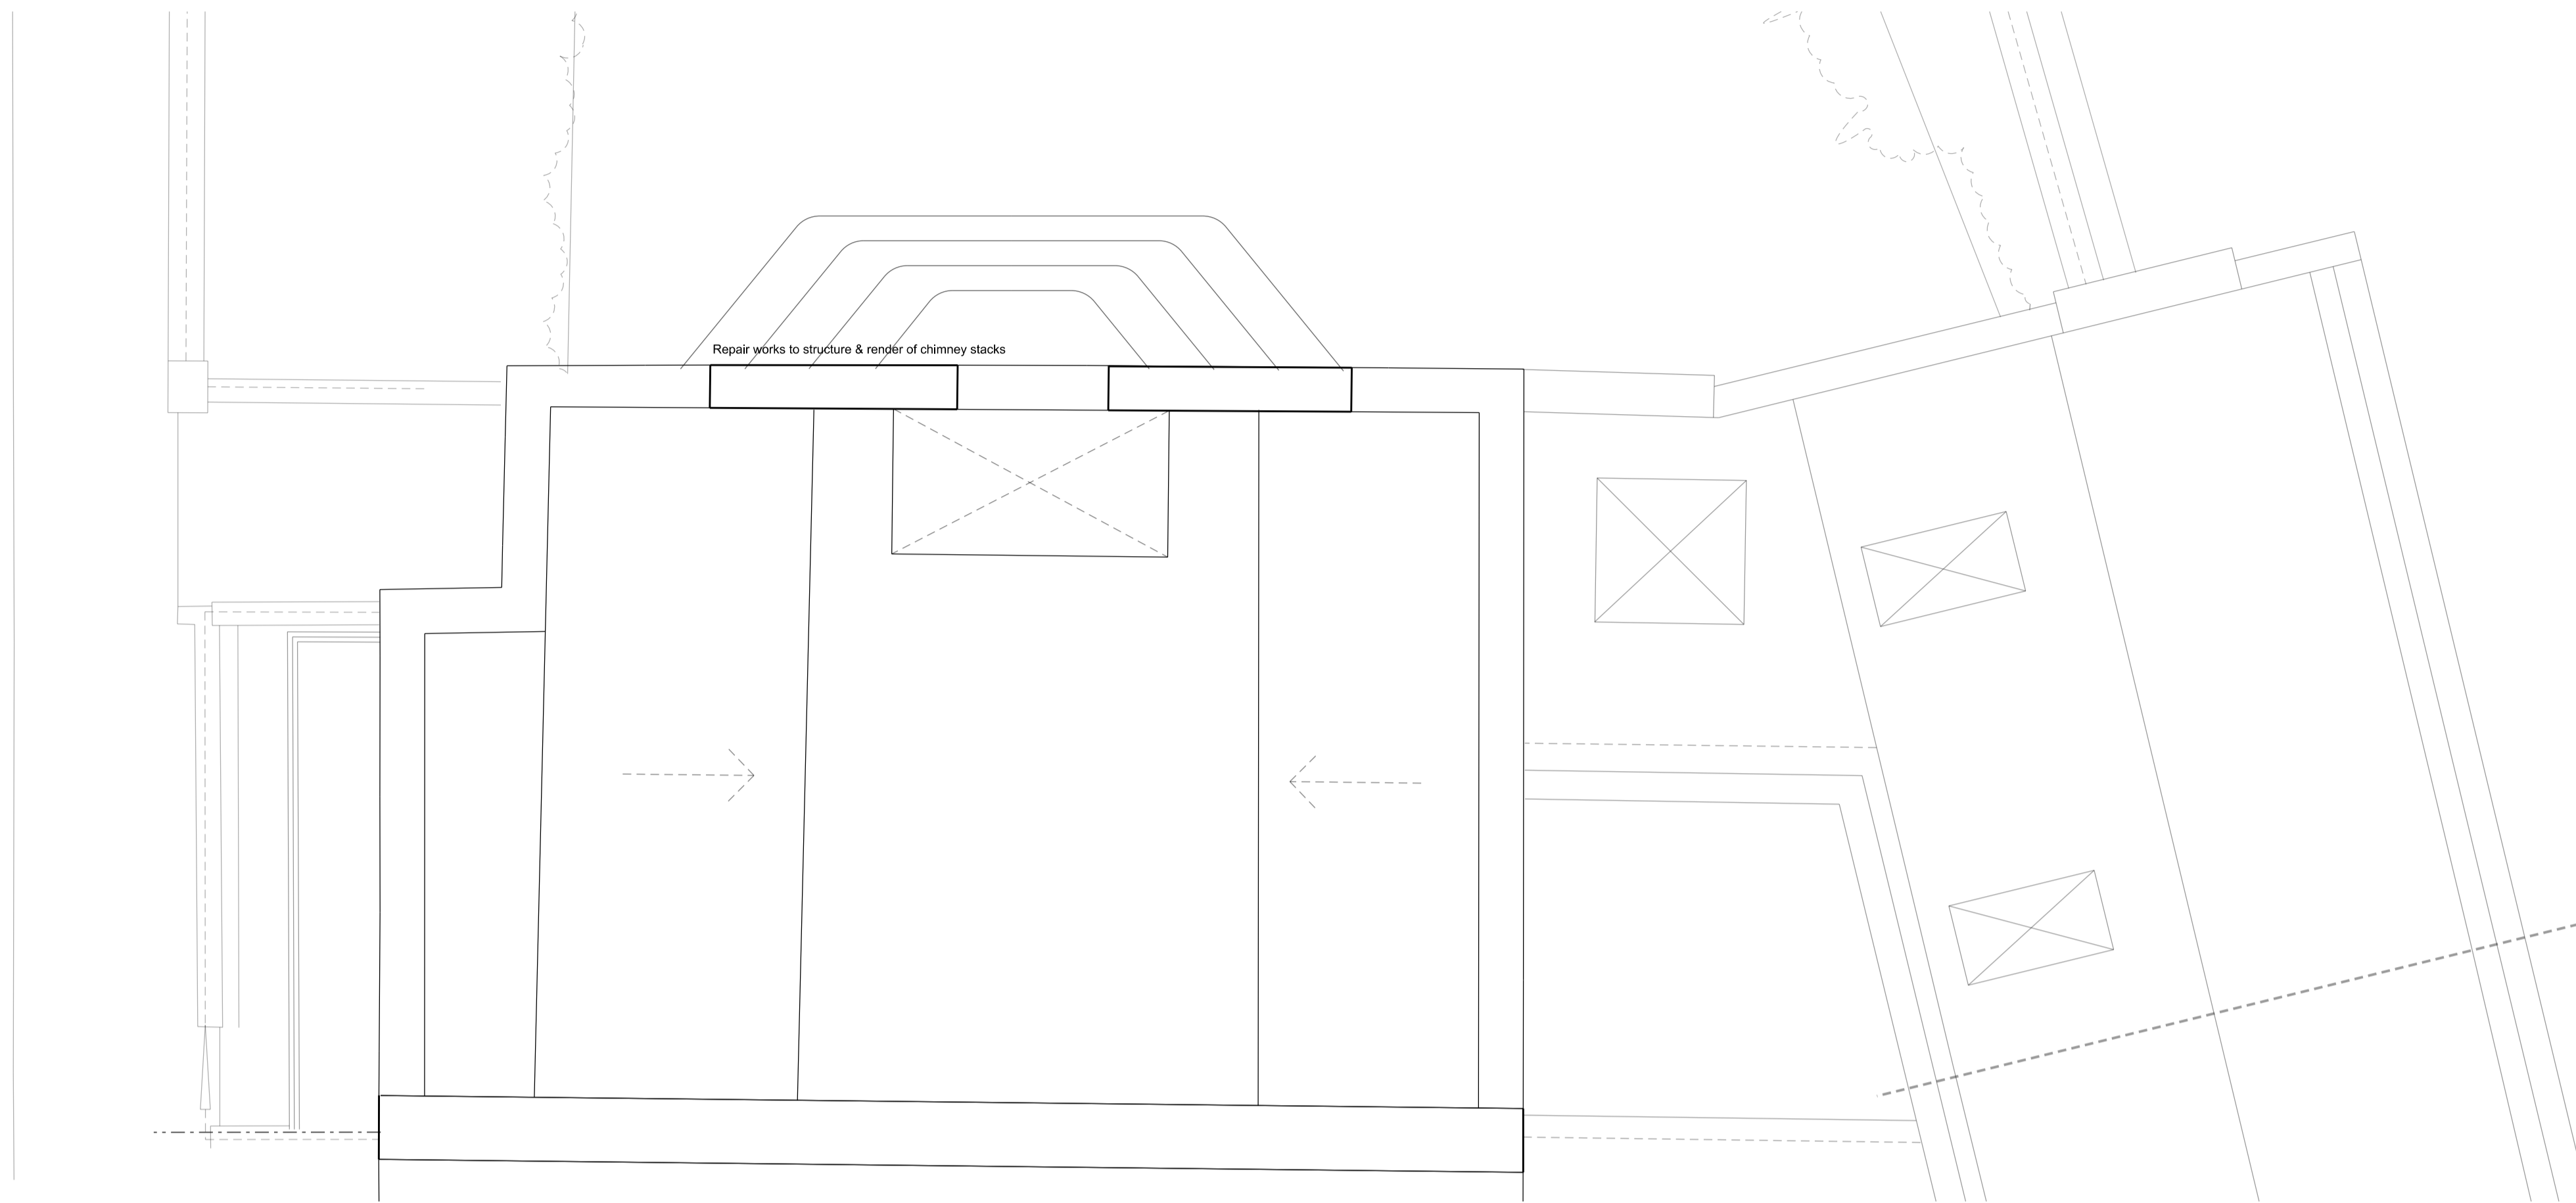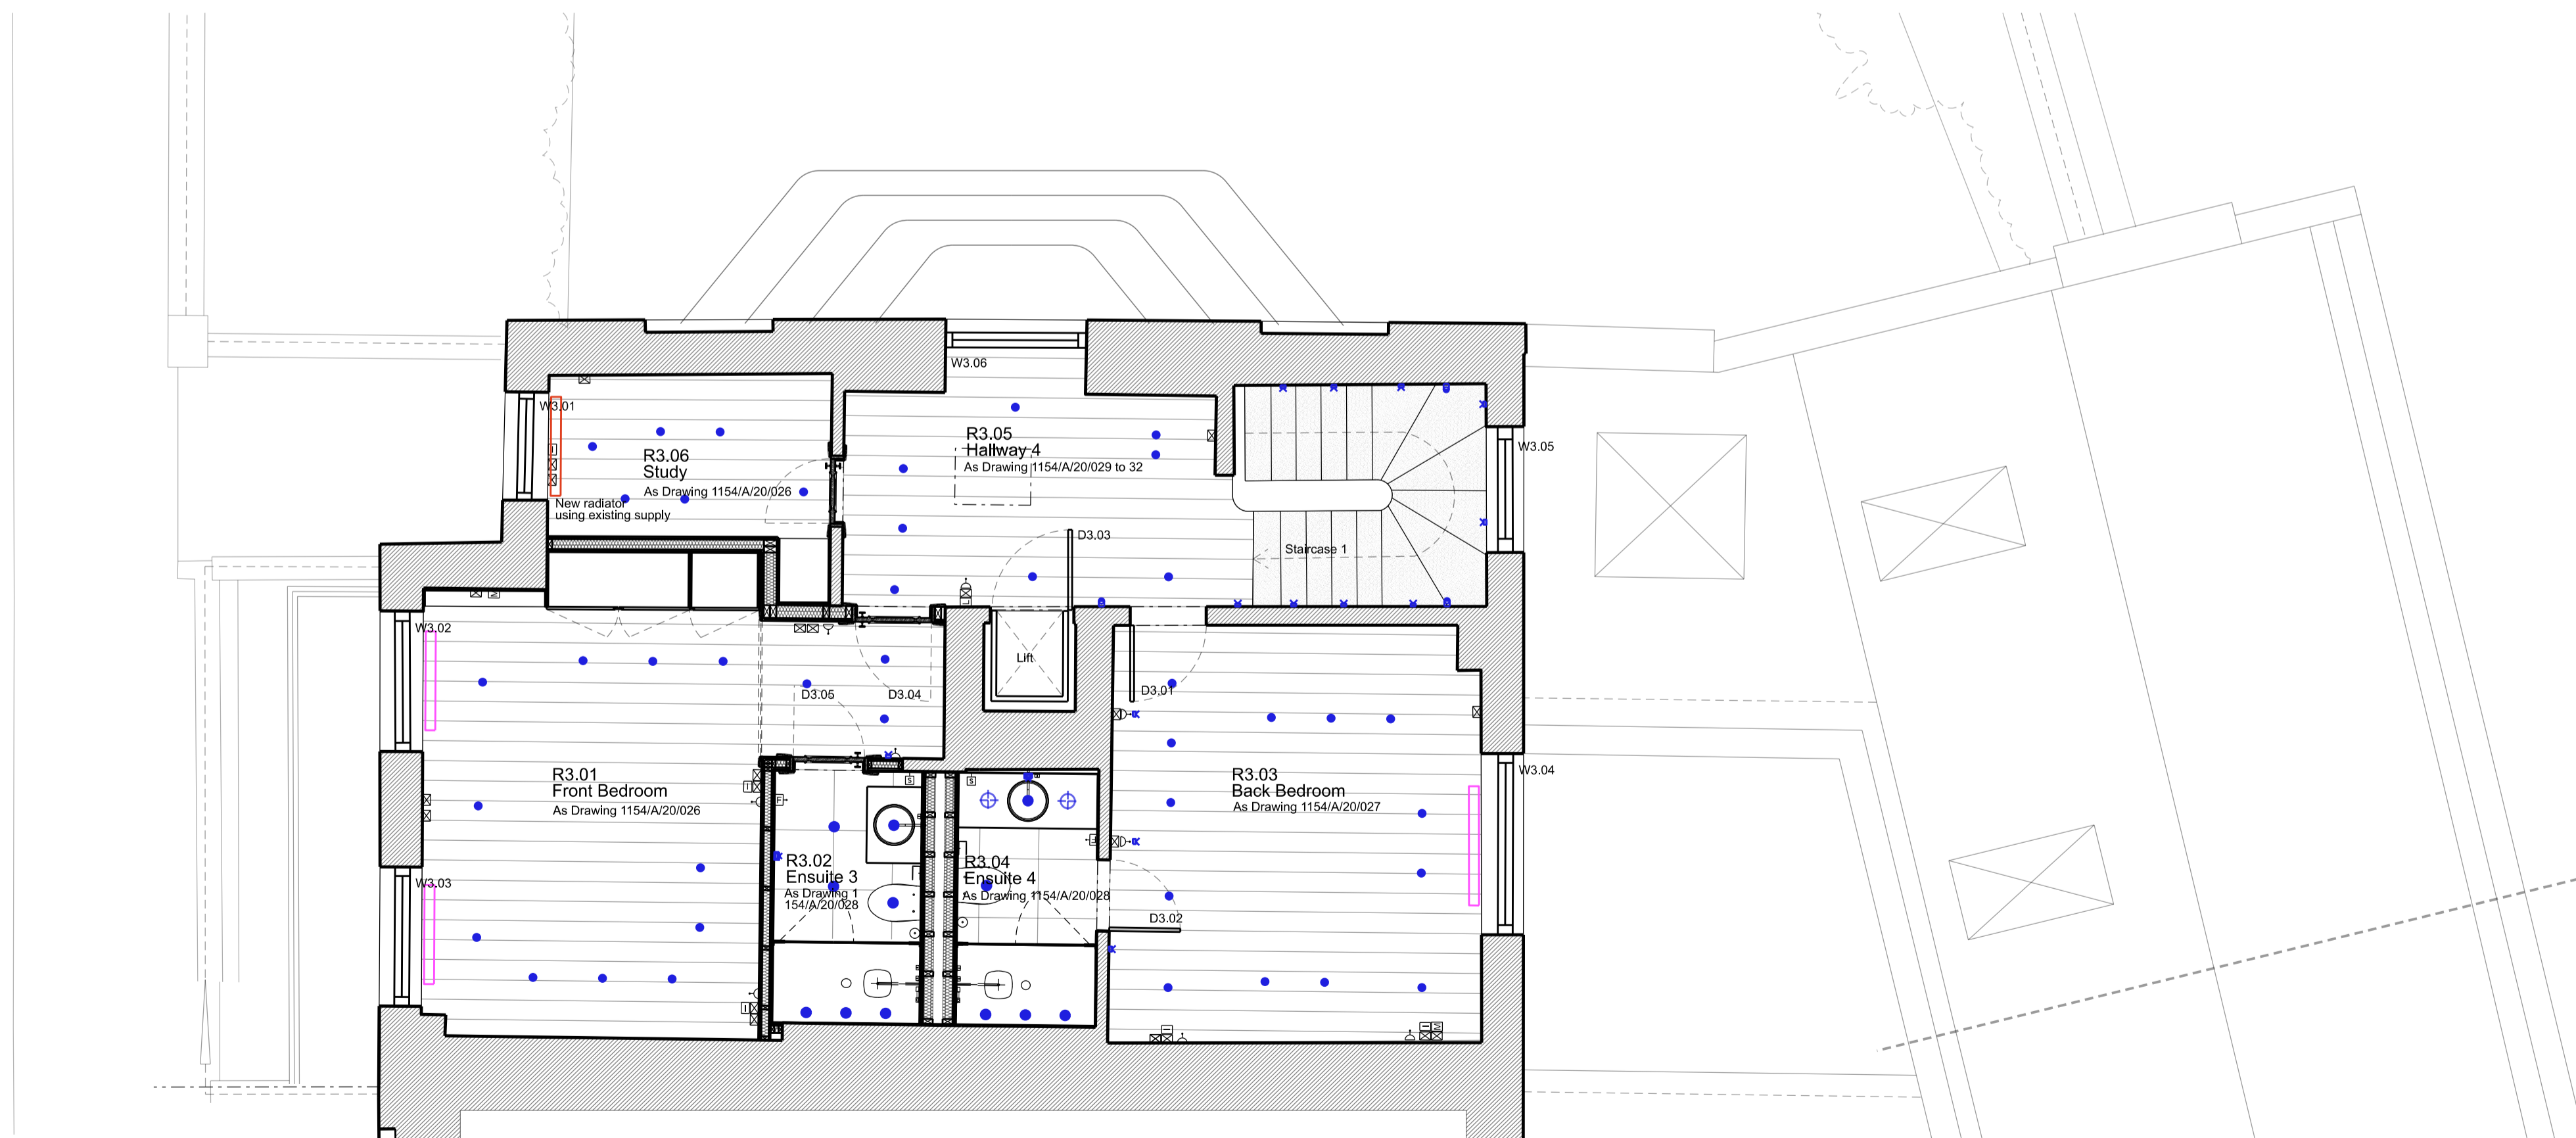

PROPOSED THIRD FLOOR PLAN

|   |                                   |          |
|---|-----------------------------------|----------|
| L | Planning Revisions                | 17/09/20 |
| L | Study Area                        | 11/09/20 |
| K | Lighting & Heating Added          | 29/06/20 |
| J | Client Presentation               | 16/04/20 |
| H | Lighting & Heating Layout Updated | 09/04/20 |
| G | Planning Application & LBC        | 20/12/19 |
| F | Planning Application & LBC        | 11/12/19 |
| E | Client Meeting                    | 19/11/19 |
| D | General Update                    | 13/11/19 |
| C | General Update                    | 04/11/19 |
| B | General Update                    | 16/10/19 |
| A | Client Presentation               | 24/09/19 |

| Rev      | Amendment | Date |
|----------|-----------|------|
| Key Plan |           |      |

**FOR PLANNING**

Client  
Jose & Daniela Neves

Project  
40 Chester Terrace  
London NW1 4ND

Title  
Proposed  
Third Floor Plan &  
Roof Plan

|                |            |           |         |
|----------------|------------|-----------|---------|
| Drawn By       | Checked By | Scale     | Date    |
|                |            | 1:50 @ A1 | Sept 19 |
| Drawing No     | Revision   |           |         |
| 1154/GA/50/003 | L          |           |         |

GROVES NATCHEVA ARCHITECTS

T: +44 (0)20 7937 7772  
E: info@grovesnatcheva.com  
W: www.grovesnatcheva.com

6 Kensington Court Mews London UK W8 5DR

