


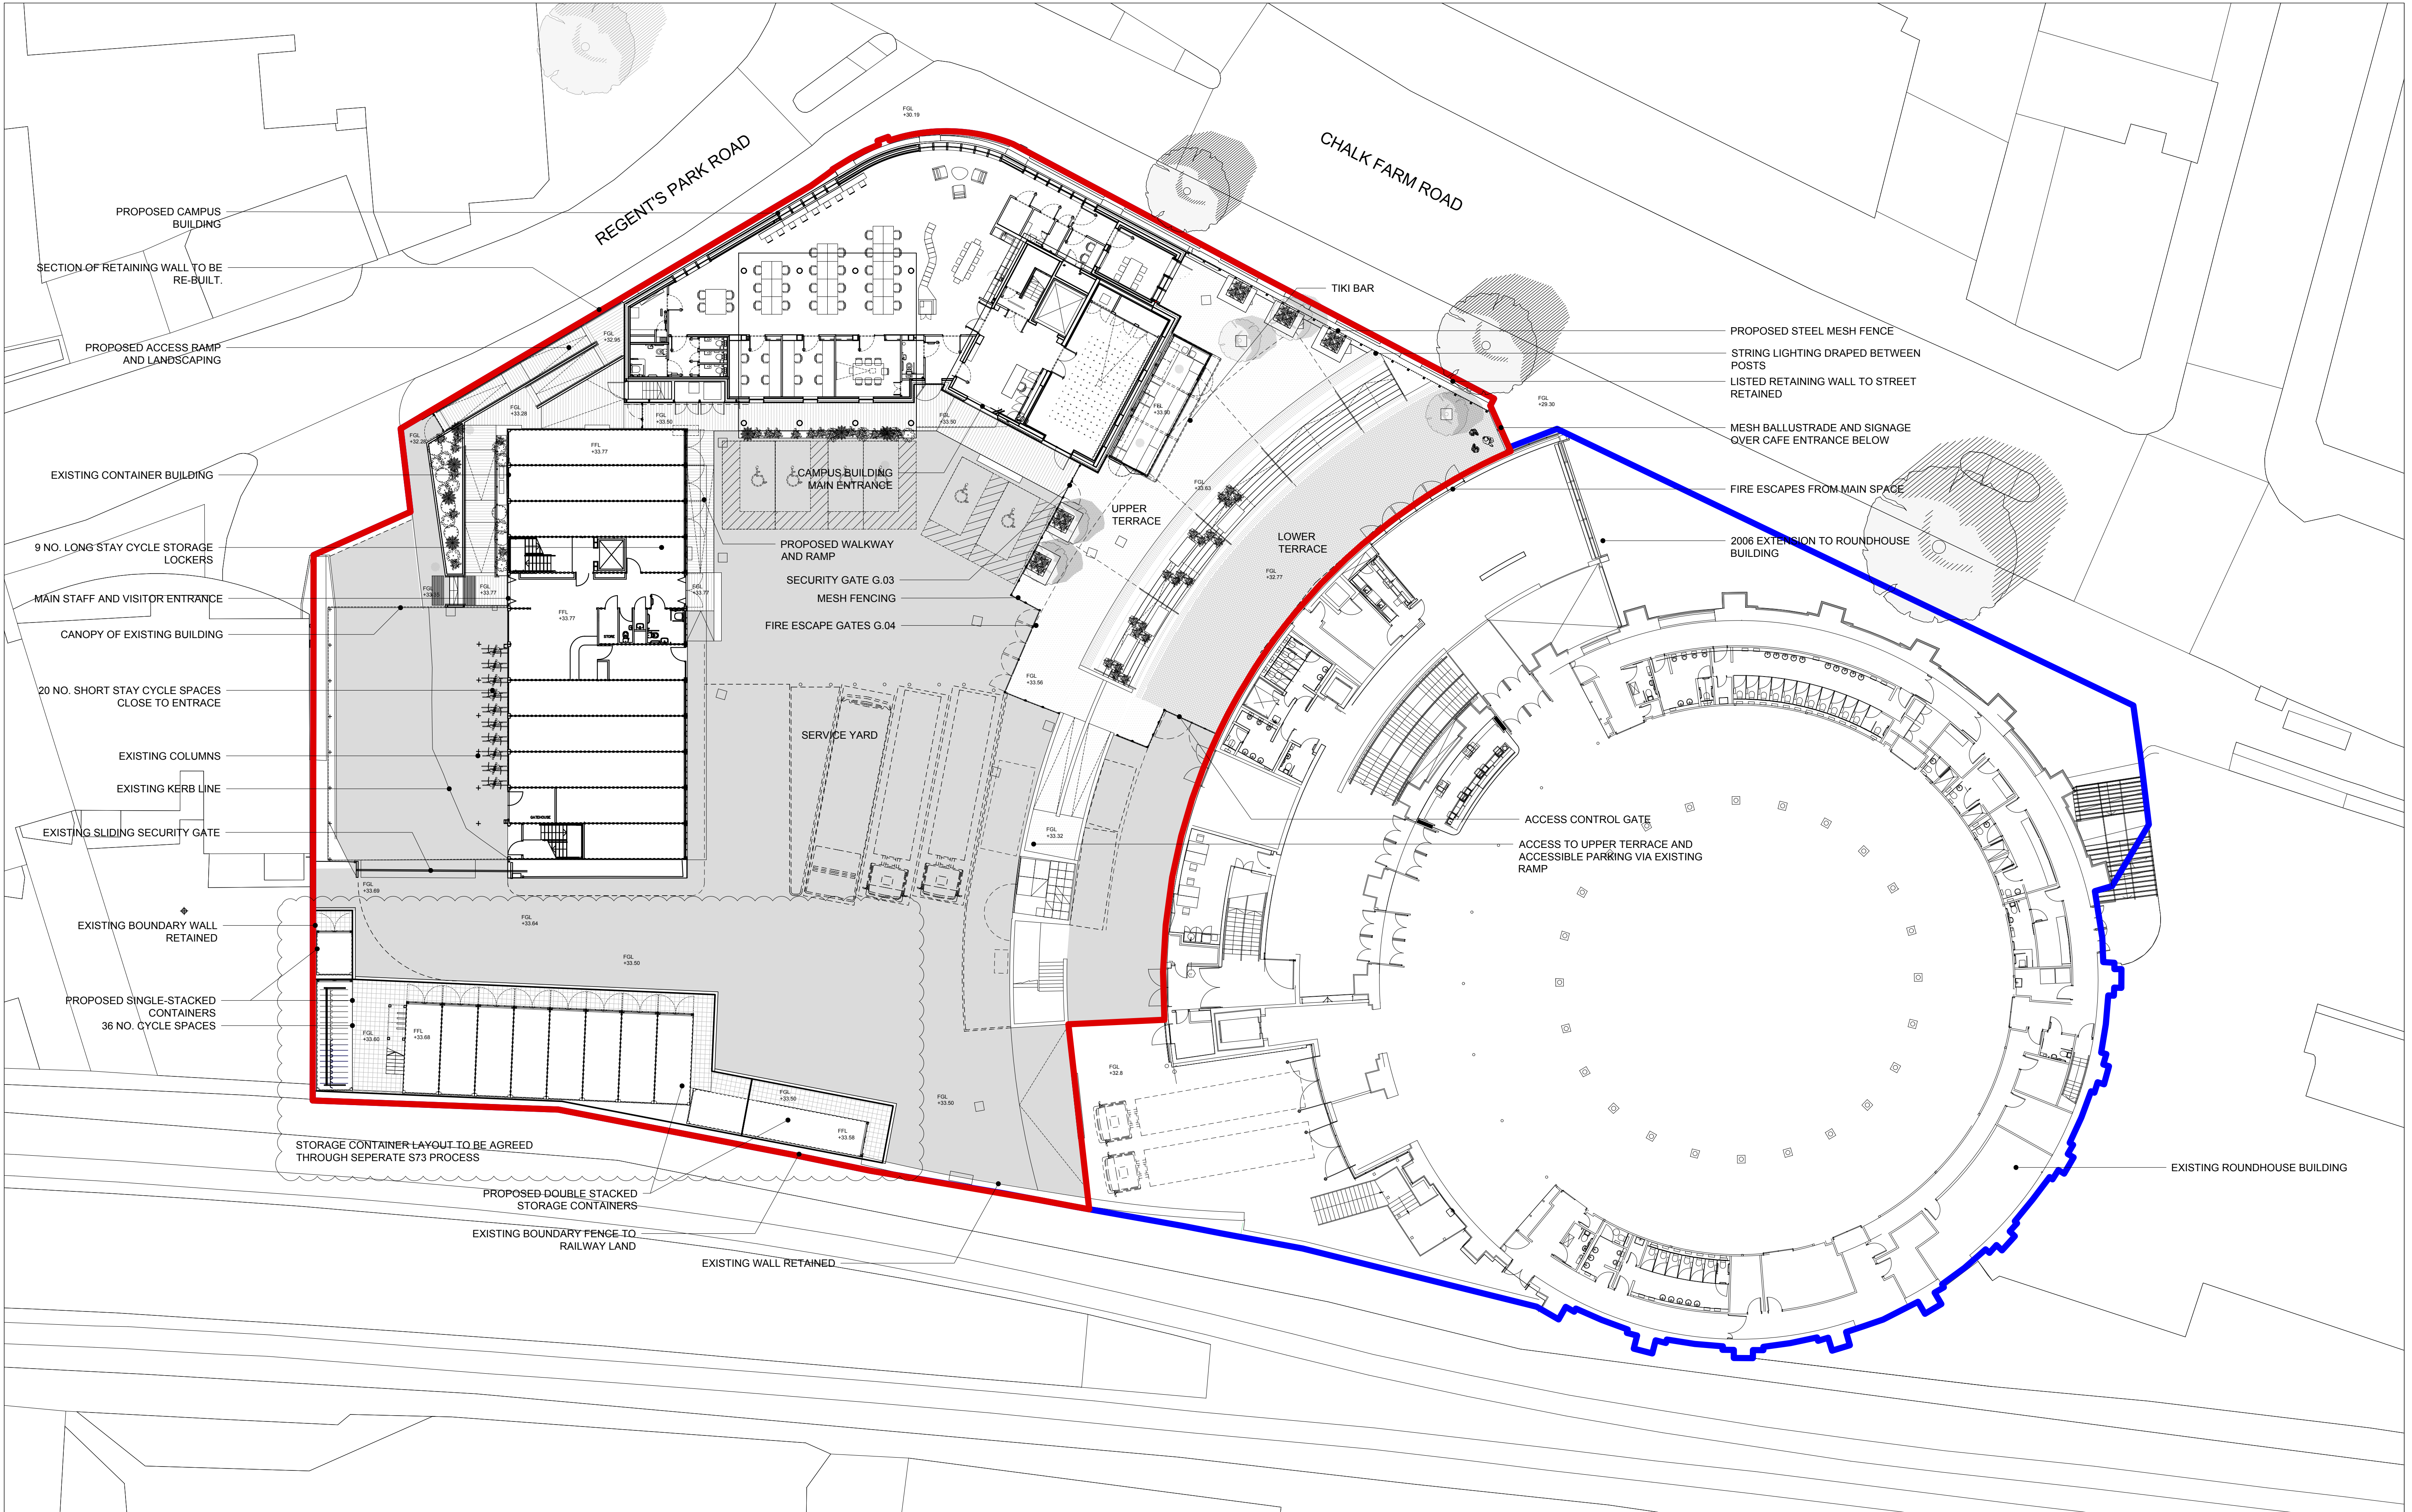

DO NOT SCALE


THE CONTRACTOR IS TO CHECK AND VERIFY ALL BUILDING AND SITE DIMENSIONS, LEVELS AND SEWER INVERT LEVELS AT CONNECTION POINTS BEFORE WORK STARTS.

THIS DRAWING IS TO BE READ AND CHECKED IN CONJUNCTION WITH ENGINEERS AND OTHER SPECIALIST DRAWINGS.

THE DRAWING AND THE WORKS DEPICTED ARE THE COPYRIGHT OF REED WATTS ARCHITECTS AND MAY NOT BE REPRODUCED EXCEPT BY WRITTEN PERMISSION.

REV	DATE	DESCRIPTION
B	27.11.19	DRAFT - PRELIMINARY STAGE 4
C	23.12.19	STAGE 4 IN PROGRESS
D	17.03.20	DRAFT TENDER ISSUE FOR CO-ORDINATION
E	08.05.20	TENDER
P01	22.09.20	PLANNING - APPLICATION TO VARY CONDITION 2
P02	25.09.20	PLANNING - CONDITION 9 DISCHARGE
P03	25.09.20	PLANNING - CONDITIONS 5+11 DISCHARGE

- PLANNING BOUNDARY
- ROUNDHOUSE OWNERSHIP BOUNDARY

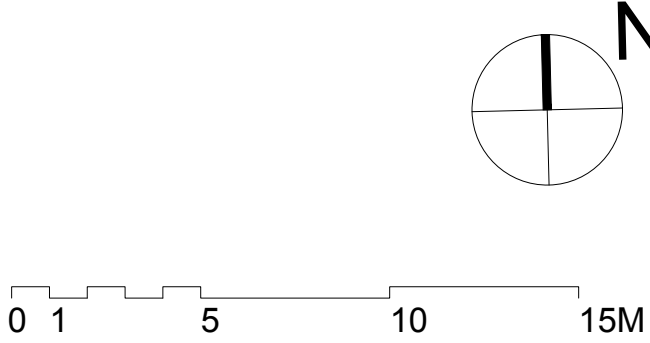

DRAWING	
PROPOSED SITE PLAN - GROUND	
DRAWING NO	REVISION
1906(0)010 P03	P02
SCALE	DATE
1:200 @ A1 1:400 @ A3	28.09.19
STATUS	
PLANNING	