





1 VELUX ROOF LIGHT FK06

NEW VELUX ROOF LIGHT FK06 (1180x660mm)

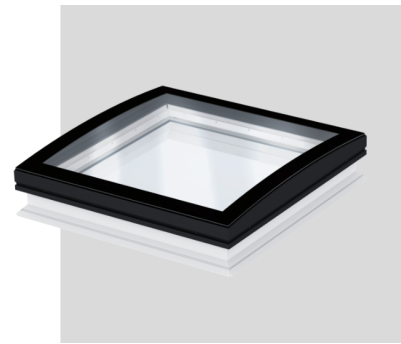

2 VELUX CURVED ROOF LIGHT 100100

NEW VELUX FLAT ROOF LIGHT 100100 TO DORMER FLAT ROOF (1000x1000mm)

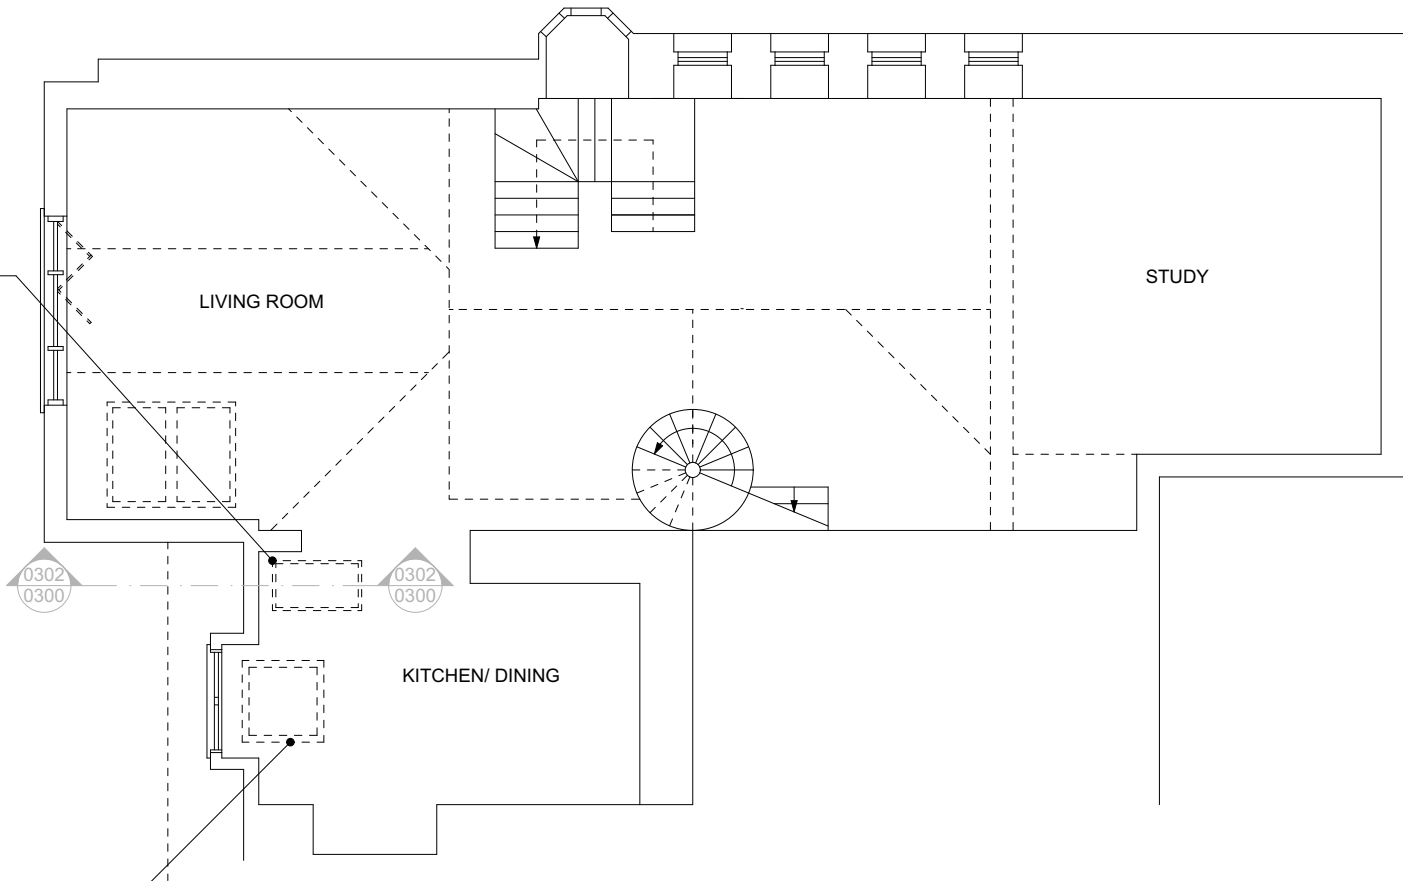

3 01-SECOND FLOOR 1:100



NOTES:  
This document and its design content is copyright ©. It shall be read in conjunction with all other associated project information including models, specifications, schedules and related consultants documents. Do not scale from documents. All dimensions to be checked on site. Immediately report any discrepancies, errors or omissions on this document to the Originator. If in doubt ASK.



02	FOR PLANNING	FG	MW	26/09/2020
01	FOR PLANNING	FG	MW	21/08/2020
REV	DESCRIPTION	DRAWN	CHECKED	DATE

CREATE

DESIGN + ARCHITECTURE

Wigglesworth House 69 Southwark Bridge Road London SE1 9HH  
+44 207 021 0267 info@createdesign.org www.createdesign.org

CLIENT:	AMIR CHEN
PROJECT:	MARESFIELD GARDENS
BUILDING NAME:	APRIL HOUSE
ADDRESS:	45 MARESFIELD GARDENS NW3 5TE
DRAWING NAME:	SECOND FLOOR PLAN
DRAWING SERIES:	0000-0199 PLANNING PLANS

CDA REF:	SCALE(S):	ORIGINAL PAPER SIZE:
000	1:100	A3

REVISION:	REVISION DESCRIPTON:
02	FOR PLANNING

PROJECT	ORIGINATOR	VOLUME	LEVEL	TYPE	ROLE	CLASS	NUMBER
000	- CDA	-	A	- 02	- DR	- A	- 05 - 0100