


Notes

- THE CONTRACTOR SHALL BE AWARE OF THEIR RESPONSIBILITIES WITH REGARD TO THE CONSTRUCTION (DESIGN AND MANAGEMENT) REGULATIONS AND SHALL UNDERTAKE THE DESIGN AND SUBSEQUENT INSTALLATION OF THESE SERVICES HAVING TAKEN DUE CONSIDERATION OF THESE REGULATIONS.
- IN CONJUNCTION WITH THE INFORMATION DETAILED UPON THIS DRAWING THE CONTRACTOR SHALL FAMILIARISE THEMSELVES WITH ALL RELATED SERVICES AND TRADE DRAWINGS, SPECIFICATIONS AND SCHEDULES, ETC. ASSOCIATED WITH THESE WORKS. THIS SHALL INCLUDE, BUT NOT LIMITED TO, THE ELECTRICAL, MECHANICAL, PUBLIC HEALTH, ARCHITECTURAL AND STRUCTURAL WORKS.
- THE CONTRACTOR SHALL FULLY COORDINATE ALL SERVICES USING THE COORDINATION AND INSTALLATION (WORKING) DRAWING PROCESS. THE CONTRACTOR SHALL COORDINATE WITH OTHER TRADES AND DISCIPLINES AND GENERAL COORDINATION WITH THE BUILDING FABRIC, STRUCTURE, ARCHITECTURAL FINISHES AND SPECIALIST TRADES.
- INFORMATION AND DETAILS RELATING TO THIS DRAWING ARE FOR INFORMATION PURPOSES ONLY AND DO NOT CONSTITUTE THE EXTENT OF THE DESIGN INFORMATION OR ANY PART THEREOF. SIZES, DUTIES, RATINGS ETC. OF ANY PLANT OR EQUIPMENT DETAILED UPON THESE DRAWINGS ARE FOR GUIDANCE PURPOSES ONLY AND SHOULD BE CONFIRMED BY THE DESIGN AND BUILD CONTRACTOR.
- THIS DRAWING IS NOT FOR CONSTRUCTION.
- ALL DEVICES TO BE LEFT WITH 3m OF CABLE COILED UP TO ALLOW FOR RELOCATION OF DEVICE.

LEGEND

- FIRE ALARM LOCKABLE SWITCH AS PER ELECTRICAL W4785HW
- WEATHERPROOF
- FIRE ALARM BREAK GLASS UNIT
- SMOKE DETECTOR WITH INTEGRAL SOUNDER
- SMOKE DETECTOR WITH INTEGRAL SOUNDER & FLASHING BEACON
- REMOTE INDICATOR
- FIRE ALARM PANEL
- INTERFACE UNIT
 - 1) SECURITY
 - 2) AHU'S
 - 3) BMS
 - 4) KOKO SOCIAL
 - 5) MEDIA/AV
 - 6) IT
- FIRE ALARM BELL

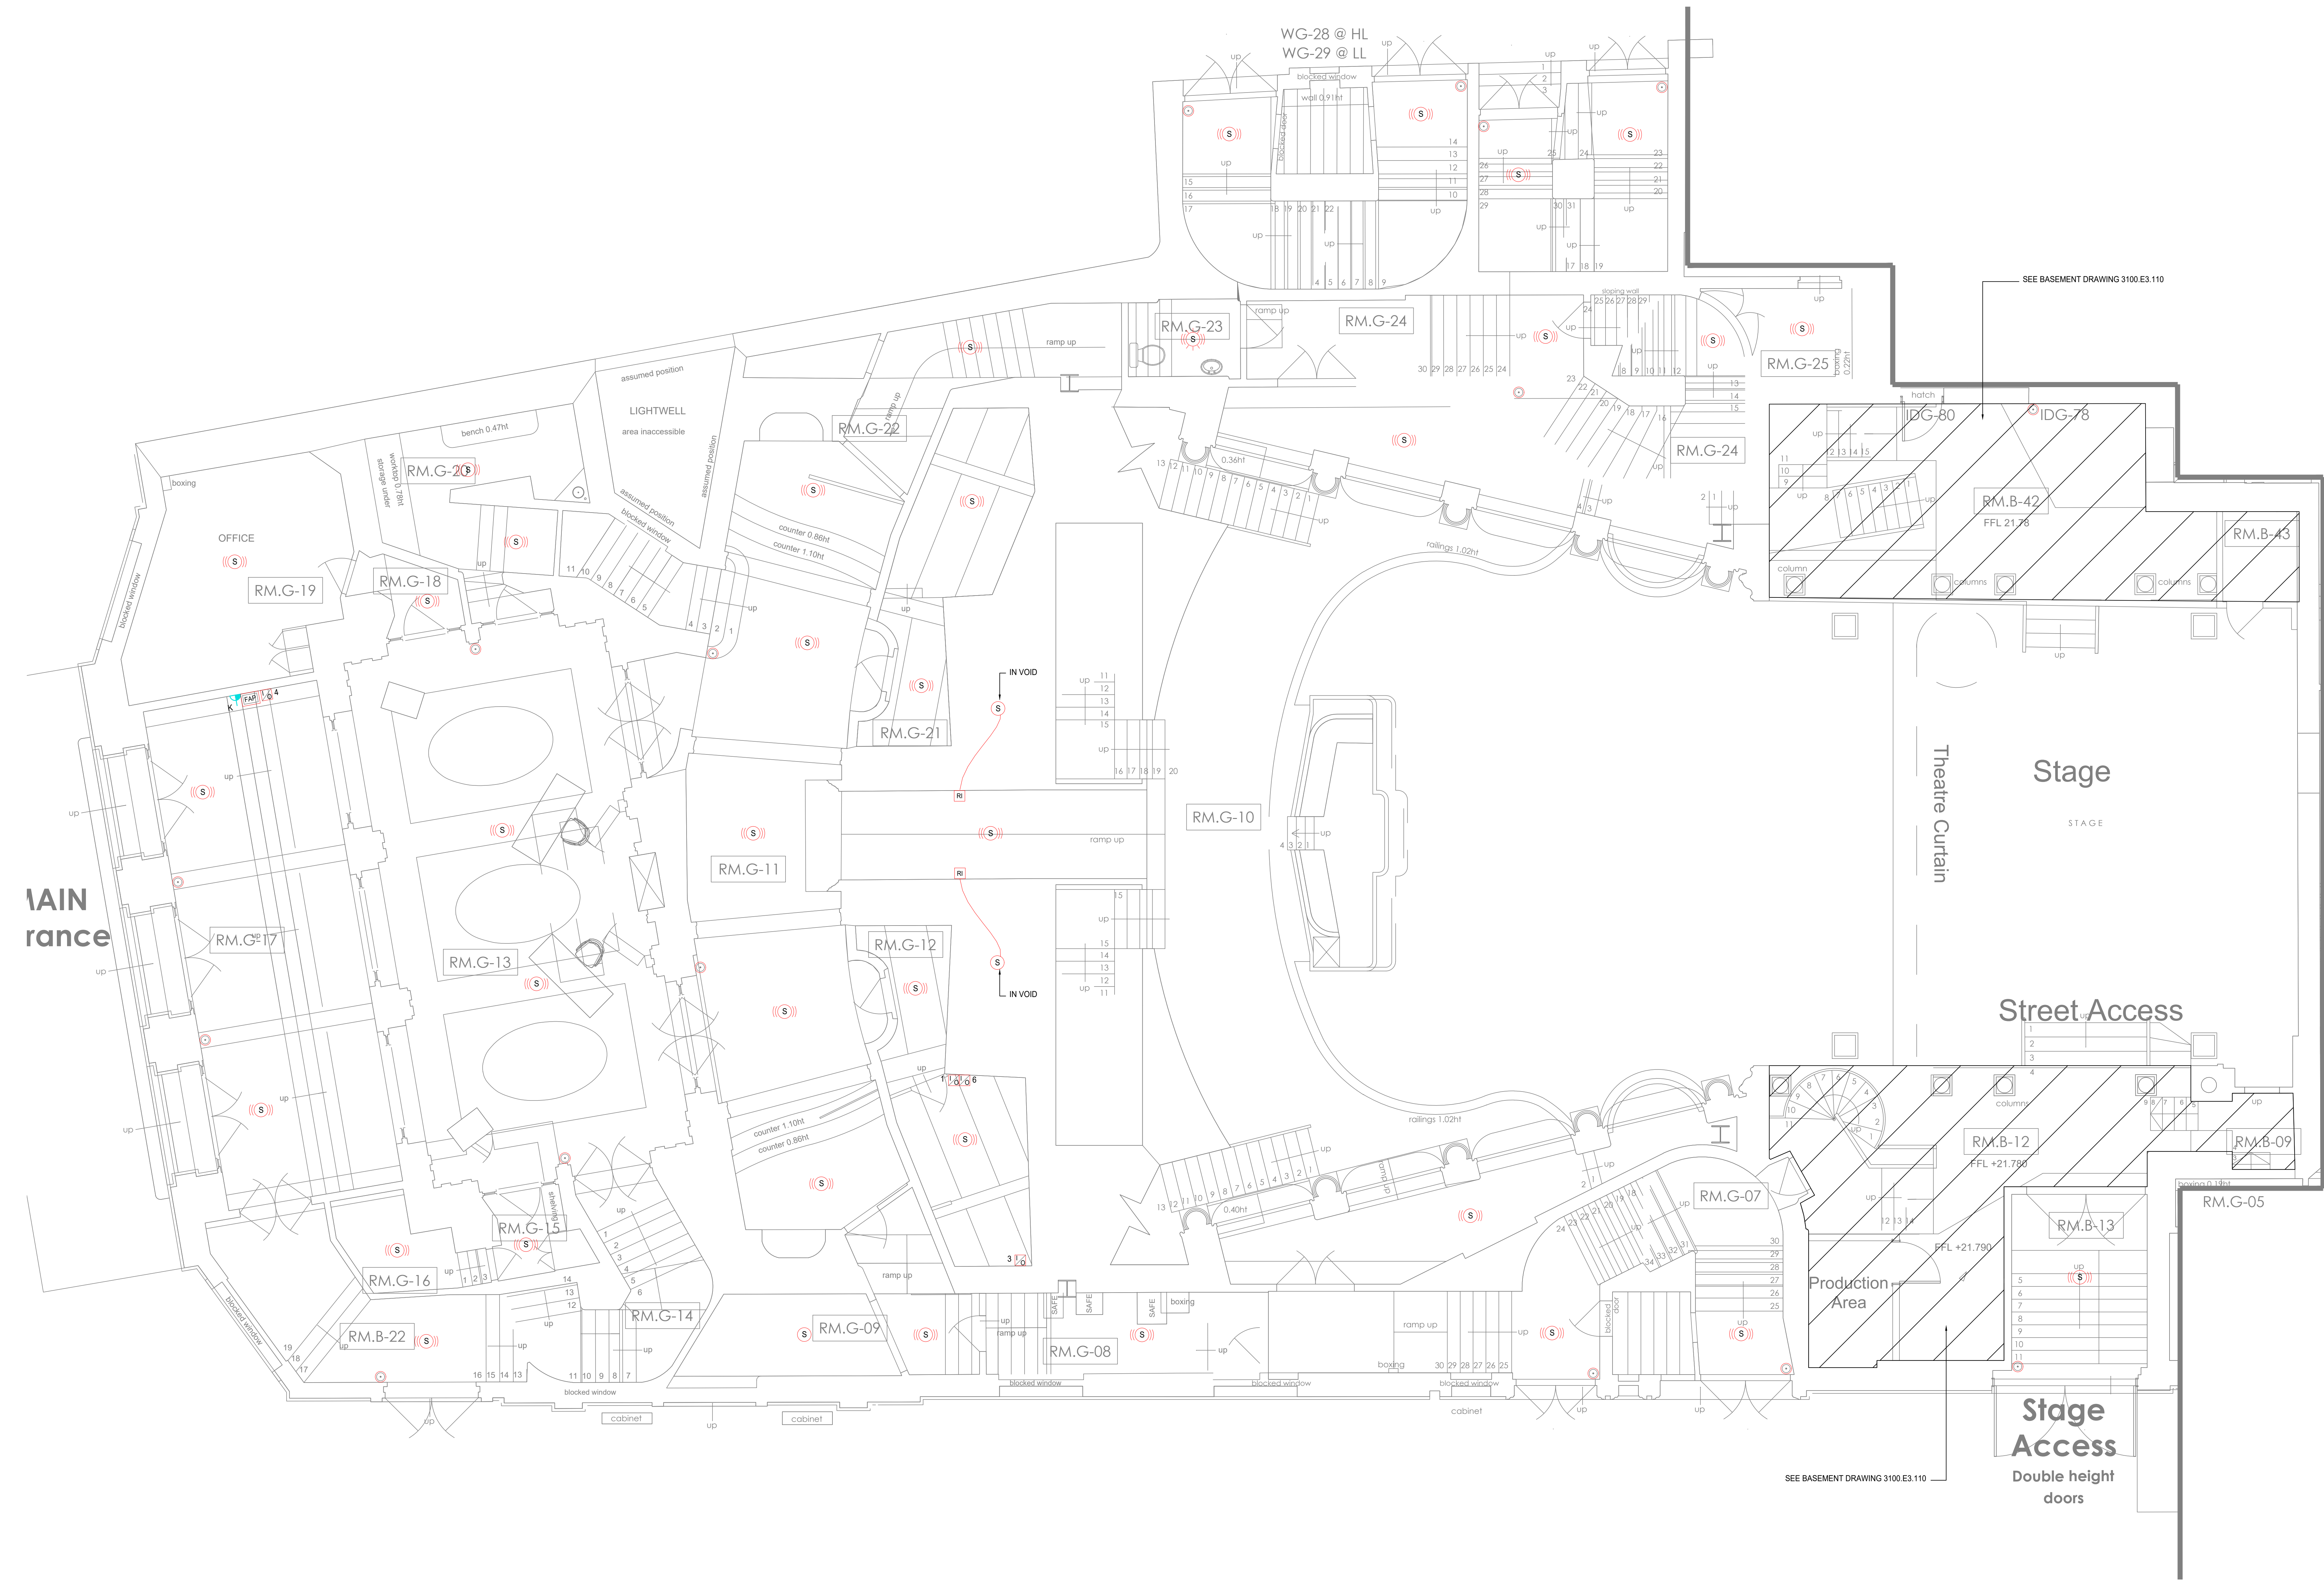

Rev.	Date	Description
1	31.12.2001	Details
STAGE 3		
Consulting Engineers Building Services		
SVM		
Berkmansd 01442 869369		
Architect		
Archer Humphryes Architects		
Structural Engineer		
Heyne Tillett Steel		
Quantity Surveyor		
Gardiner & Theobald LLP		
Project Name		
Koko Camden Palace		
Client		
The Mint Group		
Drawing Title		
Ground Floor Fire Alarm Layout		
Scale	Date	Orig. By
1:50@A0	AUG 2020	CBD
Drawn By	Checked	Revision
AL	KD	1
Drawing Number		Revision
3100.E3.120		1