




INDICATIVE EXTERNAL ELEVATION

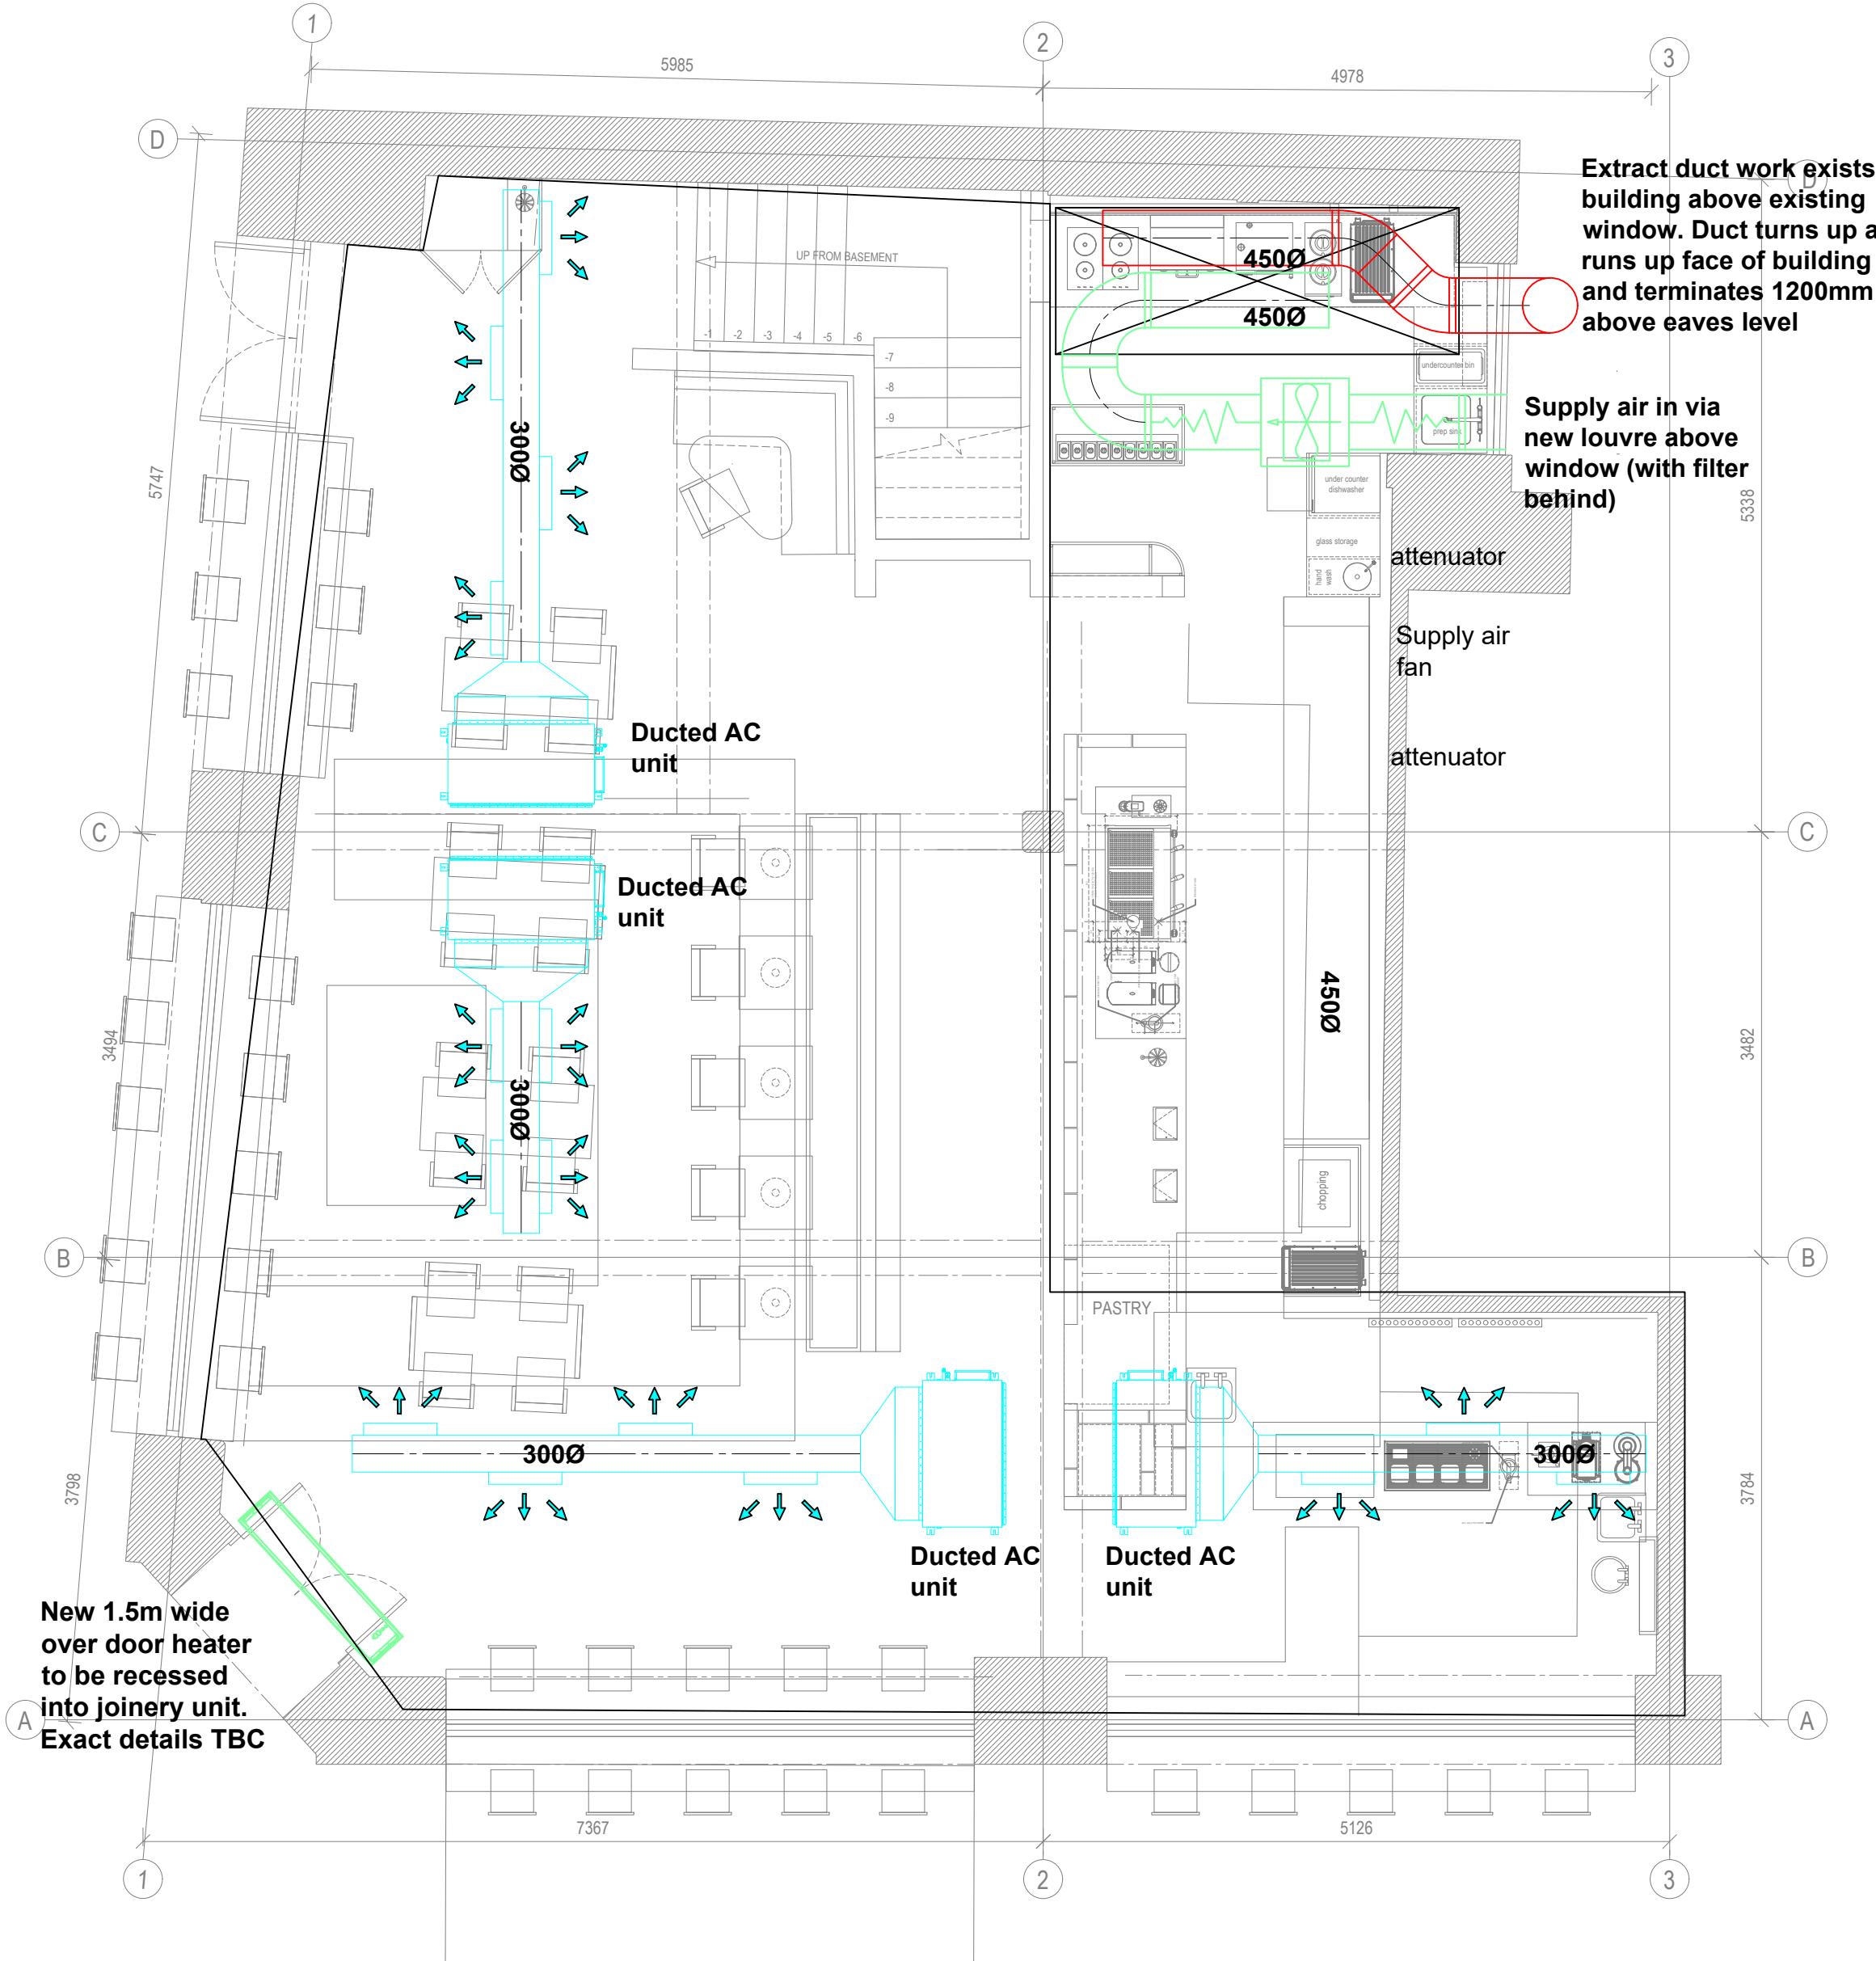

PROPOSED GROUND FLOOR PLAN

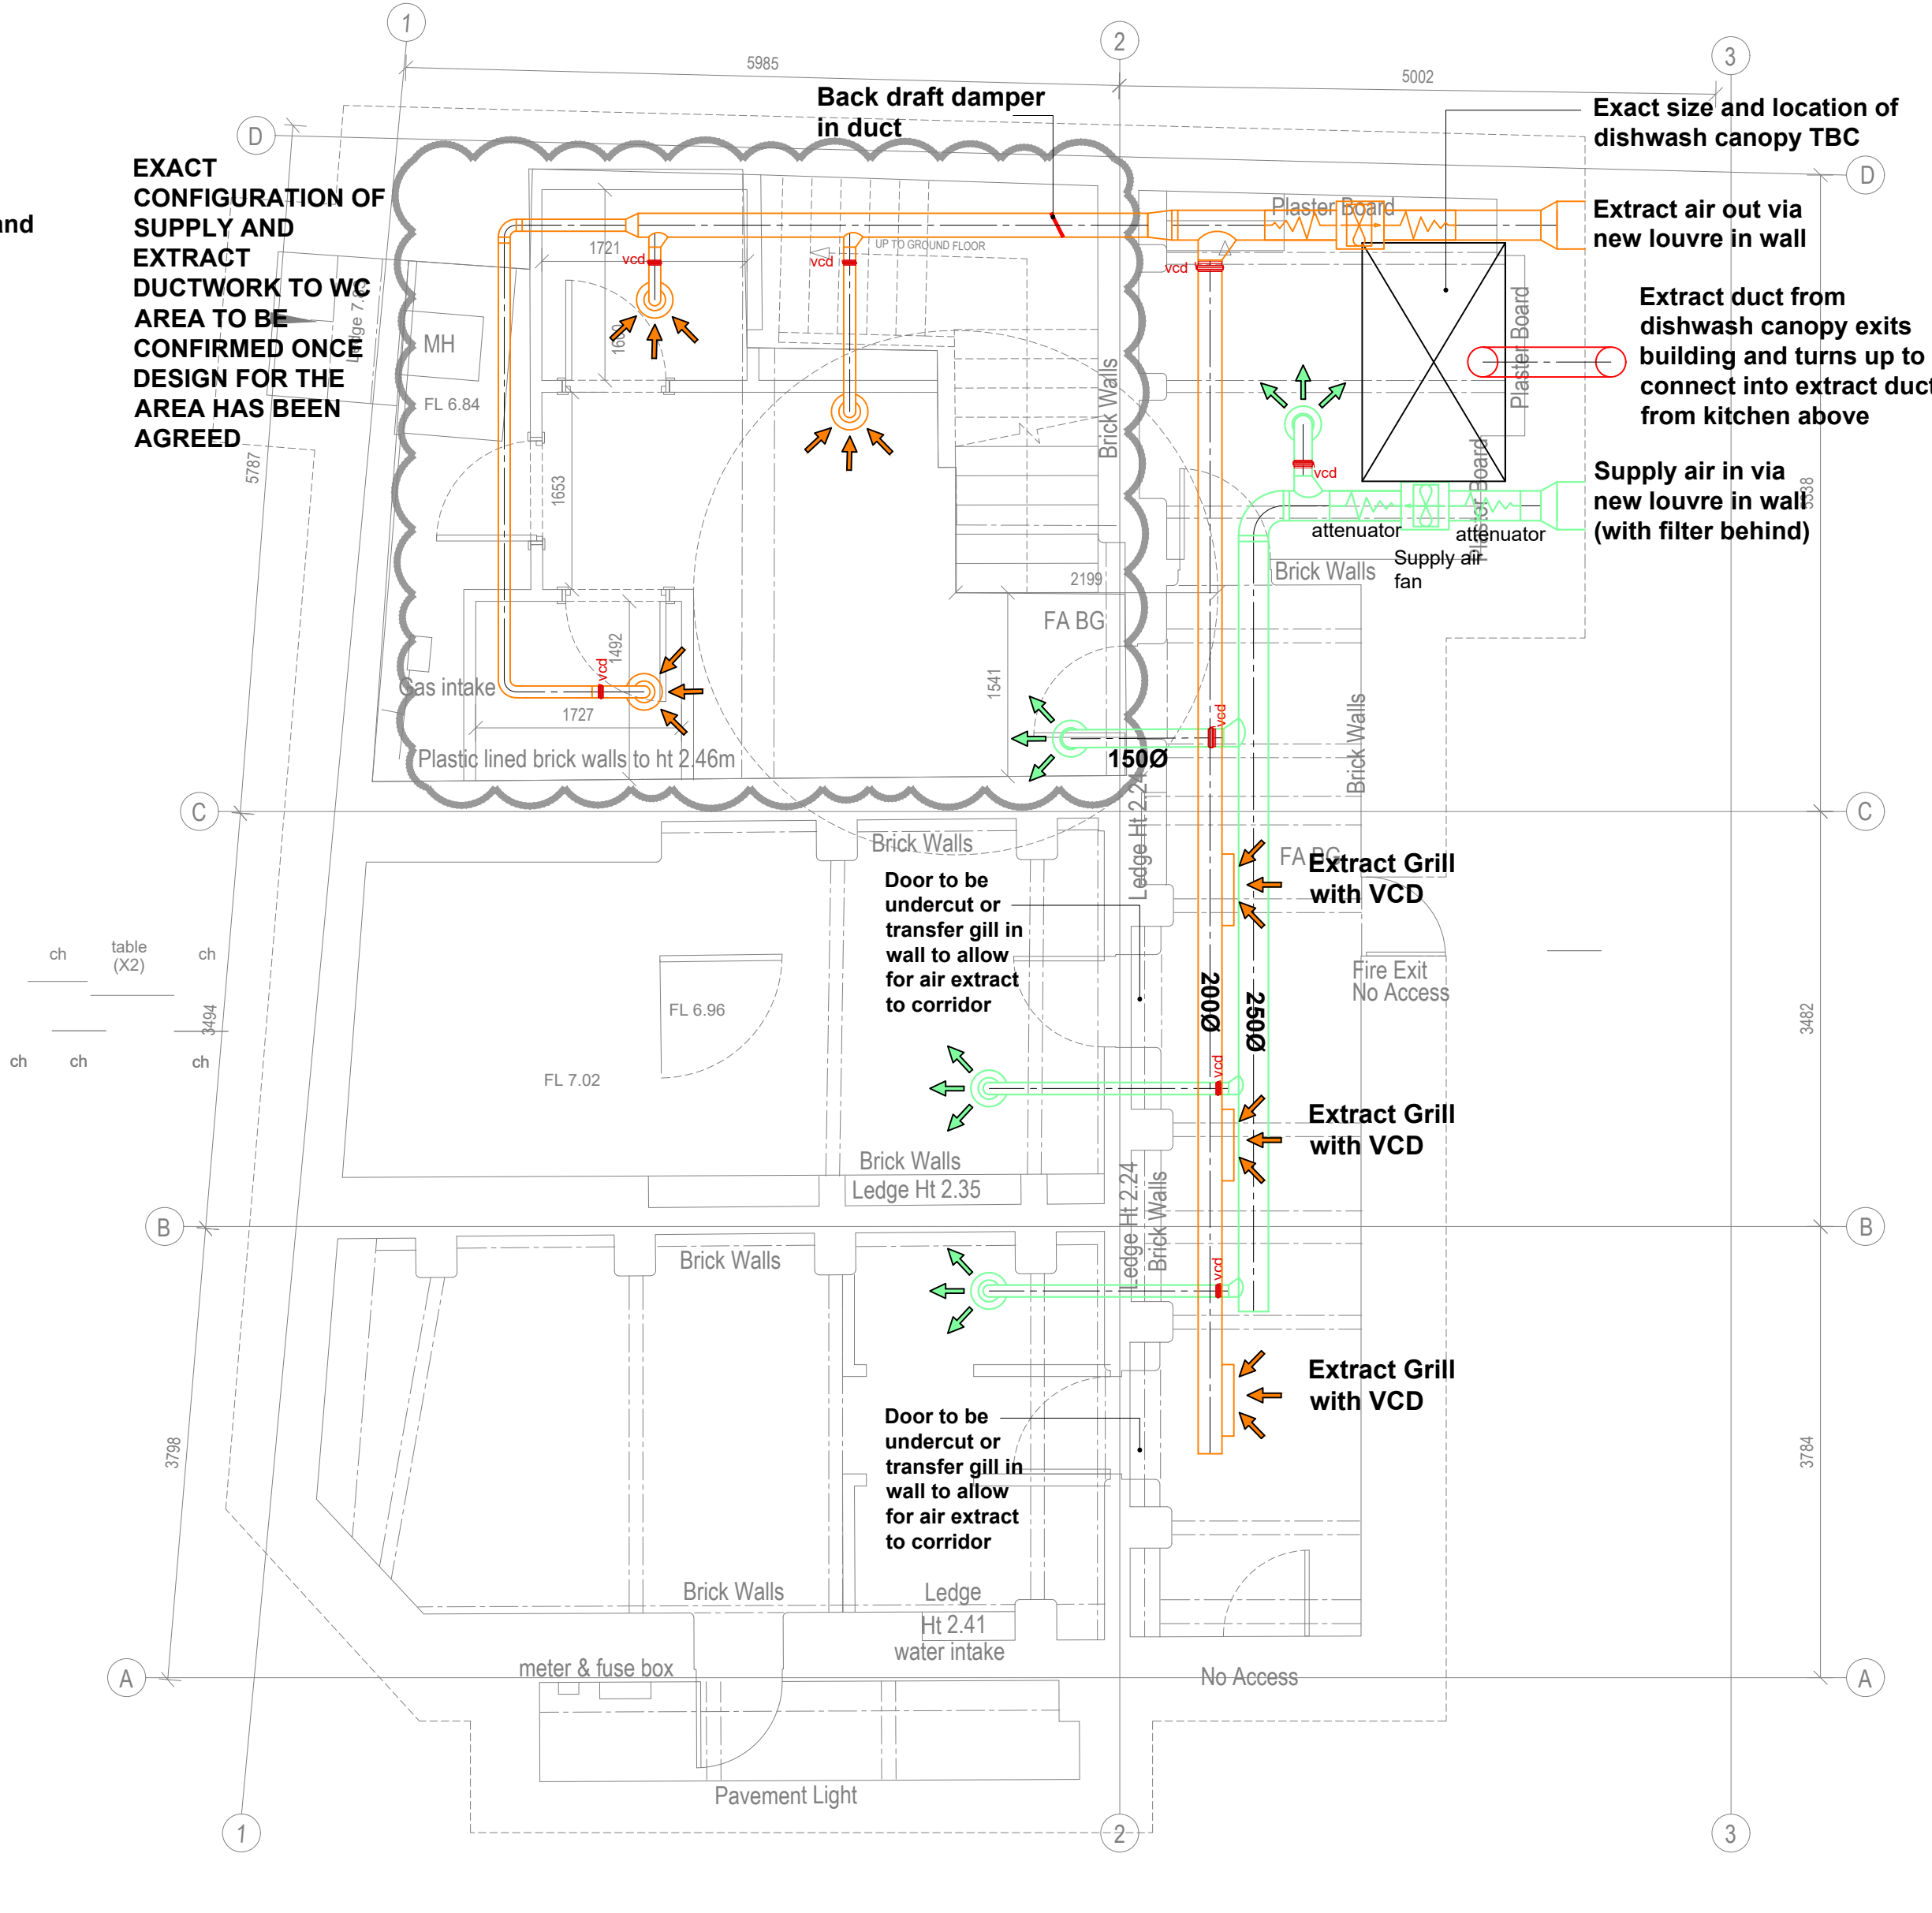

PROPOSED BASEMENT PLAN

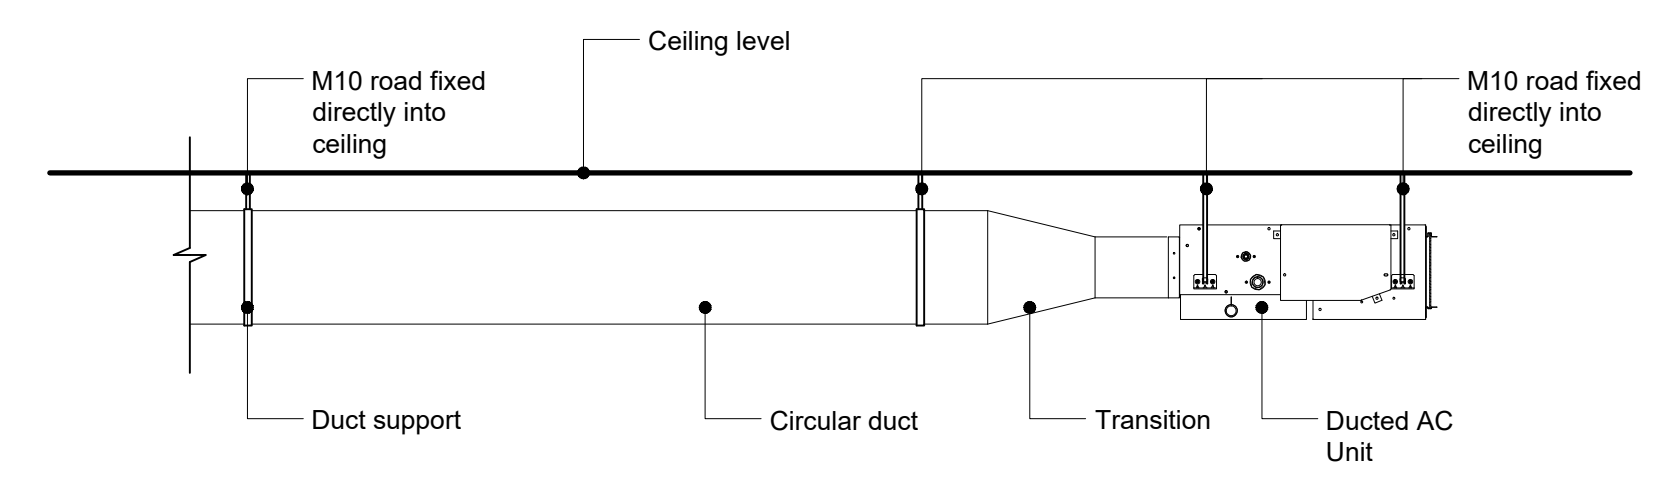

TYPICAL AC UNIT FIXING DETAIL

-	-	-
-	-	-
-	-	-
A	08/09/20	Drawing updated inline with comments from designer
Rev	Date	Description
 REFRIGERATION-AIR CONDITIONING-VENTILATION 17 Calverton Business Park Hoyle Road Calverton tel: 0115 965 5042 Nottingham NG14 6QL web: fwpuk.com		
Drawn:	Checked:	Date:
RDS	-	07/09/20
Issue: Provisional <input checked="" type="checkbox"/> Approved <input type="checkbox"/> As Built <input type="checkbox"/> Current <input type="checkbox"/>		
Site Address: Fernandez & Wells 1-3 Denmark Street London		
Drawing Title: Proposed HVAC Details		
Drawing Number:	Rev:	Paper size: Scale:
20177/001	A	A1 1:50