


This drawing is the property of Perkins+Will UK Ltd. No disclosure or copy of it may be made without the written permission of Perkins+Will UK Ltd.

All information, areas, dimensions and datum levels are subject to detailed survey, detailed design and investigative work. Do not scale from the drawing.

NOTE: DOCUMENTS ARE INCOMPLETE AND MAY NOT BE USED FOR REGULATORY APPROVAL, PERMITTING, OR CONSTRUCTION PURPOSES.

PROJECT


150 HOLBORN
EC1N 2NS

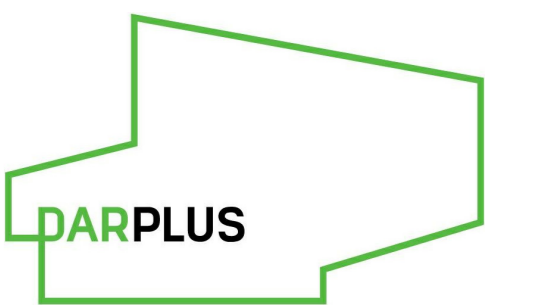


DAR

74 WIGMORE STREET

KEYPLAN

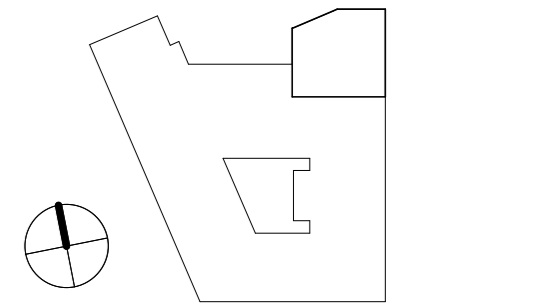

ISSUE CHART

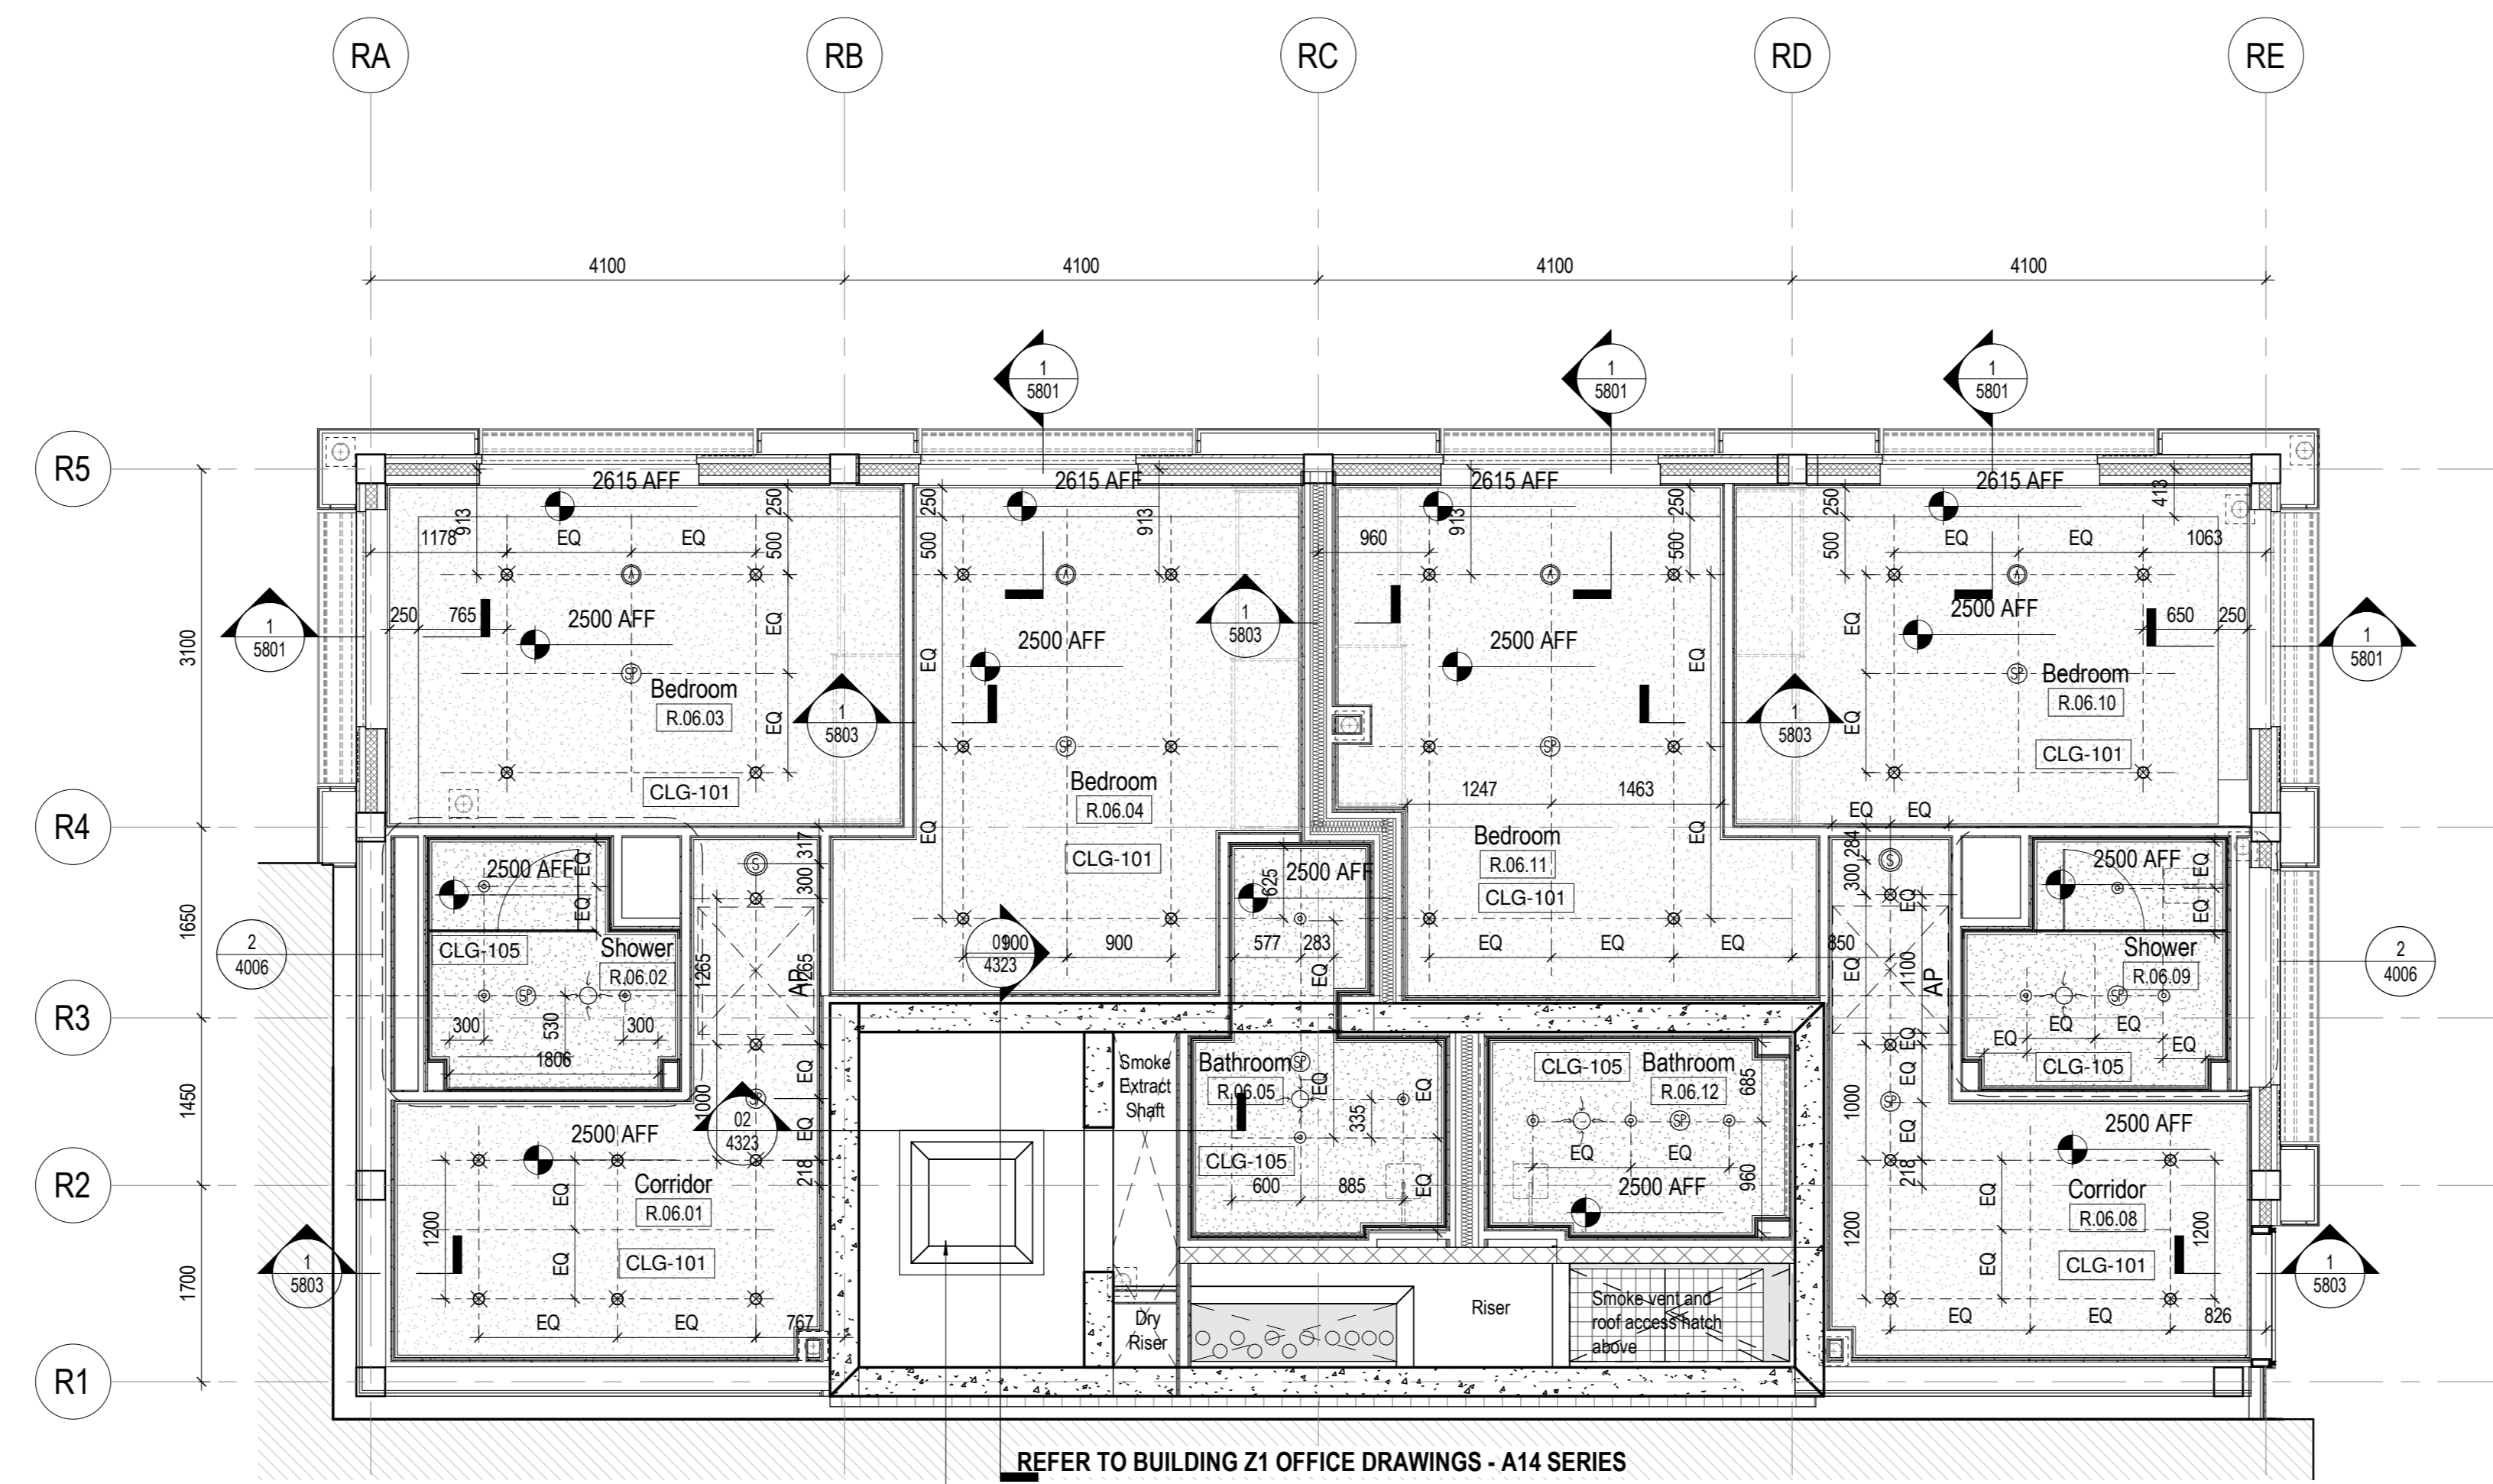


REFER TO BUILDING Z1 OFFICE DRAWINGS - A14 SERIES

Smoke vent hatch connected via plenum to the smoke extract shaft

4 RCP RESI LEVEL 06

1:50 REFER TO THE RELEVANT A40-ENLARGED PLANS DRAWINGS AND A58 SERIES FOR RCP DETAILS
Those drawings are for setting out purposes only, refer to MEP contractual documents for specs and services layouts.

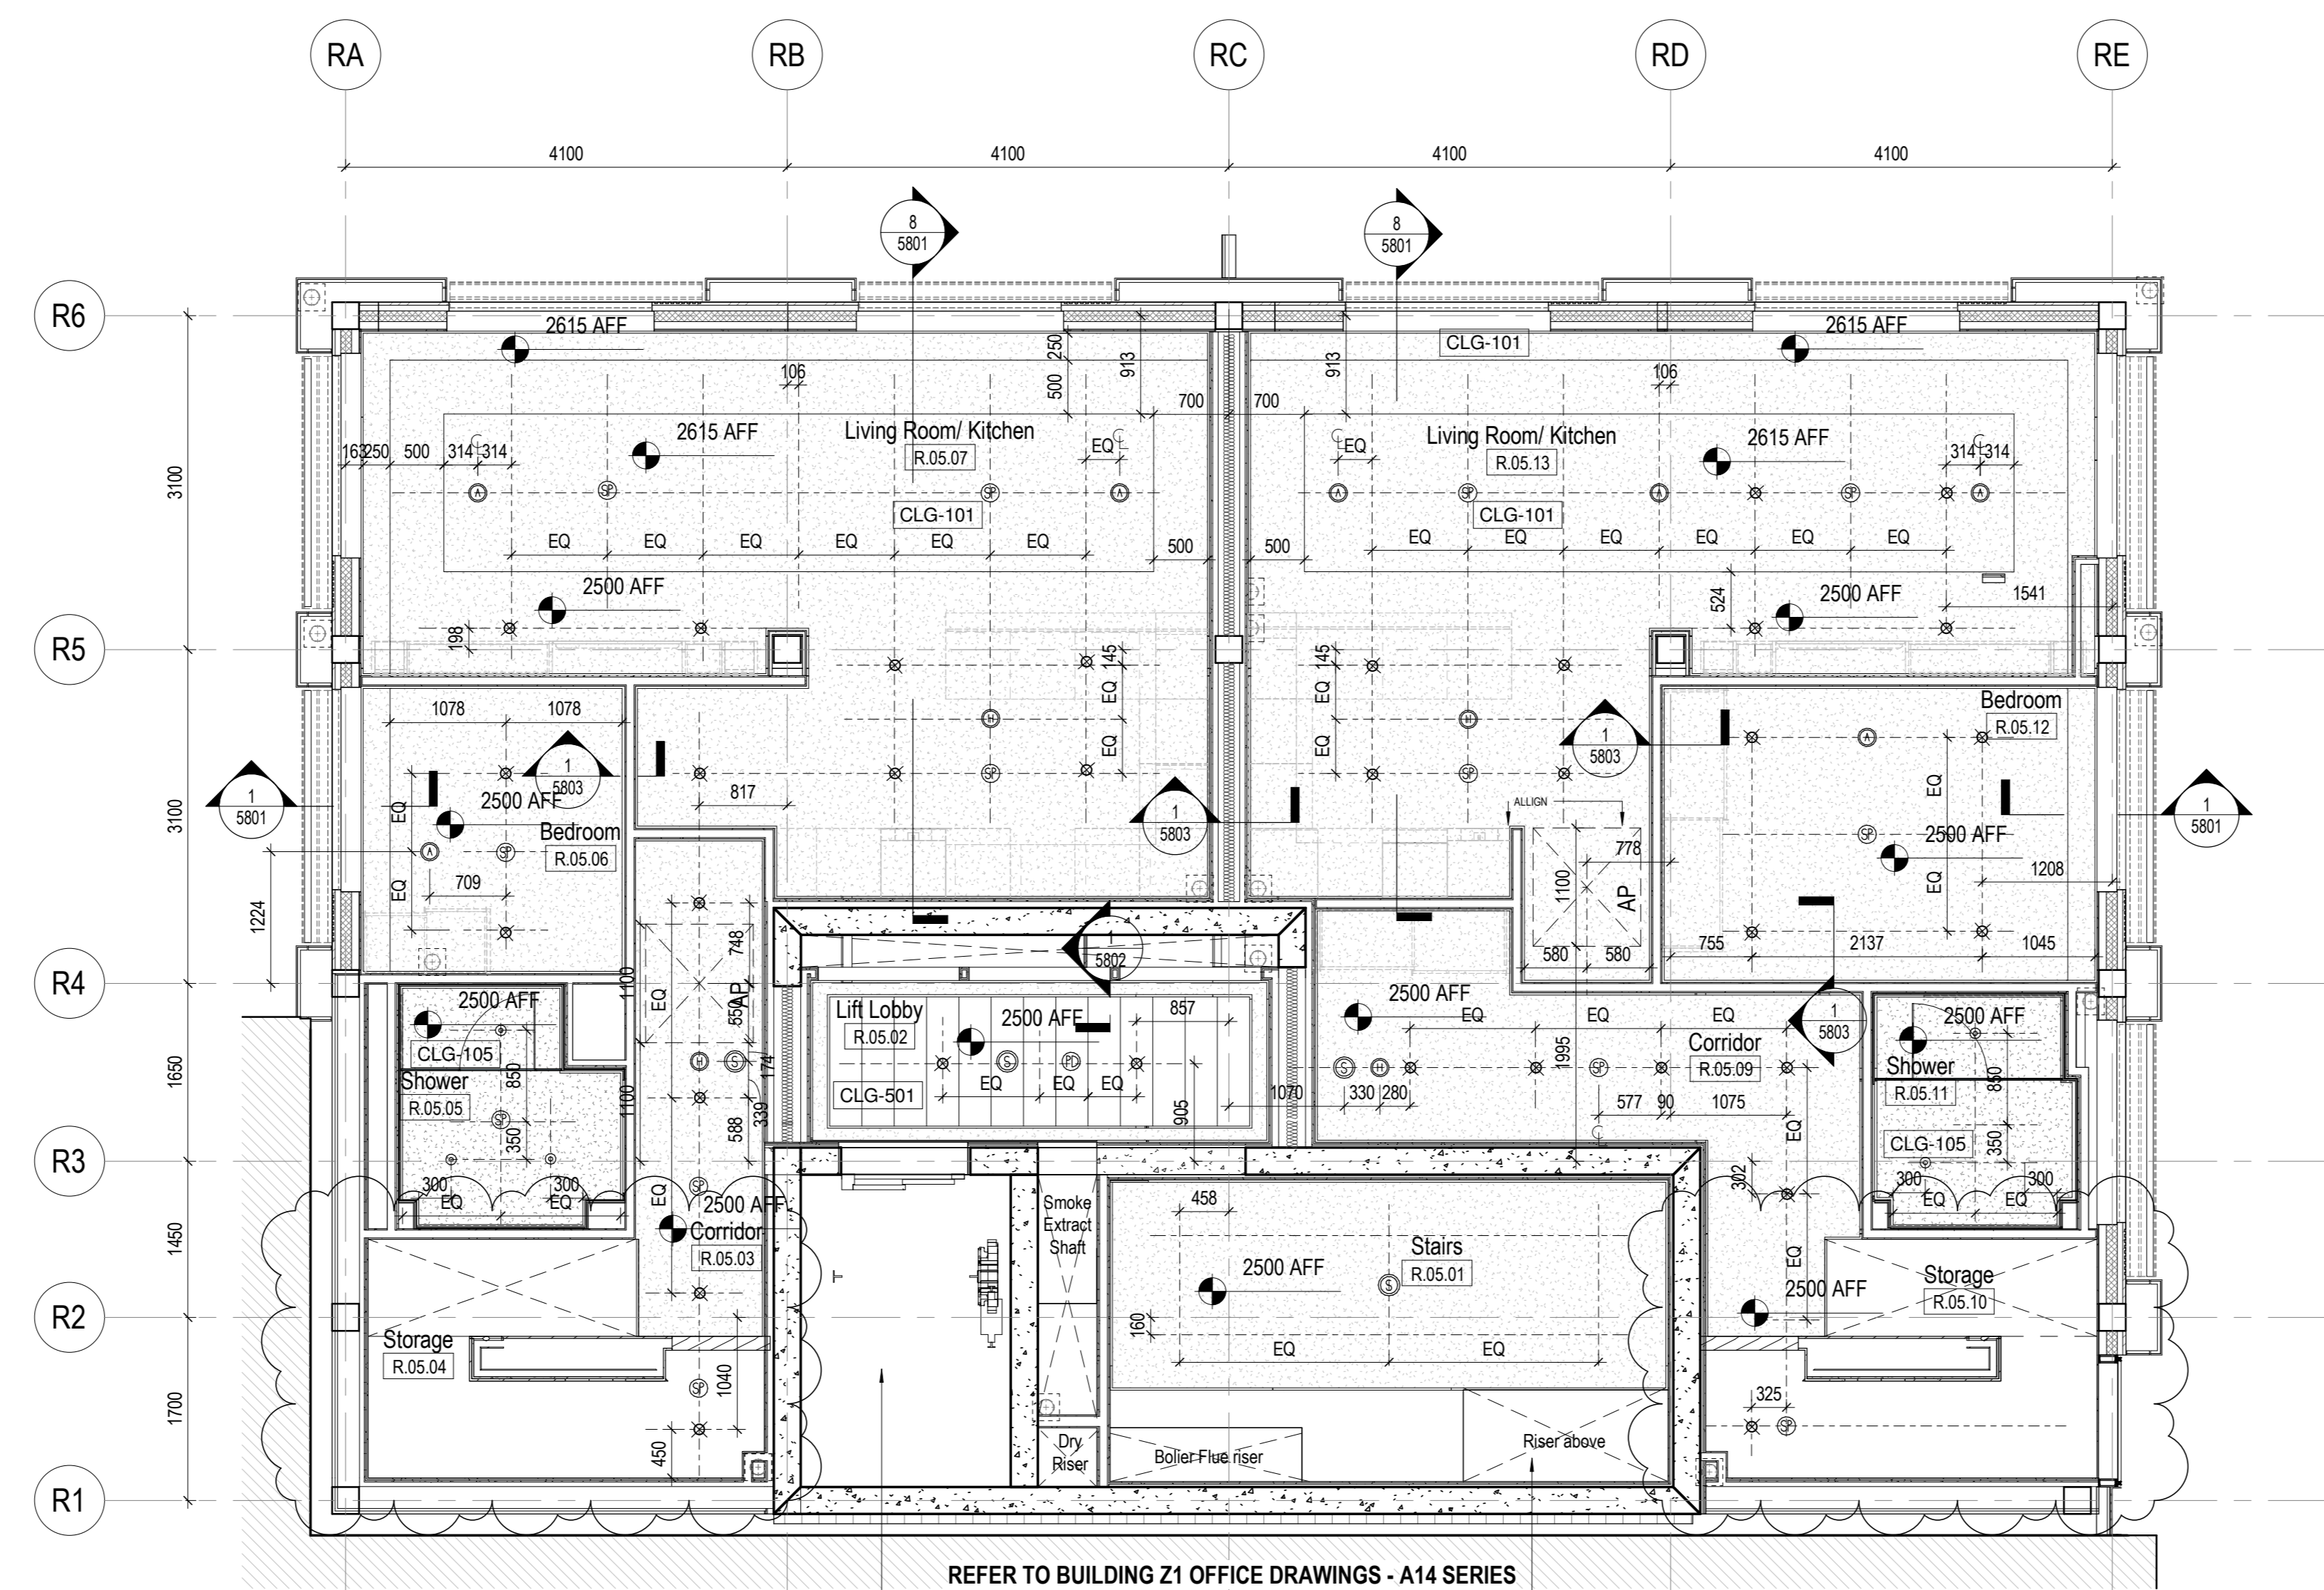

REFER TO BUILDING Z1 OFFICE DRAWINGS - A14 SERIES

Lift Overrun as per Menu recommendations

Roof access and ADV riser

3 RCP RESI LEVEL 05

1:50 REFER TO THE RELEVANT A40-ENLARGED PLANS DRAWINGS AND A58 SERIES FOR RCP DETAILS
Those drawings are for setting out purposes only, refer to MEP contractual documents for specs and services layouts.

SUSPENDED CEILING TYPES LEGEND
FOR CEILING TYPES REFER TO SERIES A14 - REFLECTED CEILING PLANS

SYMBOL	DESCRIPTION
	CLG-101 - PLASTERBOARD CEILING ON MIF SUPPORT FRAME
	CLG-105 - MOISTURE RESISTANT PLASTERBOARD CEILING ON MIF SUPPORT FRAME
	INS-201 - ROCKWOOL SOFFIT SLAB INSULATION WITH RENDER FINISH
	ESS-102 - DURASTEEL SOFFIT WITH BOARDED INSULATION UNDERNEATH RC SLAB
	CLG-501 - 1200 x 300 DEMOUNTABLE METAL CEILING TILE
	ESS-101 - ALUMINIUM SOFFIT PANELS, WITH LIGHTGRAPHIXS LD LINE 25 EXTERIOR LIGHTS NATURAL ANODISED 100A
	EWS-105 - BLACK ANODISED ALUMINIUM PANEL 545

CEILING EQUIPMENT (REFER TO DRAWINGS):

	DOWNLIGHTING
	DOWNLIGHTING FOR BATHROOMS
	WALL LIGHTING FOR UTILITY CUPBOARDS
	WALL MOUNTED LIGHT
	EXTERNAL DOWNLIGHTING
	LIGHTGRAPHIXS LD LINE 25 EXTERIOR, EXTERIOR RATED LED HOMOGENOUS LINE OF LIGHT
	LED STRIP COVE LIGHT TO ELECTRICAL ENGINEER SPECIFICATION
	AUDIO CEILING MOUNTED SPEAKER
	FIRE ALARM SMOKE DETECTOR
	FIRE ALARM HEAT DETECTOR
	SPRINKLER
	PERSON DETECTOR
	EXTRACT DISC
	ACCESS PANEL BELOW MHR UNIT AS MEP DESIGN
	FLUORESCENT LIGHT

OTHER CONSIDERATIONS

- FOR LEGEND - QUANTITY OF ALL LIGHT FITTINGS, SMOKE DETECTORS, SOUNDERS, SPRINKLERS, PIRCS, CAMERAS AND OTHER CEILING EQUIPMENT REFER TO M&E CONSULTANT INFORMATION
- ALL TIMBER PATRESSES USED ABOVE CEILINGS TO BE FSC
- ALL PATRESSES AND OTHER TRACES USED IN CEILING VOIDS TO BE NON-COMBUSTIBLE
- ALL FINISHED CEILING HEIGHTS TO BE CONFIRMED BY CONTRACTORS.

CD	STAGE	DATE
C05	STAGE 05	20/09/22
C04	STAGE 05	20/09/20
C03	STAGE 05	20/09/19
C02	STAGE 05	20/09/18
C01	STAGE 05	20/09/18
PI.4	STAGE 04	20/09/18
PI.3	STAGE 04	20/09/18
PI.2	STAGE 04	20/09/18
PI.1	STAGE 03	20/09/18
W001	GATE	

Date	04/20/18
Job Number	325424
Scale	As indicated
Drawn	Author
Checked	Checker
Approved	Approver

CDE STATUS

STAGE 05 - FOR CONSTRUCTION

TITLE

RCP Levels 05 + 06

SHEET NUMBER

150 PWA Z2 05 DR A 1403

CDE STATUS CODE **A2** REVISION **C05**

