


2 RCP RESI GROUND FLOOR
1:50 REFER TO THE RELEVANT A40-ENLARGED PLANS DRAWINGS AND A58 SERIES FOR RCP DETAILS
Those drawings are for setting out purposes only, refer to MEP contractual documents for specs and services layouts.

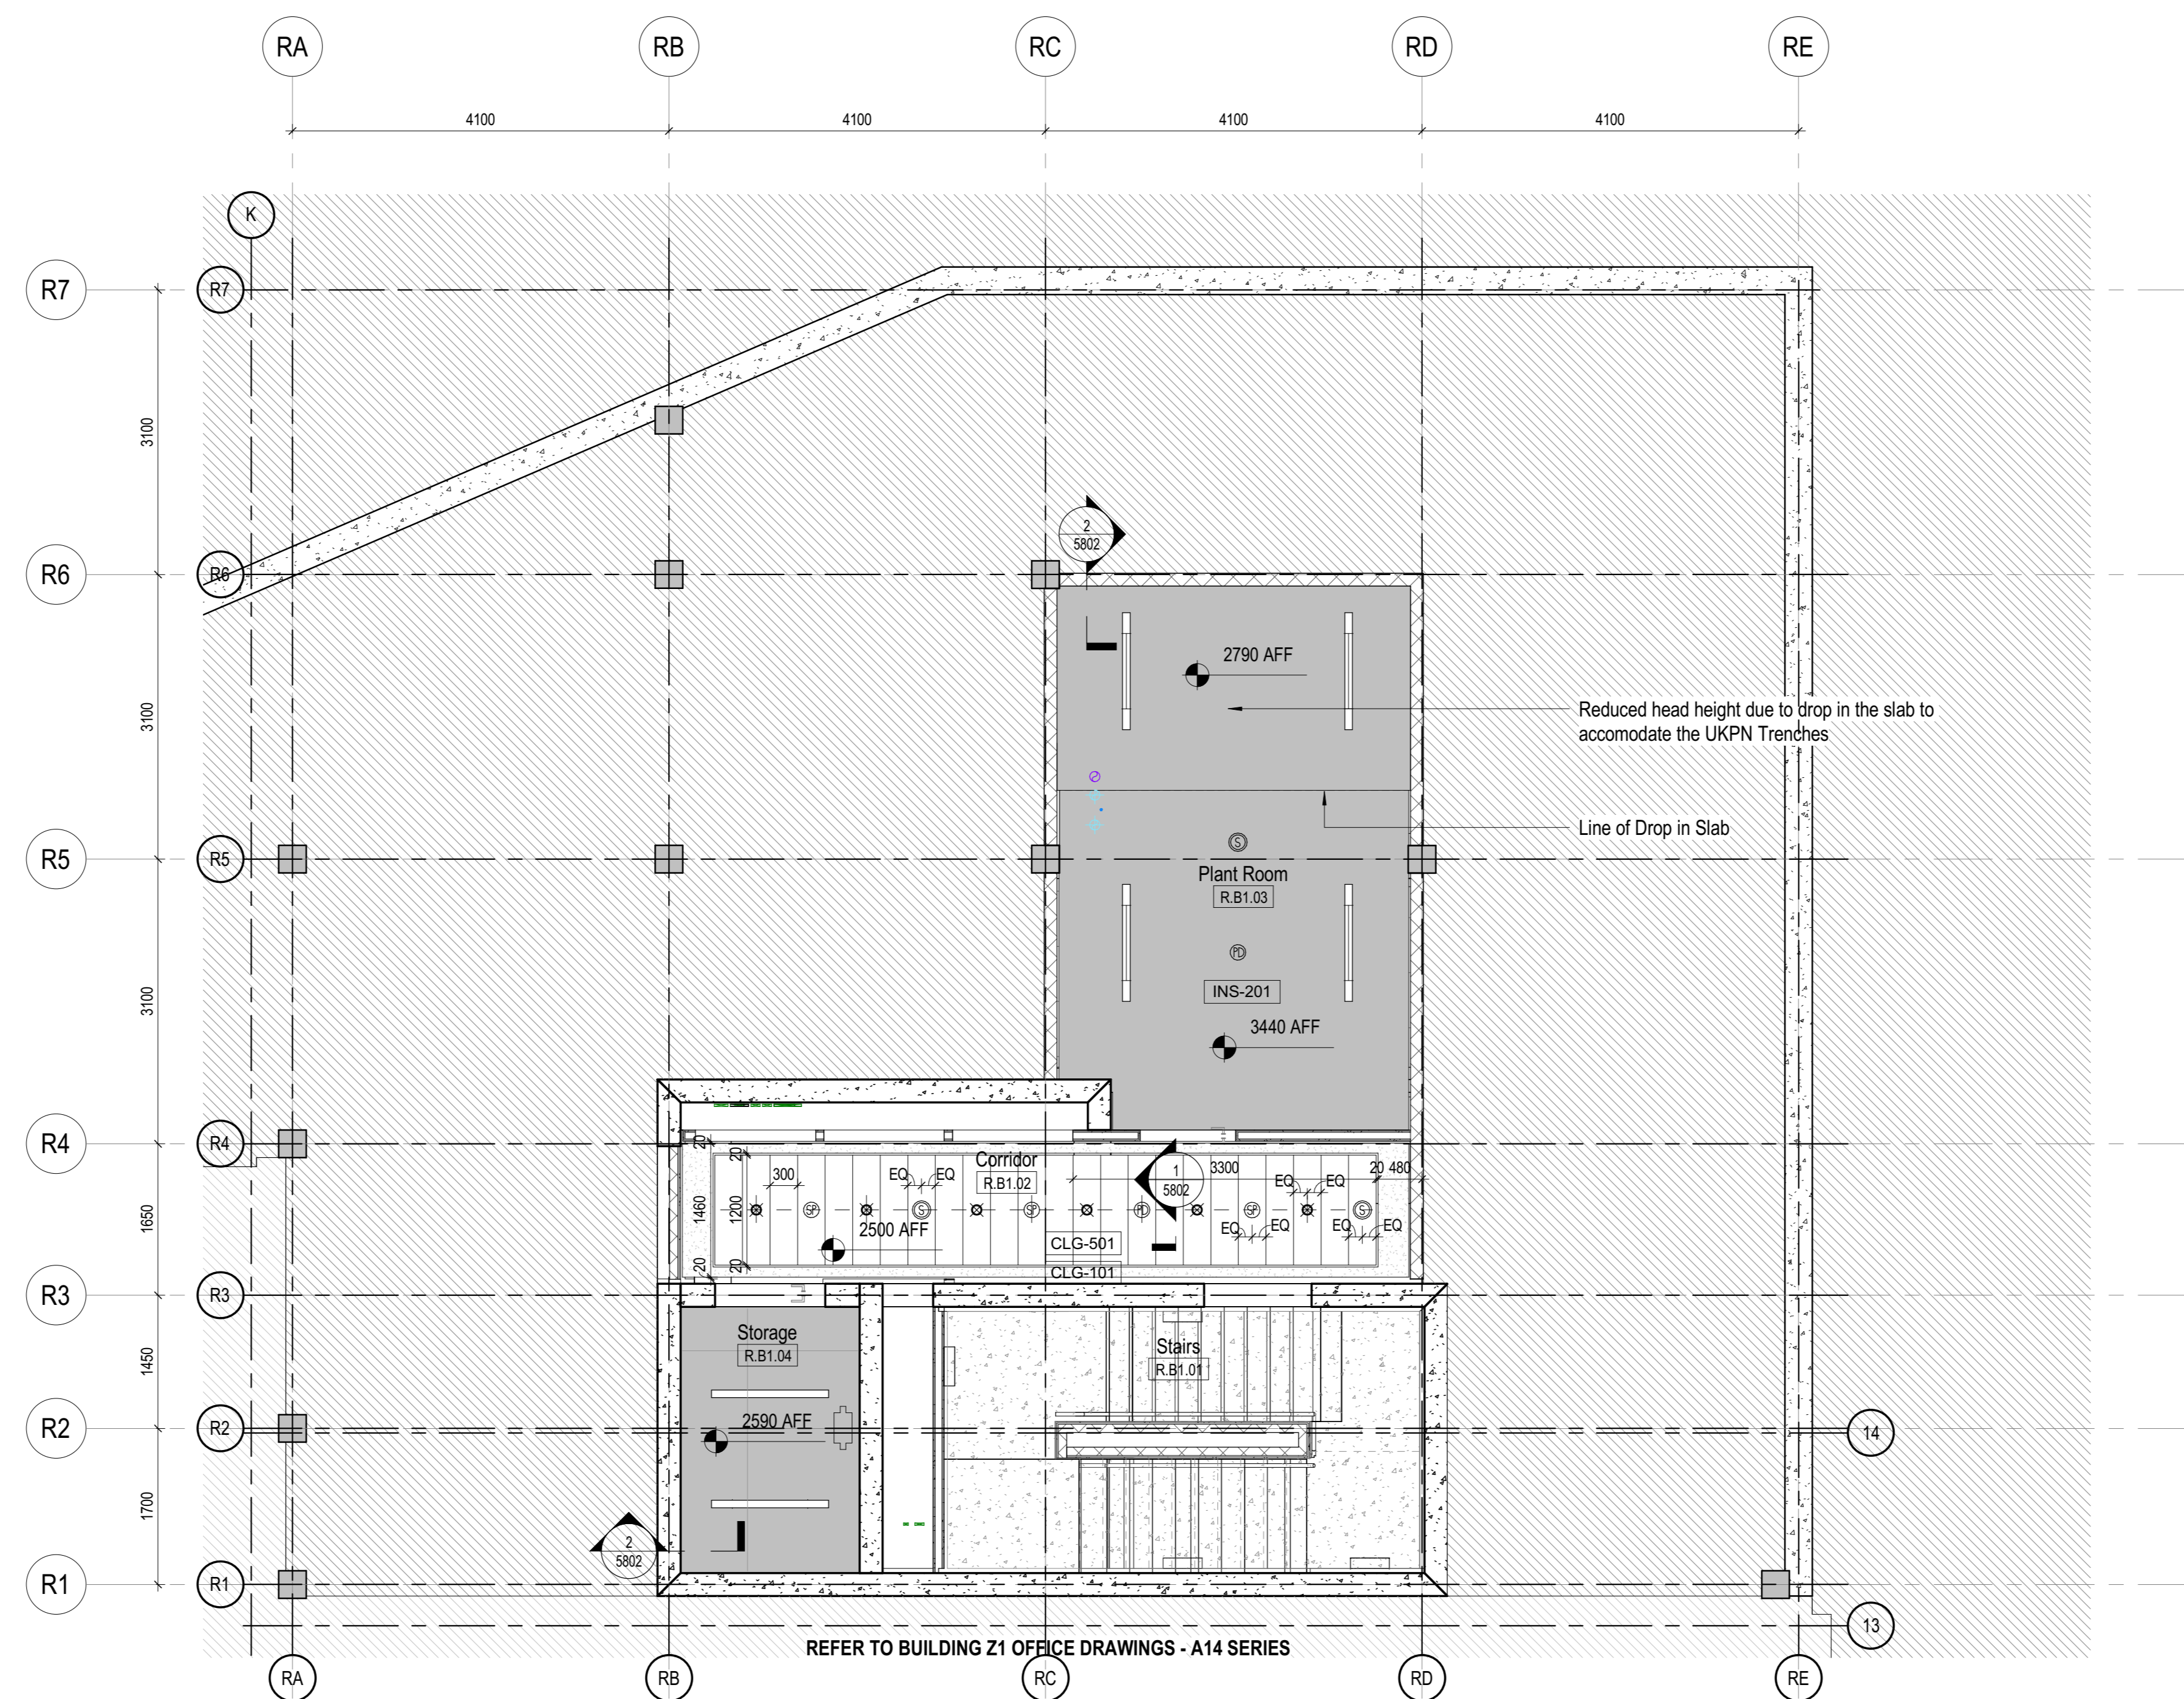

3 RCP BASEMENT LEVEL
1:50 REFER TO THE RELEVANT A40-ENLARGED PLANS DRAWINGS AND A58 SERIES FOR RCP DETAILS
Those drawings are for setting out purposes only, refer to MEP contractual documents for specs and services layouts.

SUSPENDED CEILING TYPES LEGEND
FOR CEILING TYPES REFER TO SERIES A14 - REFLECTED CEILING PLANS

SYMBOL	DESCRIPTION
	CLG-101 - PLASTERBOARD CEILING ON M/F SUPPORT FRAME
	CLG-105 - MOISTURE RESISTANT PLASTERBOARD CEILING ON M/F SUPPORT FRAME
	INS-201 - ROCKWOOL SOFFIT SLAB INSULATION WITH RENOVIS FINISH
	ESS-102 - DURASTEEL SOFFIT WITH BOARDED INSULATION UNDERNEATH RC SLAB
	CLG-501 - 1200 x 300 DEMOUNTABLE METAL CEILING TILE
	ESS-101 - ALUMINIUM SOFFIT PANELS, WITH LIGHTGRAPHIX'S LD LINE 25 EXTERIOR LIGHTS NATURAL ANODISED 100A
	ENS-105 - BLACK ANODISED ALUMINIUM PANEL 545

CEILING EQUIPMENT (REFER TO DRAWINGS):

	DOWNLIGHTING
	DOWNLIGHTING FOR BATHROOMS
	WALL LIGHTING FOR UTILITY CUPBOARDS
	WALL MOUNTED LIGHT
	EXTERNAL DOWNLIGHTING
	LIGHTGRAPHIX'S LD LINE 25 EXTERIOR, EXTERIOR RATED LED HOMOGENOUS LINE OF LIGHT
	LED STRIP COVE LIGHT TO ELECTRICAL ENGINEER SPECIFICATION
	AUDIO CEILING MOUNTED SPEAKER
	FIRE ALARM SMOKE DETECTOR
	FIRE ALARM HEAT DETECTOR
	SPRINKLER
	PERSON DETECTOR
	EXTRACT DISC
	ACCESS PANEL BELOW MHR UNIT AS MEP DESIGN
	FLUORESCENT LIGHT

OTHER CONSIDERATIONS

- FOR LEGEND - QUANTITY OF ALL LIGHT FITTINGS, SMOKE DETECTORS, SOUNDERS, SPRINKLERS, FIRE CAMERAS AND OTHER CEILING EQUIPMENT REFER TO M&E CONSULTANT INFORMATION
- ALL TIMBER PARTISSES USED ABOVE CEILINGS TO BE FSC
- ALL PARTISSES AND OTHER ITEMS USED IN CEILING VOIDS TO BE NON-COMBUSTIBLE
- ALL FINISHED CEILING HEIGHTS TO BE CONFIRMED BY CONTRACTORS.

REV	DATE	DESCRIPTION
C07	STAGE 05	20200731
C06	STAGE 05	20200409
C05	STAGE 05	20200312
C04	STAGE 05	20200203
C03	STAGE 05	20190610
C02	STAGE 05	20190405
C01	STAGE 05	20190308
P1.5	STAGE 04	20180631
P1.4	STAGE 04	20180610
P1.3	STAGE 04	20180420
P1.2	STAGE 04	20180329
P1.1	STAGE 03	20170608
W01	DATE	GATE

Date 04/20/18
Job Number 325424
Scale As indicated
Drawn Author
Checked Checker
Approved Approver

CDE STATUS

STAGE 05 - FOR CONSTRUCTION

TITLE

RCP Basement + Ground Level

SHEET NUMBER

150 PWA Z2 B1 DR A 1400

PRODUCT | AUTHOR | CHECKED | LEVEL | DATE | SCALE | REVISION

CDE STATUS CODE **A2** REVISION **C07**

Copyright © 2016 Perkins+Will

