

- Design Notes:
- Bespoke antenna support frames have been requested by local planning authority as an alternative to std. solutions to minimise visual impact.
 - Bespoke antenna supports to be provided with all required safety features (railings, flooring gates & climbing system)
 - Proposed antenna support climbing system to be confirmed at detailed design stage. Client preference is for a welded lug solution but due to constraints a special design may be required
 - Self closing gates to be provided as required
 - Plinths are to be positioned to avoid canopy overhang.
 - Additional railings provided to ensure no unauthorized access to rooftop exclusion zones

Master:	MBNL / EE / H3G	Project:	NTQ	Purpose of Issue:	Issue:
M007	MBNL	NTQ	GA	F	
Date:	26/08/2020	Revision / Upgrade Description:	Handrail amended to provide safe access to 150mm cable tray on roof edge		
Drawn:	A.Bailey	Checked:	S.Lavrenko	Approved:	F.Walters
Master:	MBNL / EE / H3G	Project:	NTQ	Purpose of Issue:	Issue:
M006	MBNL	NTQ	GA	E	
Date:	06/08/2020	Revision / Upgrade Description:	General Arrangement - Site Design Revised For HAA solution		
Drawn:	A.Bailey	Checked:	S.Lavrenko	Approved:	F.Walters
Master:	MBNL / EE / H3G	Project:	NTQ	Purpose of Issue:	Issue:
M005	MBNL	NTQ	DD	D1	
Date:	02/04/2020	Revision / Upgrade Description:	Detailed Design Issue as per RDS Dated: 04/02/2020		
Drawn:	A.Bailey	Checked:	S.Lavrenko	Approved:	F.Walters
Master:	MBNL / EE / H3G	Project:	NTQ	Purpose of Issue:	Issue:
M004	MBNL	NTQ	PA	D	
Date:	02/03/2020	Revision / Upgrade Description:	PA Issue		
Drawn:	A.Bailey	Checked:	S.Lavrenko	Approved:	F.Walters
Master:	MBNL / EE / H3G	Project:	NTQ	Purpose of Issue:	Issue:
M003	MBNL	NTQ	GA	C	
Date:	13/02/2020	Revision / Upgrade Description:	Drawings Revised - Transmission dish details added		
Drawn:	A.Bailey	Checked:	S.Lavrenko	Approved:	F.Walters



Hutchinson 3G UK Limited
Site Name: 3G Central House
Maidenhead, SL6 1TH
Tel: 01753 700000
Fax: 01753 700001

Hatfield Business Park
Hatfield
Hertfordshire
AL10 9BW
Tel: 01707 315000
Fax: 01707 319001



Mobile Broadband Network Limited
Sixth Floor, Thames Tower, Station Road, Reading, RG1 1LX

Design Consultant & Principal Contractor:



WALDON TELECOM
PHOENIX HOUSE
PYRFORD ROAD
WEST BYFLEET
SURREY
KT14 6RA
TEL: 01932 411011
FAX: 01932 411012

172 TO 202 MAIDEN LANE

1520594

172 TO 202 MAIDEN LANE
CAMDEN
LONDON
LONDON NW1 REGENTS PARK
NW1 9UQ

215 MAX CONFIGURATION SITE PLAN

NTQ

GENERAL ARRANGEMENT


98883

CMN209

N0513

1520594_CMN209_98883_N0513_M007

F

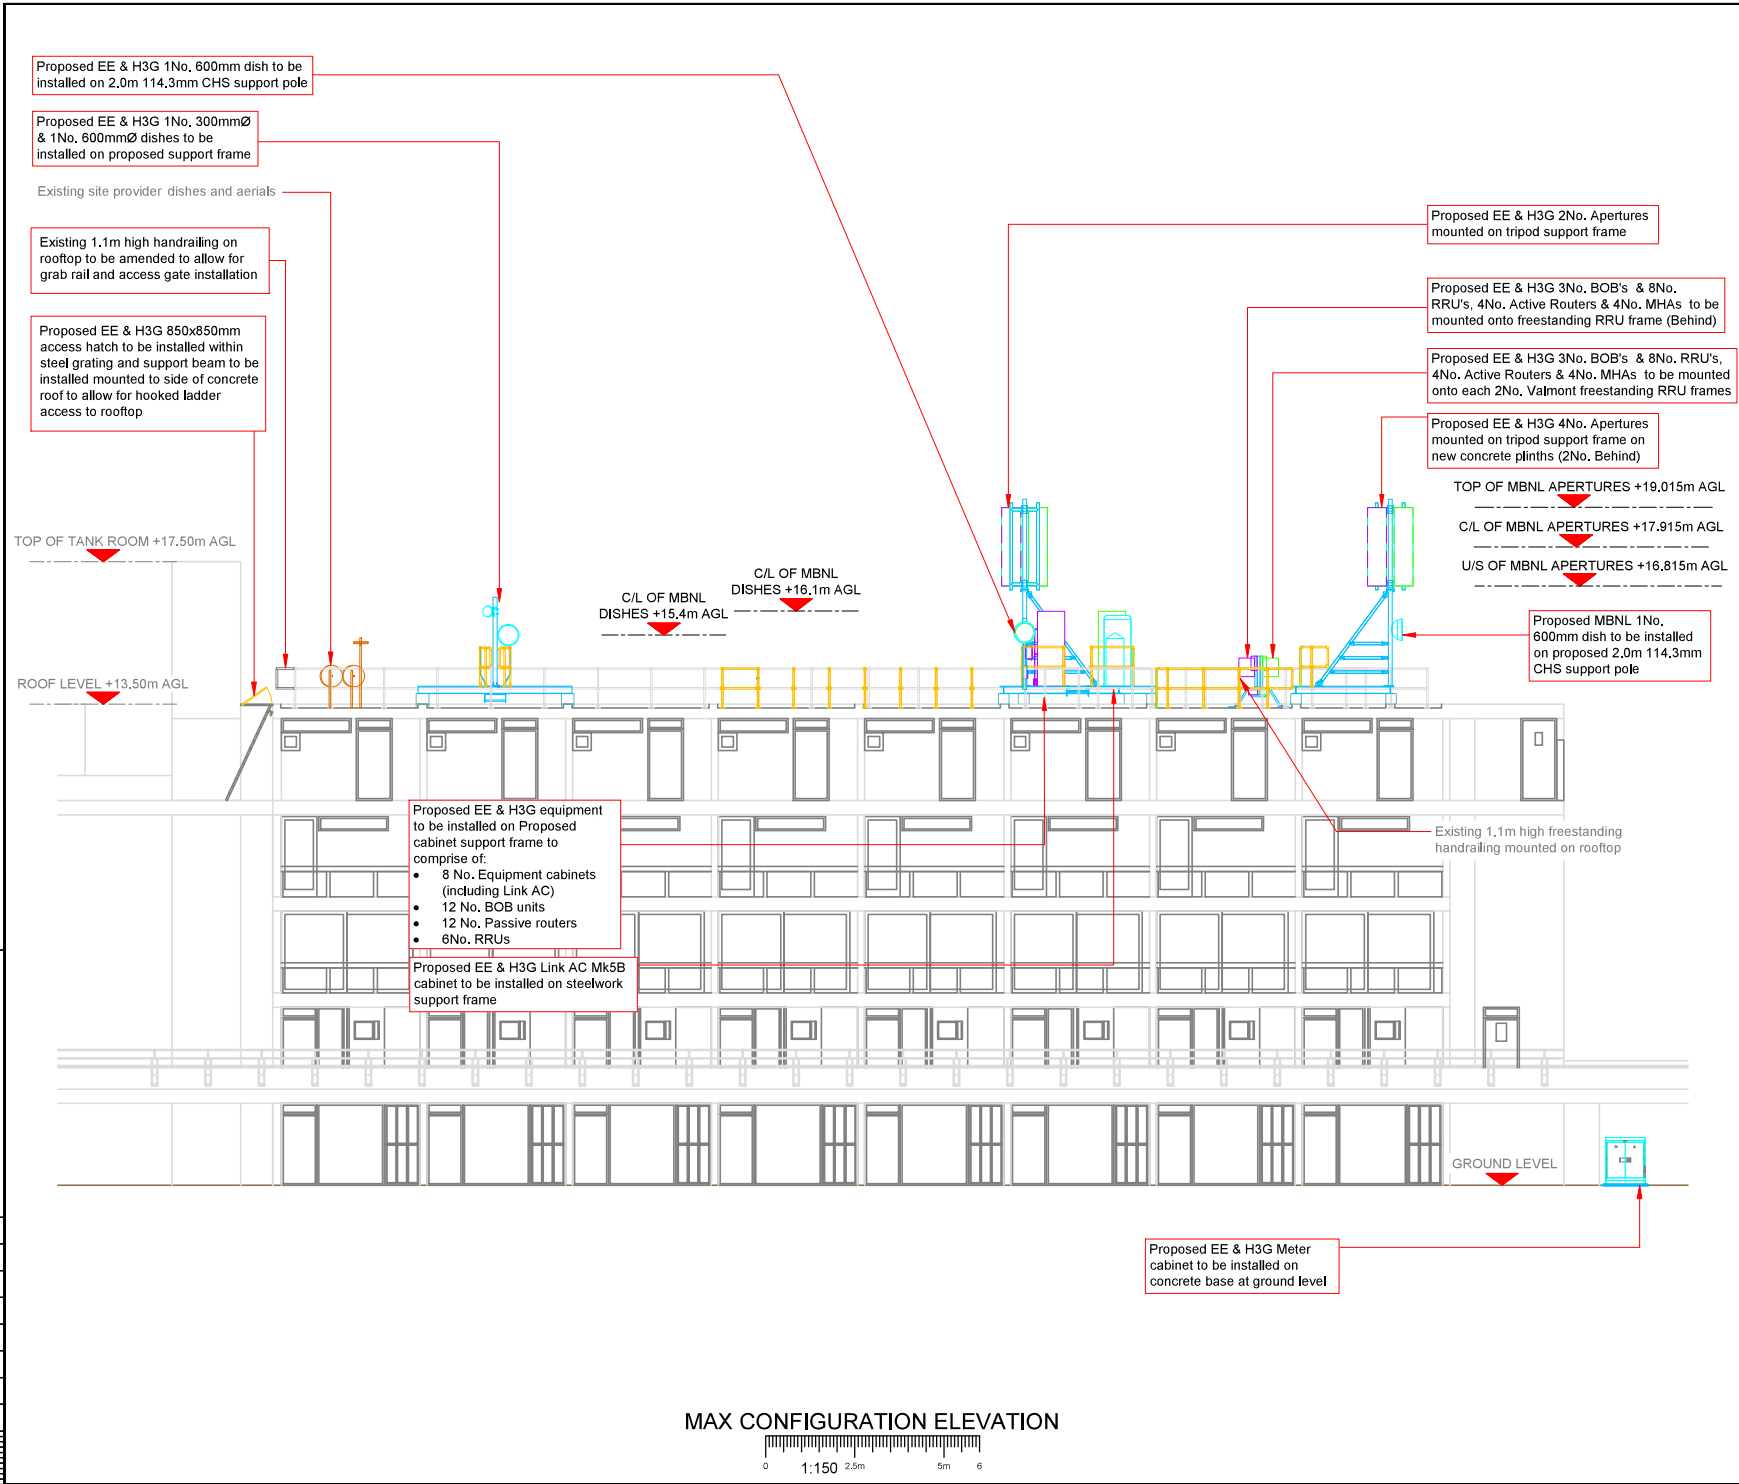

Master	MBNL / EE / H3G	Project	Purpose of Issue	Issue
M007	MBNL	NTQ	GA	F
Revision / Upgrade Description: Handrail amended to provide safe access to 150mm cable tray on roof edge				
Checked	S.J. Lawrence			
Approved	F. Waters			
Master	MBNL / EE / H3G	Project	Purpose of Issue	Issue
M006	MBNL	NTQ	GA	E
Revision / Upgrade Description: General Arrangement - Site Design Revised for H3G solution Response antenna solutions provided as per LPA request				
Checked	S.J. Lawrence			
Approved	F. Waters			
Master	MBNL / EE / H3G	Project	Purpose of Issue	Issue
M005	MBNL	NTQ	DD	D1
Revision / Upgrade Description: Detailed Design Issue as per RDS Dated: 04/02/2020				
Checked	S.J. Lawrence			
Approved	F. Waters			
Master	MBNL / EE / H3G	Project	Purpose of Issue	Issue
M004	MBNL	NTQ	PA	D
Revision / Upgrade Description: PA Issue				
Checked	S.J. Lawrence			
Approved	F. Waters			
Master	MBNL / EE / H3G	Project	Purpose of Issue	Issue
M003	MBNL	NTQ	GA	C
Revision / Upgrade Description: Drawings Revised - Transmission dish details added				
Checked	S.J. Lawrence			
Approved	F. Waters			

Hutchison 3G UK Limited
Site House, 25 Gresham Road
Maidenhead, SL6 1DH
Tel: 01753 781 000
Fax: 01753 781 001
H3G Base Station Information Line
0844 604300
A to B 888 London Monday to Friday

H3G Base Station Information Line
0844 604300
A to B 888 London Monday to Friday

Hatchfield Business Park
Hatchfield
Hertfordshire
AL10 9BW
Tel: 01707 315000
Fax: 01707 319001

Mobile Broadband Network Limited
Sixth Floor, Thames Tower, Station Road, Reading, RG1 1LX

Design Consultant & Principal Contractor:

WALDON TELECOM
PHOENIX HOUSE
PYRFORD ROAD
WEST BYFLEET
SURREY
KT14 6RA
TEL: 01932 411011
FAX: 01932 411012

172 TO 202 MAIDEN LANE

1520594

172 TO 202 MAIDEN LANE
CAMDEN
LONDON
LONDON NW1 REGENTS PARK
NW1 9UQ

265-A MAX CONFIGURATION ELEVATION

NTQ

GENERAL ARRANGEMENT


98883	CMN209	N0513
-------	--------	-------

1520594_CMN209_98883_N0513_M007	F
---------------------------------	---

100mm

150mm

100mm

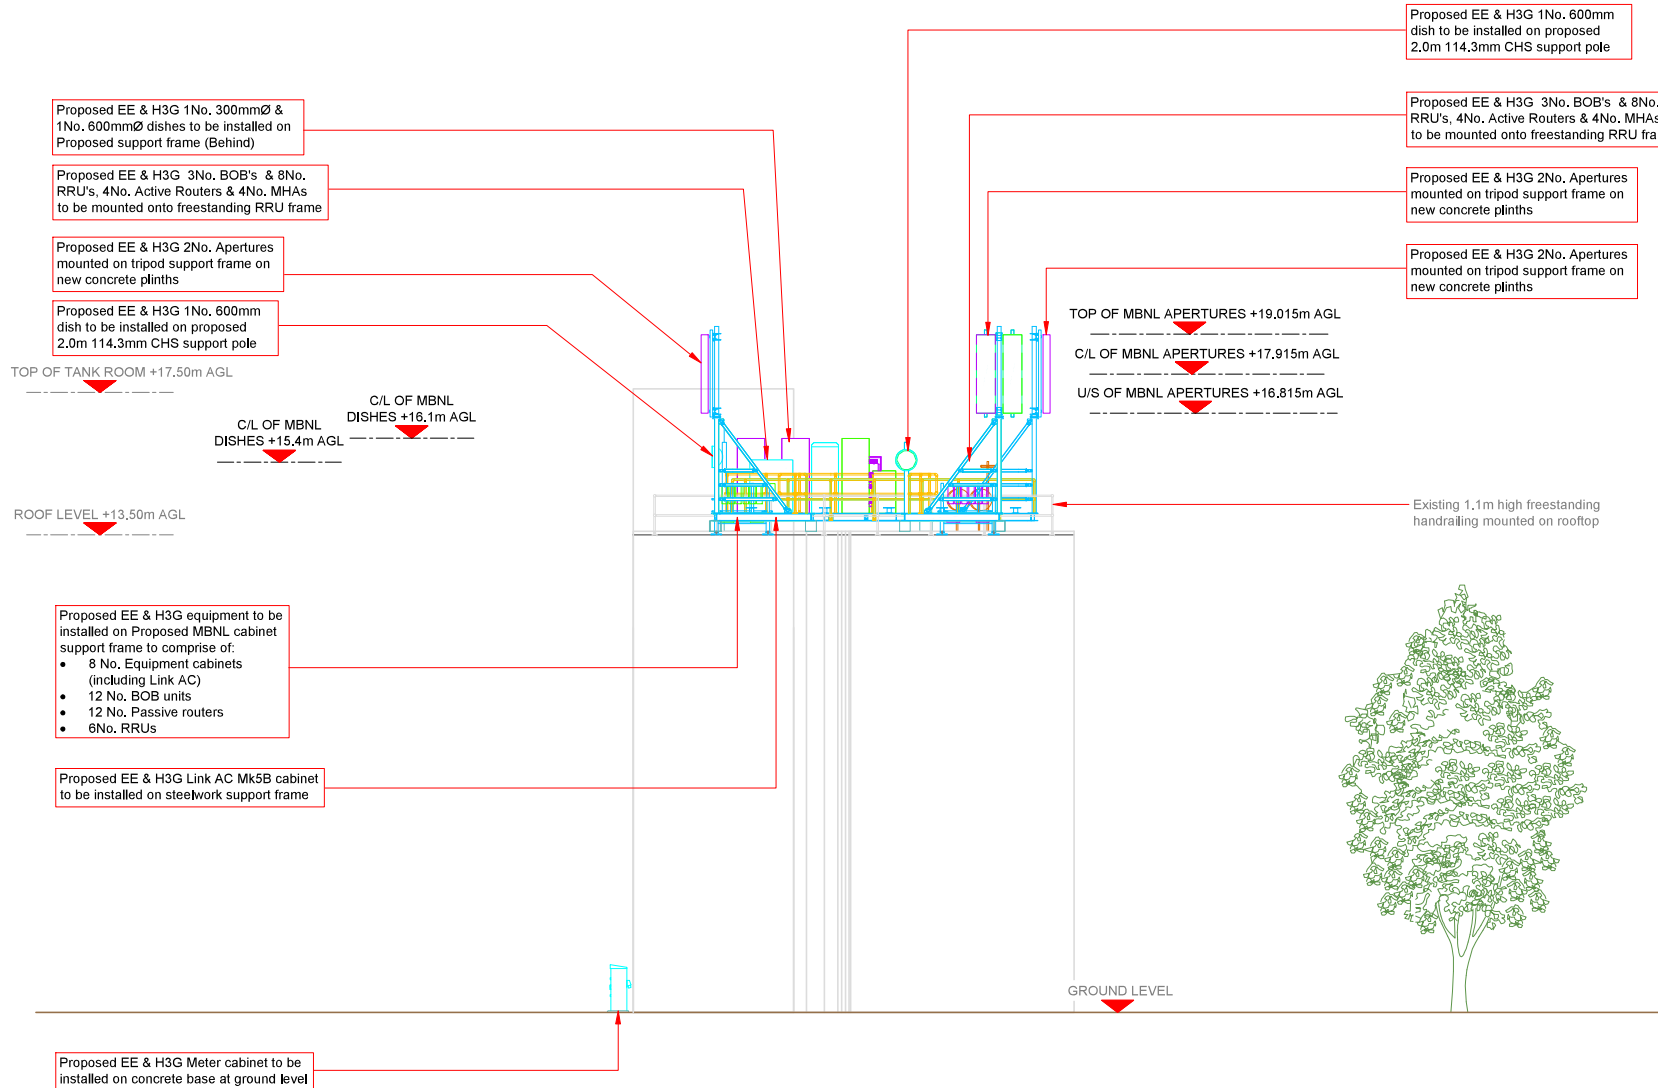

Master	MBNL / EE / H3G	Project	NTQ	Purpose of Issue	GA	Issue	F
M007	MBNL	NTQ	GA	F			
Date	26/08/2020	Revision / Upgrade Description:					
Drawn	A Bailey	General Arrangement - Site Design Revised For HAA solution					
Checked	S J Lawrence	Bespoke antenna solutions provided as per LPA request					
Approved	F. Waters						
Master	MBNL / EE / H3G	Project	NTQ	Purpose of Issue	GA	Issue	E
M006	MBNL	NTQ	GA	E			
Date	06/08/2020	Revision / Upgrade Description:					
Drawn	S J Lawrence	General Arrangement - Site Design Revised For HAA solution					
Checked	A Bailey	Bespoke antenna solutions provided as per LPA request					
Approved	F. Waters						
Master	MBNL / EE / H3G	Project	NTQ	Purpose of Issue	DD	Issue	D1
M005	MBNL	NTQ	DD	D1			
Date	02/04/20	Revision / Upgrade Description:					
Drawn	A Bailey	Detailed Design Issue as per RDS Dated: 04/02/2020					
Checked	S J Lawrence						
Approved	F. Waters						
Master	MBNL / EE / H3G	Project	NTQ	Purpose of Issue	PA	Issue	D
M004	MBNL	NTQ	PA	D			
Date	02/03/20	Revision / Upgrade Description:					
Drawn	A Bailey	PA Issue					
Checked	S J Lawrence						
Approved	F. Waters						
Master	MBNL / EE / H3G	Project	NTQ	Purpose of Issue	GA	Issue	C
M003	MBNL	NTQ	GA	C			
Date	13/02/20	Revision / Upgrade Description:					
Drawn	S J Lawrence	Drawings Revised - Transmission dish details added					
Checked	A Bailey						
Approved	F. Waters						



Hutchison 3G UK Limited
Site House 25 Goshall Road
Maldenhead, SL4 1DH
Tel: 01932 761 000
Fax: 01932 761 001
H3G Base Station Information Line
0840 0643000
A+B-BB Monday to Friday



Hatfield Business Park
Hatfield
Hertfordshire
AL10 9BW
Tel: 01707 315000
Fax: 01707 315001



Mobile Broadband Network Limited
Sixth Floor, Thames Tower, Station Road, Reading, RG1 1LX

Design Consultant & Principal Contractor:



WALDON TELECOM
PHOENIX HOUSE
PYRFORD ROAD
WEST BYFLEET
SURREY
KT14 6RA
TEL : 01932 411011
FAX : 01932 411012

172 TO 202 MAIDEN LANE

1520594

172 TO 202 MAIDEN LANE
CAMDEN
LONDON
LONDON NW1 REGENTS PARK
NW1 9UQ

265-B MAX CONFIGURATION ELEVATION

NTQ

GENERAL ARRANGEMENT


98883




CMN209


N0513

1520594_CMN209_98883_N0513_M007

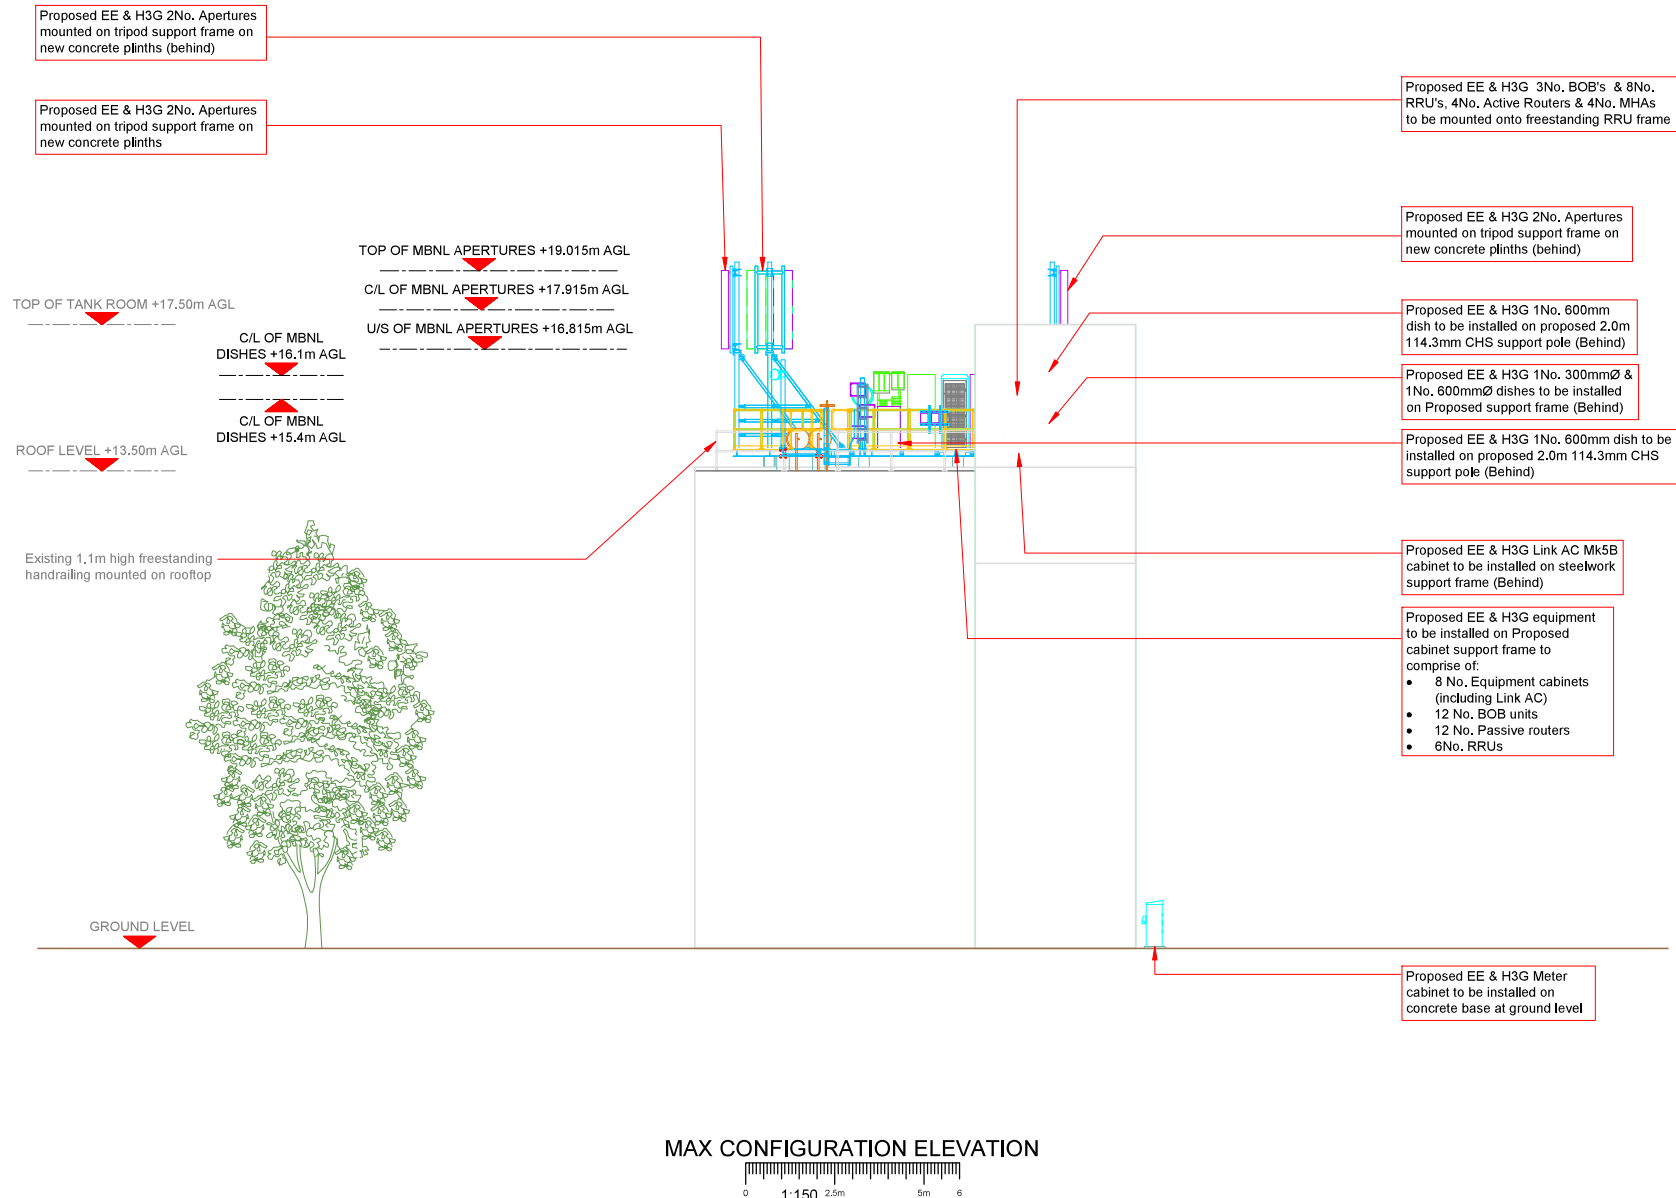F



Issue	MBNL / EE / H3G	Project	Purpose of Issue		Issue
M007	MBNL	NTQ	GA		F
Date	26/08/2020	Revision / Upgrade Description			
Drawn	A.Bailey	Handrail amended to provide safe access to 150mm cable tray on roof edge			
Checked	S.Lavence	Project			
Approved	F.Walters	Purpose of Issue		Issue	
Issue	MBNL / EE / H3G	Project	Purpose of Issue		Issue
M006	MBNL	NTQ	GA		E
Date	06/08/2020	Revision / Upgrade Description			
Drawn	S.Lavence	General Arrangement - Site Design Revised For HAA solution			
Checked	A.Bailey	Bespoke antenna solutions provided as per LPA request			
Approved	F.Walters	Purpose of Issue		Issue	
Issue	MBNL / EE / H3G	Project	Purpose of Issue		Issue
M005	MBNL	NTQ	DD		D1
Date	02/04/20	Revision / Upgrade Description			
Drawn	S.Lavence	Detailed Design Issue as per RDS Dated: 04/02/2020			
Checked	A.Bailey	Purpose of Issue		Issue	
Approved	F.Walters	Project	Purpose of Issue		Issue
Issue	MBNL / EE / H3G	Project	Purpose of Issue		Issue
M004	MBNL	NTQ	PA		D
Date	02/03/20	Revision / Upgrade Description			
Drawn	A.Bailey	PA Issue			
Checked	S.Lavence	Purpose of Issue		Issue	
Approved	F.Walters	Project	Purpose of Issue		Issue
Issue	MBNL / EE / H3G	Project	Purpose of Issue		Issue
M003	MBNL	NTQ	GA		C
Date	13/02/20	Revision / Upgrade Description			
Drawn	A.Bailey	Drawings Revised - Transmission dish details added			
Checked	S.Lavence	Project			
Approved	F.Walters	Project			
<div><div></div><div><div>Hutchison 3G UK Limited Site House, 32 Grenfell Road Maidenhead, SL6 6DY T4: 04420 765 980 F4: 01462 765 990 Fax: 01462 765 990</div><div>H3G New Station Information Line 0844 504 5060 24x7x365 (Monday to Friday)</div></div><div><div></div><div>Hatfield Business Park Hatfield Hertfordshire AL10 9BW</div><div>Tel 01707 315001 Fax: 01707 319001</div></div></div>					
MBNL Mobile Broadband Network Limited Sixth Floor, Thames Tower, Station Road, Reading, RG1 1LX					
Design Consultant & Principal Contractor:					
		WALDON TELECOM PHOENIX HOUSE PYRFORD ROAD WEST BYFLEET SURREY KT14 6RA TEL : 01932 411011 FAX : 01932 411012			
172 TO 202 MAIDEN LANE					
1520594					
172 TO 202 MAIDEN LANE CAMDEN LONDON LONDON NW1 REGENTS PARK NW1 9UQ					
265-C MAX CONFIGURATION ELEVATION					
NTQ					
GENERAL ARRANGEMENT					
98883		CMN209		N0513	
1520594_CMN209_98883_N0513_M007					F

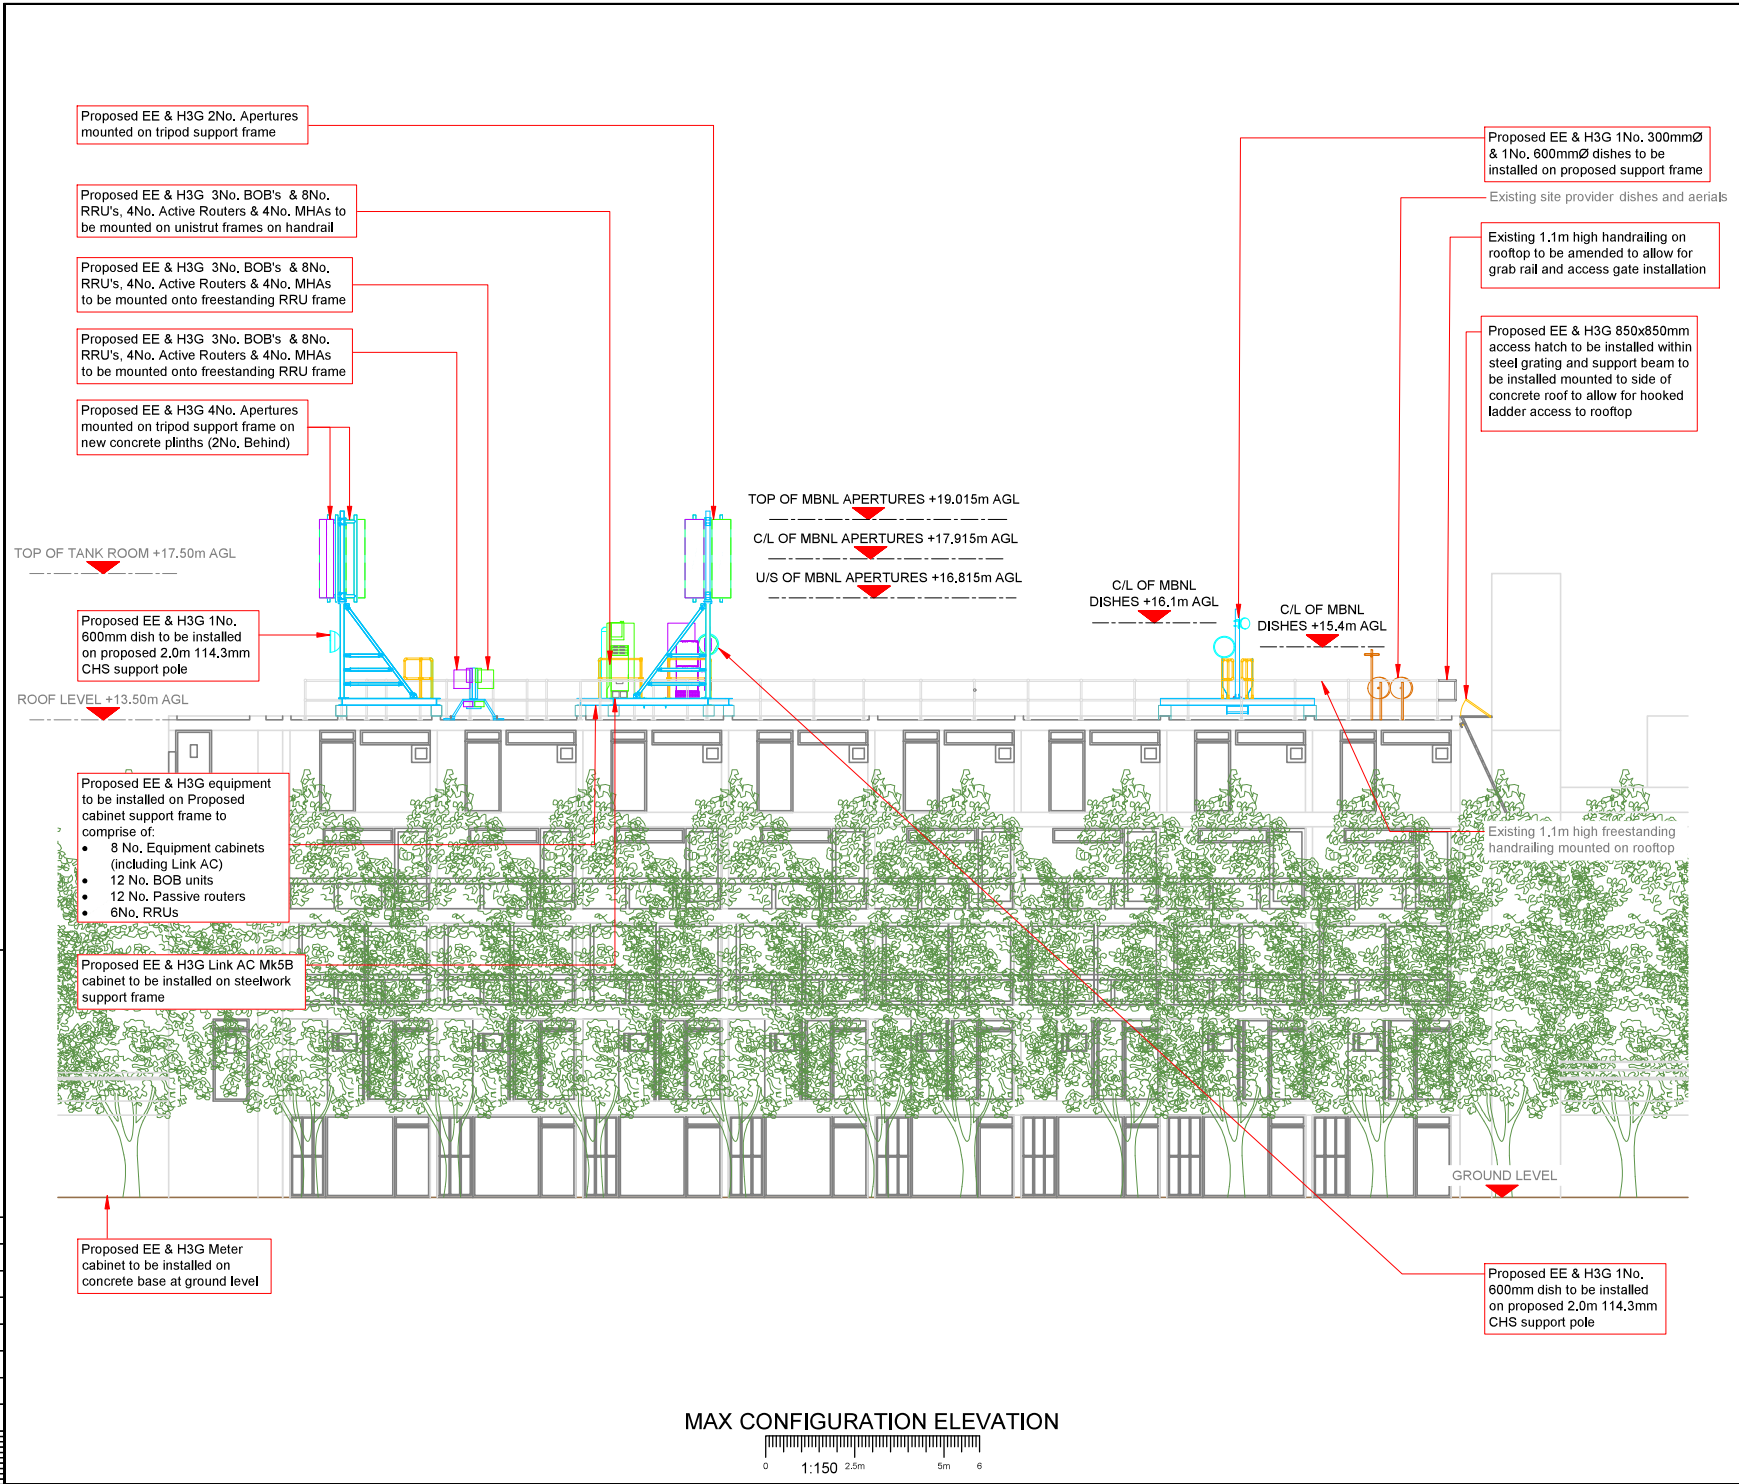

Master	MBNL / EE / H3G	Project	NTQ	Purpose of Issue	GA	Issue	F
M007	MBNL	NTQ	GA	F			
Date	26/08/2020	Revision / Upgrade Description:					
Drawn	A Bailey	Handrail amended to provide safe access to 150mm cable tray on roof edge					
Checked	S J Lawrence						
Approved	F. Waters						
Master	MBNL / EE / H3G	Project	NTQ	Purpose of Issue	GA	Issue	E
M006	MBNL	NTQ	GA	E			
Date	06/08/2020	Revision / Upgrade Description:					
Drawn	S J Lawrence	General Arrangement - Site Design Revised For H3A solution					
Checked	A Bailey	Response antenna solutions provided as per LPA request					
Approved	F. Waters						
Master	MBNL / EE / H3G	Project	NTQ	Purpose of Issue	DD	Issue	D1
M005	MBNL	NTQ	DD	D1			
Date	02/04/20	Revision / Upgrade Description:					
Drawn	A Bailey	Detailed Design Issue as per RDS Dated: 04/02/2020					
Checked	S J Lawrence						
Approved	F. Waters						
Master	MBNL / EE / H3G	Project	NTQ	Purpose of Issue	PA	Issue	D
M004	MBNL	NTQ	PA	D			
Date	02/03/20	Revision / Upgrade Description:					
Drawn	A Bailey	PA Issue					
Checked	S J Lawrence						
Approved	F. Waters						
Master	MBNL / EE / H3G	Project	NTQ	Purpose of Issue	GA	Issue	C
M003	MBNL	NTQ	GA	C			
Date	13/02/20	Revision / Upgrade Description:					
Drawn	S J Lawrence	Drawings Revised - Transmission dish details added					
Checked	A Bailey						
Approved	F. Waters						

Hutchison 3G UK Limited
Site Name: 02 Goshell Road
Maidenhead, SL6 1TH
Tel: 01753 761000
Fax: 01753 761001
H3G Site Status Information Line
0440 004000
A-B-E-B Hutchison Wireless in Priority

H3G Site Status Information Line
0440 004000
A-B-E-B Hutchison Wireless in Priority

Hatchfield Business Park
Hatchfield
Hertfordshire
AL10 9BW
Tel: 01707 315000
Fax: 01707 319001

MBNL	Mobile Broadband Network Limited Sixth Floor, Thames Tower, Station Road, Reading, RG1 1LX	
Design Consultant & Principal Contractor:		
	WALDON TELECOM PHOENIX HOUSE PYRFORD ROAD WEST BYFLEET SURREY KT14 6RA TEL: 01932 411011 FAX: 01932 411012	
172 TO 202 MAIDEN LANE		
1520594		
172 TO 202 MAIDEN LANE CAMDEN LONDON LONDON NW1 REGENTS PARK NW1 9UQ		
265-D MAX CONFIGURATION ELEVATION		
NTQ		
GENERAL ARRANGEMENT		
98883	CMN209	N0513
1520594_CMN209_98883_N0513_M007		F