


LEGEND	
TYPE	DESCRIPTION
SP3	Miniature spike mounted spotlight 3000K / 31° / IP67
EM5	Emergency wall light
LCP	Lighting Control Plate

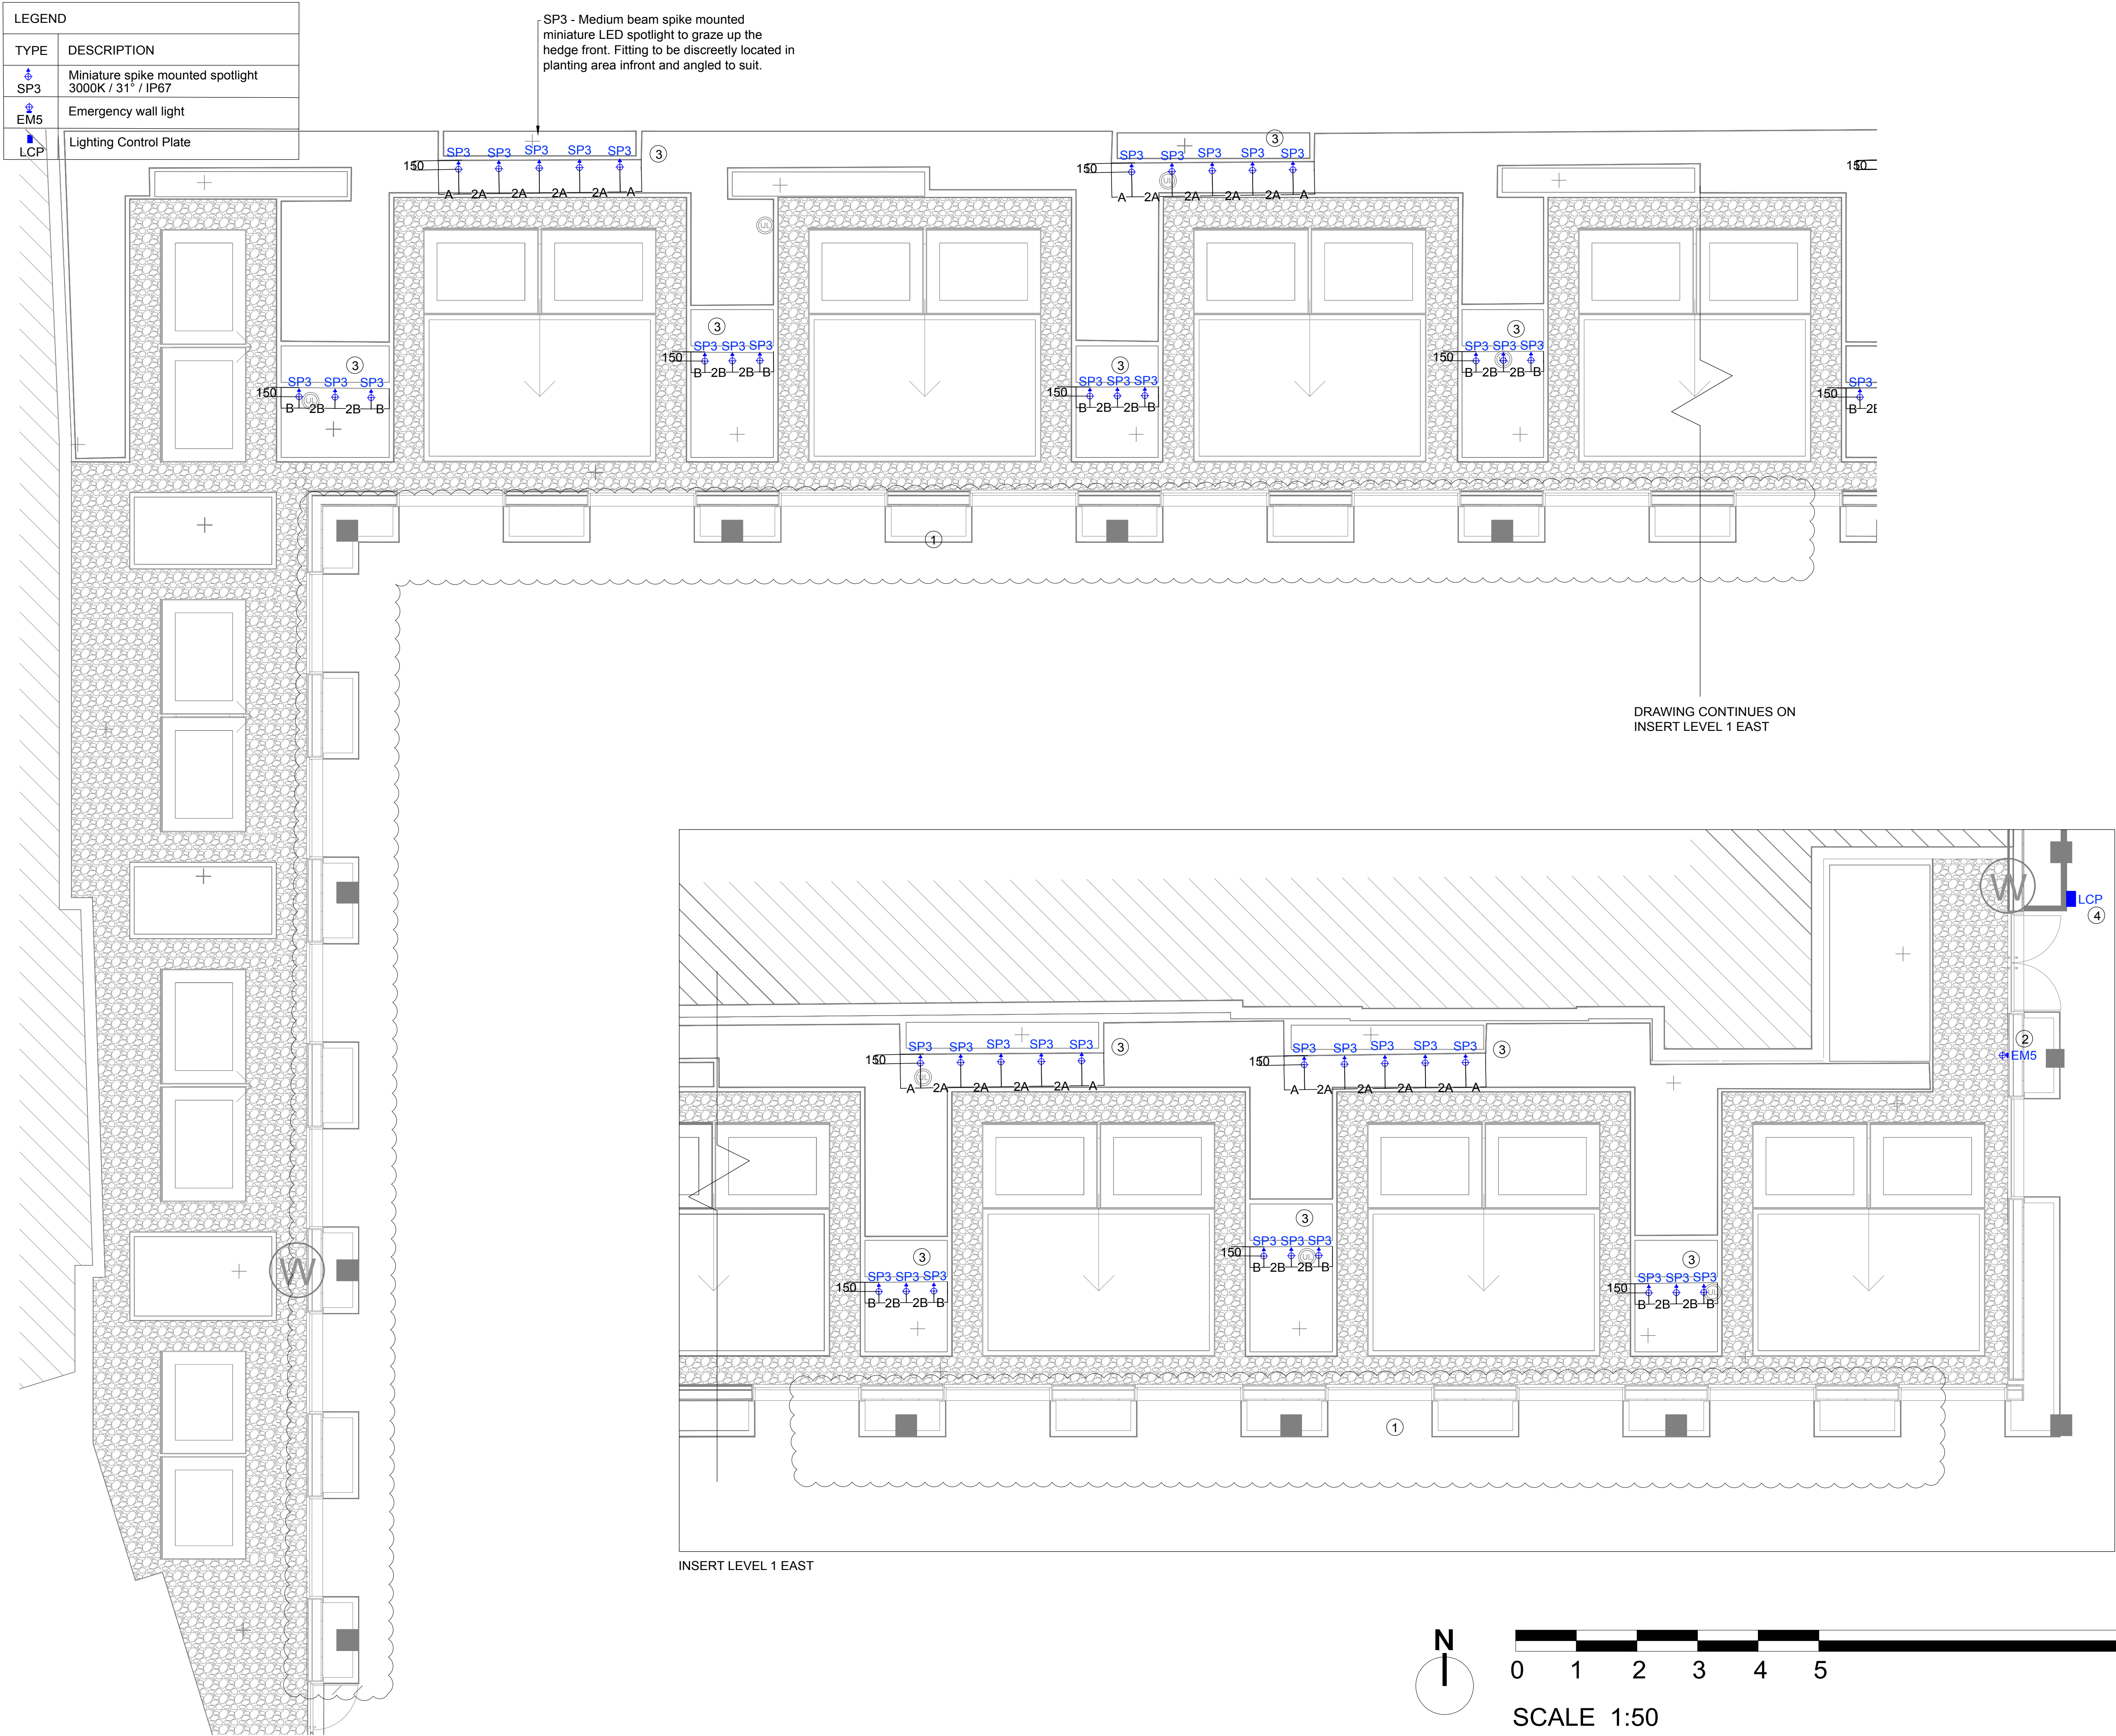

04.09.20	D	Scale bar and North arrow added for planning
17.07.20	C1	Updated notes and lighting control plate location
03.07.20	C	Updated landscape background and setting out added
29.05.20	B	Revised emergency lighting
09.11.18	A	Updated to match planting layout
10.07.18	-	Draft Stage 4

Date	Rev	Description
------	-----	-------------

Notes

- Please refer to drawing 0164-221 for locations of emergency luminaires to Level 1 terrace.
- Reference EM5 is a maintained emergency wall light. Fitting is to be located on the vertical brick piers. Please refer to MBA drawings for setting out information. Fitting to be located on the architectural control system but to be switched off in the evening.
- Drivers for SP3 are remote and can have up to 13 fittings on one driver. Drivers can be located up to 50m away, it is suggested drivers for these fittings are located internally within the pocket gardens accessible landlord cupboard. Please refer to luminaire schedule for driver dimensions.
- Suggested location for lighting control plate for terrace lighting for tenant override if required. Client and MBA to confirm final location.

Important Note

Where Dimensions are not given, drawings must not be scaled.

For complete luminaire breakdown refer to schedules

In the event of conflict between this drawing and lead consultants drawing the matter must be referred prior to proceeding

Careful positioning of spike mounted luminaires to ensure they do not penetrate the drainage layers.

Drawings to be read in conjunction with The Landscape Partnership Detailed Planting Drawings. Luminaire locations based on TLP drawings, if locations of planting differs from that indicated on Studio 29's drawings the matter must be referred prior to proceeding with any electrical works for lighting.

Emergency wall lights have integral drivers and DALI reporting emergency battery packs which form part of the Lutron system for monitoring

Please refer to MBA drawings for final setting out

CLIENT	Lazari Investments Ltd	
PROJECT	Stephenson House, 75 Hampstead road, London, NW1 2PL	PROJECT NO. 0164
STATUS	For Planning	
SCALE	1:50 @ A1 1:100 @ A3	DATE 10/07/2018
TITLE	Exterior Terraces Level 1	
DRAWING NO.	0164-220	REVISION D