


SKIRTINGS DECORATED IN JF05 THROUGHOUT

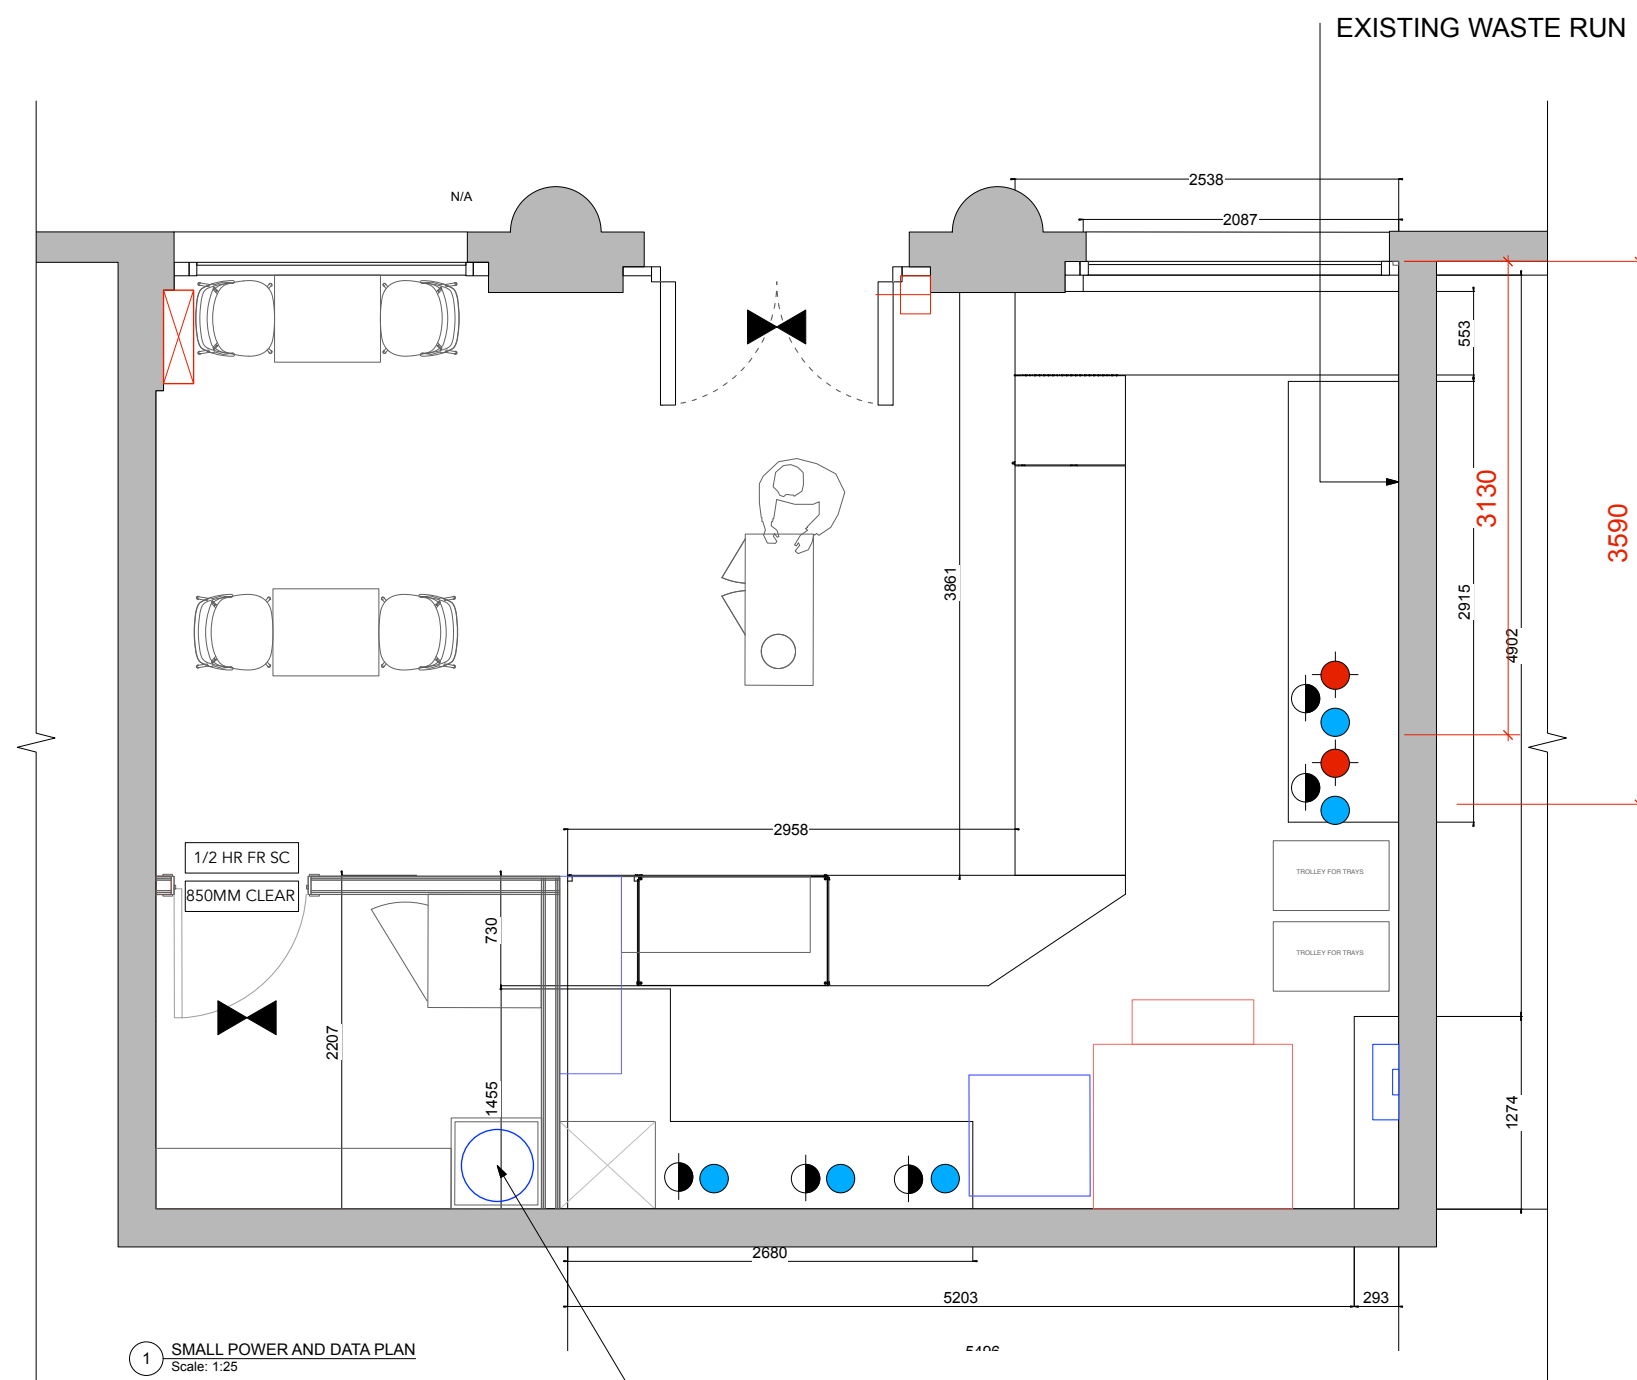

KEY - SERVICES	
	HOT WATER 15MM PIPE
	COLD WATER 15MM PIPE
	50MM WASTE PIPE
	100MM NEW SOIL PIPE
	100MM EXISTING SOIL PIPE

1 SMALL POWER AND DATA PLAN
Scale: 1:25



INDICATES 180LTR UNVENTED HOT WATER CYLINDER - PLUMBER/MAIN CONTRACTOR TO CONFIRM SPEC

REVISIONS:		
CODE	DATE	DESCRIPTION

PROJECT NO: 1029 CLIENT/PROJECT: Cafe de Nata Camden

SITE ADDRESS:
Cafe de Nata
Units 209/210 Market Hall
London
xxx

DATE: 03/02/2020 DRAWN: GP CHECKED: SH SCALE: 1:25@A1, 1:50@A3

TITLE:
PLUMBING

STATUS:
FINAL DESIGN INTENT

DWG. NO: 1029_108 REV:

RAVEN
collective
e: sara@ravencollective.co.uk t:07732 692348