

NOTES:

THIS DRAWING MUST NOT BE SCALED. ALL SETTING OUT MUST BE CHECKED ON SITE. ALL DIMENSIONS MUST BE CHECKED ON SITE. THIS DRAWING MUST BE READ IN CONJUNCTION WITH THE RELEVANT SPECIFICATION CLAUSES. THIS DRAWING MUST NOT BE USED FOR LAND TRANSFER PURPOSES.
COPYRIGHT OF LEECH GROUP SERVICES, LEECH MECHANICAL SERVICES & POSITIVE FACILITIES MAINTENANCE

LEECH

GROUP SERVICES

Unit 17, Mapledean Works,
Maldon Road, Latchingdon,
Essex, CM3 6LG
Tel: +44 (0)1621 742424.
Email: help@leechgroupservices.co.uk
www.leechgroupservices.co.uk

Rev	Rev by	Description	Date
H.			
G.			
F.			
E.			
D.			
C.	DCC	Revised as per comments	26.10.2020
B.	DCC	Revised as per comments	06.03.2020
A.	DCC	Revised as per comments	04.03.2020

PROJECT:
Cafe de Nata
Camden
Units 209/210
Market Hall, London

TITLE:
Proposed Air Conditioning
and Ventilation layout

PROJECT NUMBER: P0000106


DATE: 31/01/2020

DRAWN BY: MS

CHECKED BY: ML

DRAWING NO: P0000106/001 Rev C

SCALE 1:50@A3

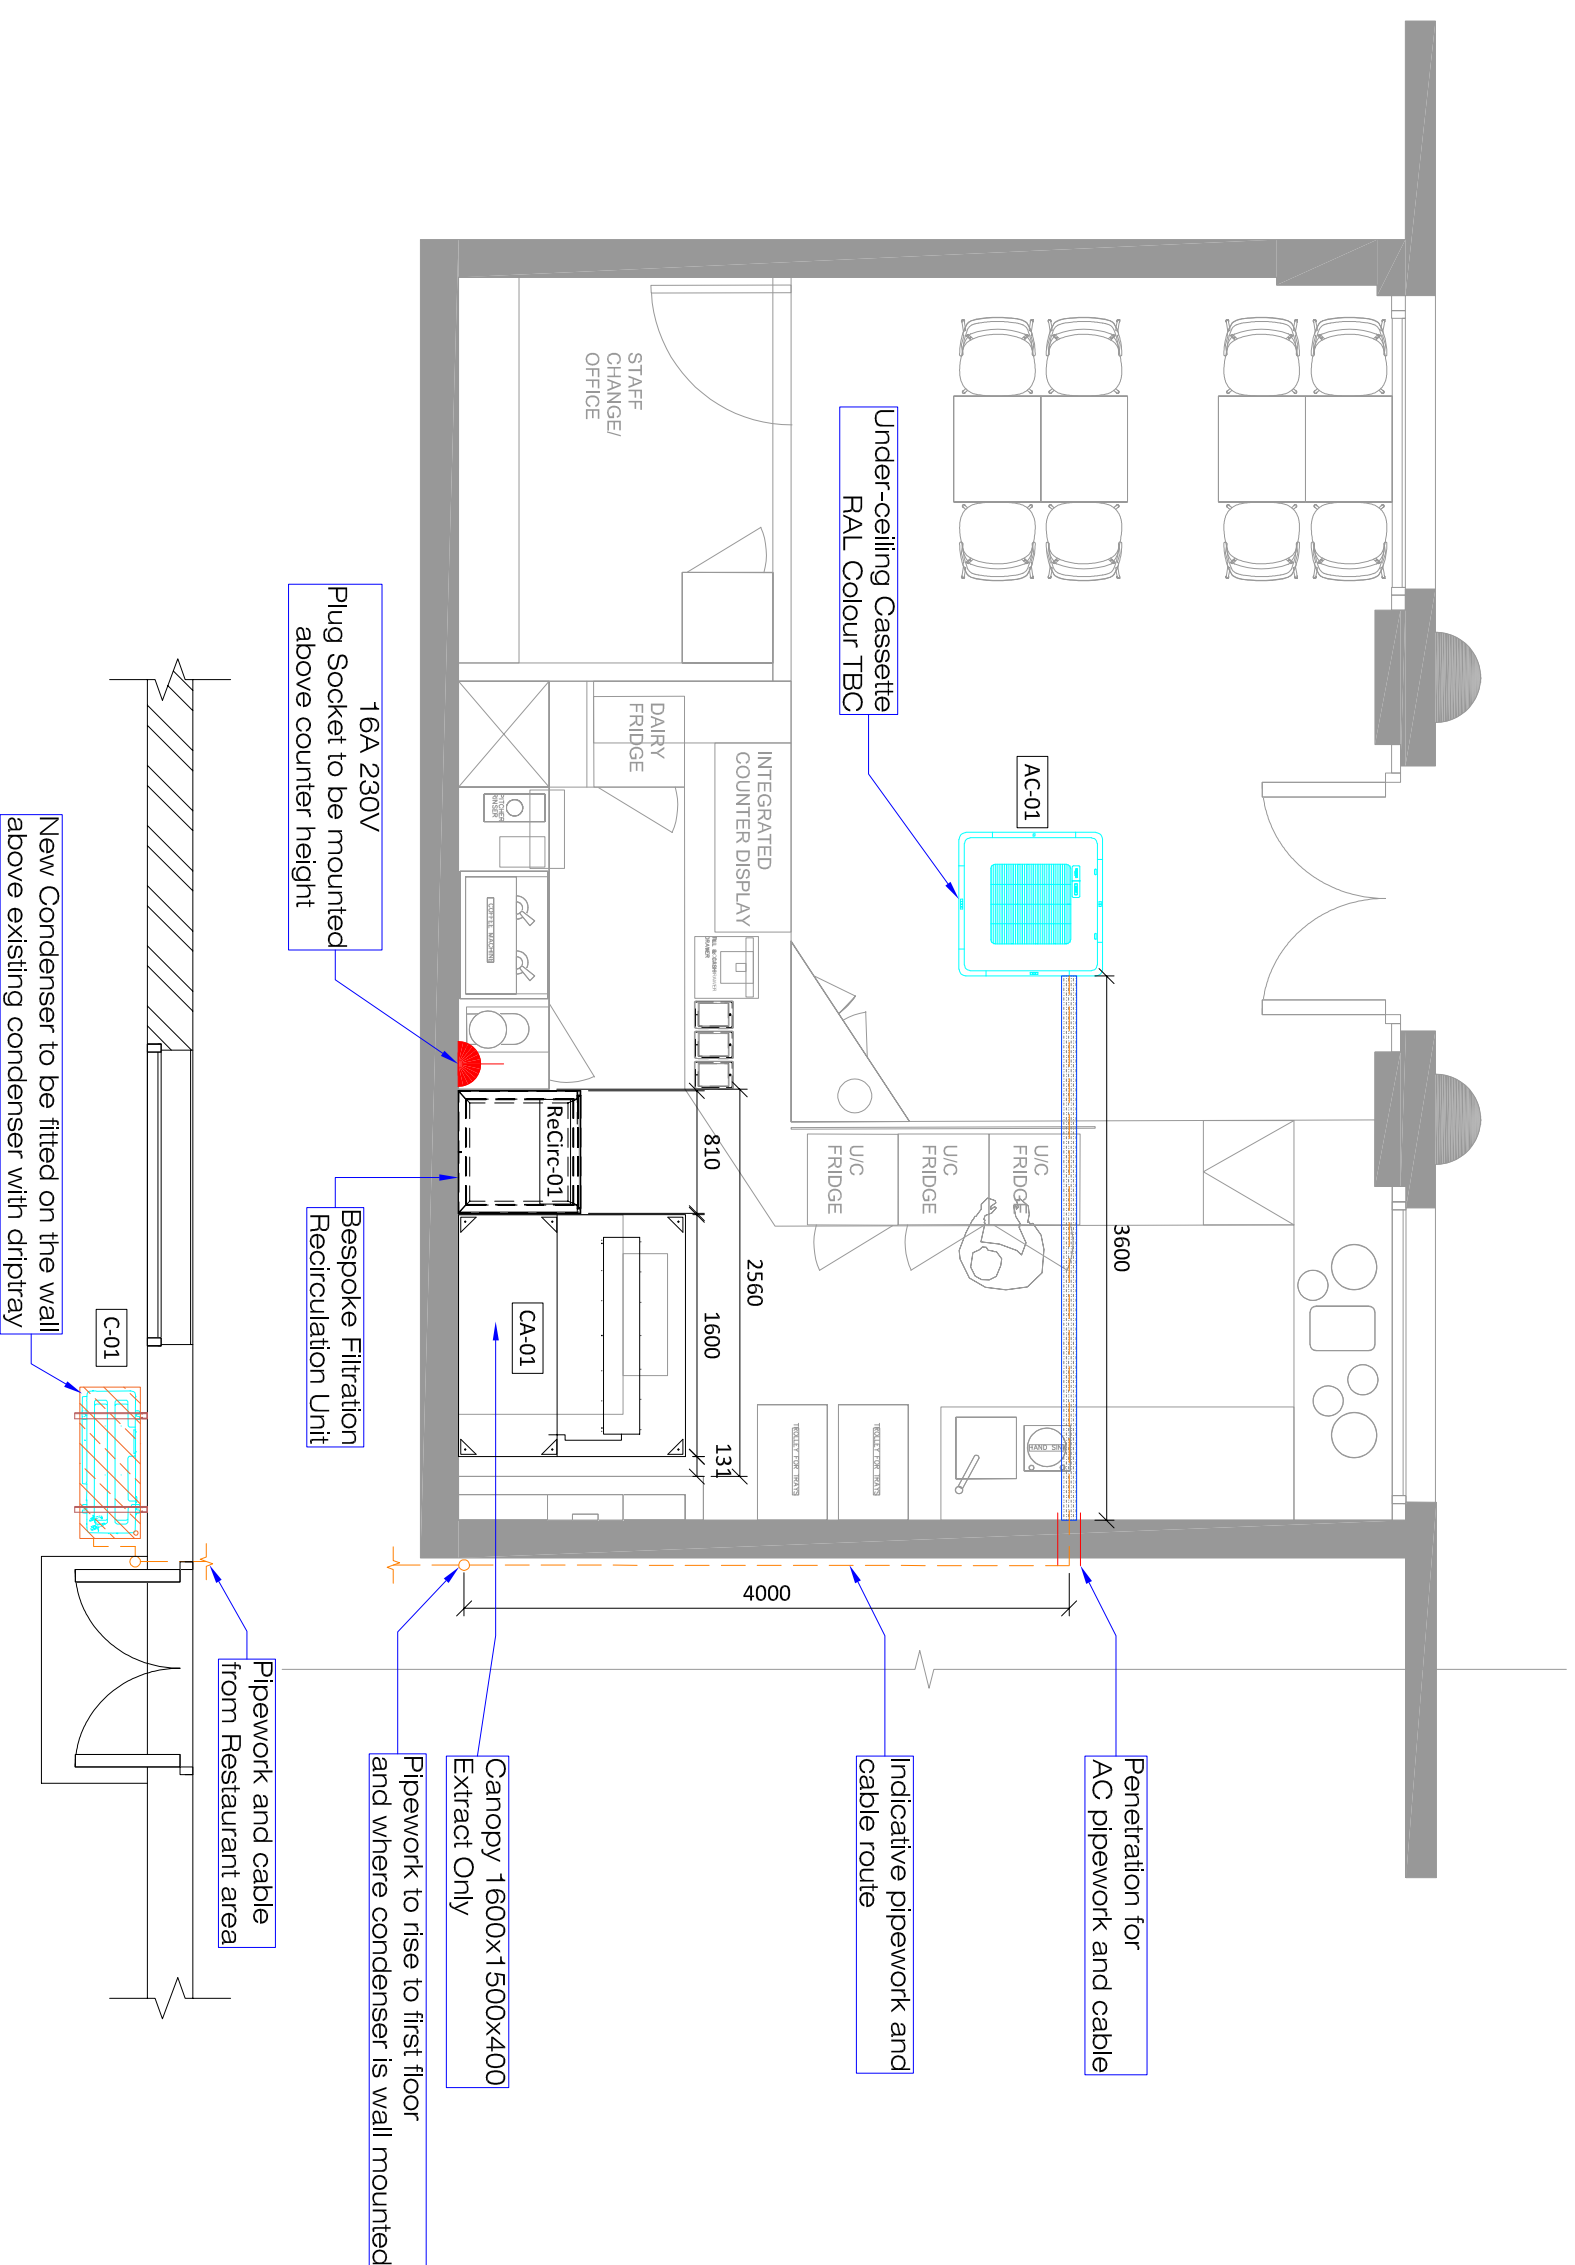

First Floor level, back of the unit
[See P0000106-001-C for proposed location of the condenser](#)