
 


EXISTING BASEMENT PLAN

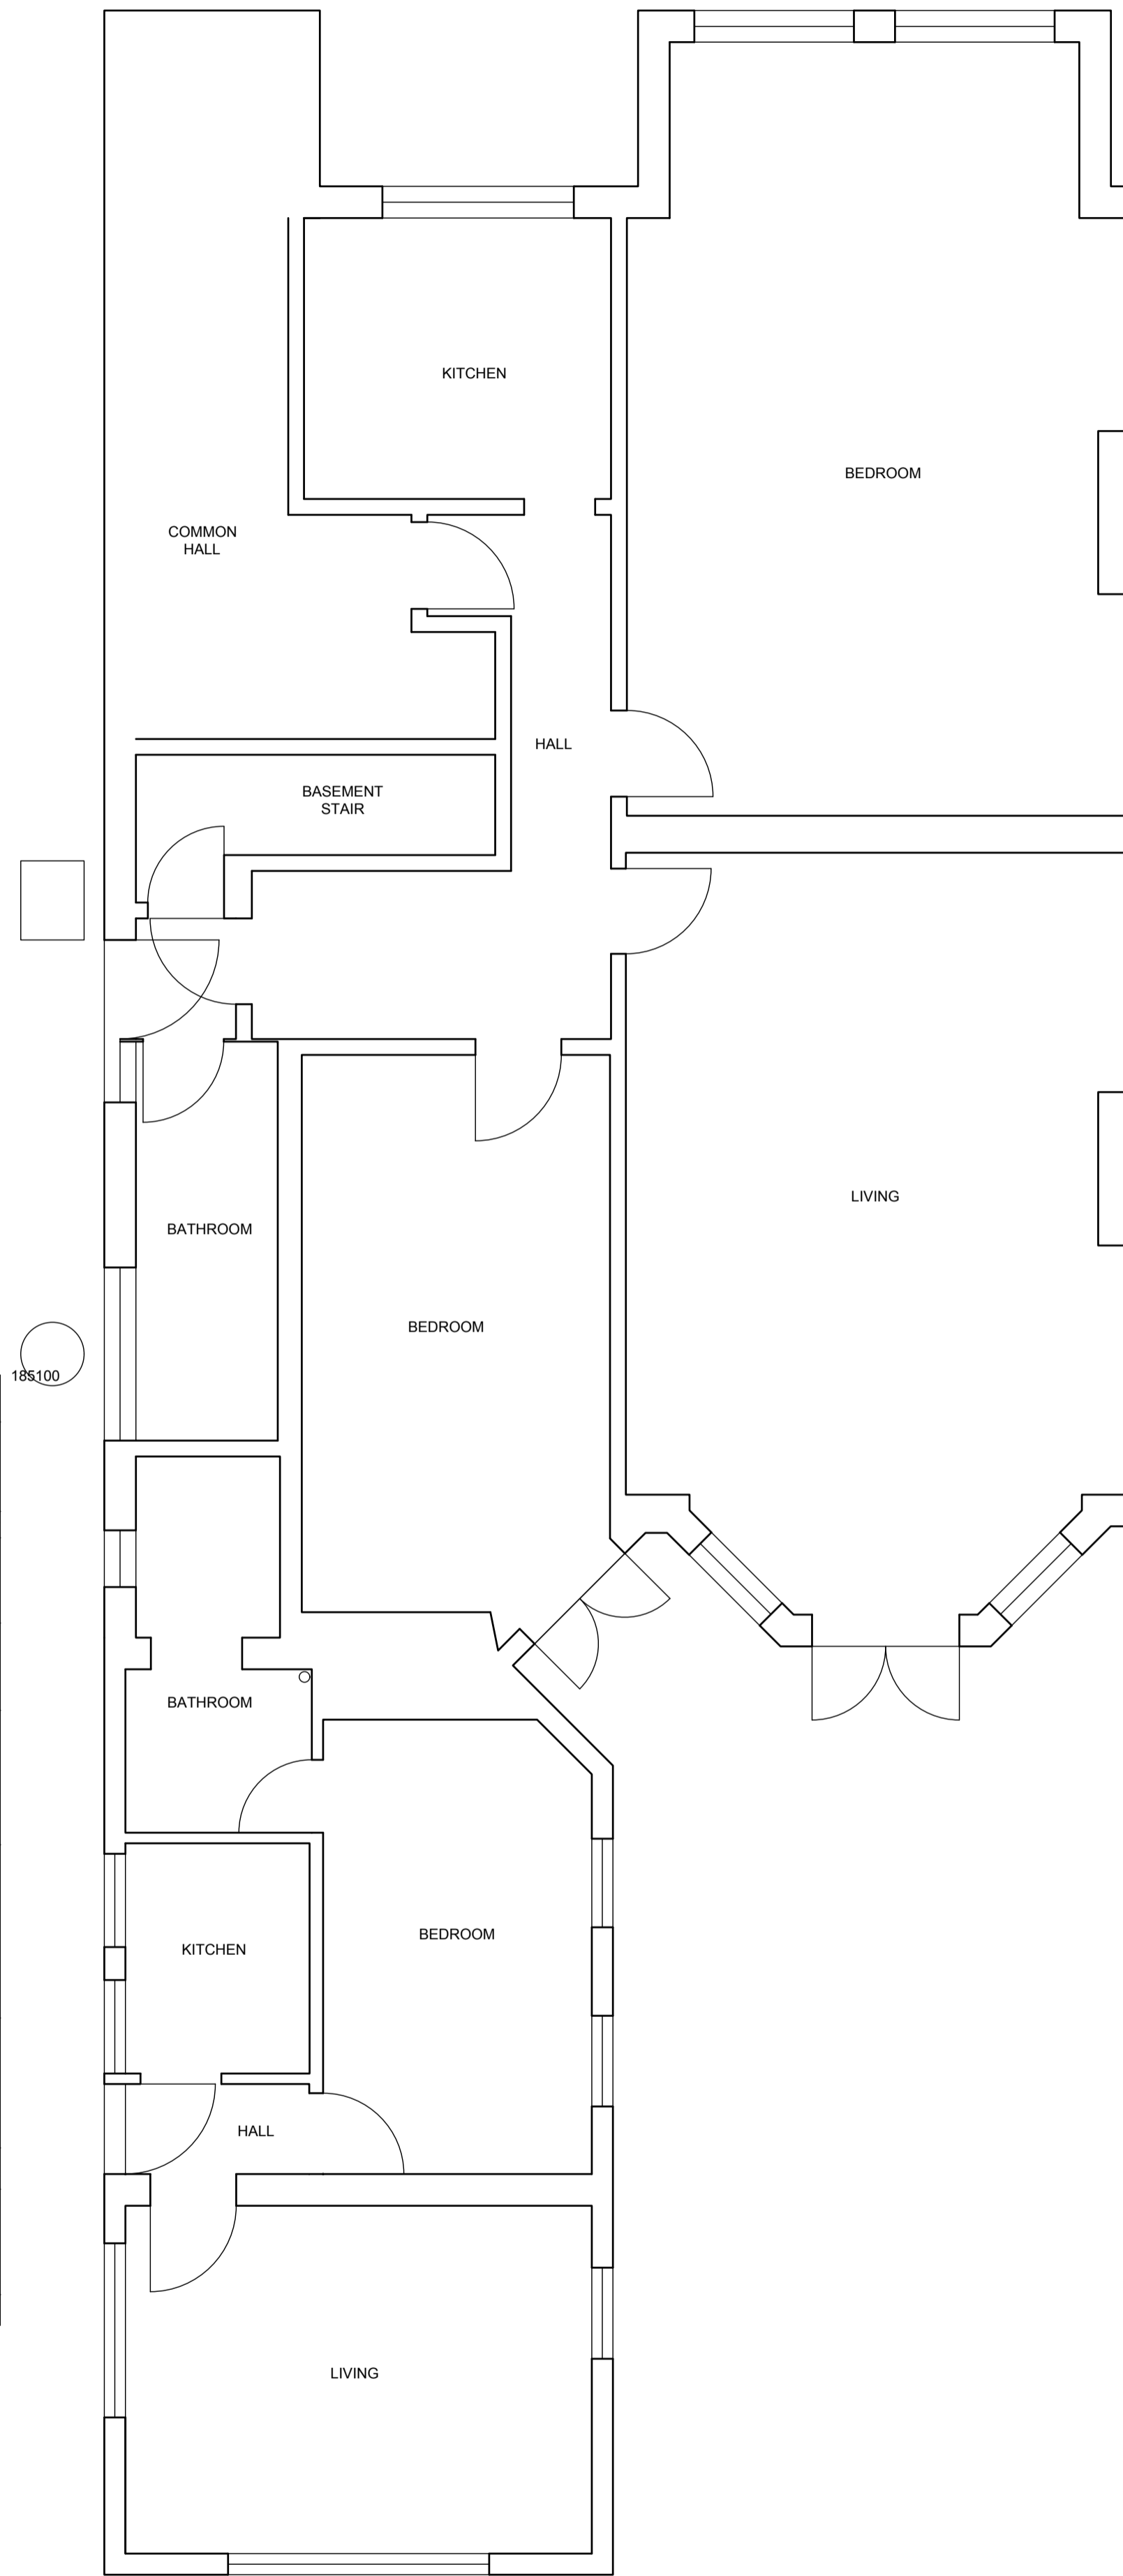

EXISTING GROUND PLAN



EXISTING FIRST PLAN



EXISTING SITE/BLOCK PLAN 1:500

GENERAL NOTES

1. THE CONTRACTOR MUST CHECK ALL DIMENSIONS ON SITE BEFORE COMMENCING WORK
2. ANY DISCREPANCIES MUST BE IMMEDIATELY BROUGHT TO THE ATTENTION OF THE DESIGNER
3. ALL WORK MUST CONFORM TO CURRENT BUILDING REGULATIONS, BRITISH STANDARDS & CODES OF PRACTICE AND NHBC STANDARDS
4. THESE DRAWINGS ARE TO BE READ IN CONJUNCTION WITH ALL RELEVANT DESIGNER, ENGINEER OR SPECIALIST DRAWINGS AND SPECIFICATIONS
5. ALL DIMENSIONS ARE IN MILLIMETERS UNLESS STATED OTHERWISE
6. ALL MATERIALS ARE TO BE USED AND INSTALLED IN STRICT COMPLIANCE WITH THE RELEVANT MANUFACTURER'S RECOMMENDATIONS
7. THE CONTRACTOR IS RESPONSIBLE FOR PROVIDING ALL NECESSARY TEMPORARY SUPPORT TO THE BUILDING AND ANY ADJACENT STRUCTURES
8. ALL CONSTRUCTION MUST BE BUILT WITHIN THE ACTUAL PROPERTY BOUNDARIES UNLESS PARTY WALL AGREEMENT ALLOWS OTHERWISE

HATCHLINE LEGEND		DRAINAGE ABBREVIATIONS	
	concrete		demolish
	brickwork		above/beyond
	blockwork		boundary
			drain
			insulation/ stud partition
			mh = manhole
			ic = inspection chamber
			re = rodding eye
			g = gully
			svp = soil vent pipe
			rwp = rain water pipe
			ss = stub stack
			rainwater drainage to contractor design
			electrical layout to client design

REVISION	DESCRIPTION	DATE

DRAW+PLAN

T: 0800 689 0101
 E: info@drawandplan.com
 W: www.drawandplan.com

Location

**FLAT 1 AND FLAT 5
 21 FAWLEY ROAD
 LONDON
 NW6 1SJ**

Drawing title

GENERAL ARRANGEMENT

Date

10/11/2020

Scale

1:50@A1

Job no.

20067

Dwg no.

EGA001

Revision

-

