


ROOF PLAN

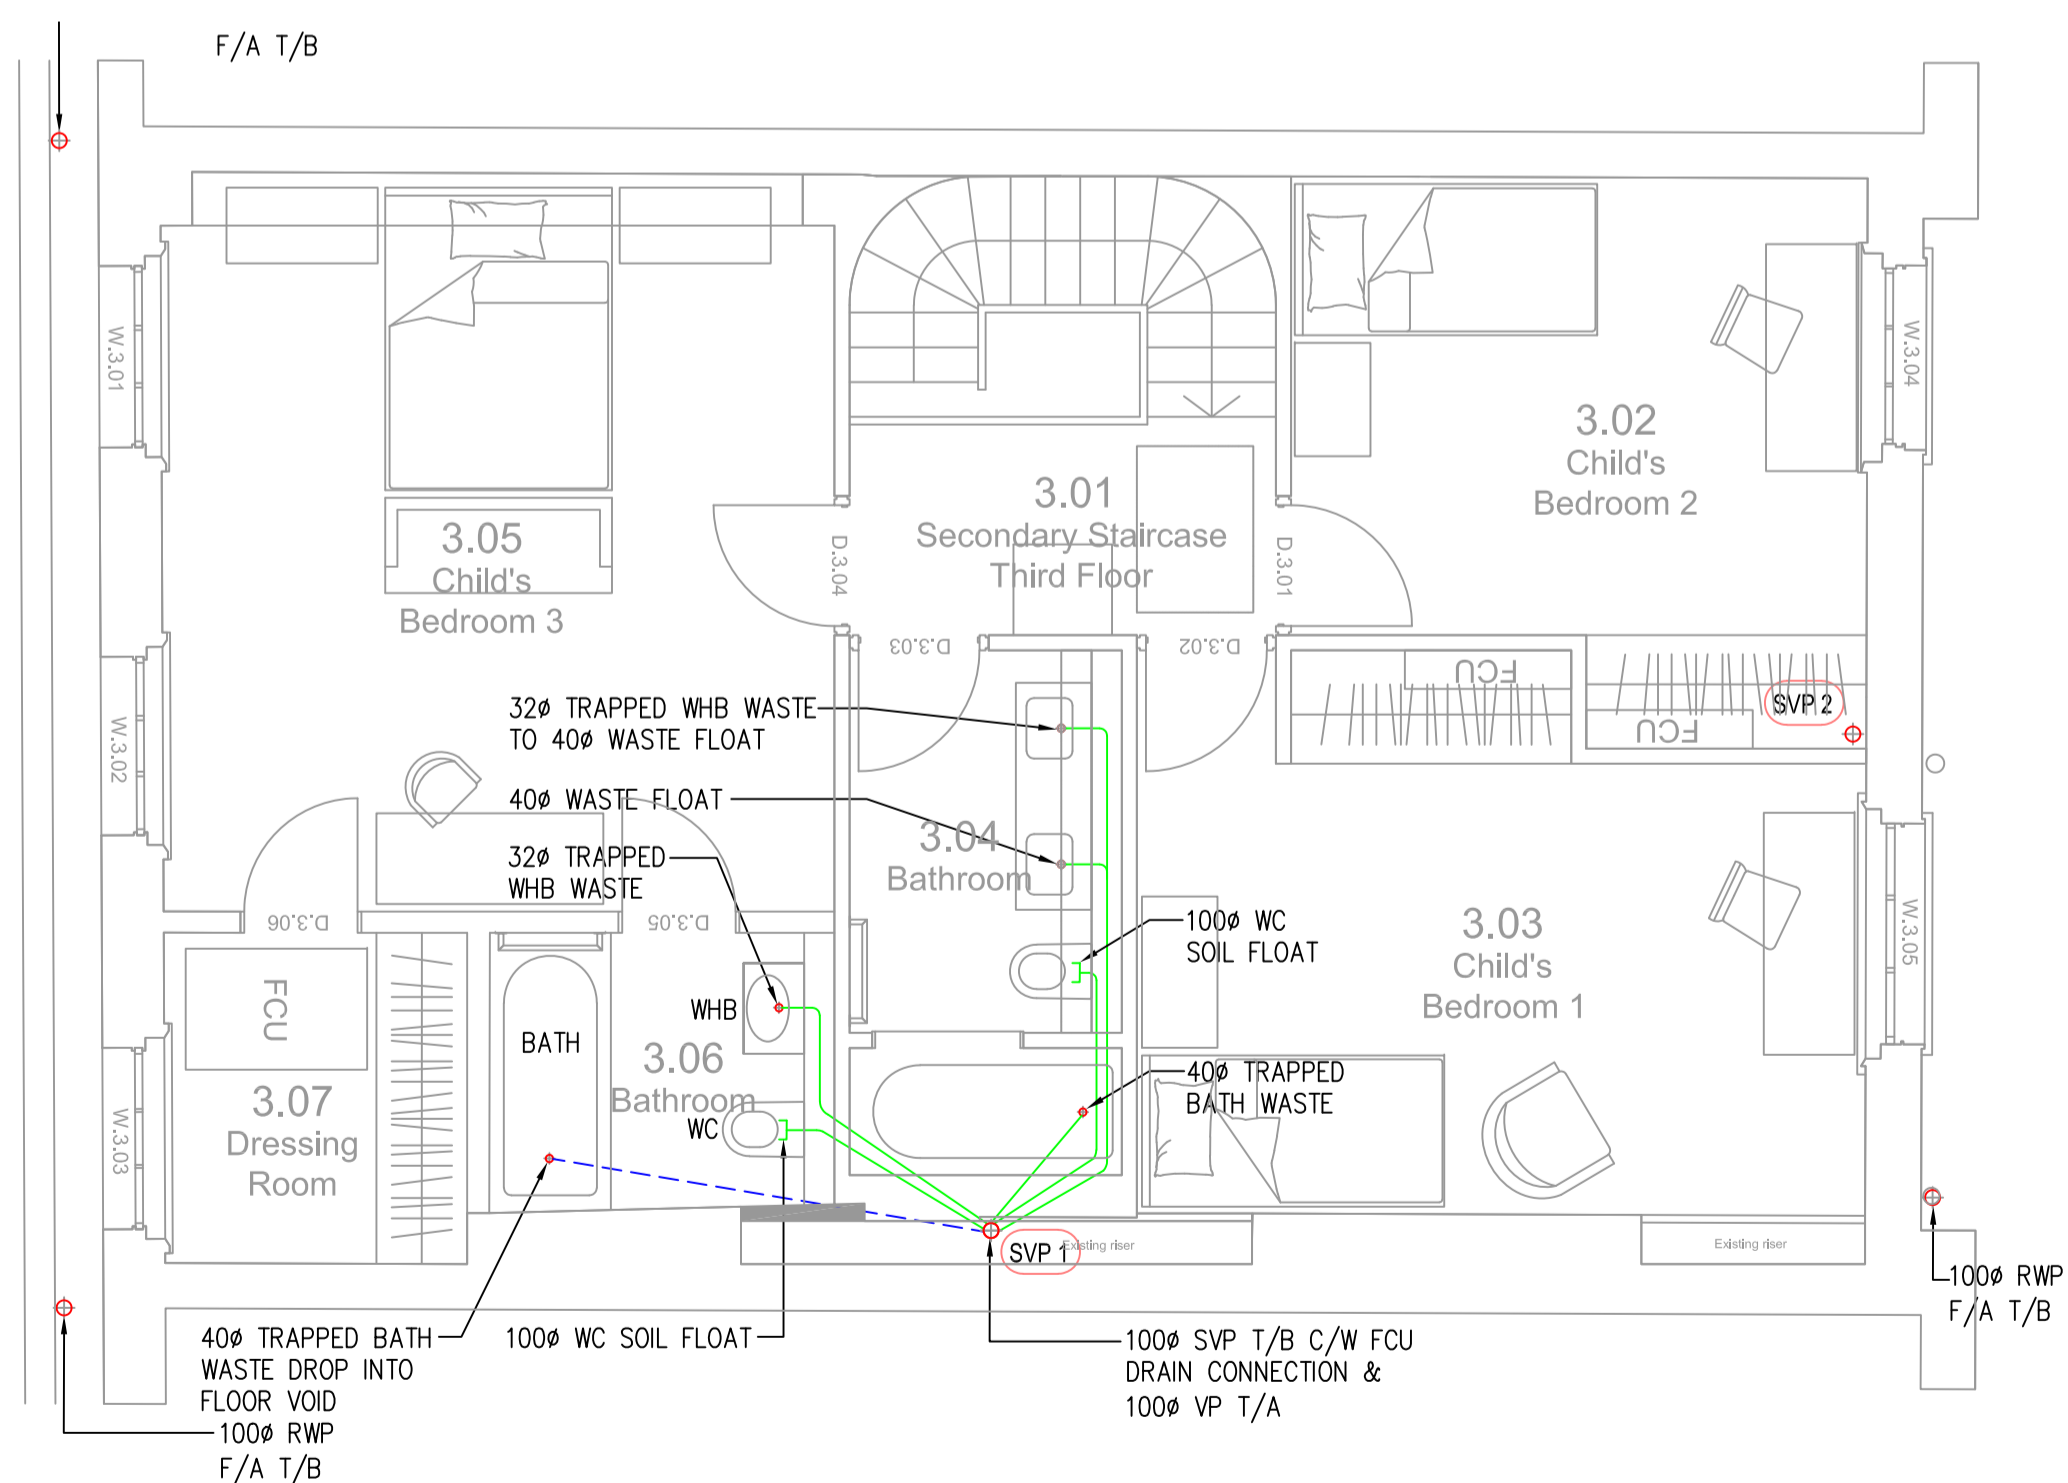

THIRD FLOOR PLAN

NOTES

- WHB - 30# TRAPPED WASTE
- SHR - 40# TRAPPED WASTE WITH TOP RODDING ACCESS
- BATH - 40# TRAPPED WASTE
- WC - 100# SOIL PIPE
- WM - 40# TRAPPED STANDPIPE
- SINK - 40# TRAPPED WASTE
- DW - 40# TRAPPED STANDPIPE
- CYL - 40# TRAPPED STANDPIPE
- BOILER - 30# HEPVO DRY TRAPPED STANDPIPE

LEGEND

- PIPEWORK AT HIGH LEVEL
- PIPEWORK AT LOW LEVEL
- BELOW GROUND RAINAGE

- AAV - AIR ADMITTANCE VALVE
- CYL - CYLINDER
- DW - DISHWASHER
- FA - FROM ABOVE
- FCU - FAN COIL UNIT
- FG - FLOOR GULLY
- H/L - HIGH LEVEL
- L/L - LOW LEVEL
- RE - RODDING EYE
- RWO - RAIN WATER OUTLET
- RWP - RAIN WATER PIPE
- SHR - SHOWER
- SS - STUB STACK
- SVP - SOIL VENT PIPE
- T/A - TO ABOVE
- T/B - TO BELOW
- VP - VENT PIPE
- WC - WATER CLOSET
- WHB - WASH HAND BASIN
- WM - WASHING MACHINE
- WP - WASTE PIPE

BWIC NOTE

USE OF EXISTING NOTCHES AND JOISTS TO BE USED WHERE PRACTICAL. ANY NEW NOTCH AND HOLES WILL BE CARRIED OUT IN ACCORDANCE TO LISTED BUILDING REGULATIONS AND STRUCTURAL ENGINEER'S DETAILS

Note

ALL DIMENSIONS TO BE VERIFIED ON SITE BEFORE SETTING OUT OR MAKING ANY SHOP DRAWINGS. THIS DRAWING IS TO BE READ IN CONJUNCTION WITH THE CONSULTANT ENGINEER'S SPECIFICATION.

Orientation

ref./date	REVISIONS
P 04.06.20	PRELIMINARY ISSUE FOR COMMENT
P1 19.06.20	PRELIMINARY ISSUE, AMENDED TO SUIT LATEST GA's
P2 09.07.20	PRELIMINARY ISSUE, AMENDED TO SUIT LATEST GA's
P3 15.09.20	PLANNING ISSUE
P4 24.09.20	PLANNING ISSUE
P5 09.11.20	PLANNING ISSUE AMENDED TO SUIT LATEST GA's

FOR PLANNING


KUT

KUT LLP
First Floor
2E Berol House
25 Ashley Road
London
N17 9LJ
Tel: +44(0)20 8348 5171
Fax: +44(0)20 8340 8926
Email: tkp@kut.co.uk
Web: www.kut.co.uk

**THIRD FLOOR & ROOF
PUBLIC HEALTH SERVICES
ABOVE GROUND DRAINAGE**

Project

55 CUMBERLAND TERRACE
CAMDEN, LONDON
NW1 4HJ

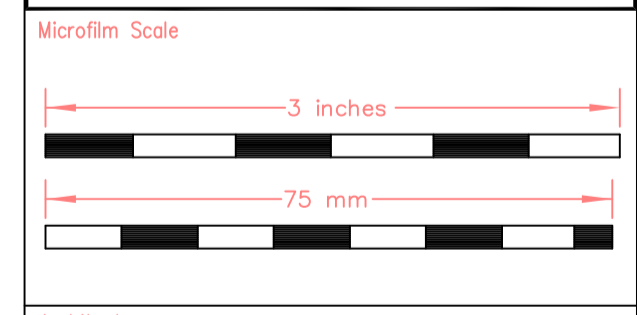

Architect

COLLETT-ZARZYCKI Ltd
Fernhead Studios, 2B
Fernhead Road, London W9 3ET
Tel: +44(0)20 8969 6967
email: mail@czltd.co.uk

xref 55CT - GA - (20-11-06)

Scale A1@1:50 **Drawn** IC

Date June 2020 **Checked**

Issue PRELIMINARY

Project No.	Services	Dwg No.	Rev.
6618	PH	103	P5

3rd & Roof