

REVISION	DATE	DESCRIPTION	DRAWN	CHECKED
1	17.09.20	Additional Condenser added and slab size amended to DDA details.		
2	25.09.20	Revised to include ADA reduced size compound		
3	11.11.20	Plant Slab size added		




**Typical Refrigeration Plant Cage Example**

Indicative Only




**Typical Mechanical Plant Cage Example**


Indicative Only

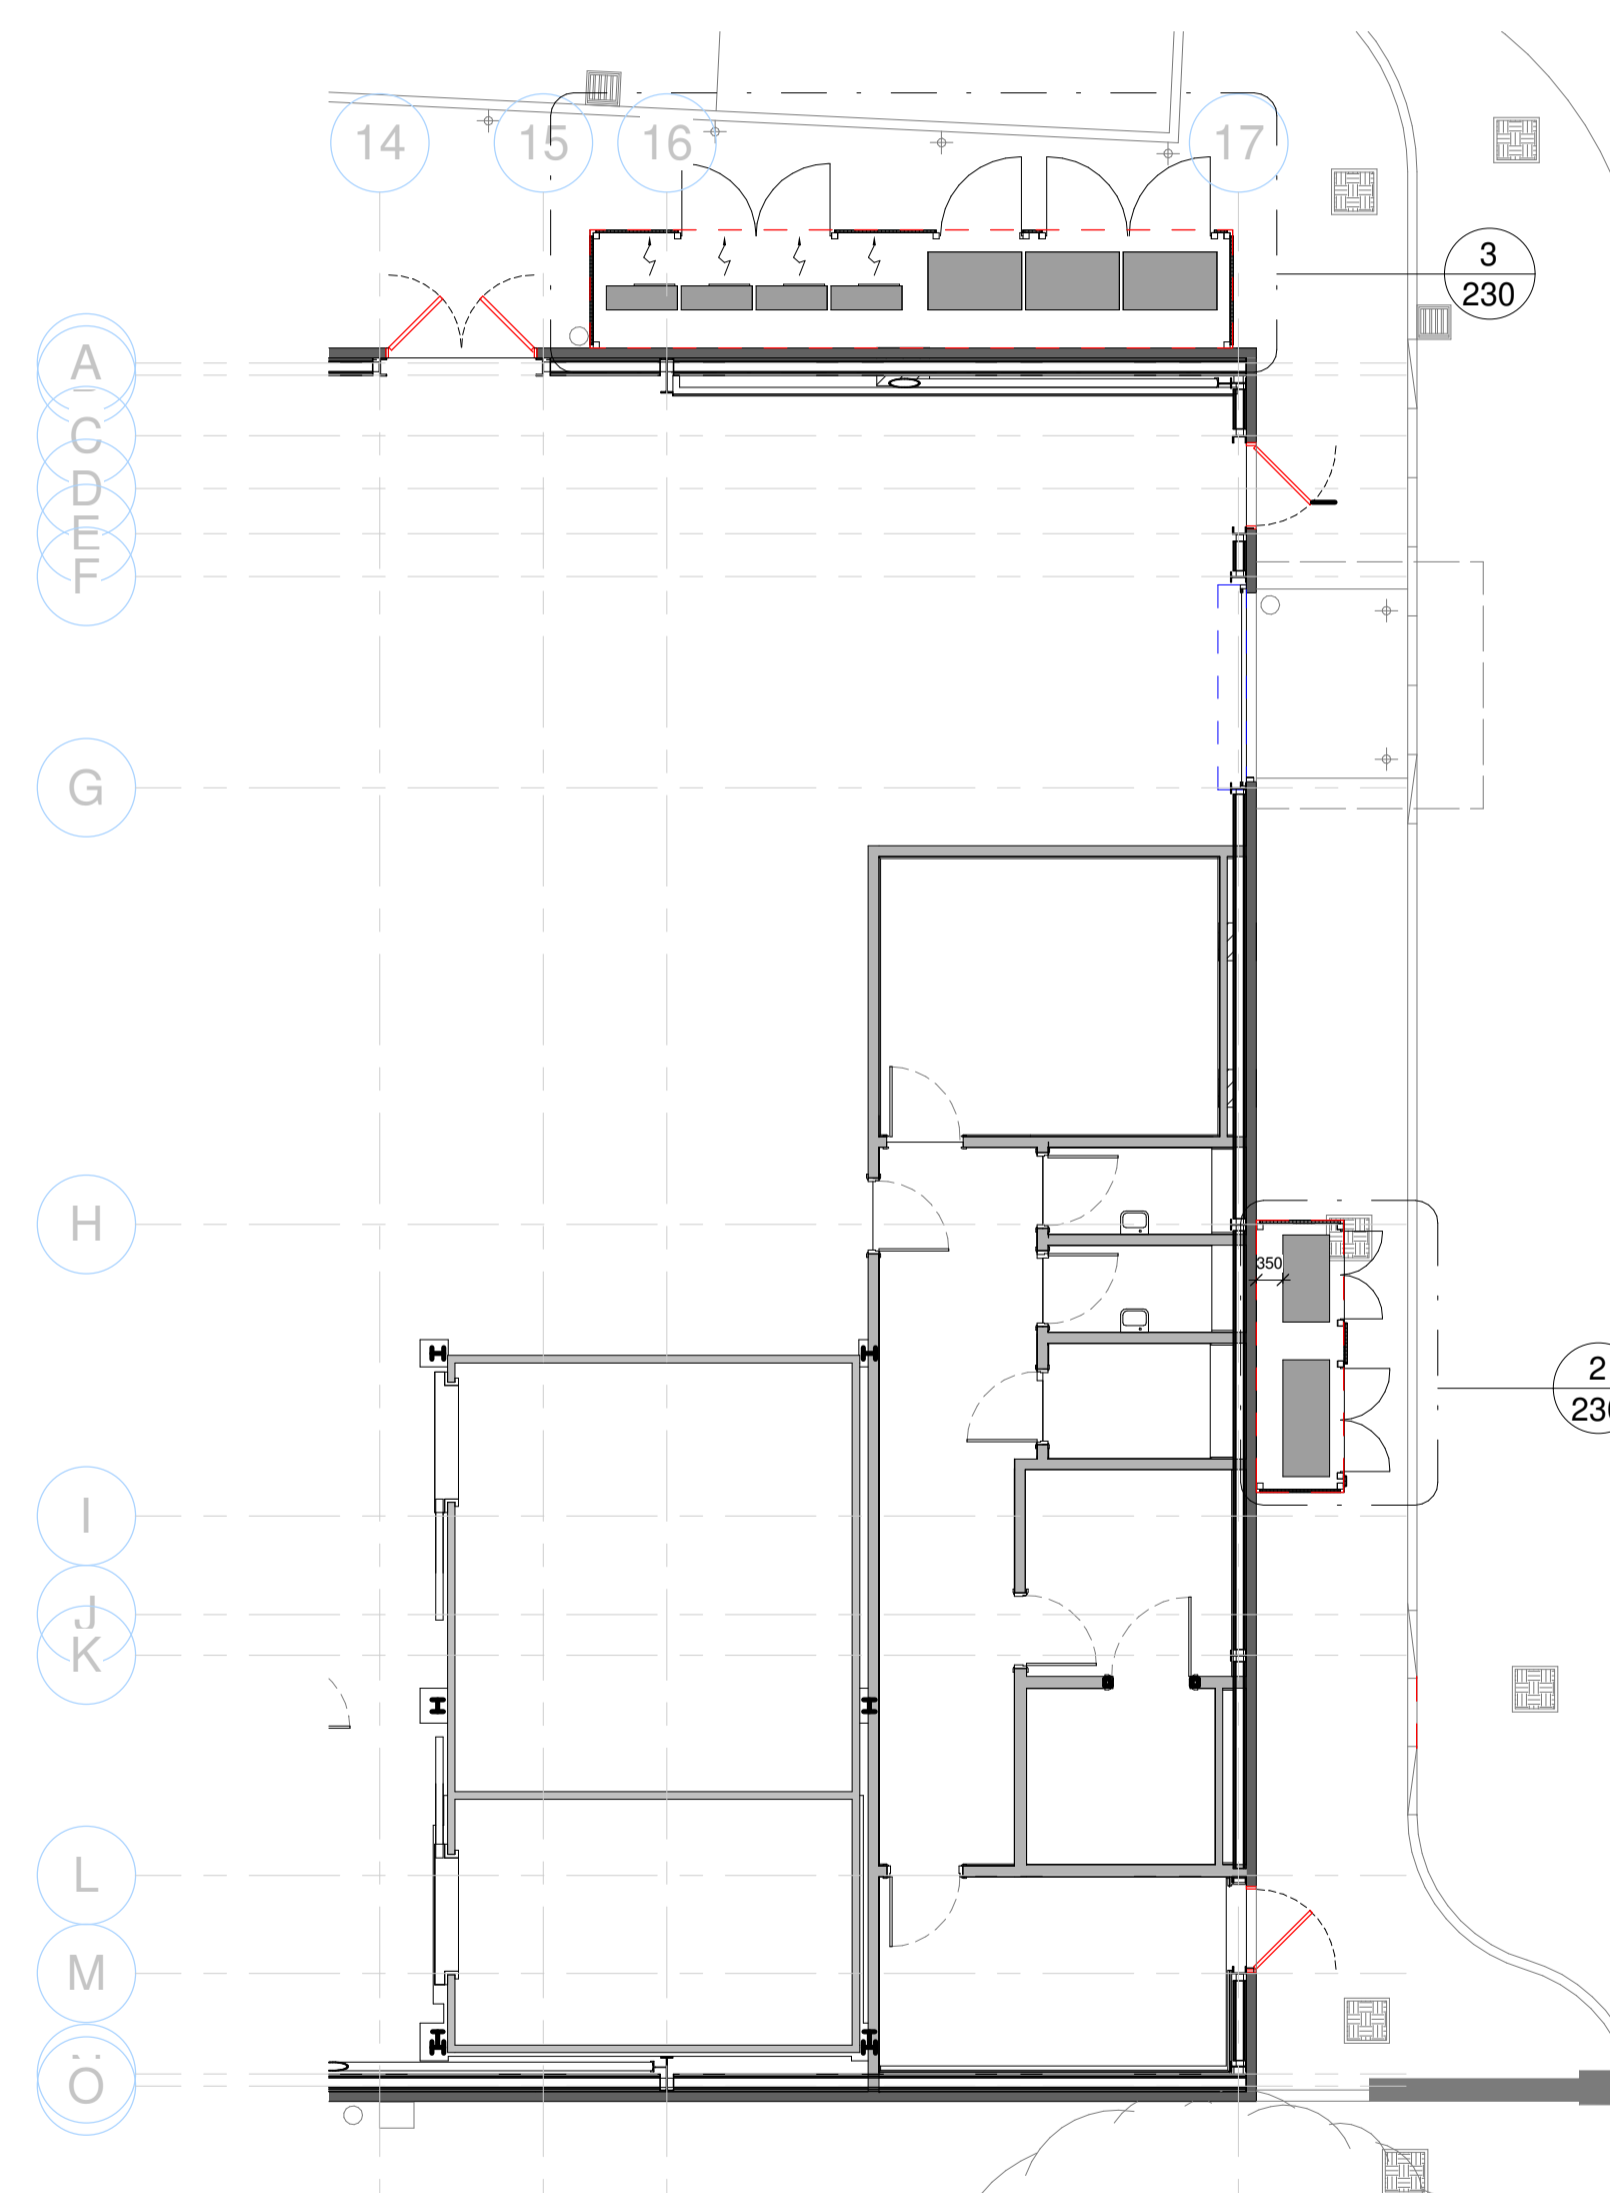

**1 Plant Compound Plan**  
1:100

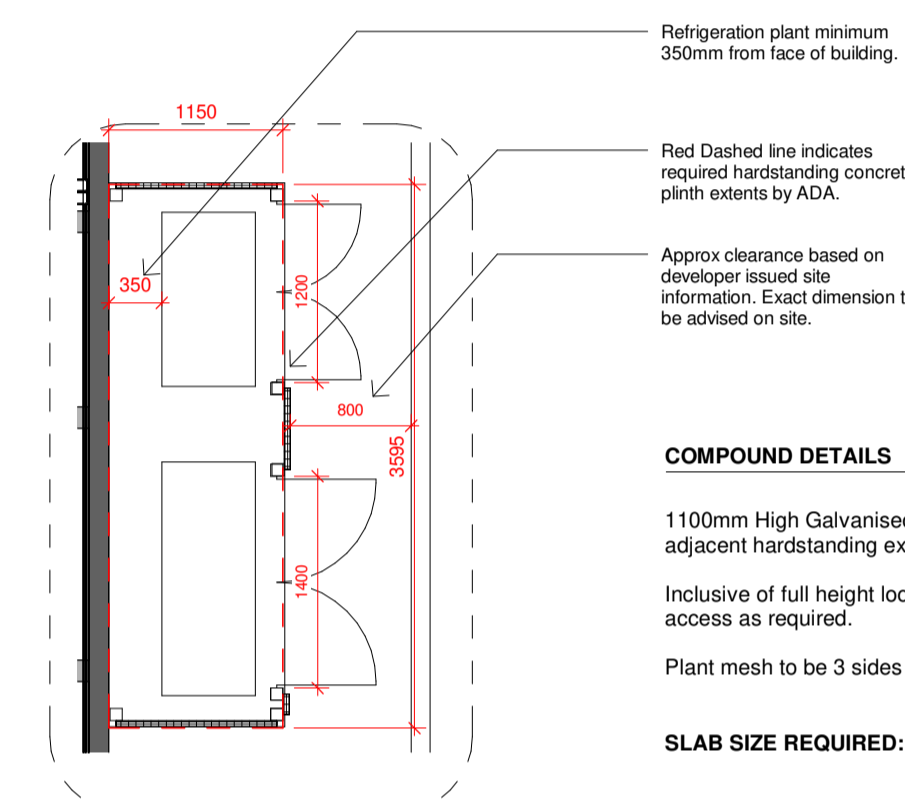

**2 Plant Compound - Refrigeration**  
1:50

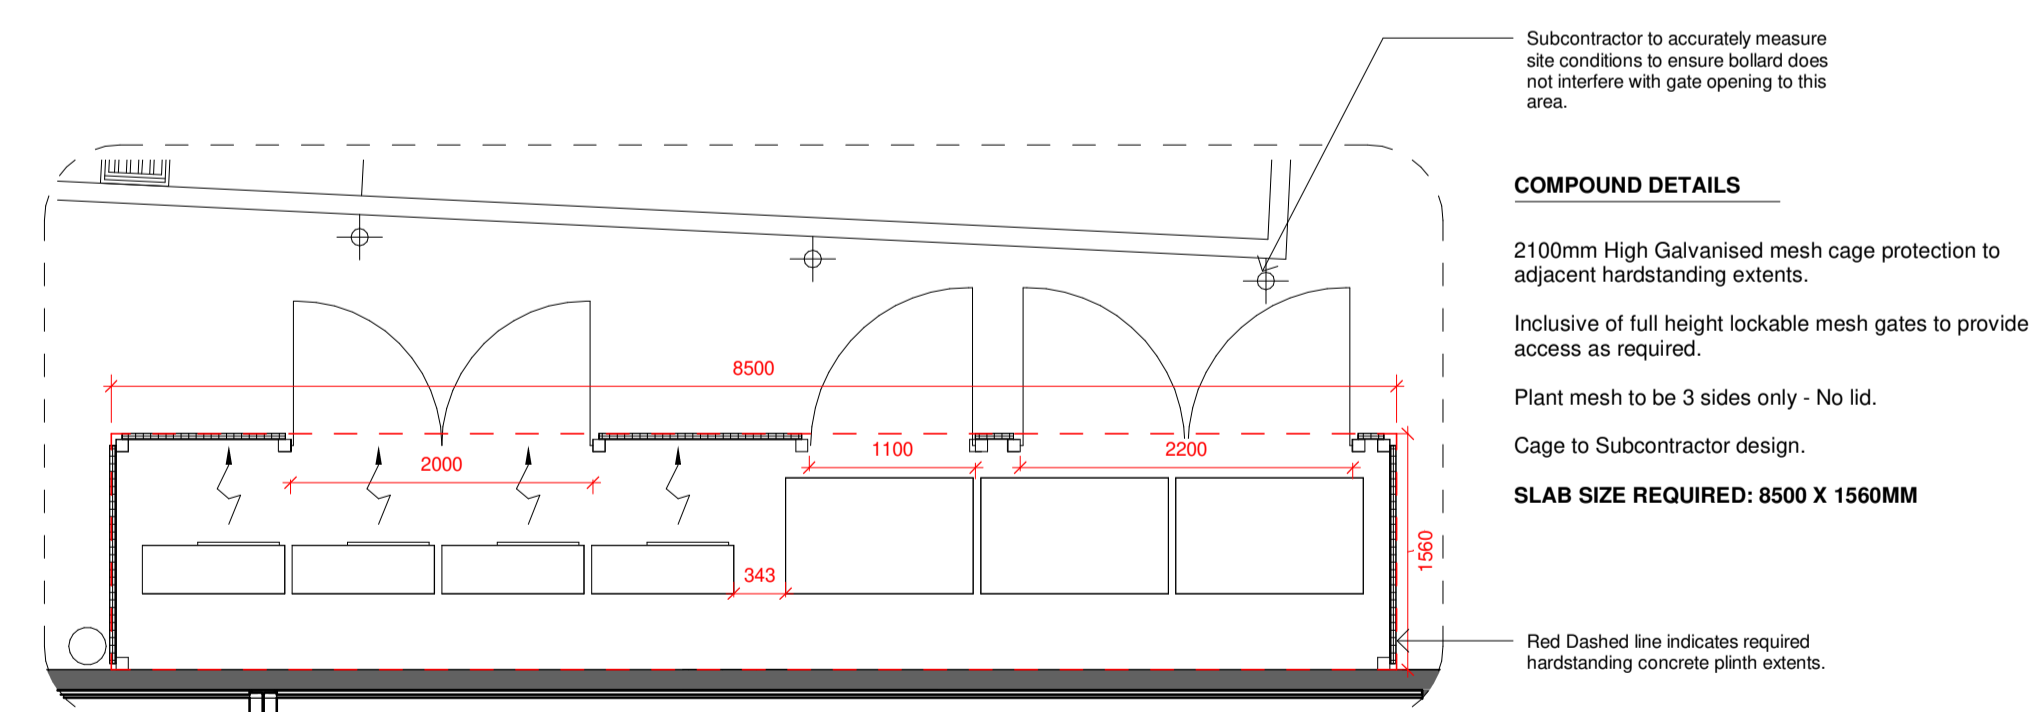

**3 Plant Compound - Mechanical**  
1:50

**STATUS: INFORMATION**



SOUTHPORT | t: 01704 531 252 | f: 01704 532 833 | e: southport@njsr.co.uk  
 MANCHESTER | t: 0161 873 8770 | f: 0161 873 8771 | e: manchester@njsr.co.uk  
 WWW.NJSR.CO.UK | WWW.NJSRPROJECTSERVICES.CO.UK  
 Client



Project  
 Temporary Store, Camden

Title  
 Plant Compound Details

Scale	Date	Drawn	Checked
As indicated	01.05.20	-	-
Contract	Dwg. No.	Rev	
1464-021	230	3	