



All drawings & designs are subject to final approval by the assigned Principal Designer, local authority and fire officer, which is the responsibility of the client.


All dimensions to be checked on site. Dimensions shown in millimetres.


General Notes:


KEY:

 Double Sockets

 Dimmer Light Switch

 Consumer Unit

 CAT6 Socket

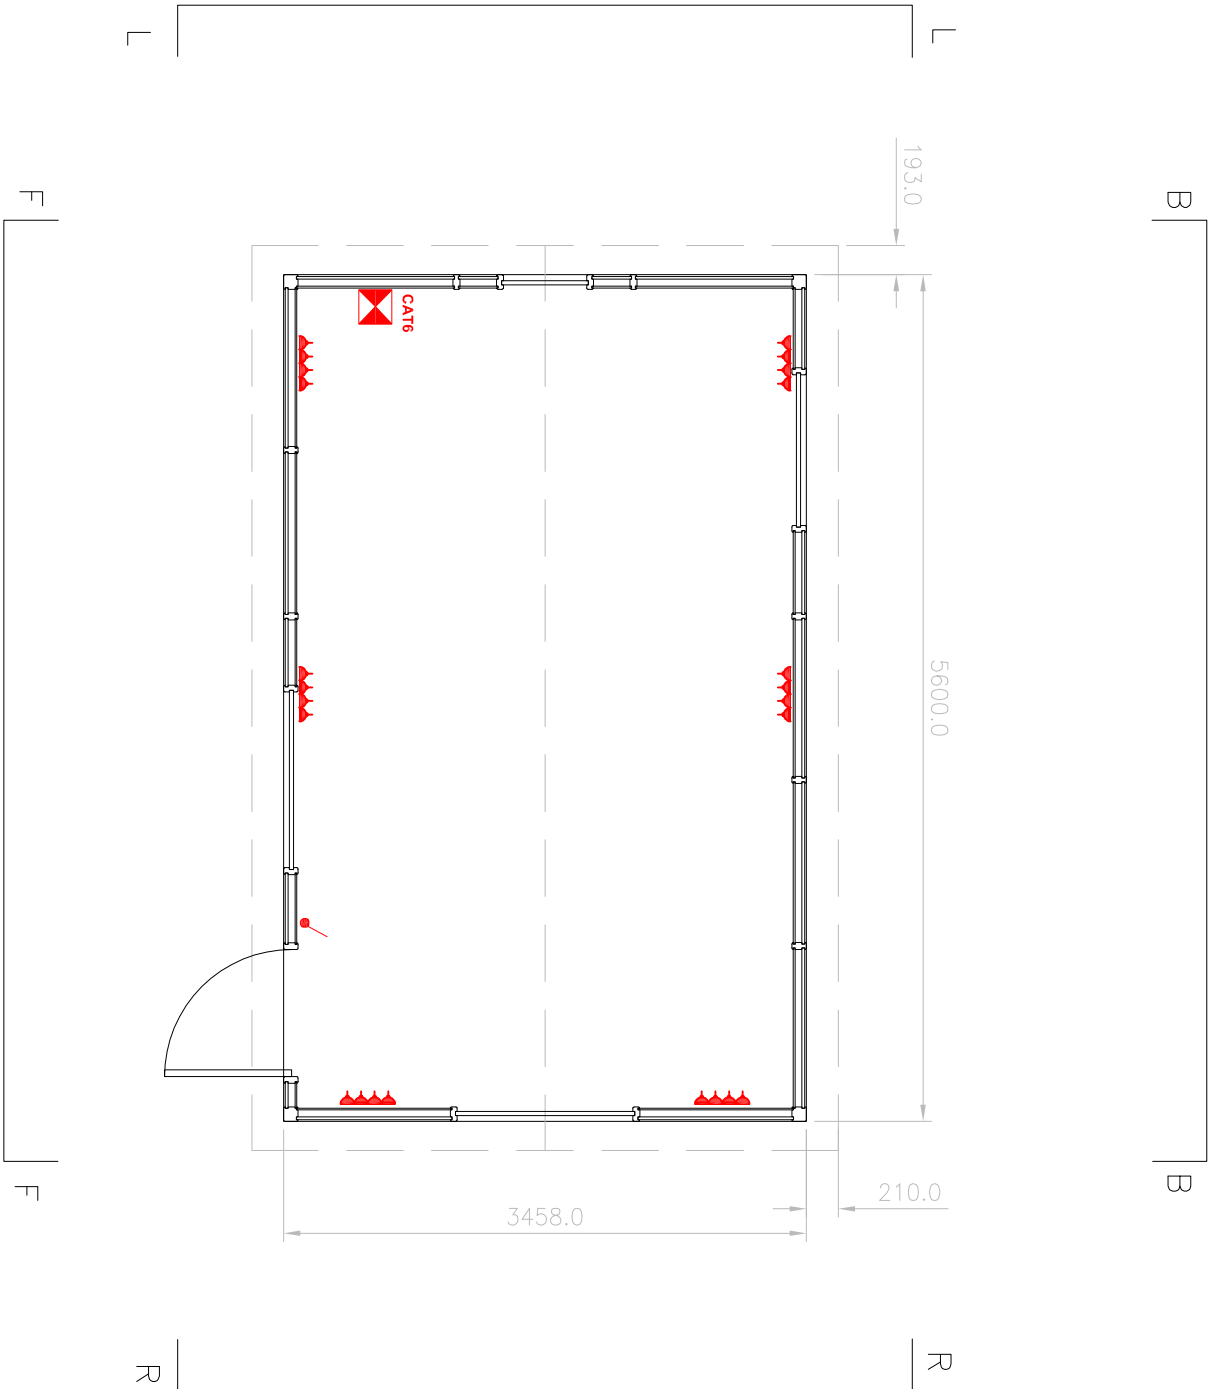

FLOOR PLAN – SCALE 1:50



PLAN - PROPOSED

Drawing No.	202083P01
Date	01 12 2020
Scale	1-50 A3



Project: 202083  
SUFFOLK BARN 5.3x3.2 2020  
SMART OFFICE  
PLAN PROPOSED

Installation Address:  
8 Holly Terrace  
London N6 6LX

Client Name and Address:  
Mr Ormond  
8 Holly Terrace  
London N6 6LX

Thurston Park  
Church Road, Thurston  
Bury St Edmunds  
Suffolk, IP11 3NN  
0800 242 5559  
www.smartgardens.co.uk

SMART  
GARDEN ROOMS, OFFICES AND STUDIOS

No.	Revision/ Issue	Date
-	-	-
-	-	-
-	-	-