








1. No information or designs contained within this document should be copied or reproduced without the specific consent of Gunter & Co Interiors Ltd.
2. Do not scale from this drawing. Any areas, measurements or distances given are approximate only and should be confirmed before design or fabrication.
3. Any drawings, photos, or computer generated images shown are indicative and cannot be guaranteed to represent the complete interiors or exteriors of a scheme.
4. © 2017 Gunter & Co Interiors Ltd. All Rights Reserved

Notes A3

LEGEND

-  **LINEAR LED LIGHT**
-  **WALL LIGHT**
-  **PENDANT LIGHT**
-  **SMOKE ALARM**
-  **SWITCH**
-  **EMERGENCY LIGHT FITTING**

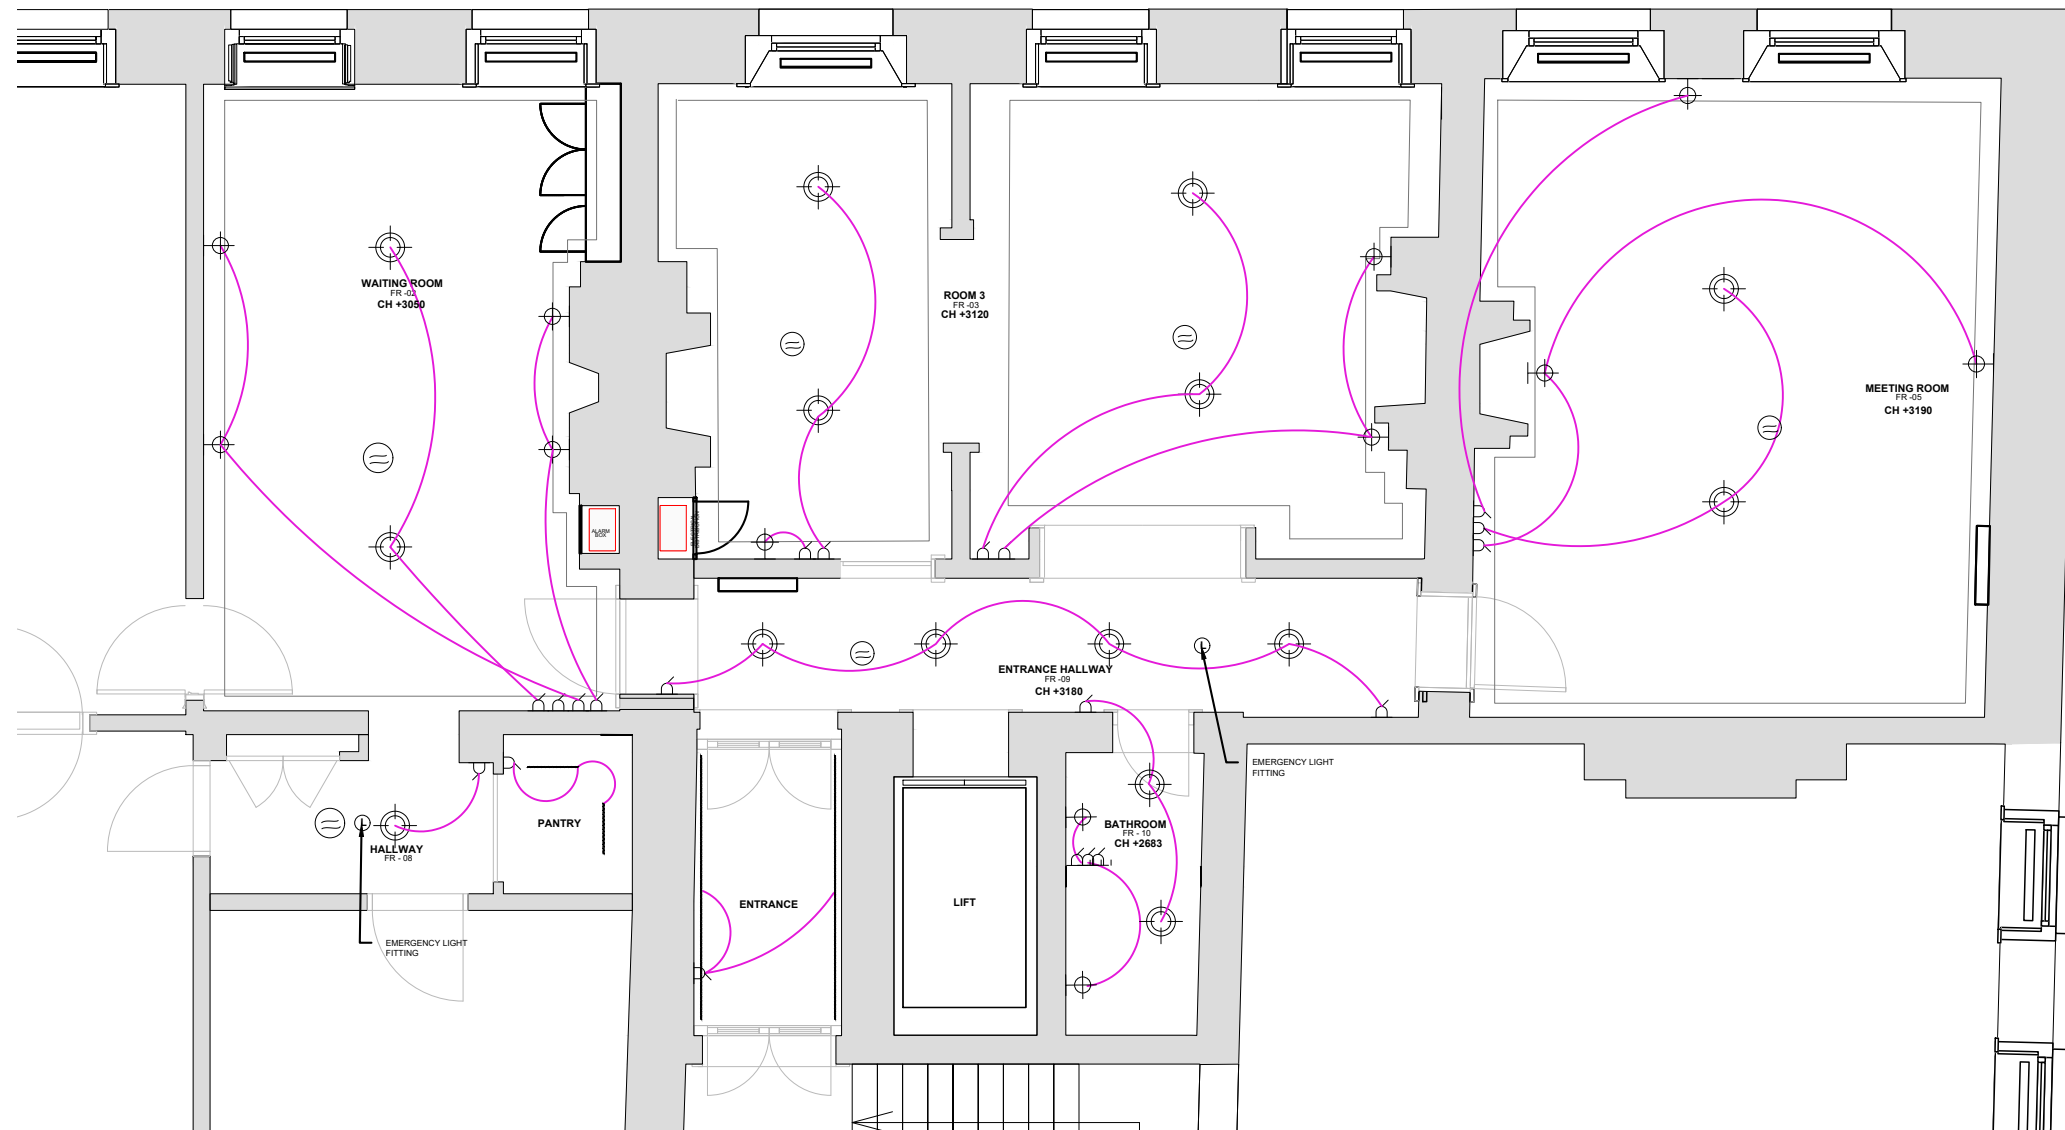

01 Existing RCP & Lighting Layout
scale 1:75 @A3

Rev	Note	Date

Project Title
FALCON

Drawing Title
**RCP & Lighting Layout
Existing Layout**

Date	Scale	Drawn By
27.11.2020	1:75 at A3	MB

Drawing No	Rev
FL- FF - 120	-

.\\Gunter&Co_G&_Gunter&Co_black.jpg

Unit 1.23 The Plaza
535 King's Road
London, SW10 0SZ
United Kingdom
+44 (0)20 7993
8583

Gunter&Co_G&_Gunter&Co_black.jpg