


A PENDANT LIGHT Supplier: Holloways of Ludlow Dot Atomium Suspension Bulbs: 12 x G9 LED 12x 3.5W 120V / 240V (included) Color temperature: 2700 K (with bulb included) CRI: 80 Standard Dia: 965mm H: 622mm / 775mm TBC Weight: 2.5/2.7 Kg SWITCHED Finish: Brass	B PICTURE LIGHT Supplier: Mr. Light Galileo 1 Color temperature: 2400 K 24V - Required driver 107x40x23mm mounts behind frame L: Bespoke TBC Type 17 arm 170 mm SWITCHED Finish: Bronze	C WALL LIGHT Supplier: Astro Lighting Shadow 300 Color temperature: 2700 K Lamp Type & Wattage: 2 x 6W Max LED GU10 Dimension: H 300 W 94 D 100mm SWITCHED Finish: Plaster	D WALL LIGHT Supplier: ATRIUM Intraighting Hexagon Mesh Wire suspension height: TBC DIMMABLE - DALI Finish: Black Wire suspension: White Ceiling Cup: White	E PICTURE LIGHT Supplier: Holloways of Ludlow Laurent 16 Suspension Color temperature: 2700 K (with bulb included) Bulb: 10 x G9 LED 4.5W 120V / 240V (included) Height: Variable Width: 3239mm Weight: 19 kg DIMMABLE TBC Finish: Black structure, black cable	F PICTURE LIGHT Supplier: Mr. Light Cremone 65 Color temperature: 2700 K LED 230V 14.8W Brightness: 1560 lumen H5 cm L70.5 cm D11.7 cm SWITCHED ON A TIMER Finish: Brushed bronze	G PENDANT LIGHT Supplier: Square in Circle Pole Dance Color temperature: 3000 K Voltage - 230V Wattage - 5W, 3W 1 x E14 LED, 1 x G9 LED Dimension: H 820mm TBC W 200mm L 920mm Weight: 7 KG SWITCHED Finish: Brushed Brass	H LINEAR LED LIGHT Supplier: ATRIUM Tryka - Adder FLEX 60 Color temperature 2700 K 425 Lm/m 4.8 W/m CRI Standard CRI90 Voltage 12V DC Cut Point 50mm (6 LEDs) SWITCHED TBC Finish: N/A	I LINEAR LED LIGHT Supplier: ATRIUM Tryka - Adder FLEX 120 Color temperature 2700 K 850 Lm/m 9.6 W/m CRI Standard CRI90 Voltage 12V DC Cut Point 50mm (6 LEDs) SWITCHED TBC Finish: N/A	J BATHROOM WALL LIGHT Supplier: Roll & Hill Agnes Sconce - 2 Lights H67cm x W 26cm x D9cm Socket: G9 Bulb: 2 x 3 Watt JCD LED Wattage: 6 Watts Lumens: 200 Lumens Color Temperature: 2700 Kelvin Dimming: ELV DIMMABLE TBC Finish: Polished nickel	CEILING CORNICE ORAC DECOR C902 L 200 x H 10.3 x W 10.3 cm
-------------------------------------------------------------------------------------------------------------------------------------------------------------------------------------------------------------------------------------------------------------------------------------------------------------------------------	-----------------------------------------------------------------------------------------------------------------------------------------------------------------------------------------------------------------------------------------------	-------------------------------------------------------------------------------------------------------------------------------------------------------------------------------------------------------------------------------	-------------------------------------------------------------------------------------------------------------------------------------------------------------------------------------------------------------	-----------------------------------------------------------------------------------------------------------------------------------------------------------------------------------------------------------------------------------------------------------------------------------------------------------------------------	------------------------------------------------------------------------------------------------------------------------------------------------------------------------------------------------------------------------------------------	-------------------------------------------------------------------------------------------------------------------------------------------------------------------------------------------------------------------------------------------------------------------------------------	-------------------------------------------------------------------------------------------------------------------------------------------------------------------------------------------------------------------------------------------------	--------------------------------------------------------------------------------------------------------------------------------------------------------------------------------------------------------------------------------------------------	-------------------------------------------------------------------------------------------------------------------------------------------------------------------------------------------------------------------------------------------------------------------------------------------------------------	----------------------------------------------------------------------------

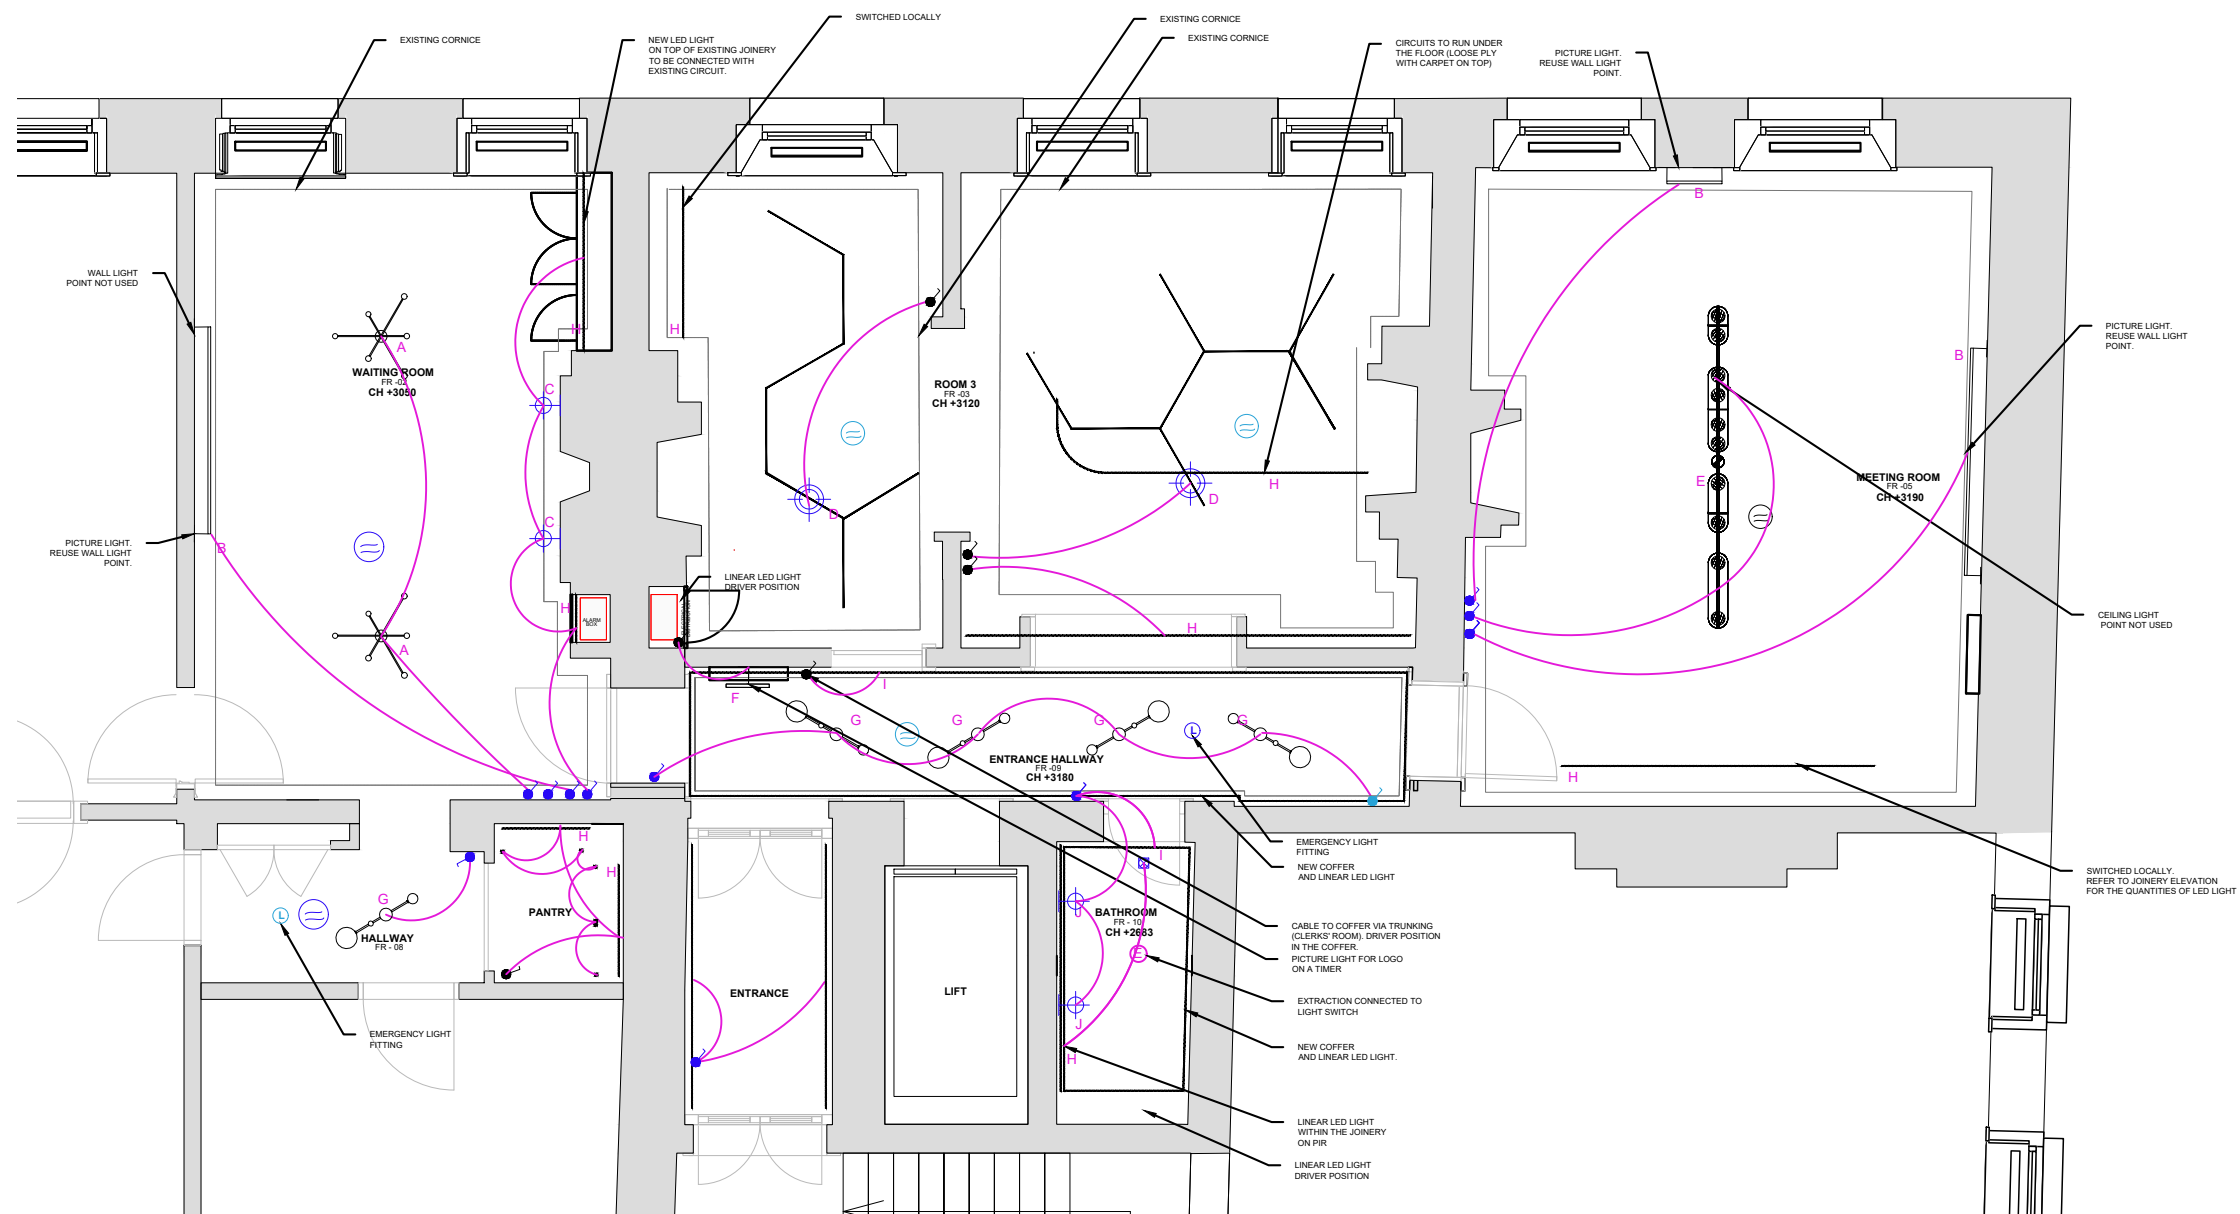

Drawing Status
PRELIMINARY

- No information or designs contained within this document should be copied or reproduced without the specific consent of Gunter & Co Interiors Ltd.
- Do not scale from this drawing. Any areas, measurements or distances given are approximate only and should be confirmed before design or fabrication.
- Any drawings, photos, or computer generated images shown are indicative and cannot be guaranteed to represent the complete interiors or exteriors of a scheme.
- © 2017 Gunter & Co Interiors Ltd. All Rights Reserved

Notes A3

LEGEND

- LINEAR LED LIGHT
- WALL LIGHT
- PENDANT LIGHT
- SMOKE ALARM
- SWITCH
- EXTRACTION
- EMERGENCY LIGHT FITTING
- NEW POSITION
- EXISTING POSITION
- MODIFIED POSITION

NOTE: FOR DESIGN INTENT ONLY. INFORMATIONS TO BE CHECKED ON SITE BEFORE CONSTRUCTION.

Rev	Note	Date
Project Title FALCON		
Drawing Title RCP & Lighting Layout Detailed Proposed Layout		
Date 27.11.2020	Scale 1:75 at A3	Drawn By MB
Drawing No FL- FF - 122	Rev -	

01 Detailed Proposed RCP & Lighting Layout
scale 1:75 @A3

.Gunter&Co_G&_Gunter&Co_black.jpg

Unit 1.23 The Plaza
535 King's Road
London, SW10 0SZ
United Kingdom
+44 (0)20 7993
8583

Gunter&Co_C&_G&_black.jpg