




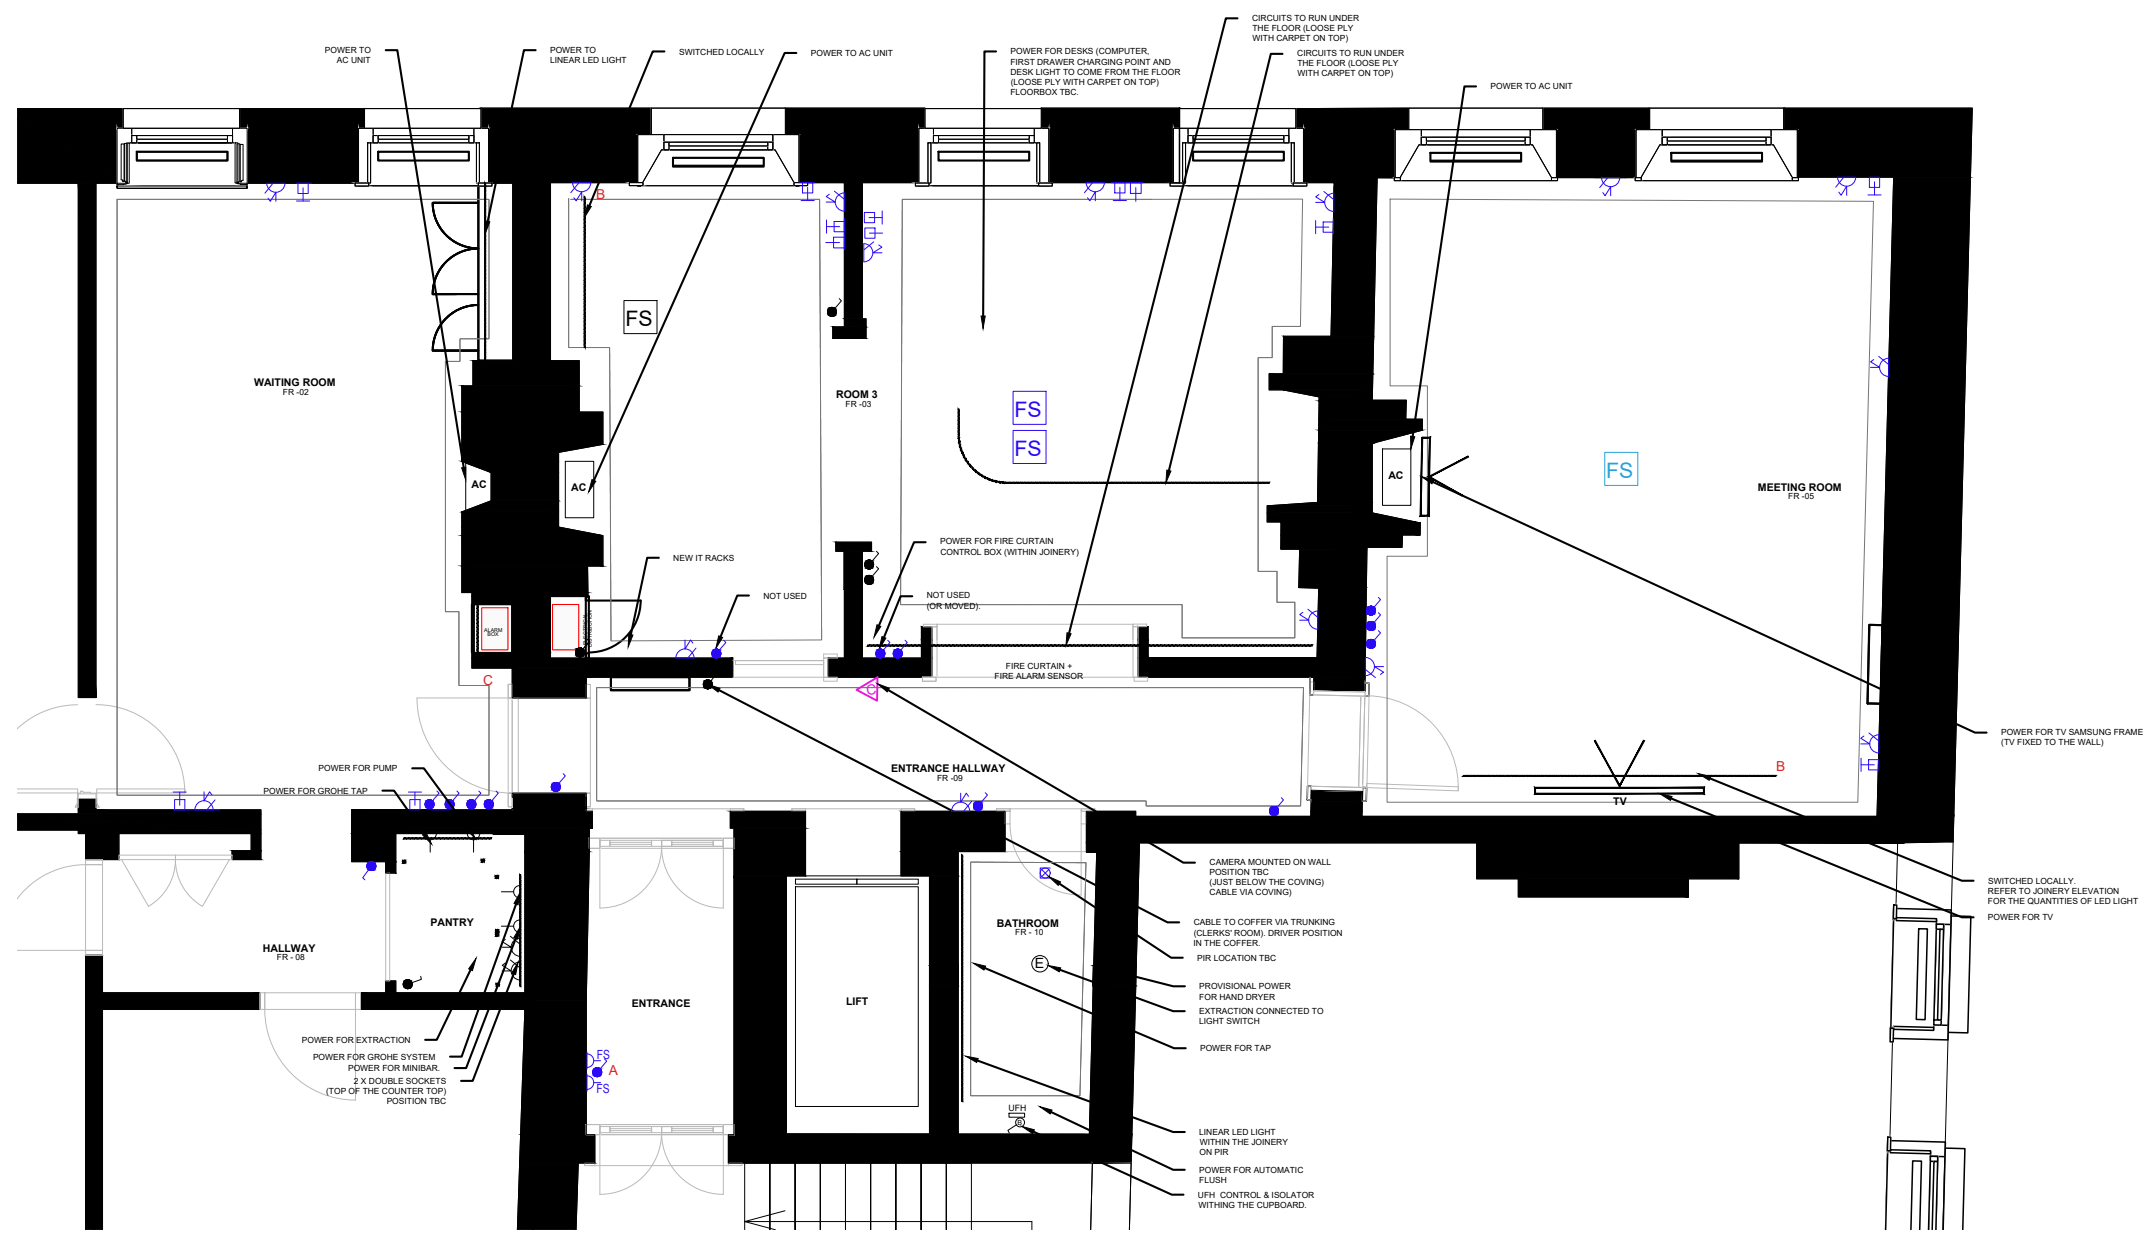


<p>SWITCHES/PLATES FOCUS SB Horizon Classic Visible hex screws</p> <p>Finish: Polished Brass</p> 	<p>SOCKETS FOCUS SB Paintable Rockers &amp; Sockets White</p> <p>Finish: to match paint</p> 	<p>A SOCKETS FOCUS SB Prism Rockers &amp; Sockets White</p> 	<p>B LOCAL SWITCH HAFELE LED Motion Detector Switch, Modular, for use with Loox LED Lights Art. no. 833.89.129 Diameter 13.5 mm Length 56 mm Drill hole Ø 12 mm Material Plastic Colour Silver coloured</p> 	<p>C MAGNETIC DOOR STOP Fire Protection Shop DRG Brass Decorative 24Vdc 112N Door Retainer DRGDR001/001 Protection Rating: IP51</p> <p>Finish: Brass</p> 
--	---	---	---	--

GENERAL NOTE:  
 - KEEP EXISTING SOCKET HEIGHT  
 - KEEP EXISTING SWITCHED HEIGHT  
 - USE ROCKER SWITCHES. ROTARY DIMMERS ONLY FOR DIMMABLE LIGHTS.  
 - MAX 3-GANG SWITCH ON A DOUBLE SOCKET SIZE BACKBOX







 
 
 


 





**01** Proposed Small Power Layout  
 scale 1:75 @A3

Drawing Status  
**PRELIMINARY**

- No information or designs contained within this document should be copied or reproduced without the specific consent of Gunter & Co Interiors Ltd.
- Do not scale from this drawing. Any areas, measurements or distances given are approximate only and should be confirmed before design or fabrication.
- Any drawings, photos, or computer generated images shown are indicative and cannot be guaranteed to represent the complete interiors or exteriors of a scheme.
- © 2017 Gunter & Co Interiors Ltd. All Rights Reserved

Notes A3

**LEGEND**

-  LINEAR LED LIGHT
-  DOUBLE SOCKET
-  SINGLE SOCKET
-  FUSED SPUR
-  TELEPHONE OUTLET
-  CAT6 NETWORK POINT
-  UFH CONTROL & ISOLATOR
-  SWITCH
-  EXTRACTION
-  CAMERA
-  AC UNIT
-  FLOOR SOCKET OUTLET
-  NEW POSITION
-  EXISTING POSITION
-  MODIFIED POSITION

NOTE: FOR DESIGN INTENT ONLY.  
 INFORMATIONS TO BE CHECKED ON  
 SITE BEFORE CONSTRUCTION.

Rev	Note	Date
Project Title <b>FALCON</b>		
Drawing Title <b>Proposed Small Power Layout Proposed Layout</b>		
Date 27.11.2020	Scale 1:75 at A3	Drawn By MB
Drawing No <b>FL- FF - 131</b>	Rev -	

.Gunter&Co\_G&\_Gunter&Co\_black.jpg

Unit 1.23 The Plaza  
 535 King's Road  
 London, SW10 0SZ  
 United Kingdom  
 +44 (0)20 7993 8583