



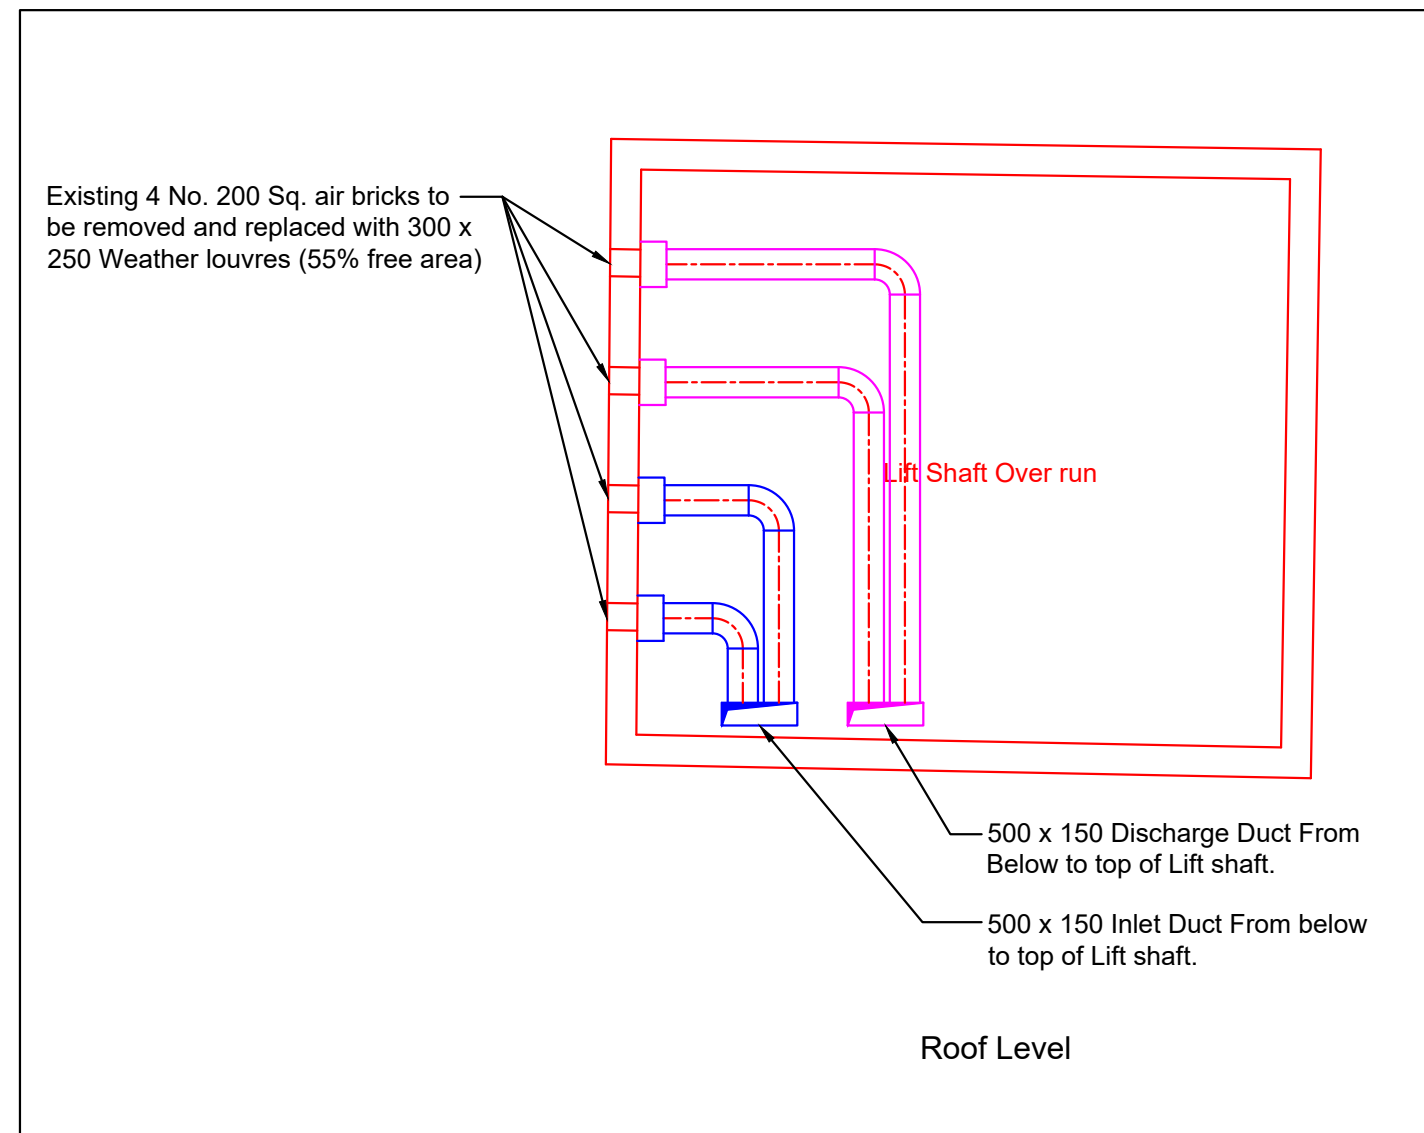

Existing Air Bricks

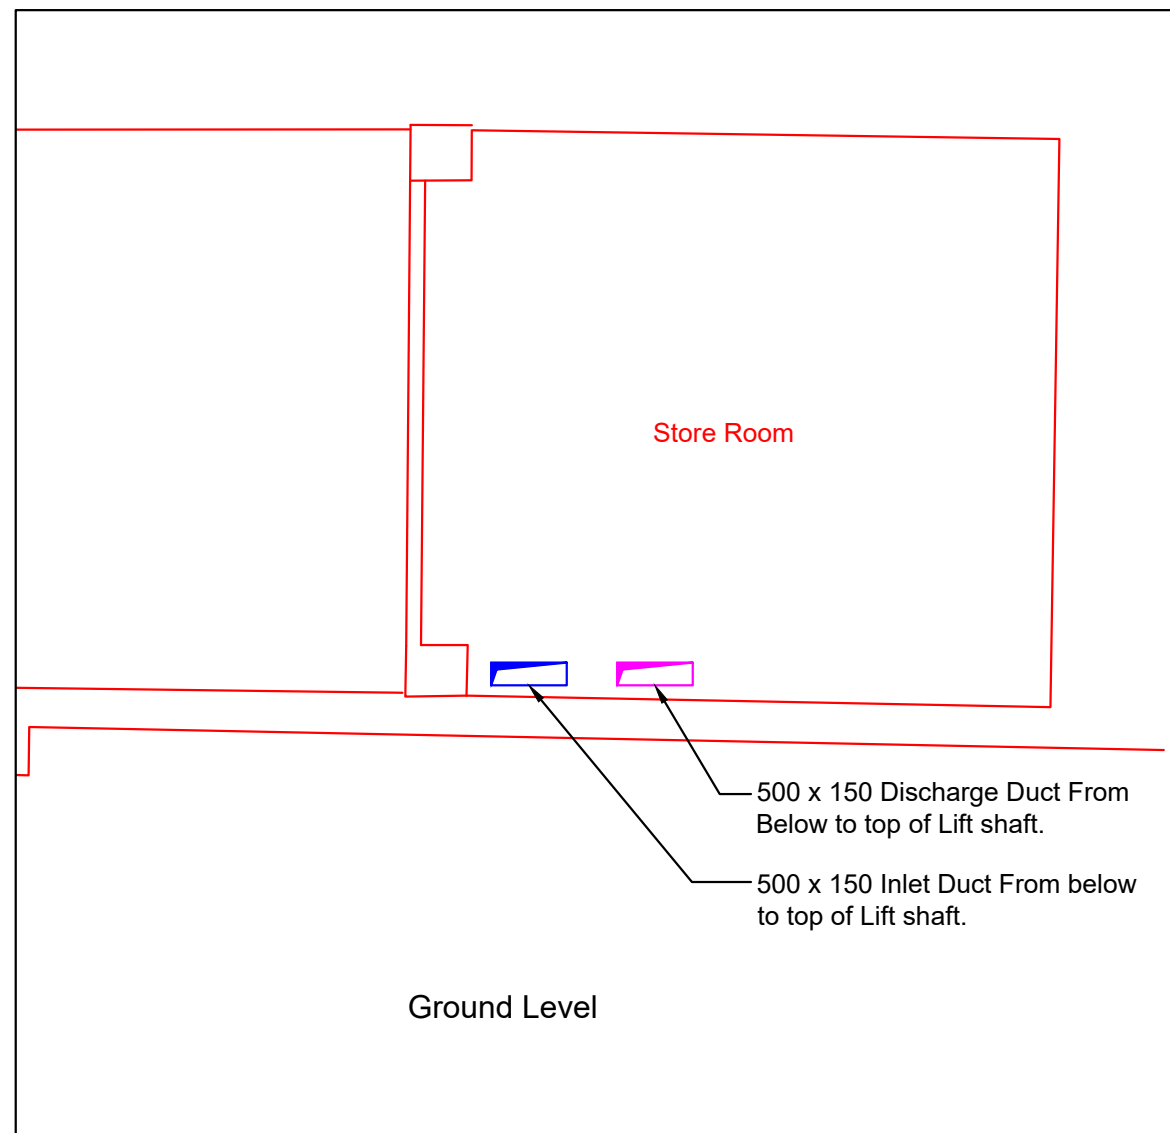

Proposed Louvres



Revisions

Client

Peldon Rose

Project title

Heals Building
Torrington Place
London

Drawing title

Roof Level proposed
Ventilation Layout

Drawing No: C-xxx-B-V-002

Revision: ----

Date: 14/12/20

Scale: 1:50

Drawn: MJL

Checked: ----



53 High Street, Ewell, Surrey
KT17 1RZ
E: accounts@mistrallondon.com
T: 020 8786 8754