
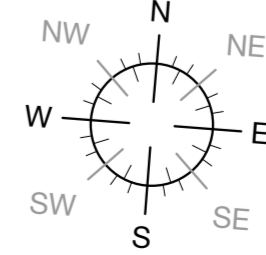
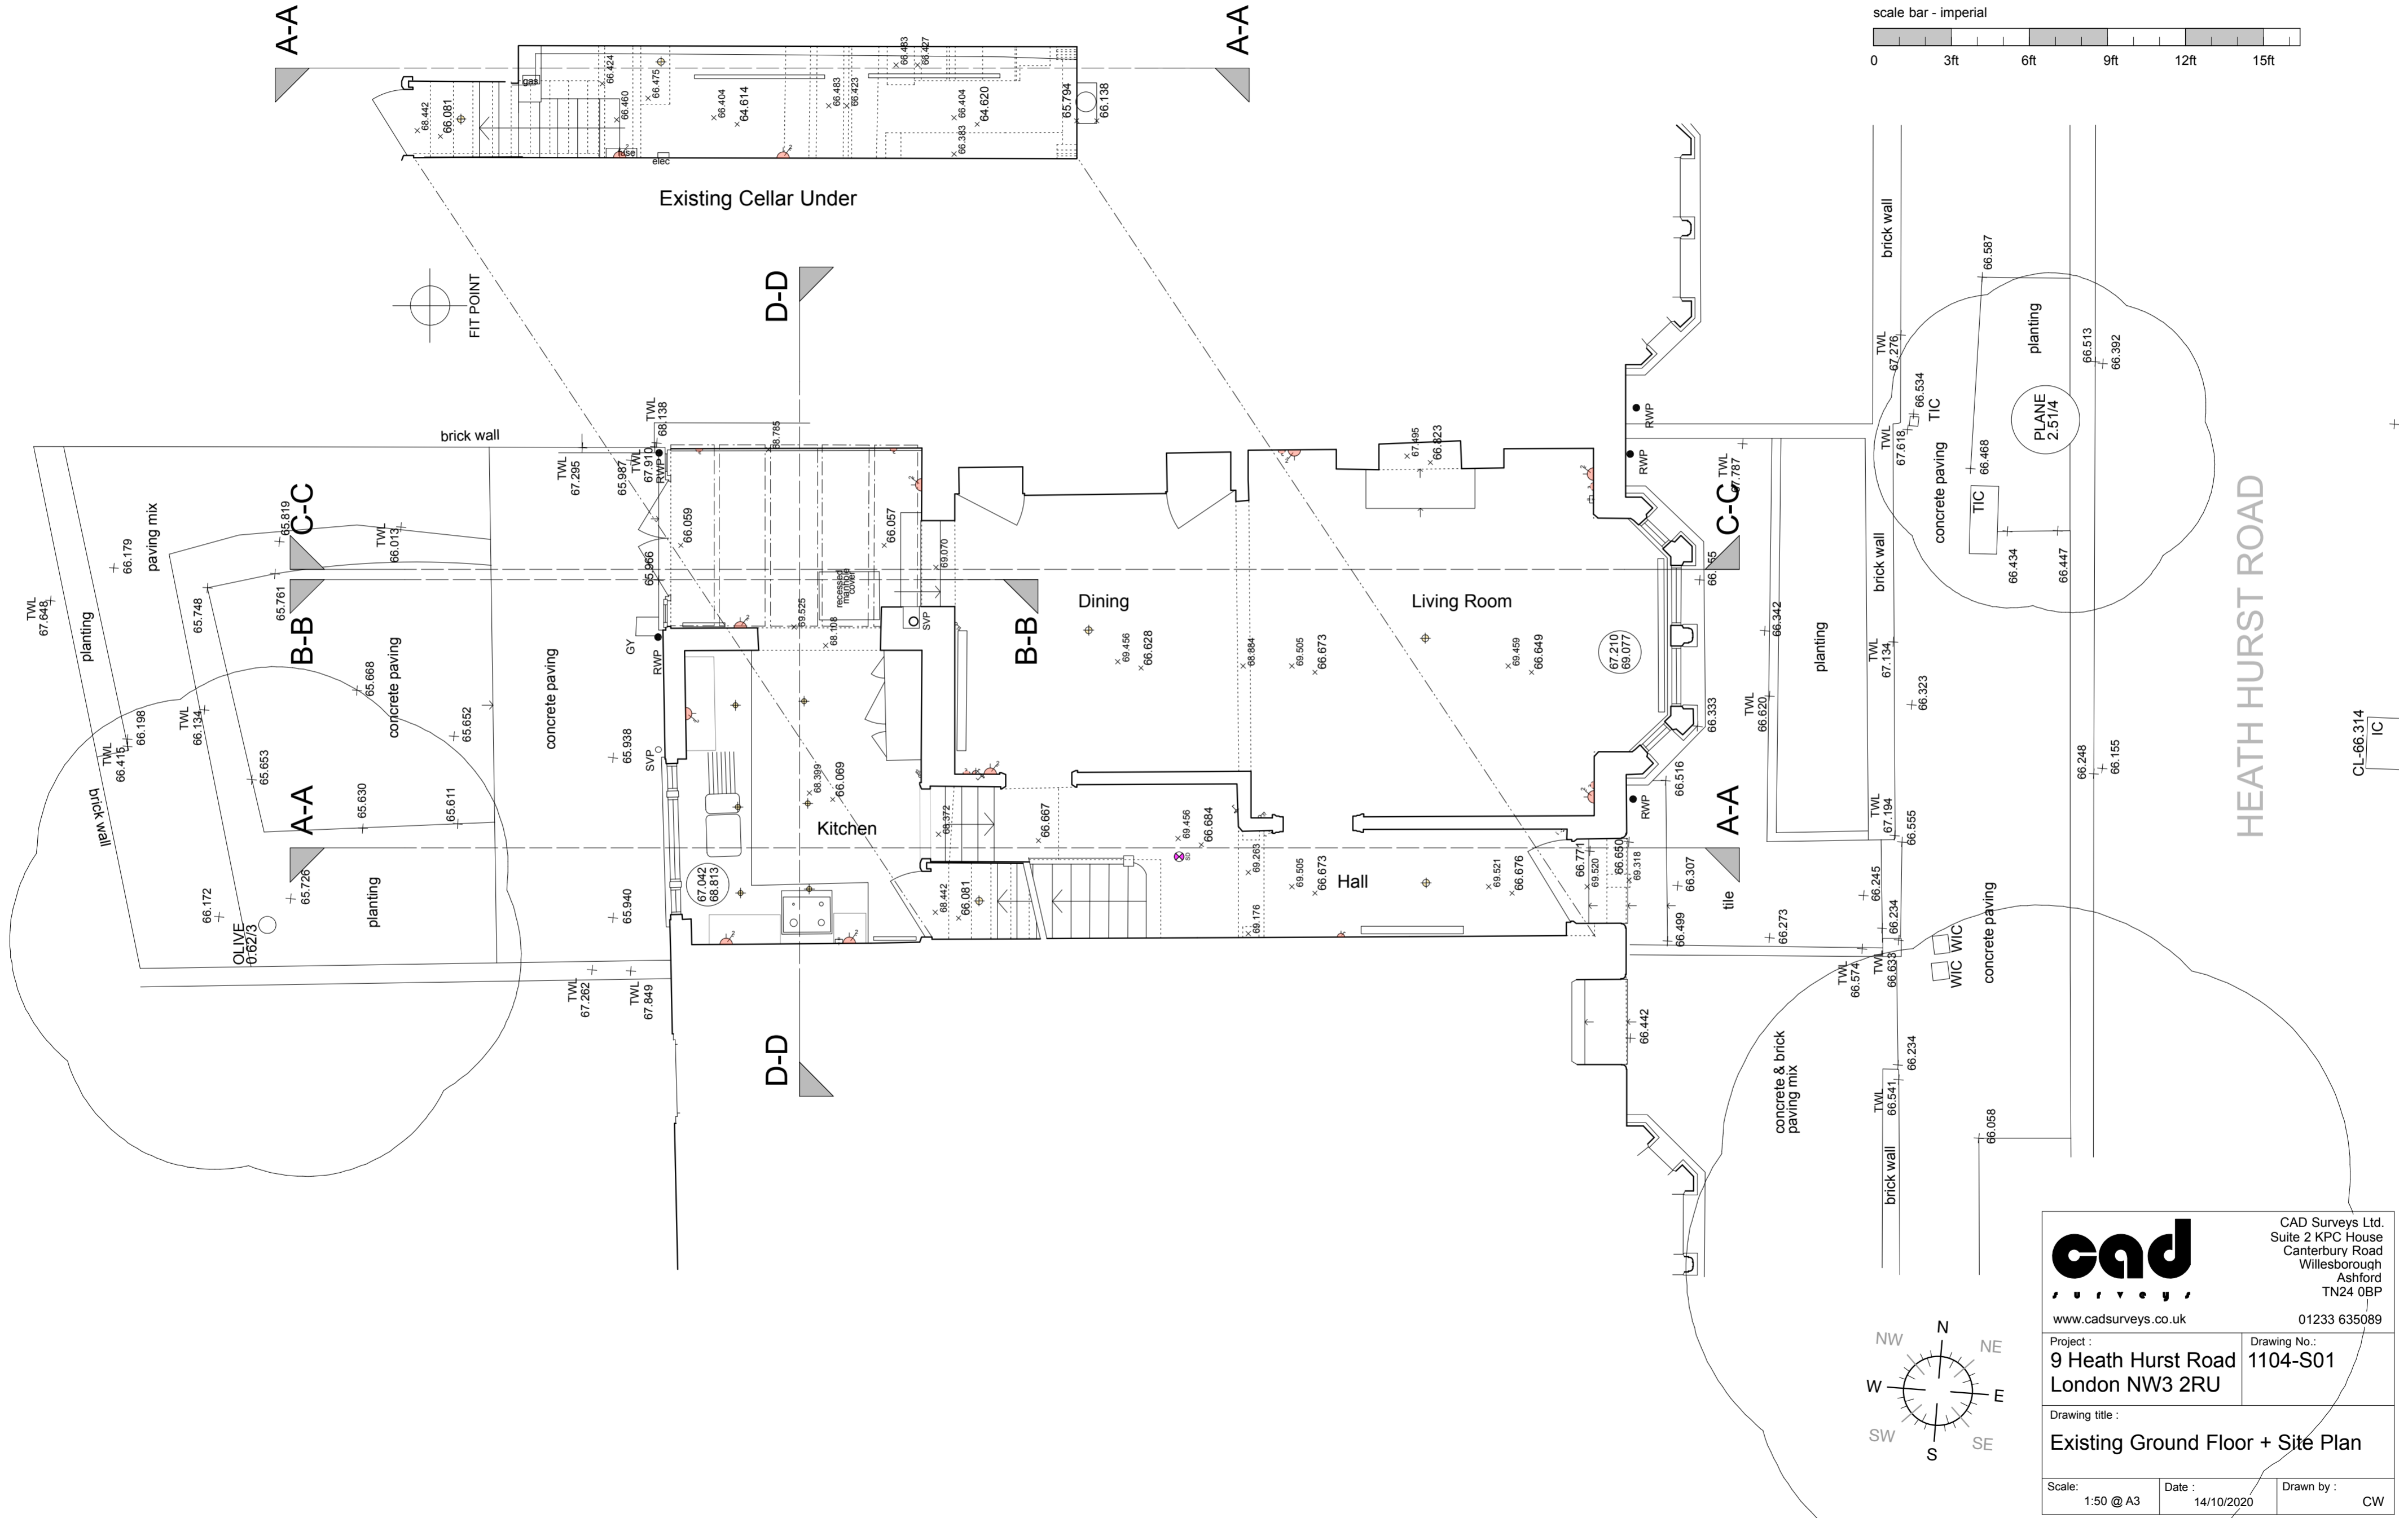


Heating zones / routes	Smoke Detector	Thermostat	Plug Socket (Switched)	Manter Light
Inclusive drainage routes	Heat Detector	Heating Manifold	Plug Socket	Lighting
Garden Tap	Extractor Fan	CAT 6 Port	Shower Socket	Wall Light
CCTV Camera	Alarm Keypad	Coaxial/Fiber Point & BT Point	Router Switch	Pendant Light
Wi-Fi Access Point (CAT 6)	Interphone Panel	5 Amp Point	Dimmer Switch	Directional Downlight
Calling Speaker	Air Conditioning Controller	Fixed Switch	External Spike Light	Fixed Downlight
			LED Tape Light	

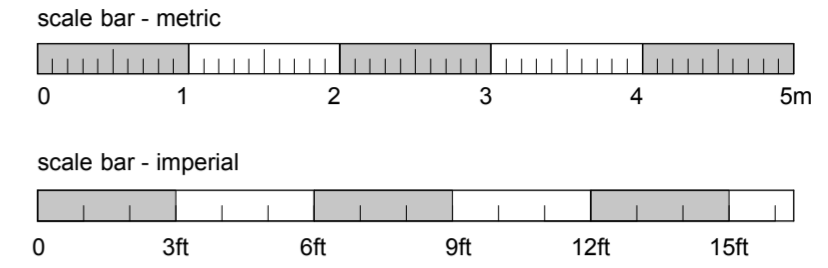

www.cadsurveys.co.uk

CAD Surveys Ltd.
Suite 2 KPC House
Canterbury Road
Willesborough
Ashford
TN24 0BP

01233 635089

Project : 9 Heath Hurst Road London NW3 2RU		Drawing No. : 1104-S01	
Drawing title : Existing Ground Floor + Site Plan			
Scale: 1:50 @ A3	Date : 14/10/2020	Drawn by : CW	