




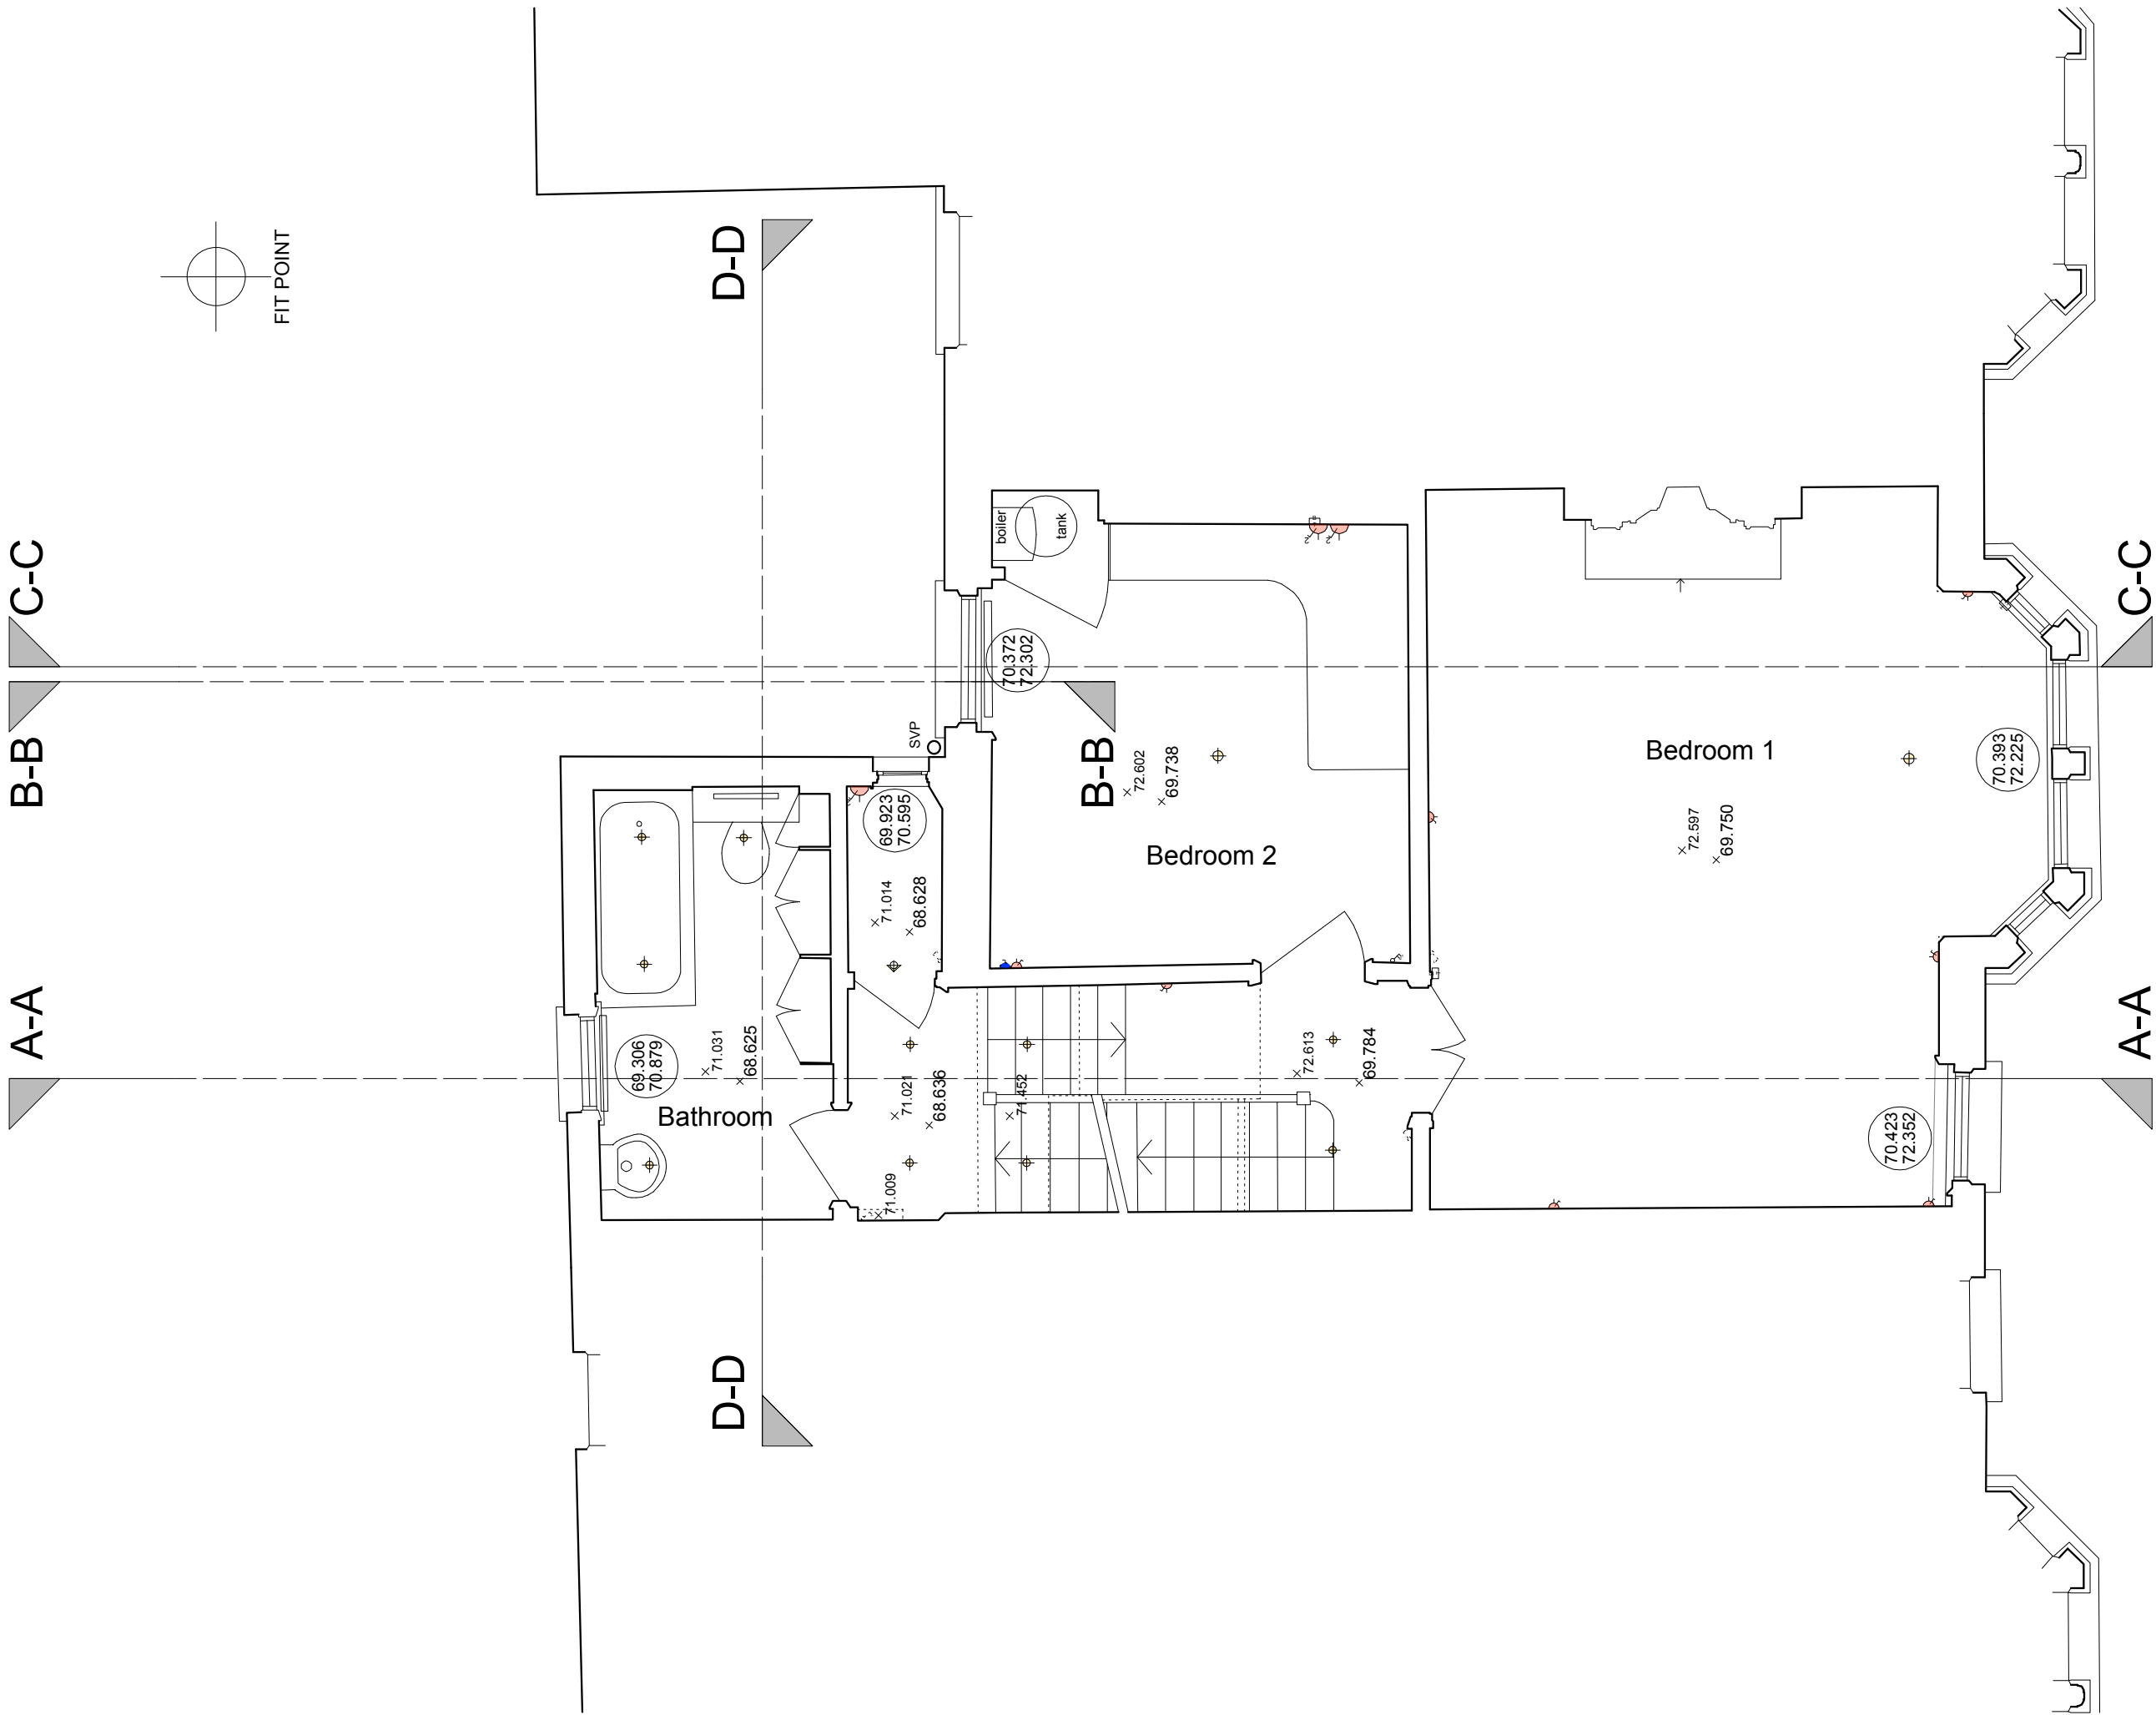

Heating zones / routes	Smoke Detector	Thermostat	Plug Socket (Switched)	Marker Light
Indicative drainage routes	Heat Detector	Heating Manifold	Plug Socket	Uplighter
Garden Tap	Extractor Fan	CAT 6 Port	Shower Socket	Wall Light
CCTV Camera	Alarm Keypad	Coaxial/Sky Point & BT Point	Rocker Switch	Pendant Light
Wi-Fi Access Point (CAT 6)	Entryphone Panel	5 Amp Point	External Spike Light	Directional Downlight
Ceiling Speaker	Air Conditioning Controller	Fixed Switch	LED Tape Light	Fixed Downlight

SERVICE KEY

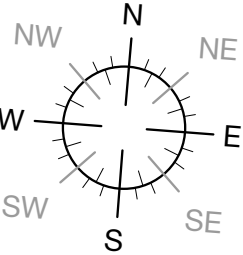

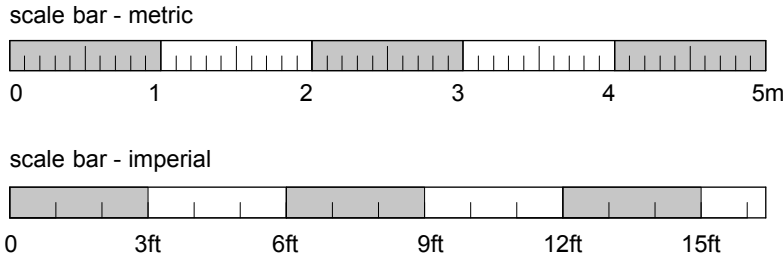

CAD Surveys Ltd.

Suite 2 KPC House

Canterbury Road

Willesborough

Ashford

TN24 0BP

www.cadsurveys.co.uk

01233 635089

Project :

Drawing No.:

9 Heath Hurst Road

1104-S02

London NW3 2RU

Drawing title :

Existing First Floor Plan

Scale:

Date :

Drawn by :

1:50 @ A3

14/10/2020

CW