






EXISTING REAR ELEVATION

SCALE: 1:50

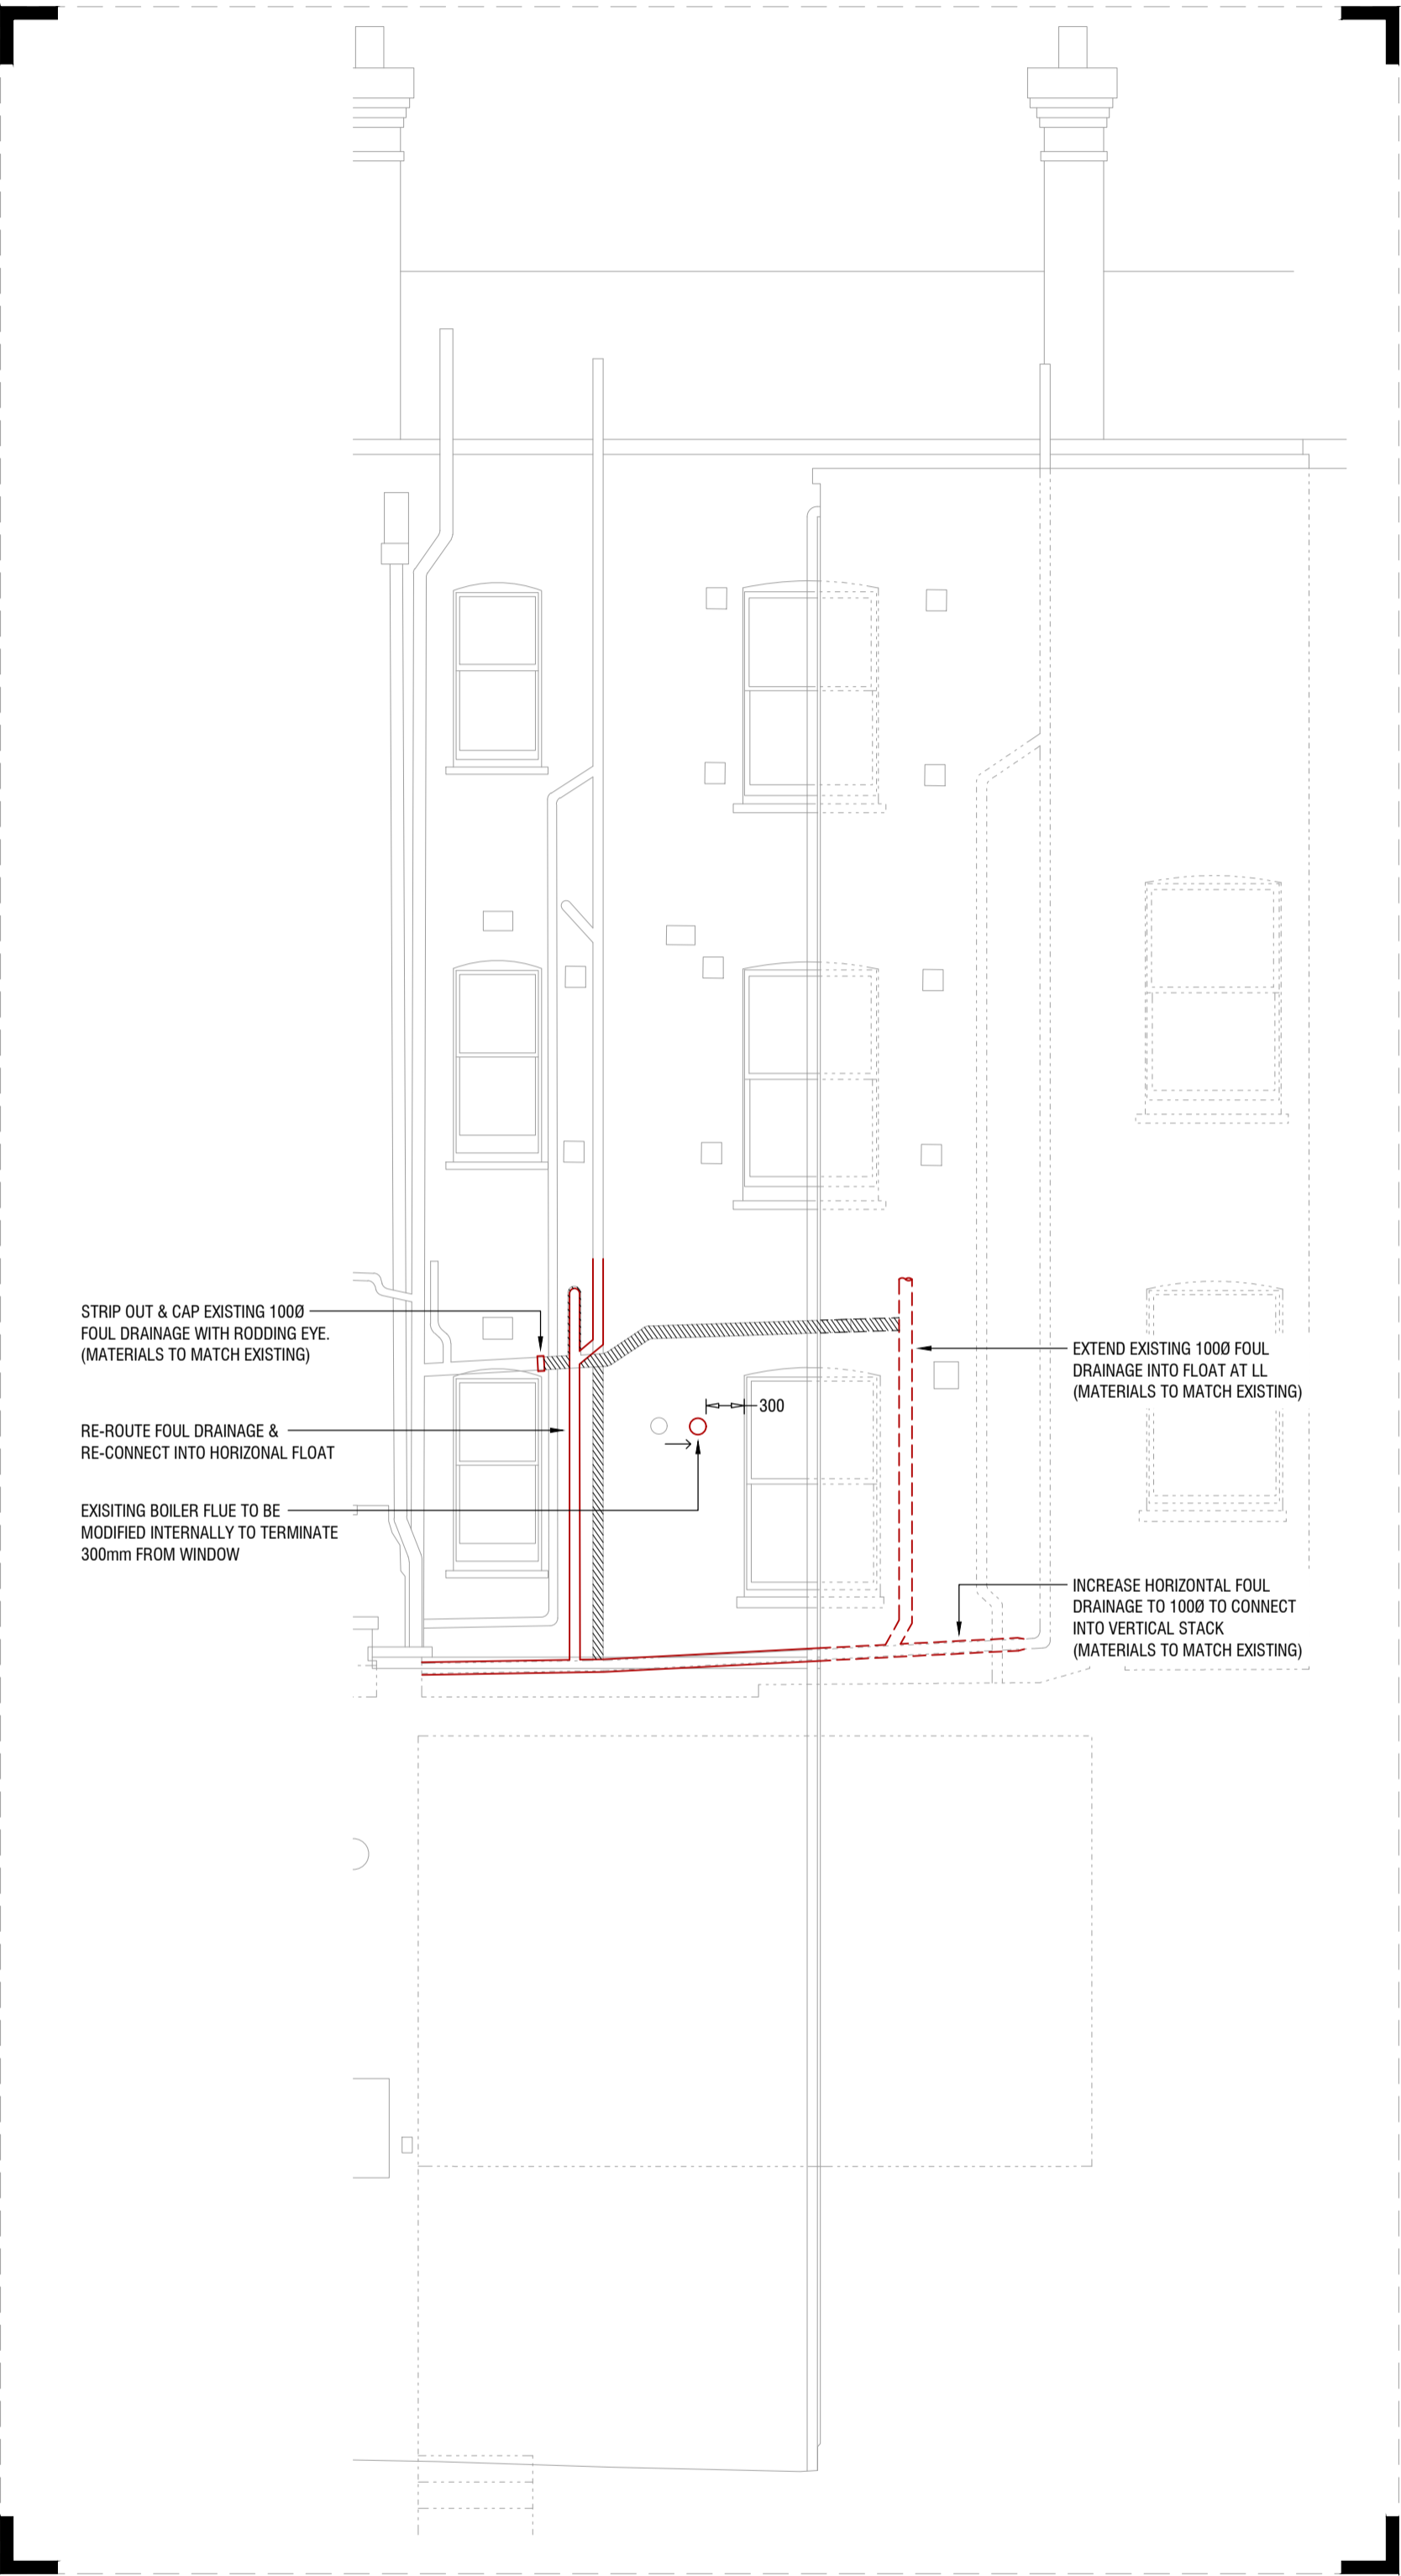


PROPOSED REAR ELEVATION

SCALE: 1:50

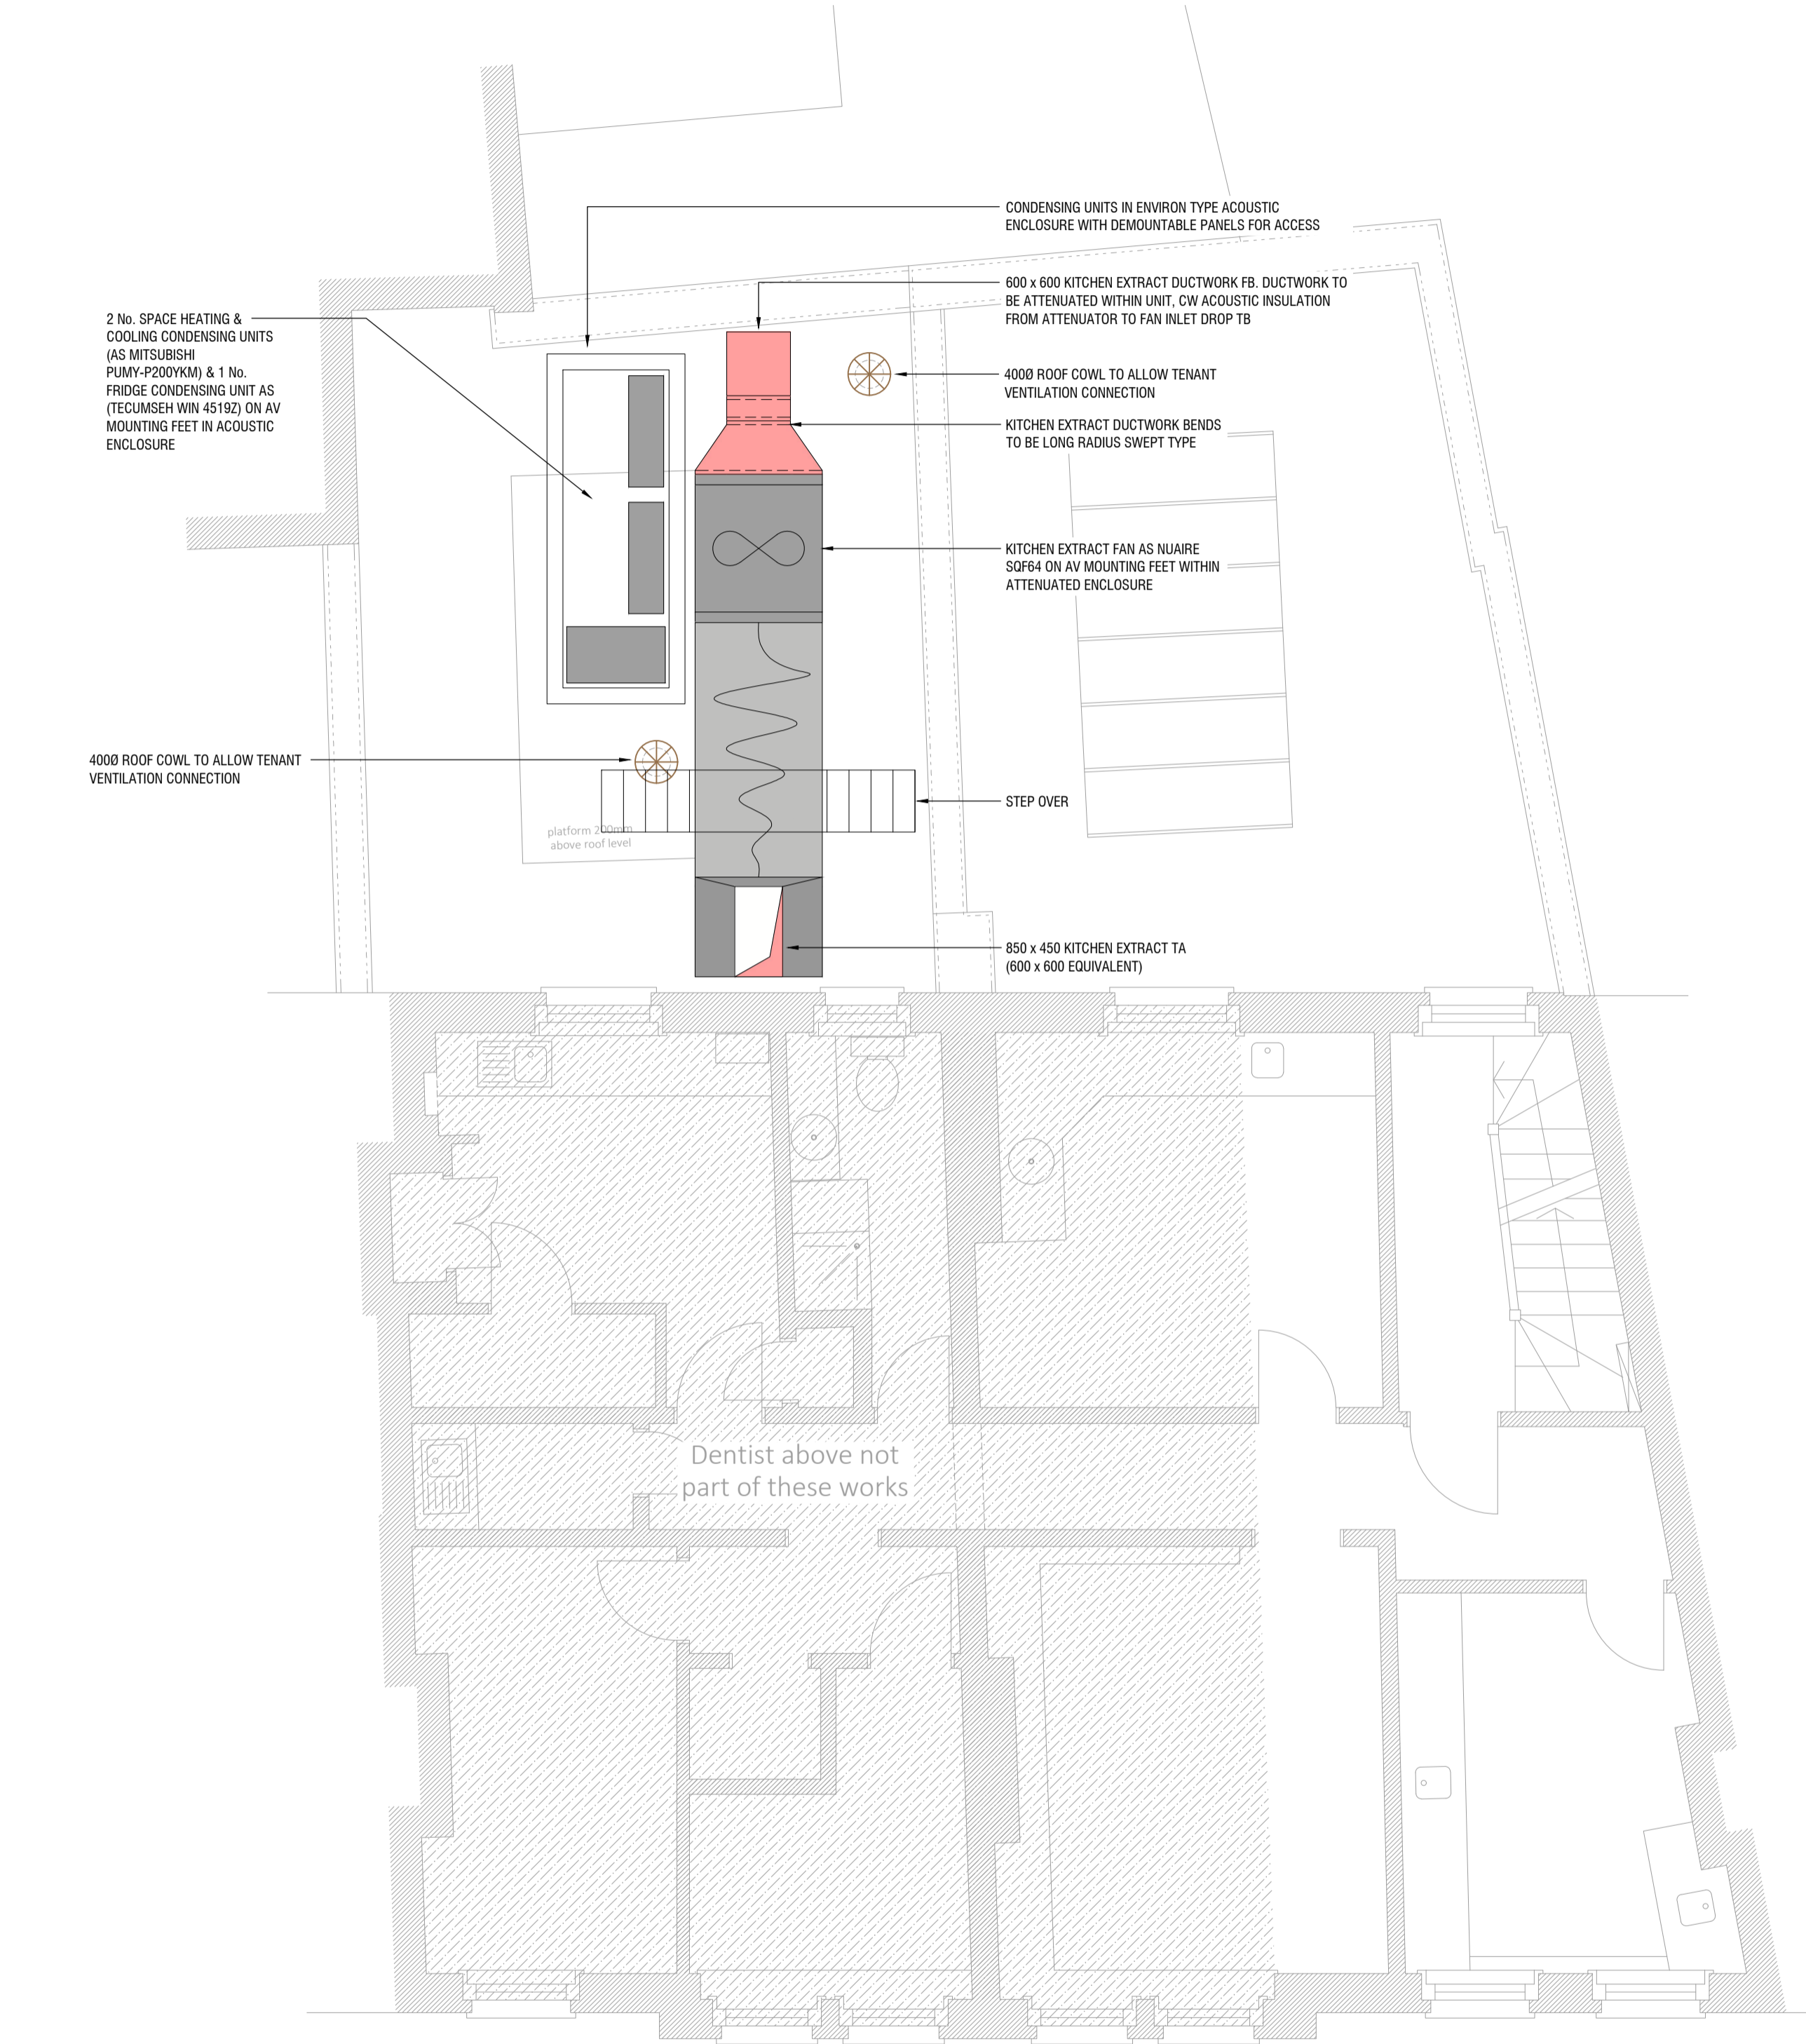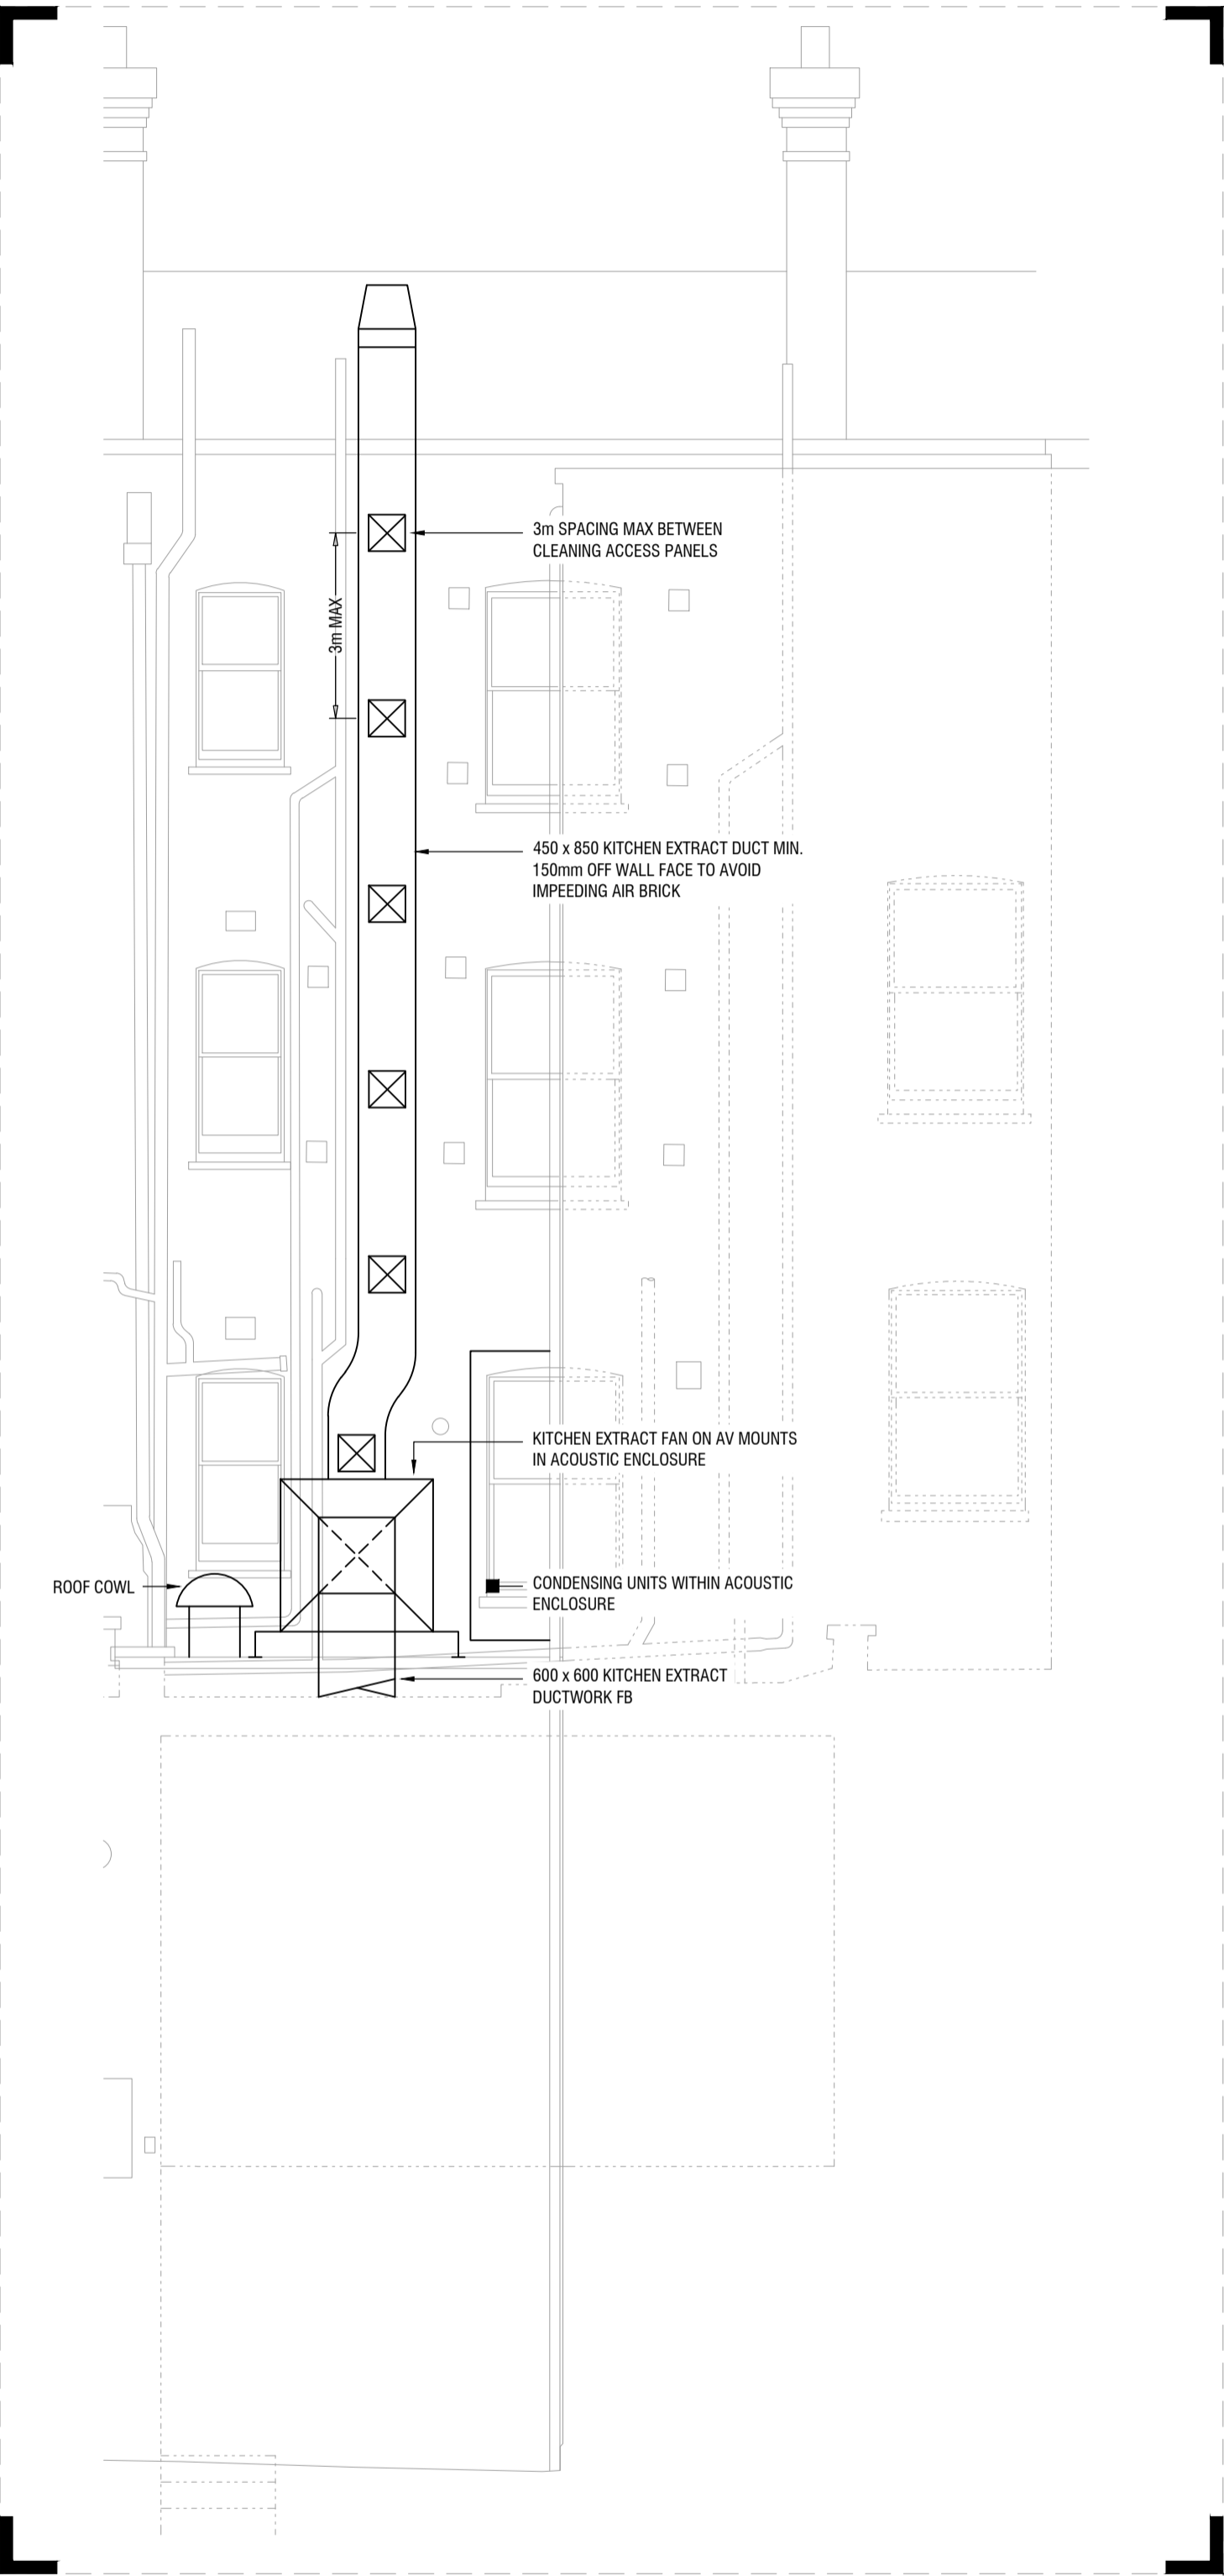

DRAWING NOTES

 - THIS DRAWING SHALL BE READ IN CONJUNCTION WITH ALL PROJECT RELEVANT QUINNROSS INFORMATION, THE CONTRACT SPECIFICATION, ALL ARCHITECTS & CONSULTANTS LATEST INFORMATION & ALL RELEVANT THIRD PARTY INFORMATION.
- ALL DIMENSIONS ARE IN MILLIMETRES (mm) UNLESS OTHERWISE STATED.



S:\PROJECTS\P190X\P1934 - 64 GOODGE STREET (F&T)\03 - DRAWINGS\3 - IN PROGRESS\3 - FLOOR PLANS\P1934-(M3)-4.dwg - PRINTED FROM AUTOCAD BY AMAINES ON 18.01.2021 - 14:07

P2	18.01.20	ISSUED FOR COMMENT	AM	DC
P1	15.12.20	ISSUED FOR COMMENT	AM	DC
REV	DATE	DESCRIPTION	DRN	CHK

THIS DRAWING IS THE PROPERTY OF QUINNROSS CONSULTANTS LTD. & IS ISSUED BY COURTESY. IT MUST NOT BE COPIED OR DISCLOSED TO THIRD PARTIES WITHOUT WRITTEN PERMISSION OF THE COMPANY.

FOR COMMENT

CLIENT

F&T

PROJECT

64 GOODGE STREET
LONDON
W1

TITLE

1ST FLOOR
MECHANICAL SERVICES
VENTILATION LAYOUT

QuinnRoss
CONSULTANTS LTD

SCALE

1:50

SIZE

A1

PLOTTED

AMAINES

DRAWING No.

P1934-(M3)-4-101

REV

P2

KENT | ME9 8NY

LONDON | N1 9JU

T: 01785 841035

W: www.quinnross.com

E: admin@quinnross.com

Ver 3.2