


FOR
PLANNING

T02	Updated as indicated	RM	MR	09.03.18
T01	Stage 4 Issue	RM	MR	29.09.17

BDP.

16 Brewhouse Yard
Clerkenwell
London
EC1V 4LJ
United Kingdom

T +44 (0)20 7812 8000
www.bdp.com

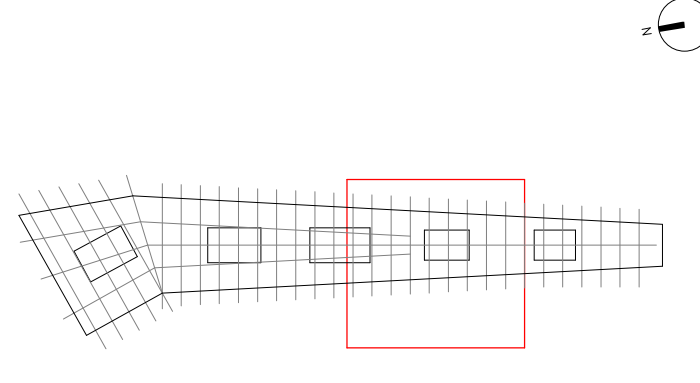

For Tender

Title: Level 12 External Roof Lighting Layout - Sheet 02

Date: 29.09.17

Project: P2007133

Scale: 1 : 100


Sheet: A0

Client: RM

Contract: MR

Drawing No: KXC-A-001-J-BDP-63-11206

T02

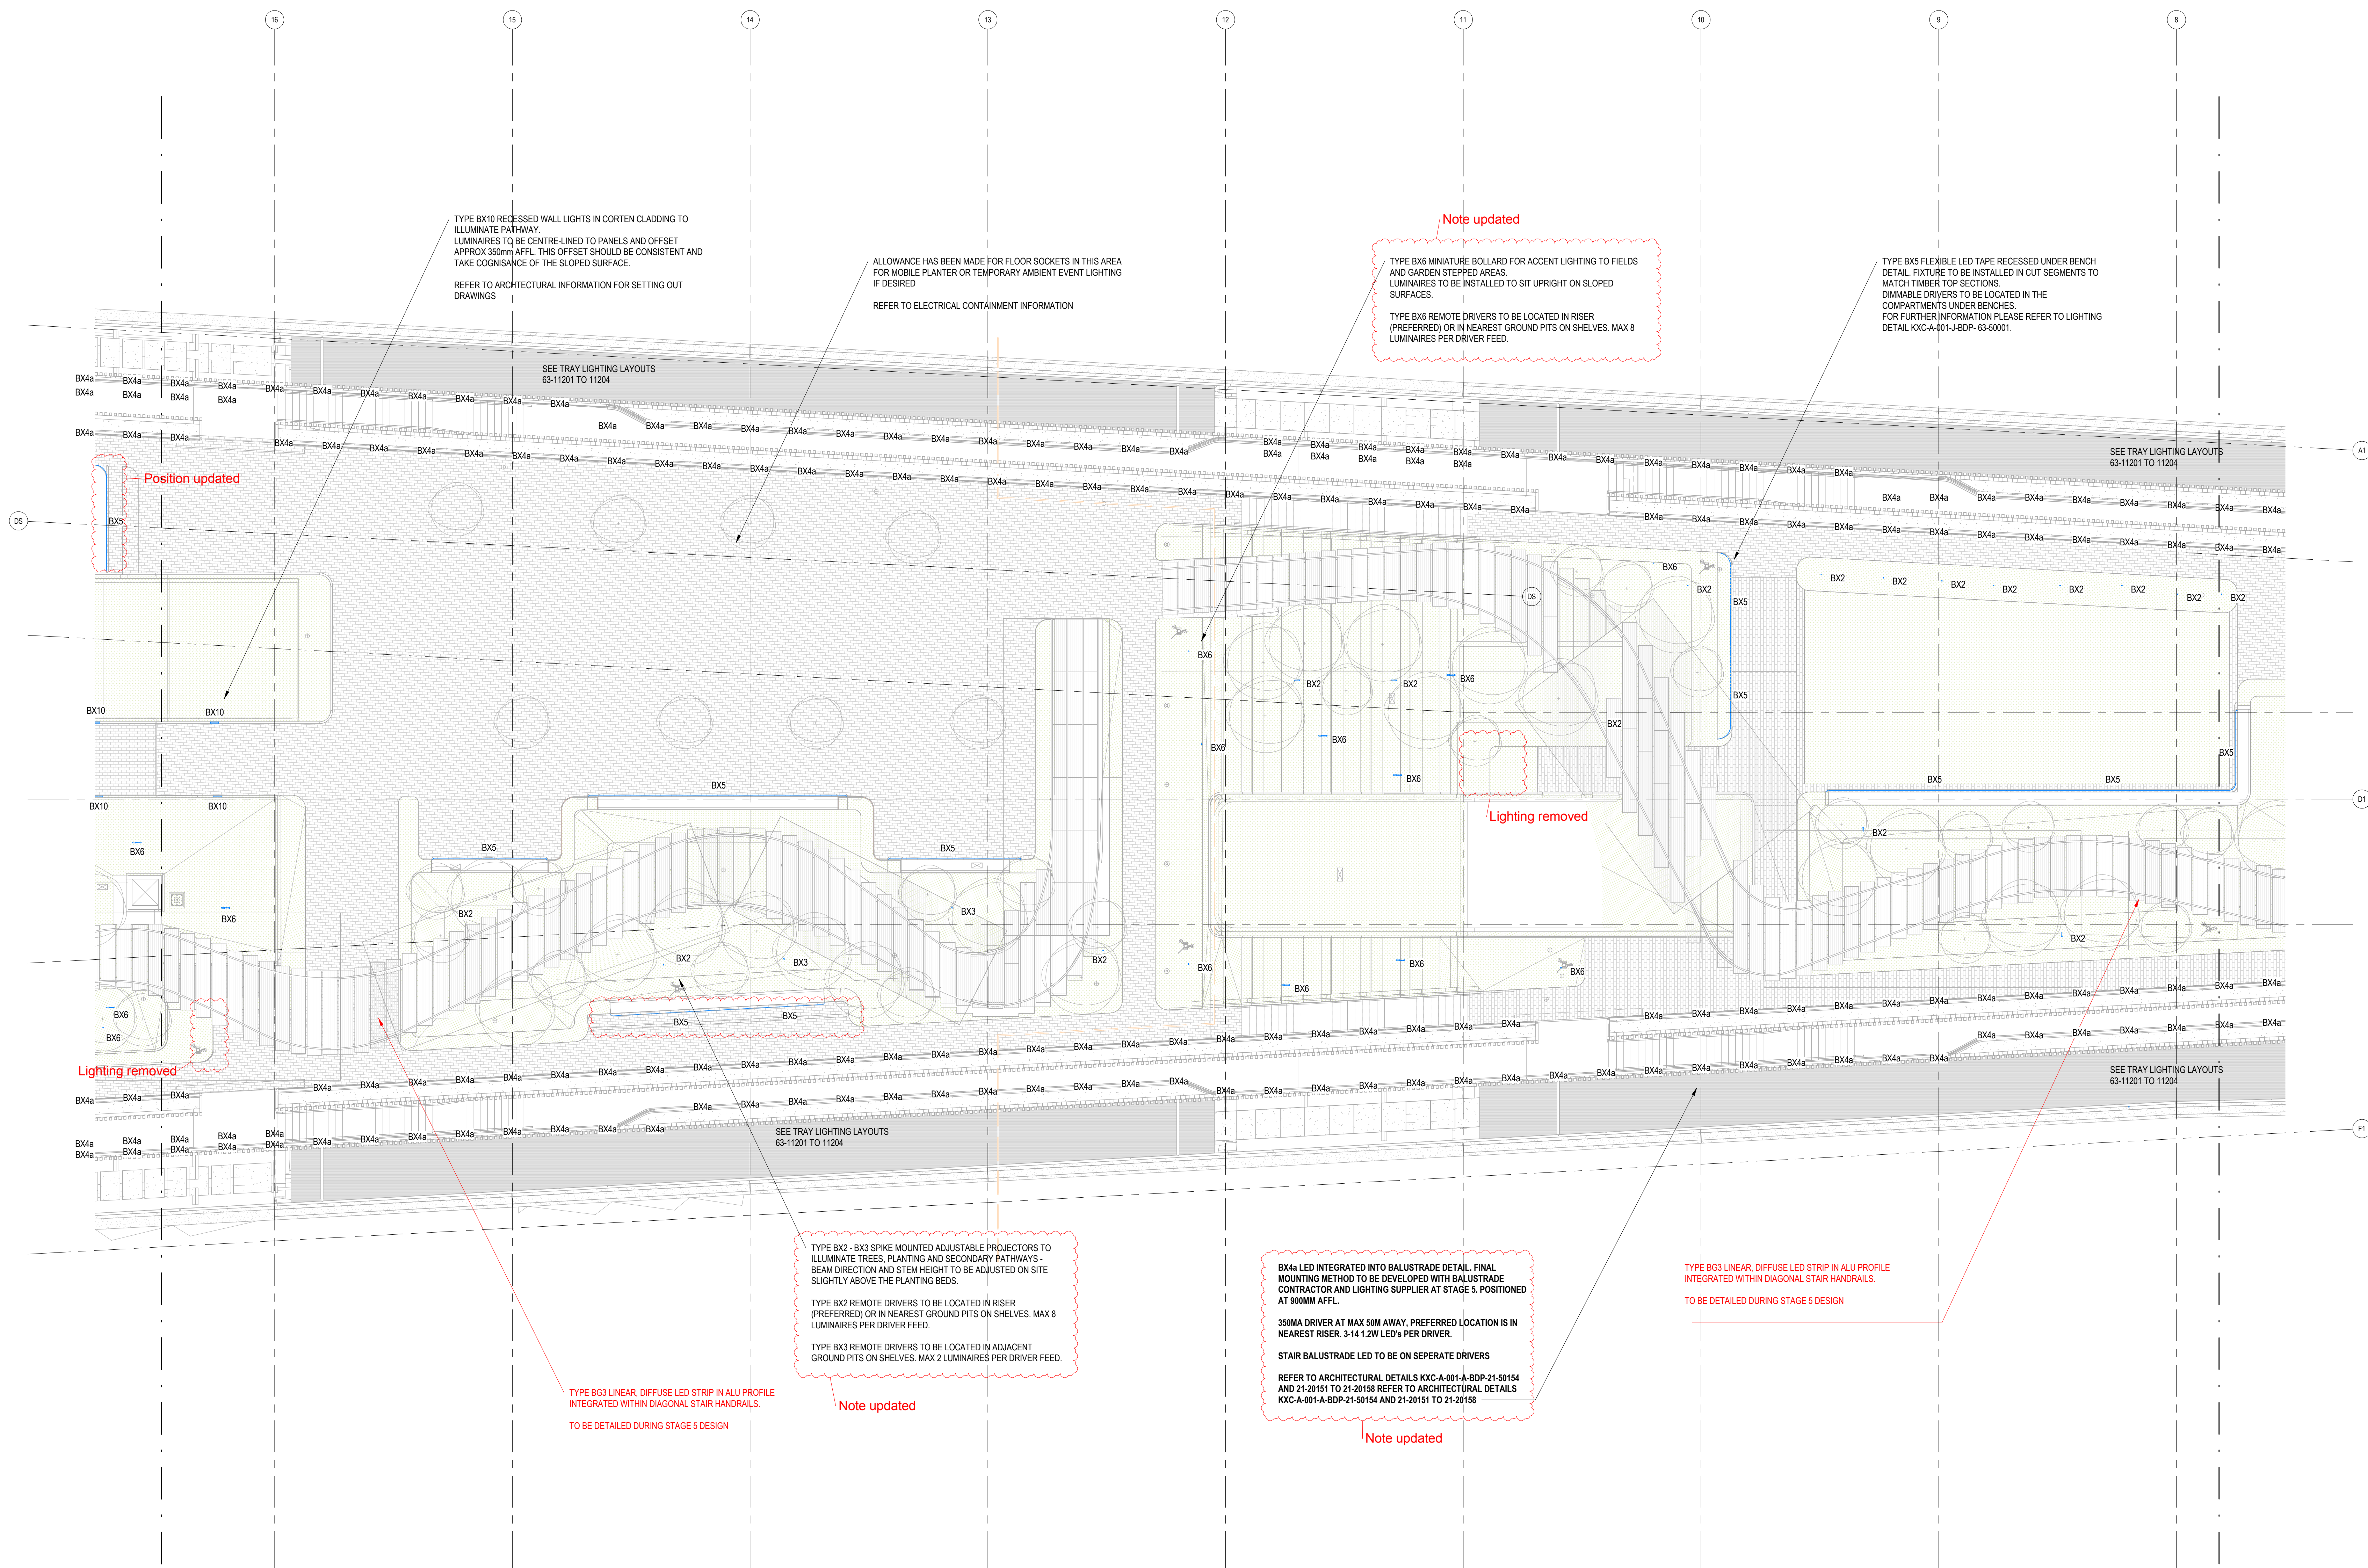

For continuation refer to Sheet 3 of 4

For continuation refer to Sheet 1 of 4