



1 Service Yard Alarm Valve Room Layout
1:50

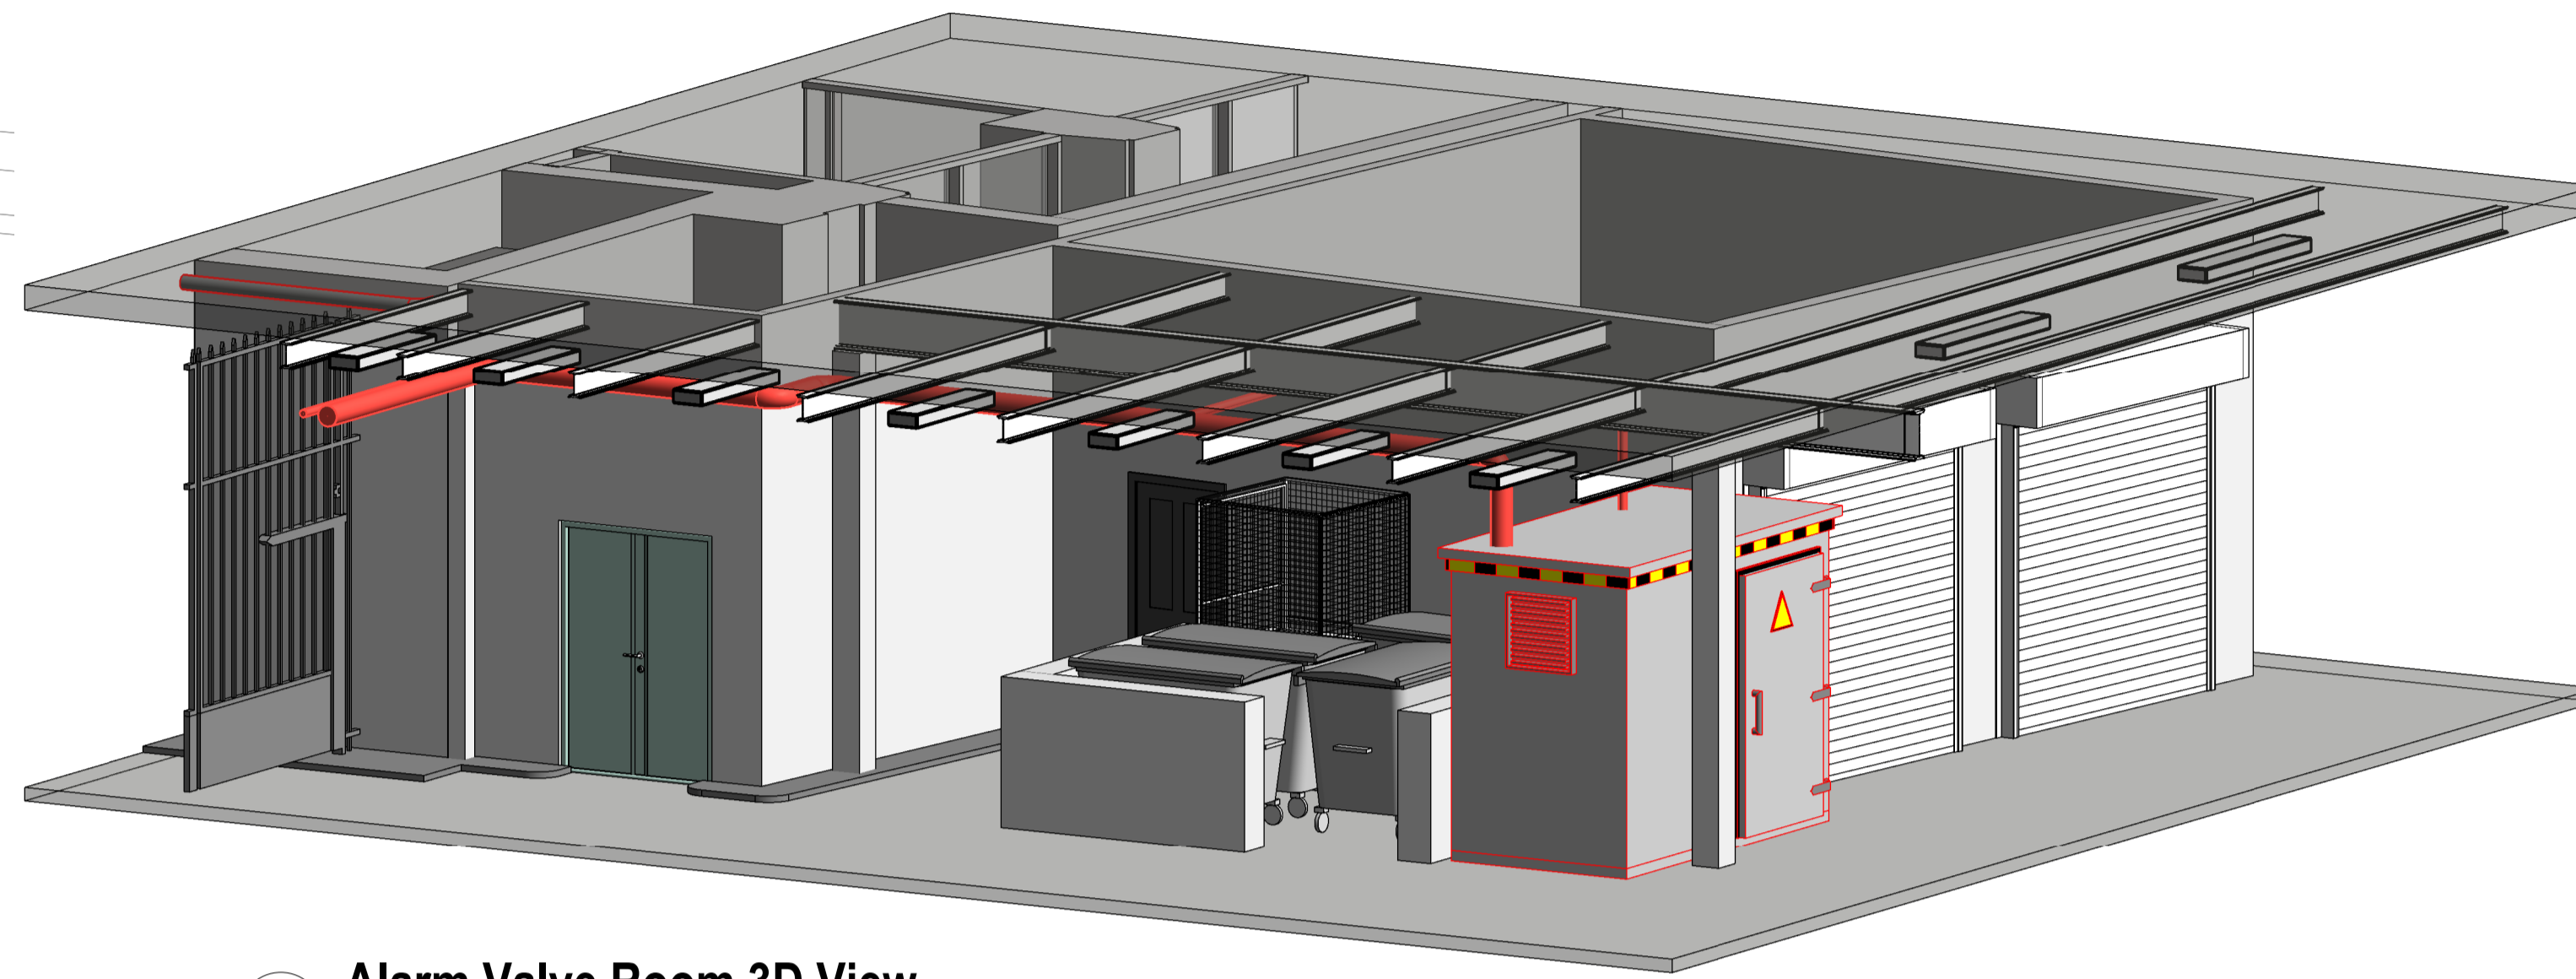


5 Alarm Valve Room 3D View

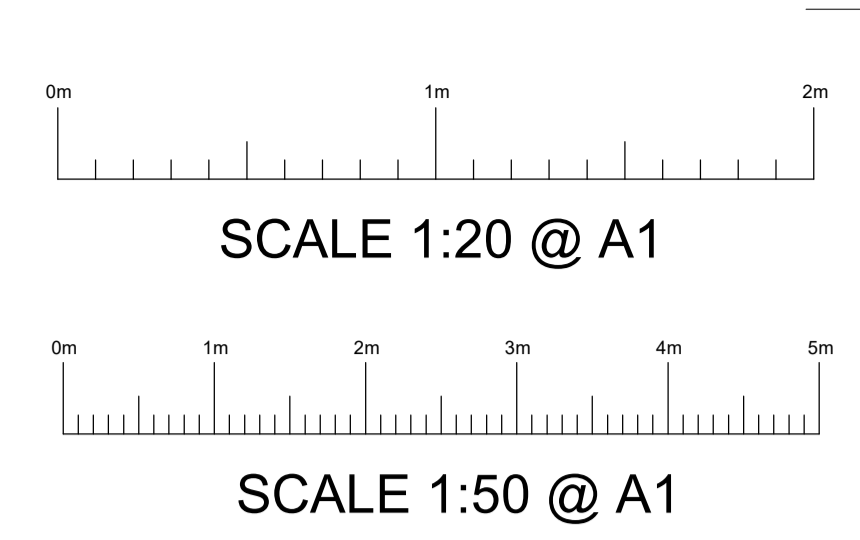


- NOTES
1. THIS IS A PRE APPLICATION INFORMATION DRAWING AND SHALL NOT BE USED FOR CONSTRUCTION OR INSTALLATION PURPOSES. DO NOT SCALE OFF THIS DRAWING.
 2. ALL DIMENSIONS TO BE VERIFIED ON SITE BEFORE COMPLETING SHOP DRAWINGS AND SETTING OUT WORK
 3. THIS DRAWING SHALL BE READ IN CONJUNCTION WITH THE TECHNICAL SPECIFICATION AND ASSOCIATED EQUIPMENT SCHEDULES.
 4. FOR FIRE COMPARTMENTATION DETAILS SEE DRAWING: SP08
 5. FOR BRACKET FIXING DETAILS SEE DRAWING: SP07

LEGEND:
— SPRINKLER PIPEWORK

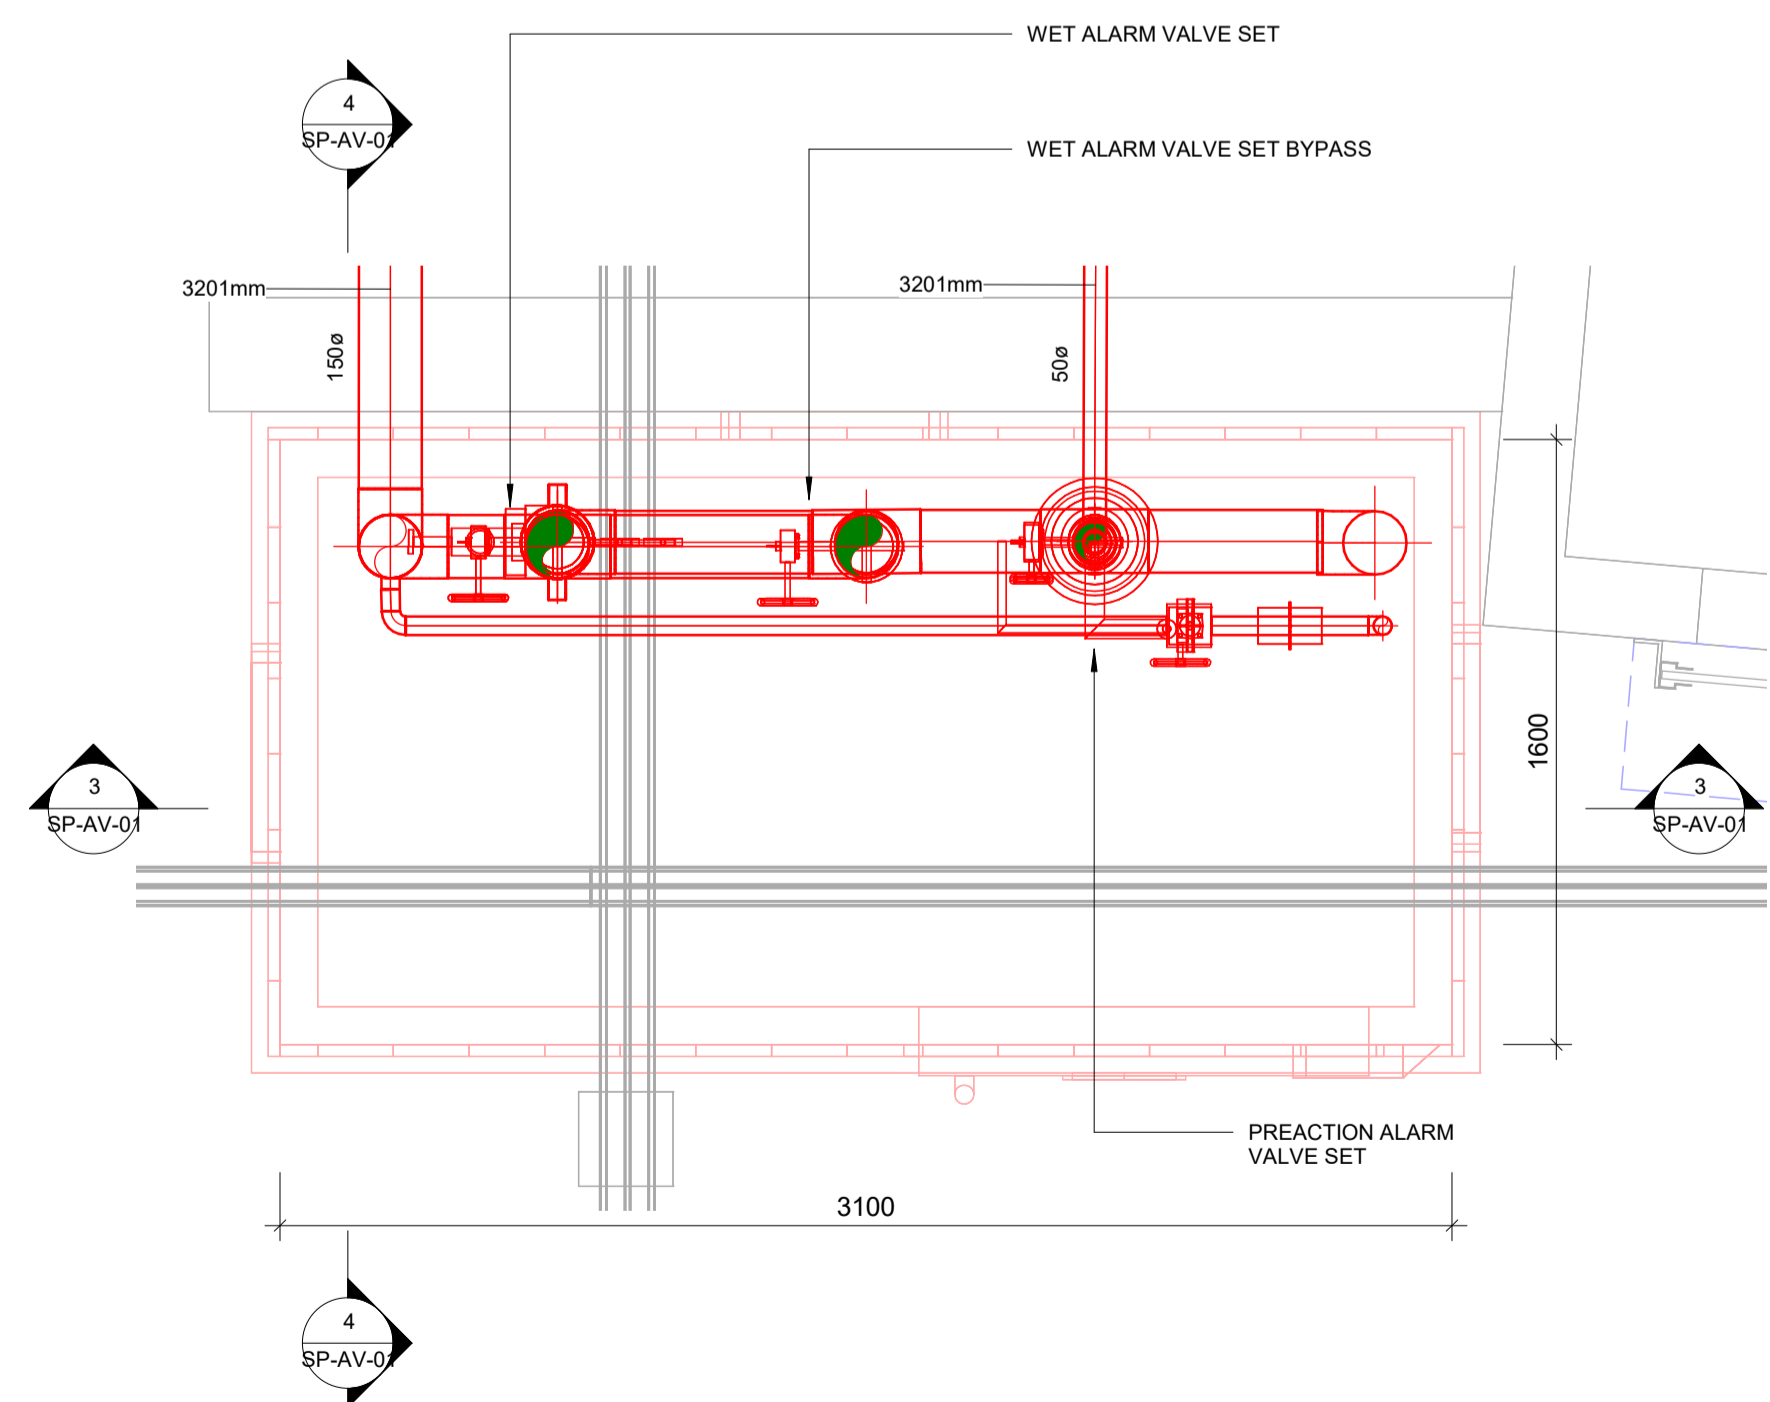

2 Service Yard Alarm Valve Room Floor Plan
1:20

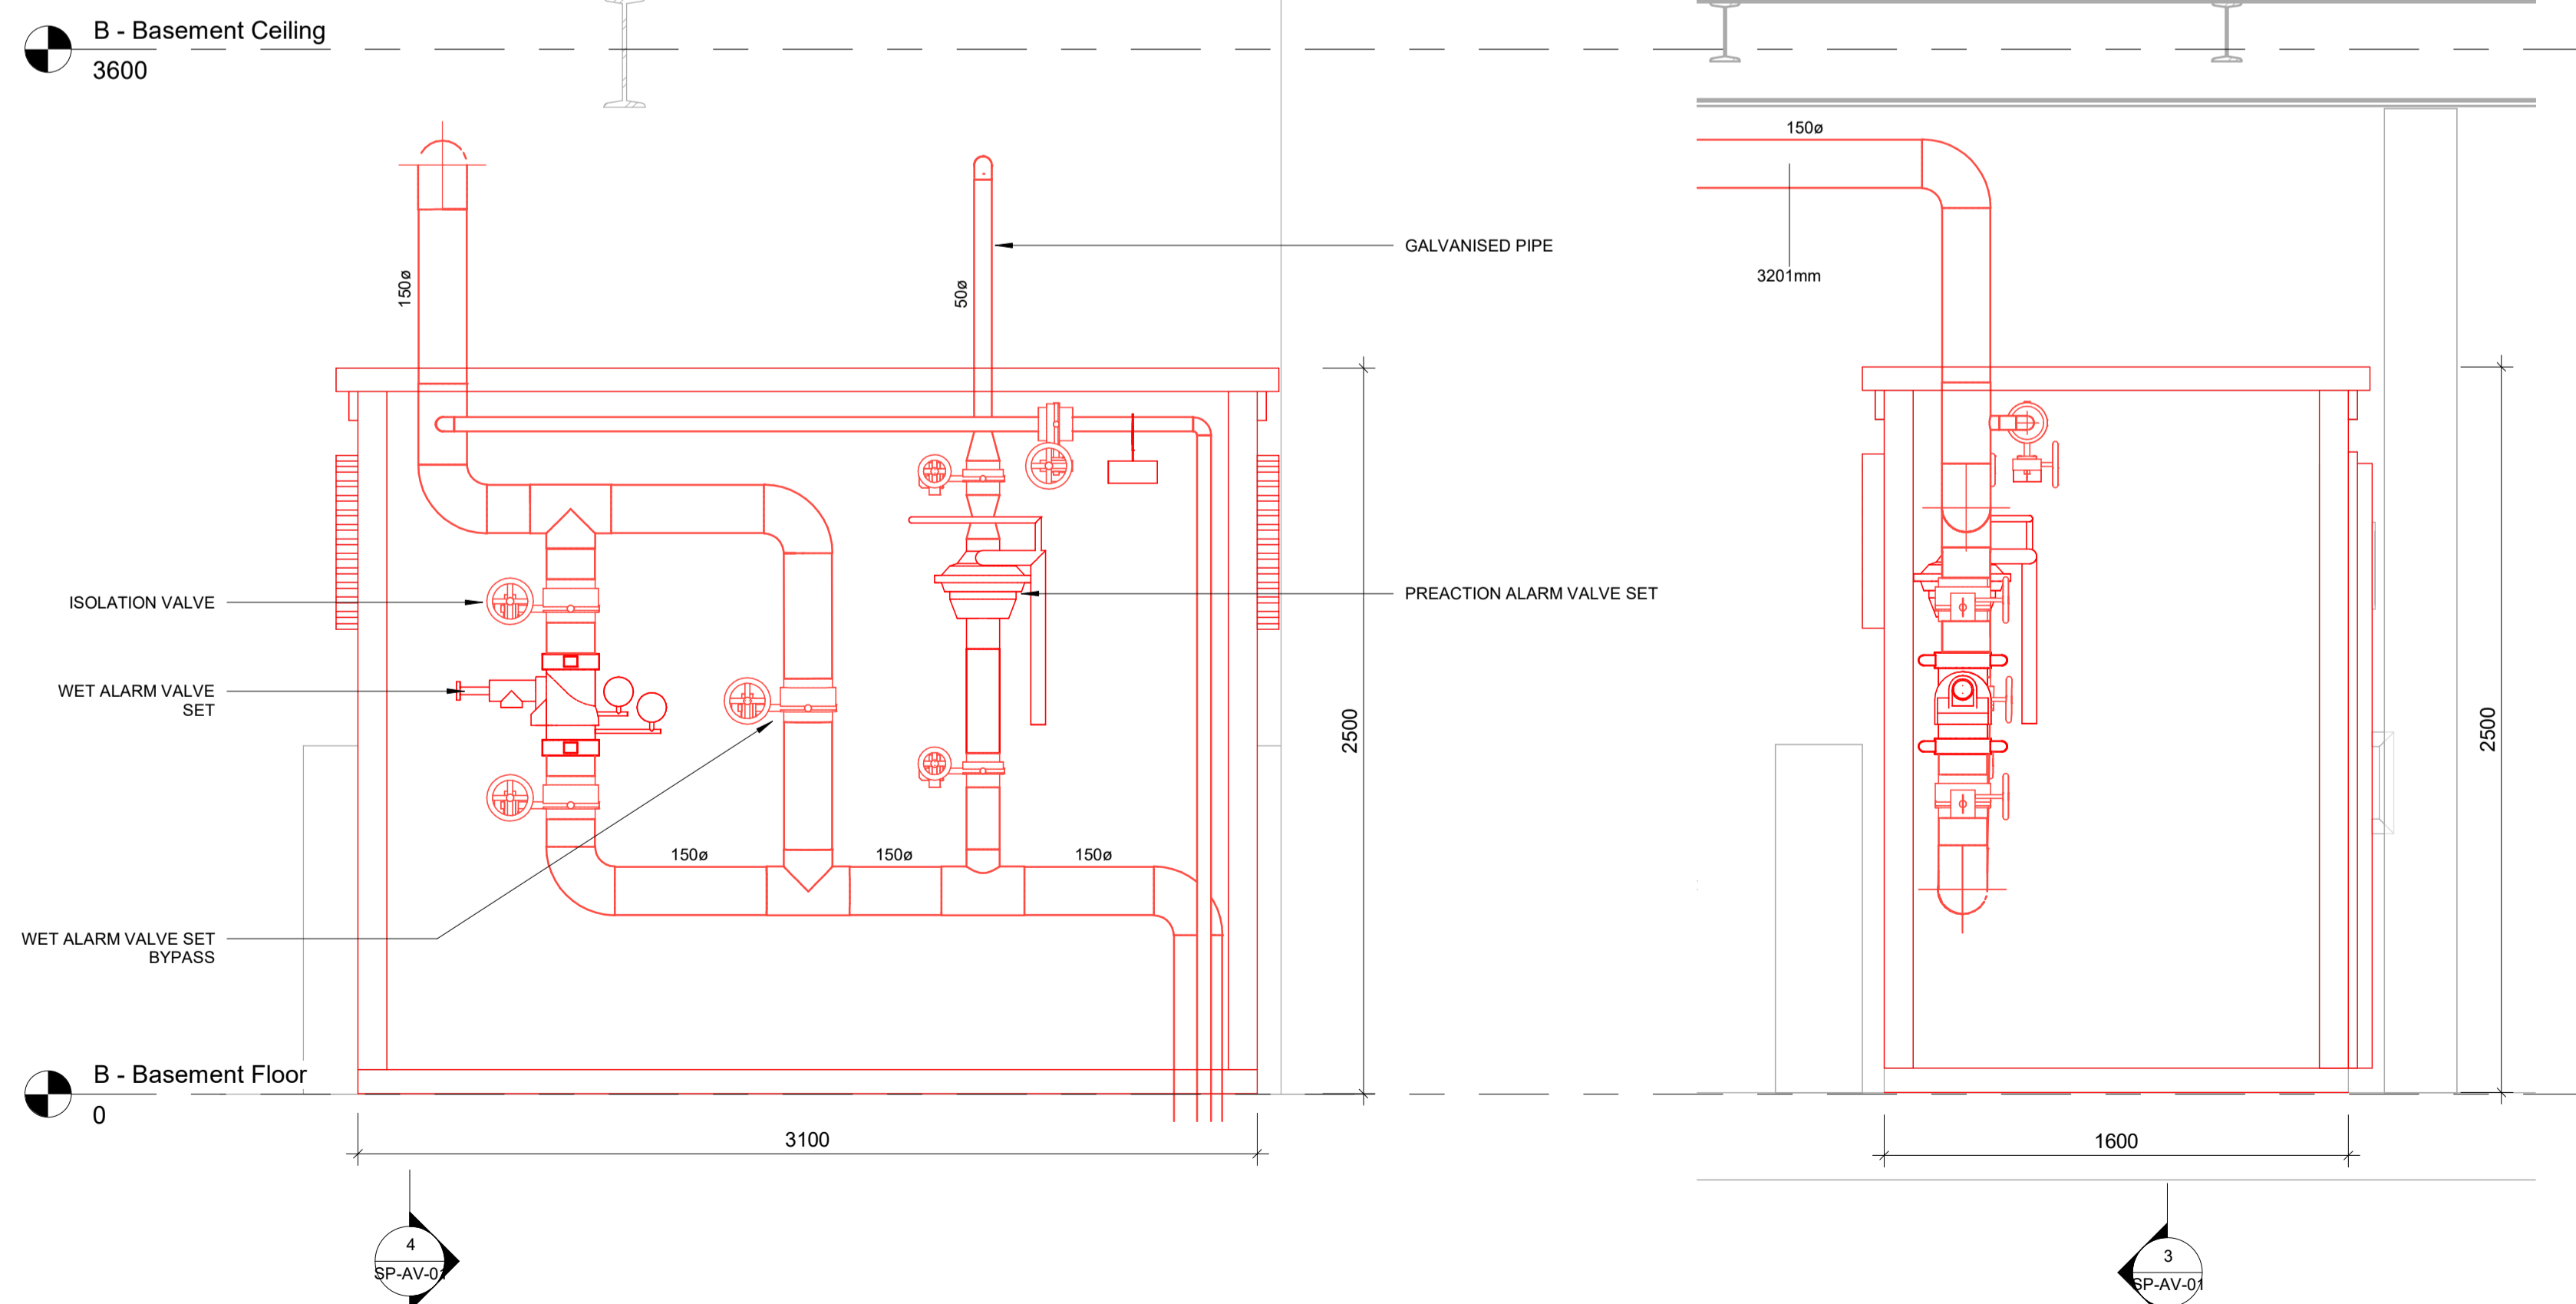

3 Alarm Valve Room Section 1
1:20

4 Alarm Valve Room Section 2
1:20

| Revision | | | | |
|----------|--|--|--|--|
| | | | | |

| Rev | Date | Description | Chk'd | App'd |
|-----|----------|--------------|-------|-------|
| T1 | 09.07.20 | TENDER ISSUE | SD | SD |



Building Services & Fire Engineering Consultants

OSBORN ASSOCIATES

Osborn Associates Ltd
South Barn, Crockham Park,
Crockham Hill, Edenbridge,
Kent, TN8 6SR
England
TEL: +44 (0)1732 860460
www.osbornassociates.co.uk

Project
**UNIVERSITY COLLEGE LONDON
SLADE SCHOOL OF ART
SPRINKLER INSTALLATION**

Drawing
**SERVICE YARD
ALARM VALVE ROOM
ARRANGEMENT**

| | | | |
|------------|--------------|--------------------|---|
| Scale @ A1 | As indicated | CAD Ref. File Path | C:\OSB\Files\Osborn\1955-1959\1955 UCL Slade School of Art Drawings |
| Drawn | HS | Chk'd/App'd | SD/SD |
| Job No. | 1955 | Dwg No. | SP-AV-01 |
| Date | JULY.20 | Rev | T1 |