



**1 Riser Internal Basement & Ground Plan**  
1 : 50

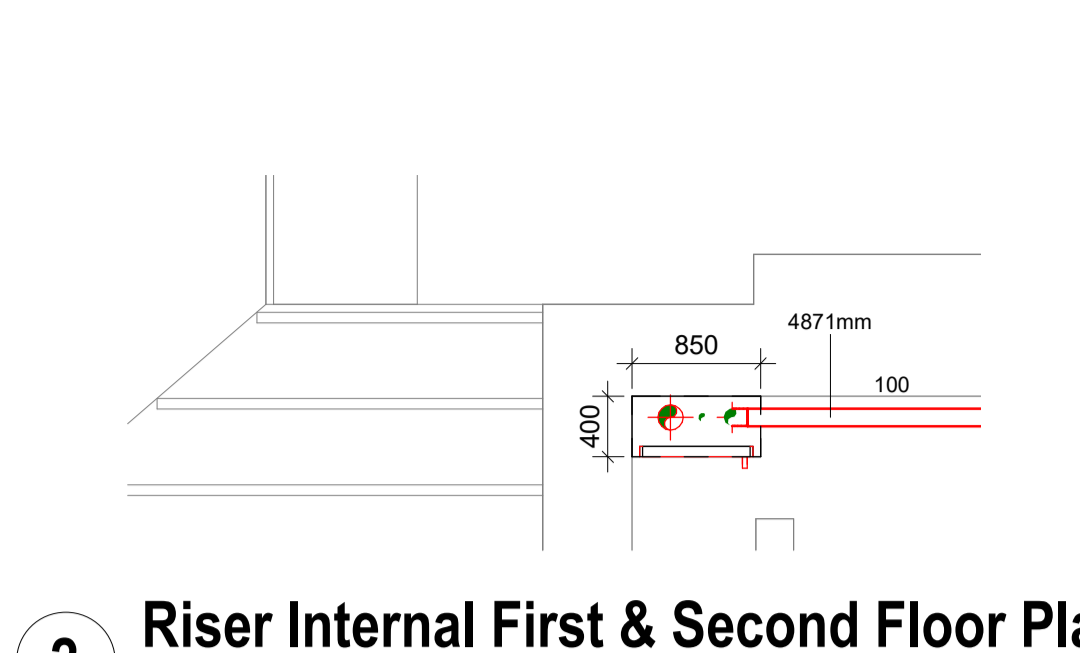


**2 Riser Internal First & Second Floor Plan**  
1 : 50

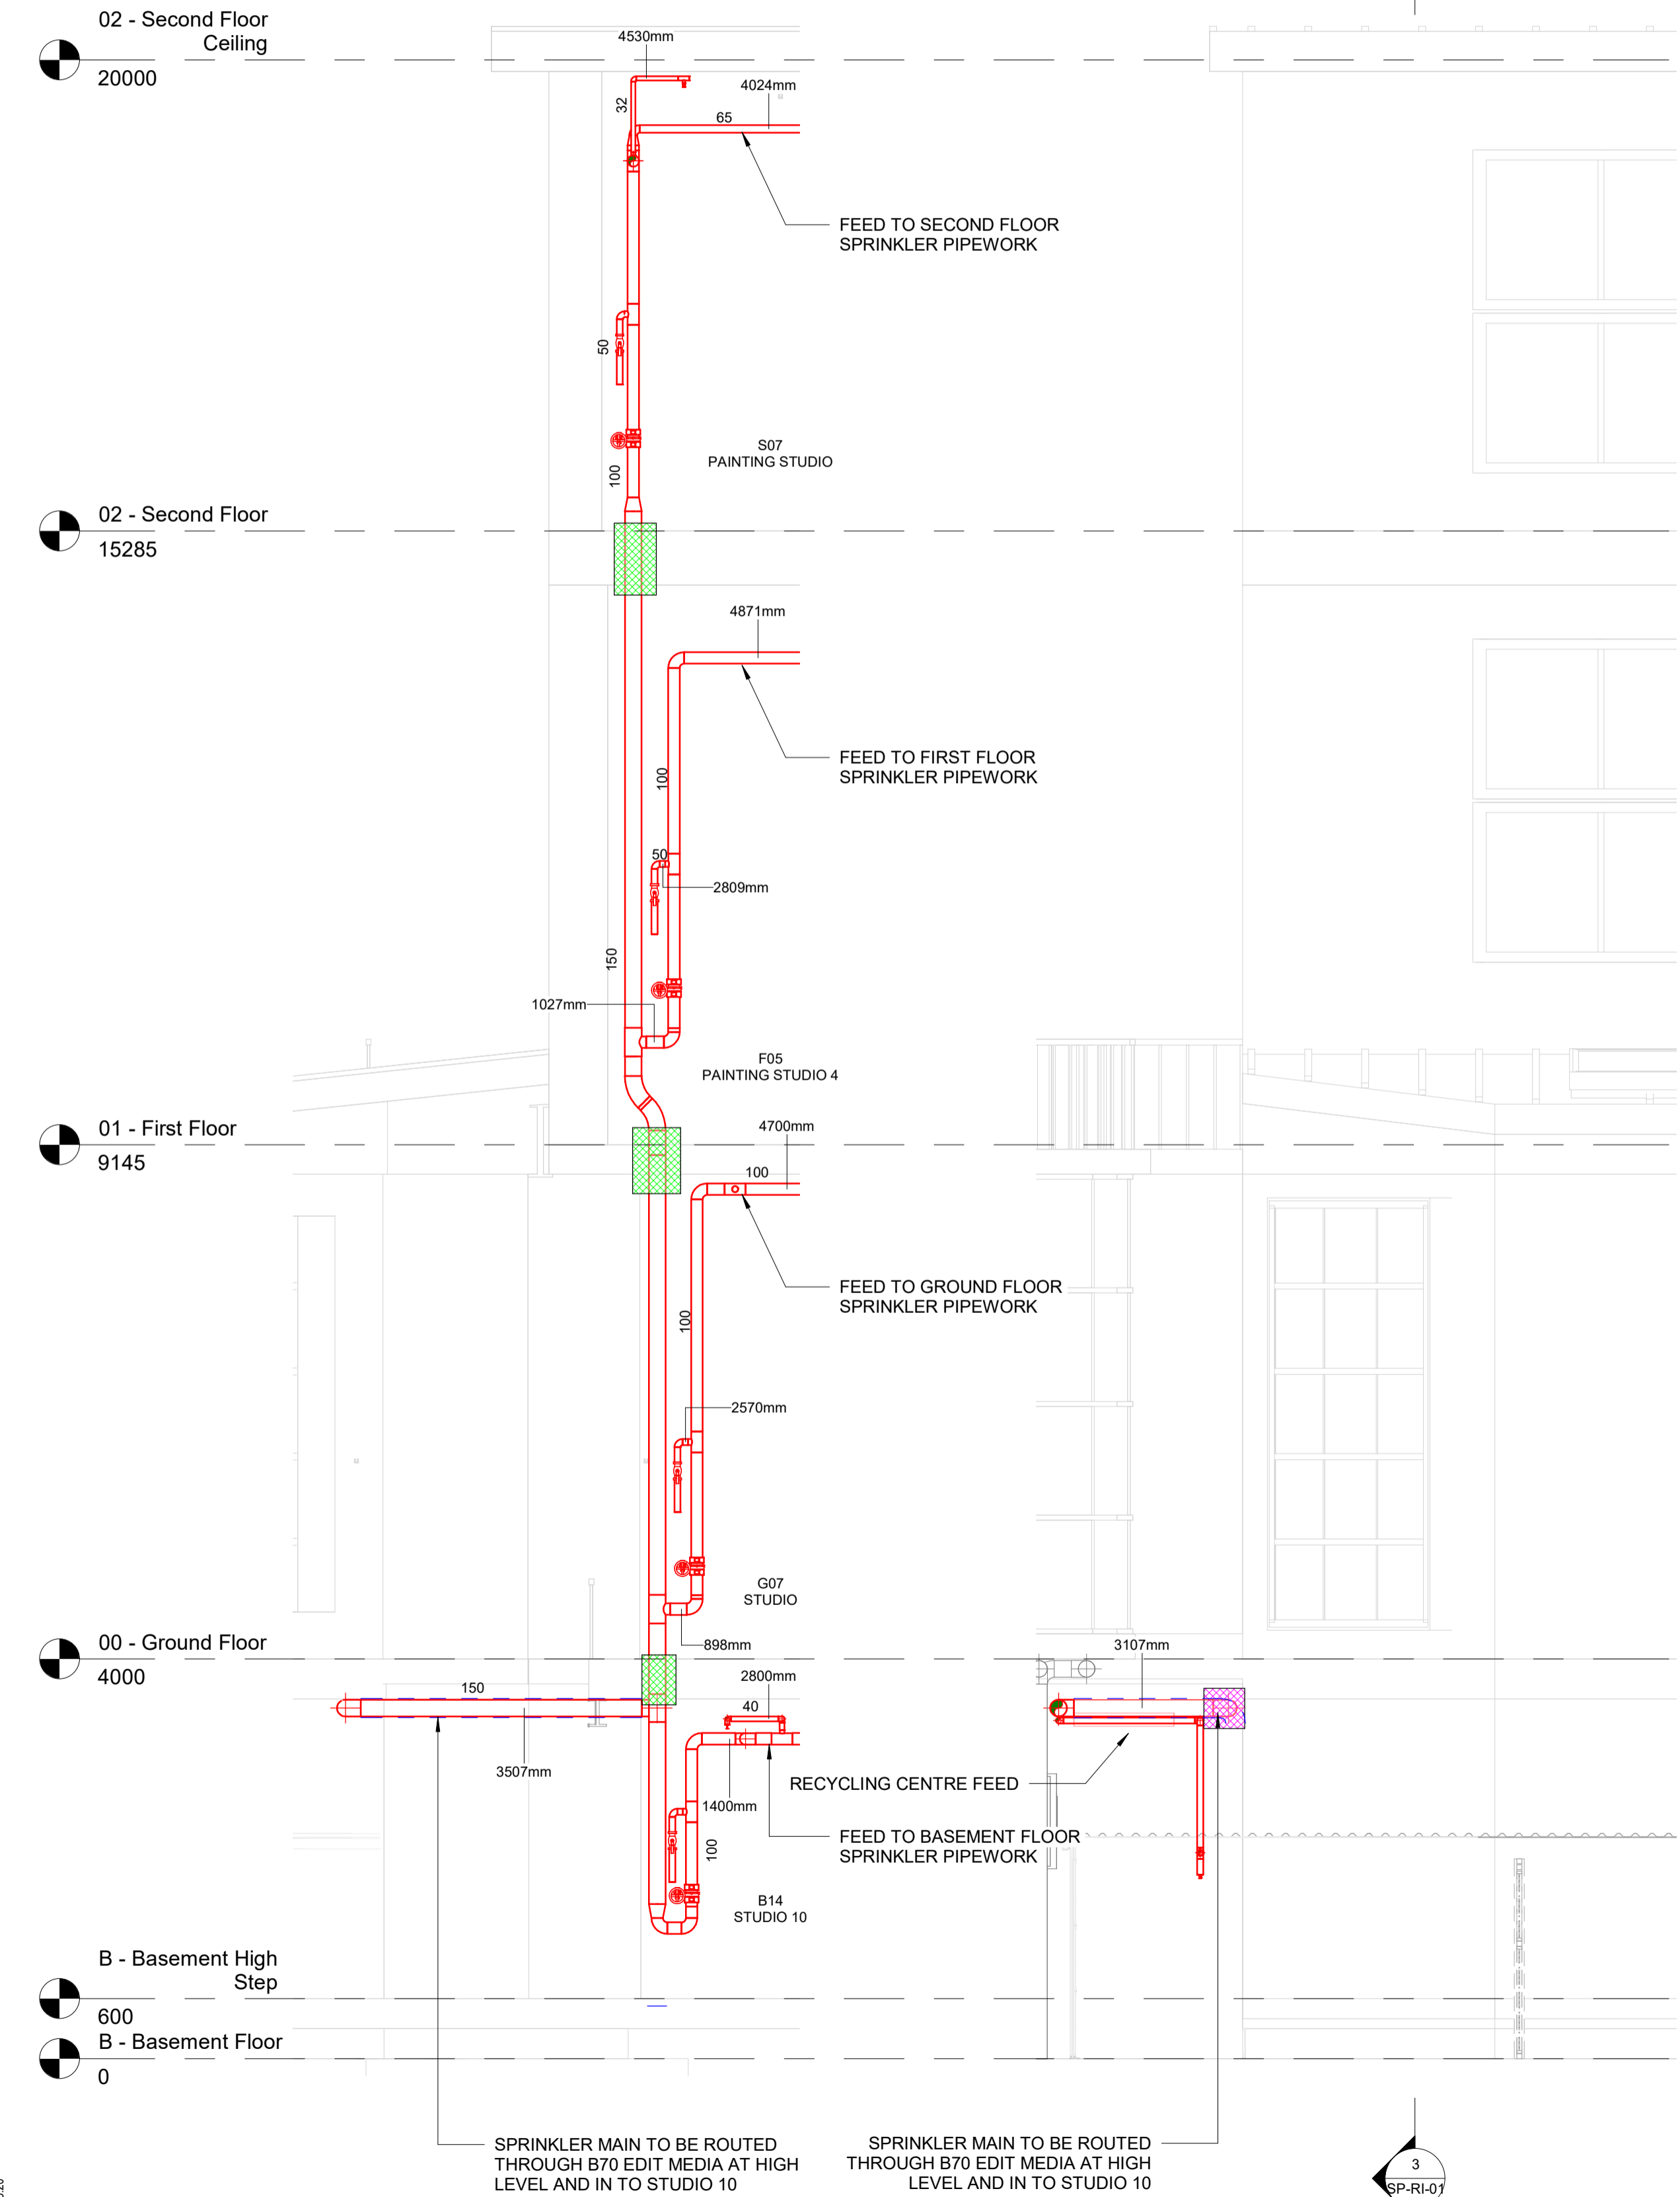


**3 Riser Pipework Internal Section 1**  
1 : 50


**4 Riser Pipework Internal Section 2**  
1 : 50

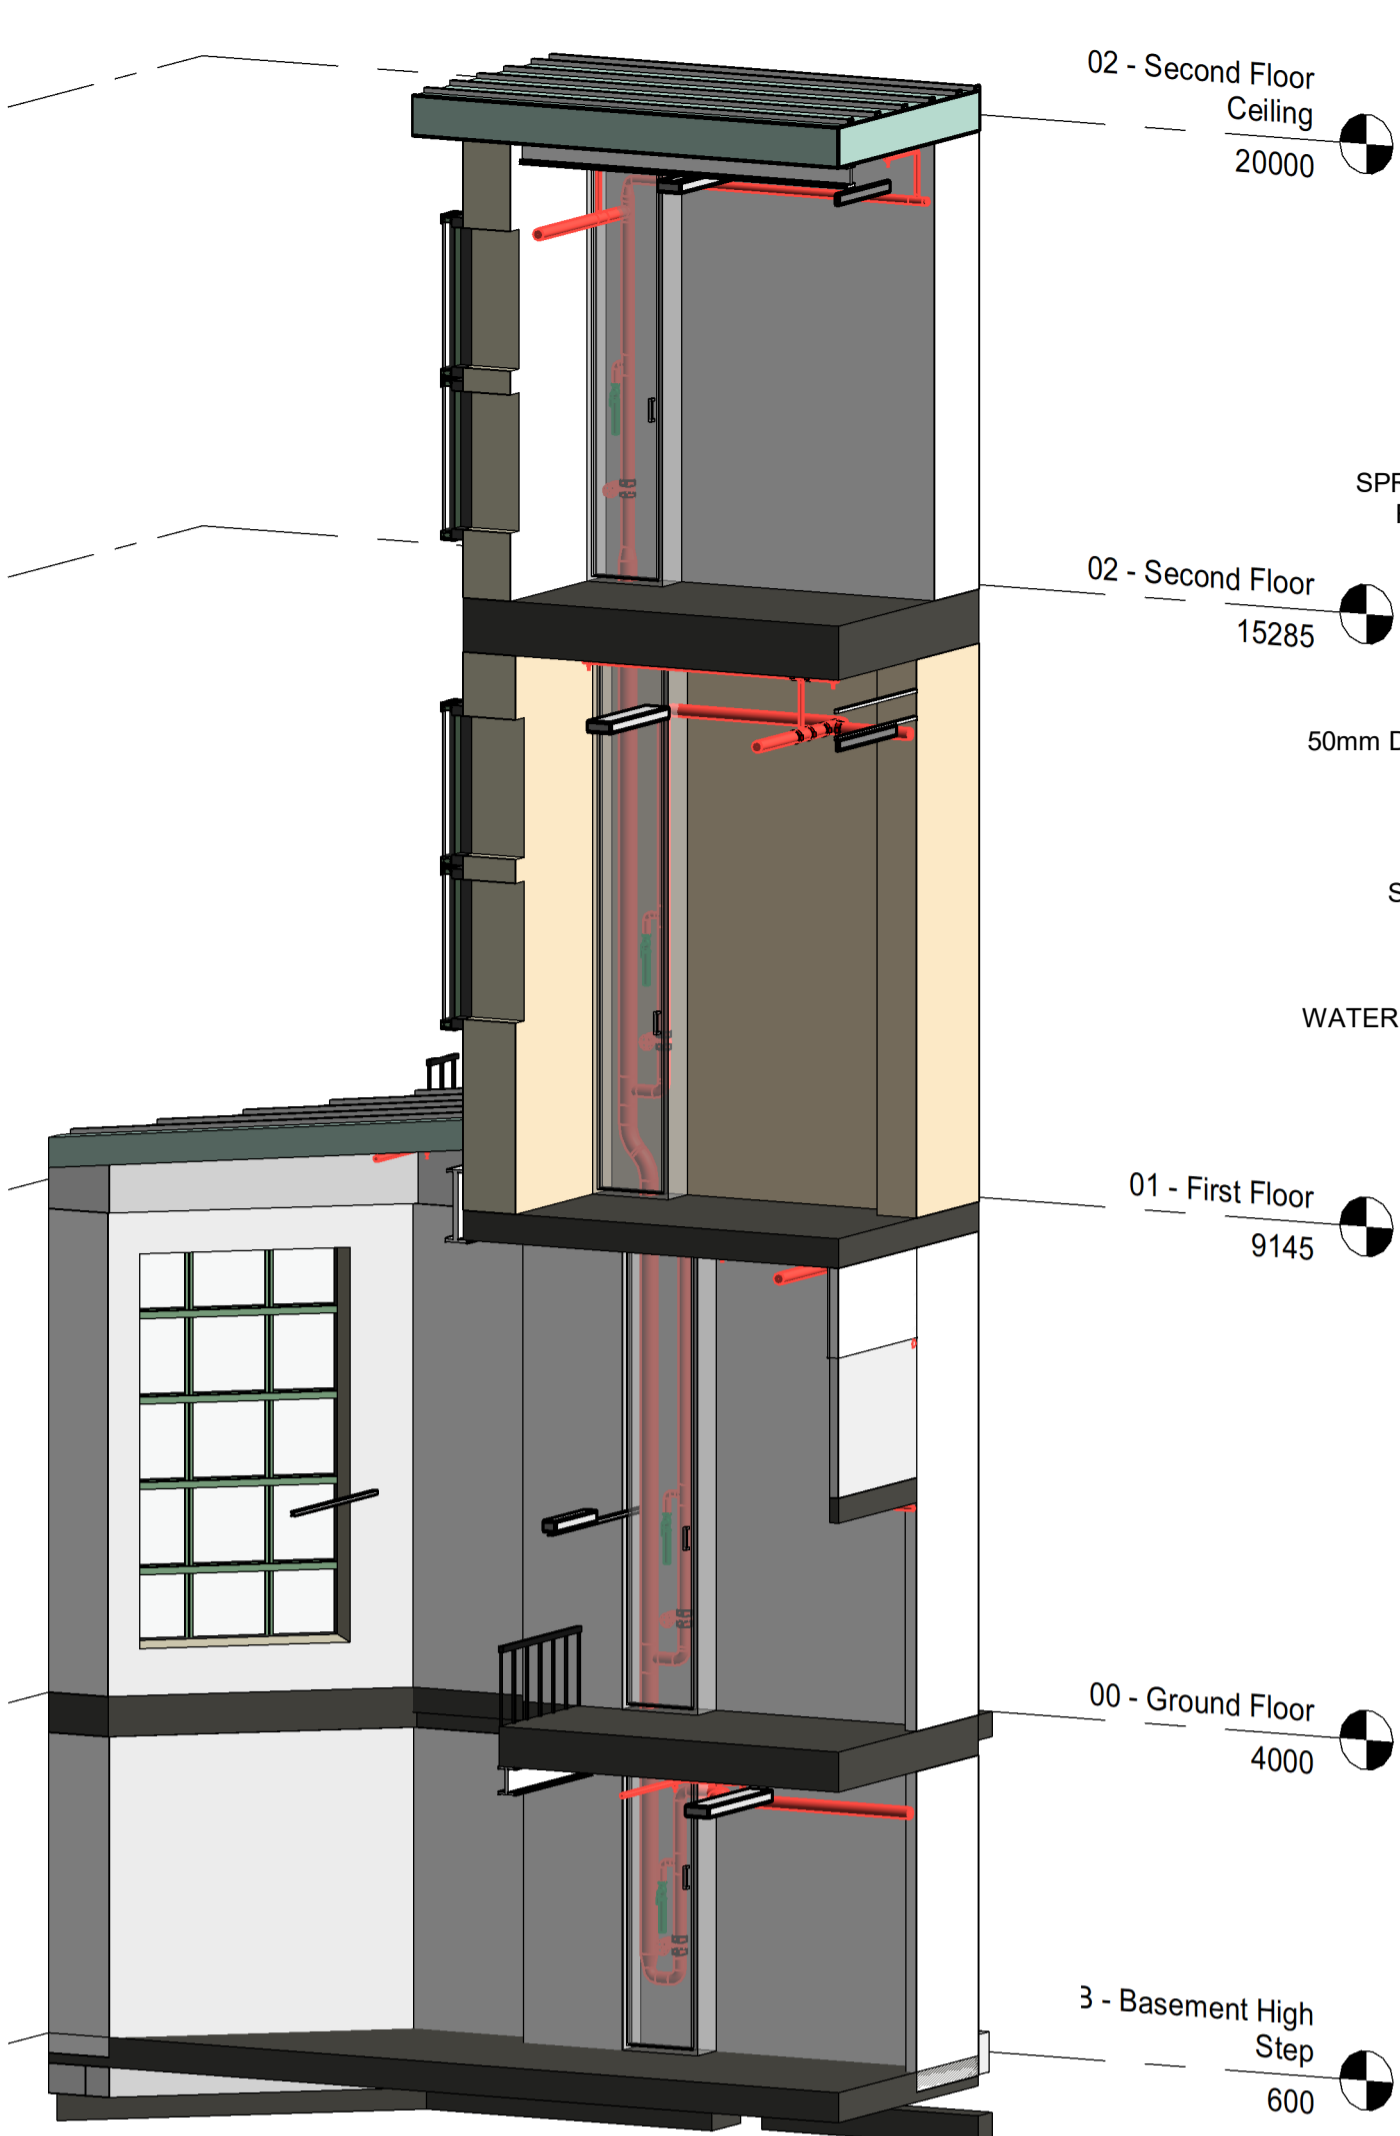


**5 Riser Internal 3D**

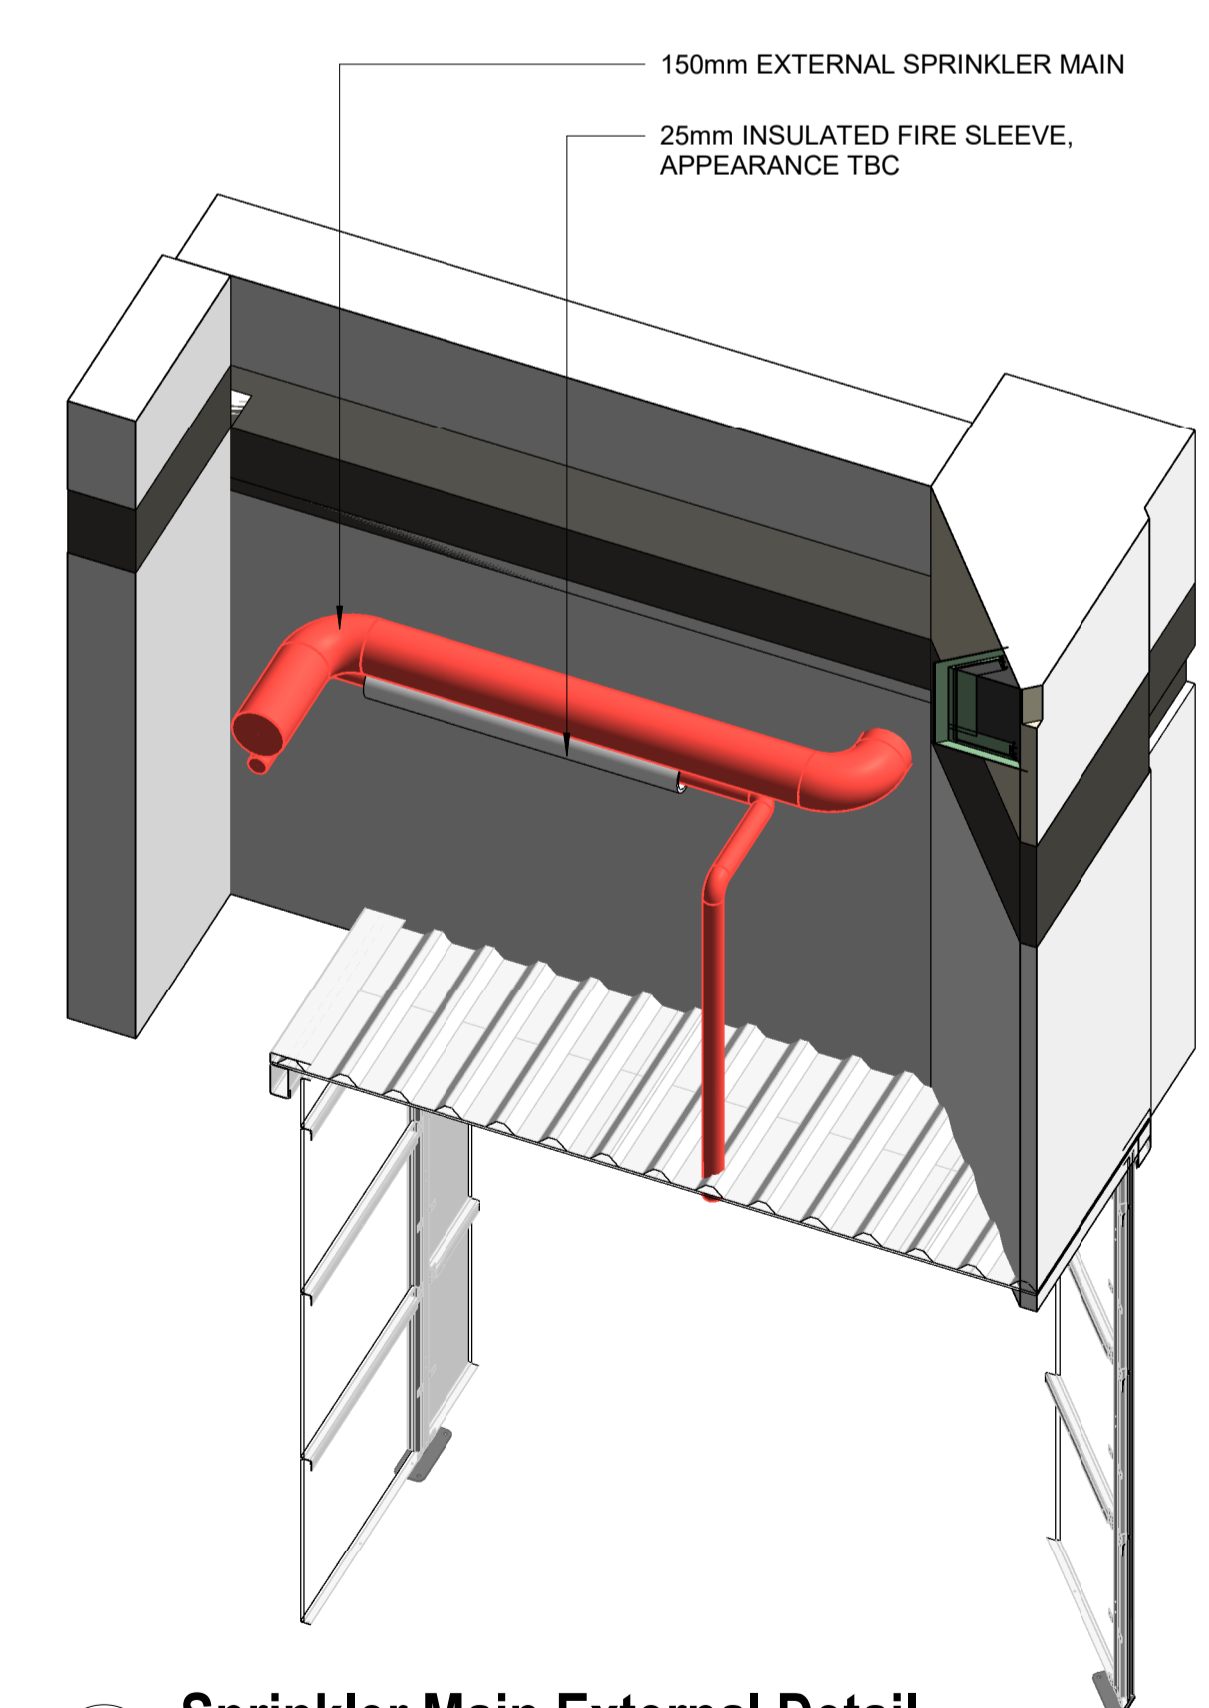

**6 Sprinkler Main External Detail**

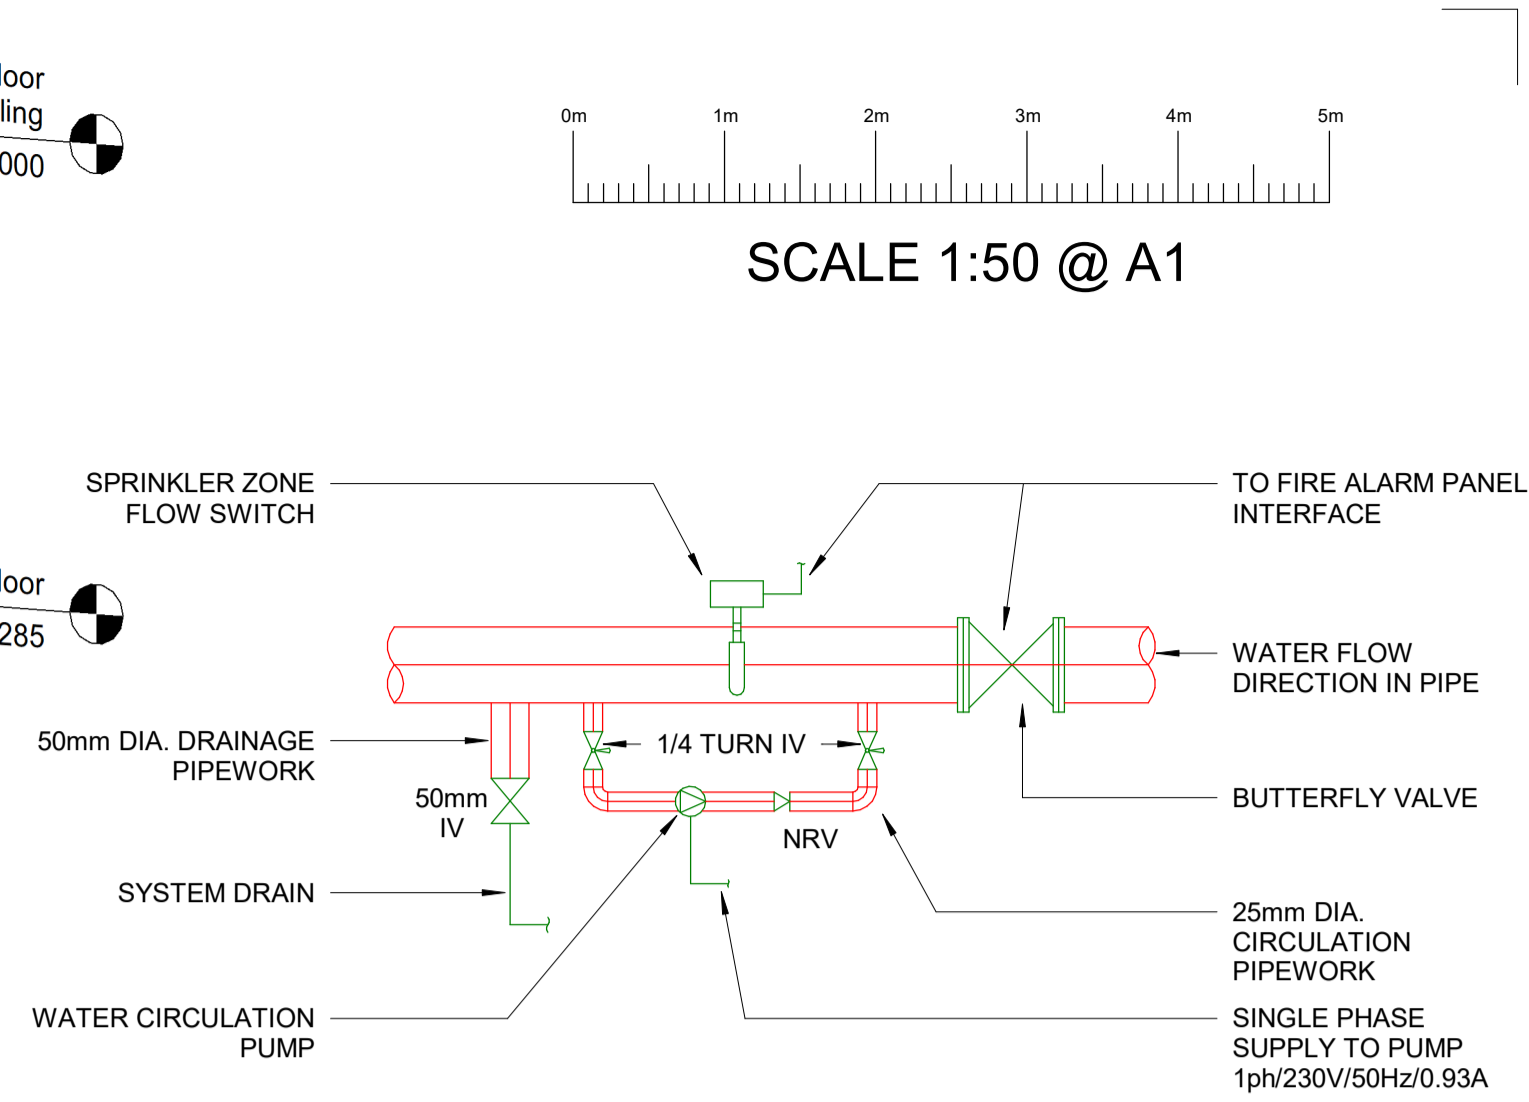

**8 12 - Zone Control Arrangement Detail**  
1 : 10

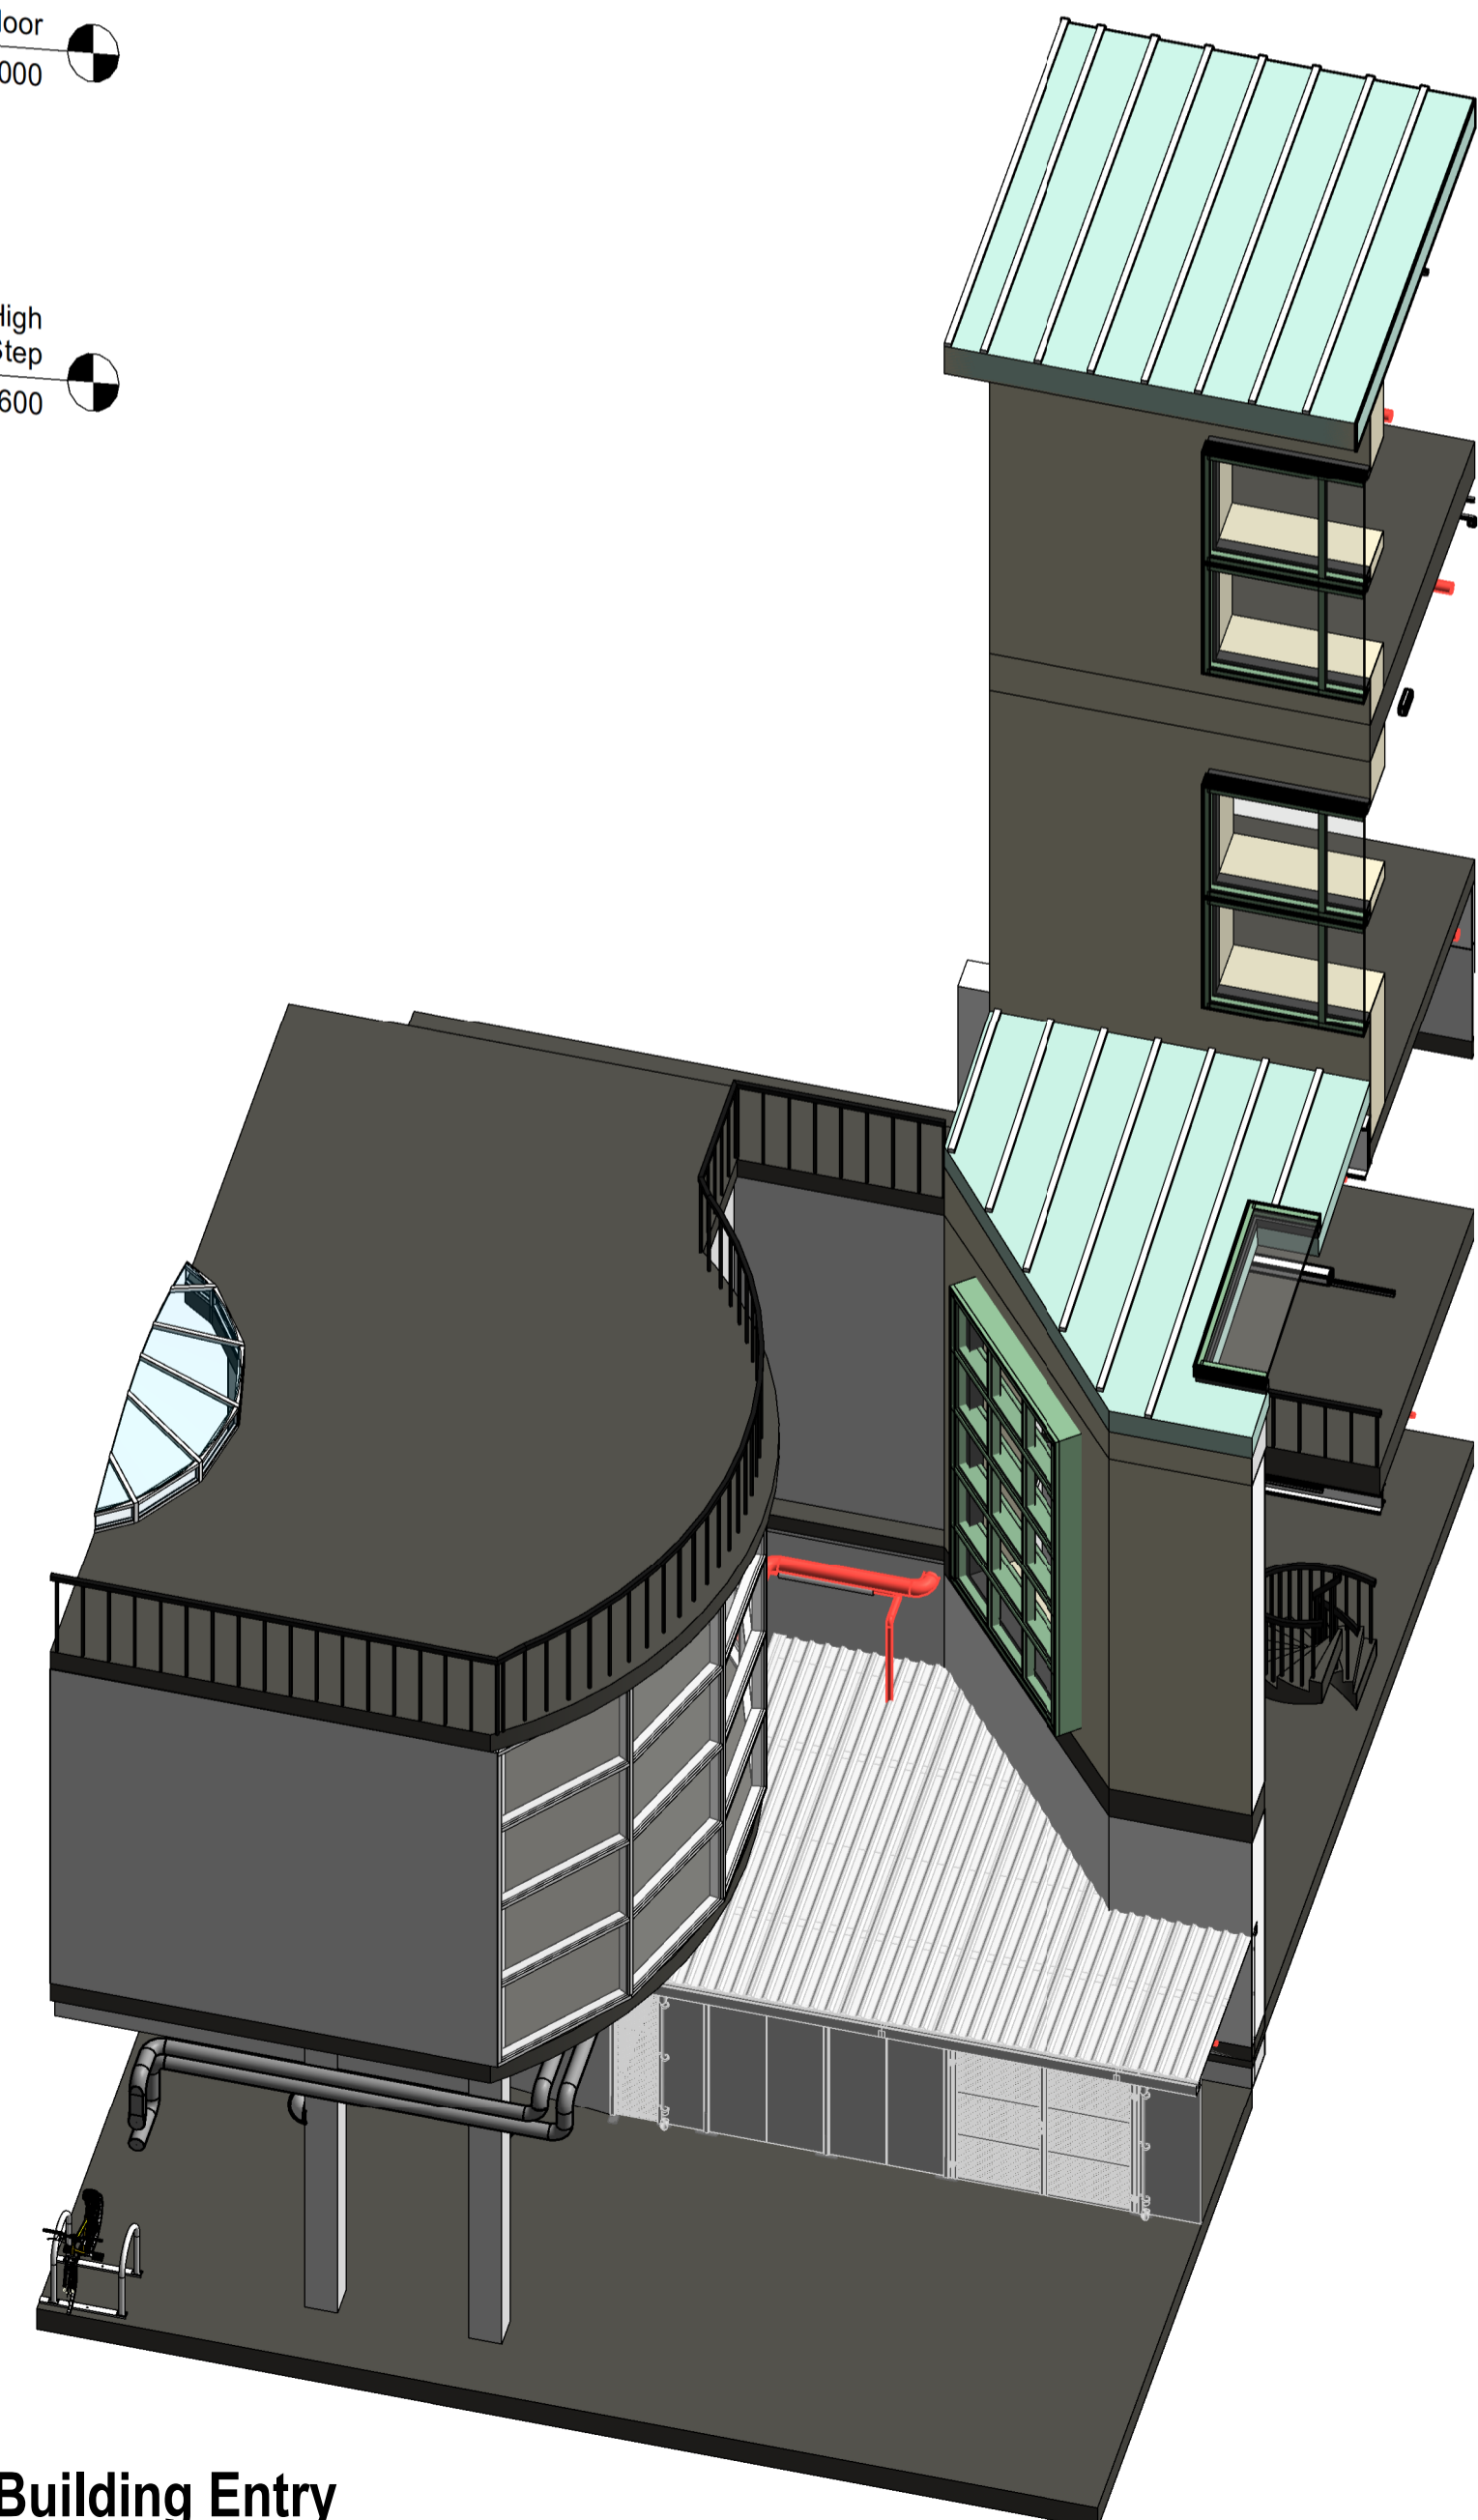

**7 Riser Internal Building Entry**

**NOTES**

- THIS IS A PRE APPLICATION INFORMED DRAWING AND SHALL NOT BE USED FOR CONSTRUCTION OR INSTALLATION PURPOSES.
- DO NOT SCALE OFF THIS DRAWING.
- ALL DIMENSIONS TO BE VERIFIED ON SITE BEFORE COMPLETING SHOP DRAWINGS AND SETTING OUT WORK.
- THIS DRAWING SHALL BE READ IN CONJUNCTION WITH THE TECHNICAL SPECIFICATION AND ASSOCIATED EQUIPMENT SCHEDULES.

**LEGEND:**

- PROPOSED SPRINKLER WORKS
- PIPEWORK INSULATION EXTENTS
- WALL PIPE PENETRATION AREAS
- SLAB/FLOOR PIPE FROM FLOOR BELOW PENETRATION AREAS

Revision				
Rev	Date	Description	Chk'd	App'd
T1	09.07.20	TENDER ISSUE	SD	SD

Client



**Building Services & Fire Engineering Consultants**

Osborn Associates Ltd  
South Barn, Crockham Park,  
Crockham Hill, Edenbridge,  
Kent, TN8 6SR  
England

TEL: +44 (0)1732 860460  
www.osbornassociates.co.uk

Project  
**UNIVERSITY COLLEGE LONDON  
SLADE SCHOOL OF ART  
SPRINKLER INSTALLATION**

Drawing  
**SPRINKLER RISING MAIN  
TO SLADE BUILDING  
INTERNAL**

Scale @ A1	As indicated	CAD Ref. File Path	C:\OS\p\Files\Osborn\1955-1959\1955 UCL Slade School of Art Drawings
Drawn	HS	Chk'd/App'd	SD/SD
Date	JULY.20	Job No.	1955
Drg No.	SP-RI-01	Rev	T1