



UK-LON-KGX1
The Delivery Room
2nd Floor
2 Pancras Square
London, N1C 4AG


Building Design Partnership shall have no responsibility for any use made of this document other than for that which it was prepared and issued.
All dimensions should be checked on site.
Do not scale from this drawing.
Any drawing errors or divergences should be brought to the attention of Building Design Partnership at the address shown below.
Drawings shall be read in conjunction with the following before work commences:
• The CDM design issues register
• The BDP risk series of drawings
• The project CDM risk register

Mansafe Cable


T04	Updated as indicated - CRF928	WT	AE	11.10.19
T03	Tender Issue CRFs no 137.190	WT	WT	03.08.18
T02	Stage 4 Update Tender Issue	WT	JC	15.12.17
T01	Stage 4 issue	WT	JC	29.09.17

BDP.


16 Brewhouse Yard
Clerkenwell
London
EC1V 4LJ
United Kingdom
T +44 [0]20 7812 8000
www.bdp.com

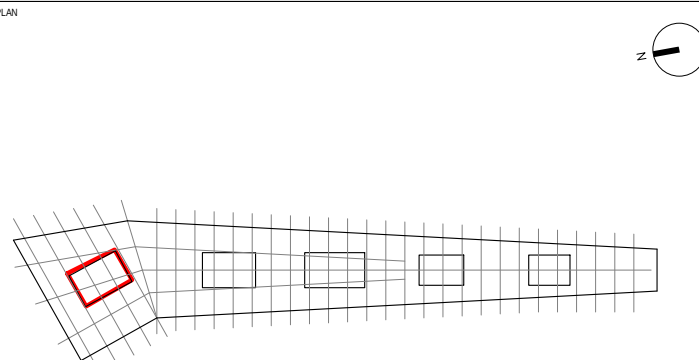

Status		FOR TENDER	
Title		Date: 02/06/17	
Detailed Floor Plan - Level 12 North Shed		Project No: P2007133	
Scale: 1 : 100		Size: A1	
Drawn: AKO		Checked: JC	
Drawing No: KXC-A-001-A-BDP-00-11203		Rev: T04	

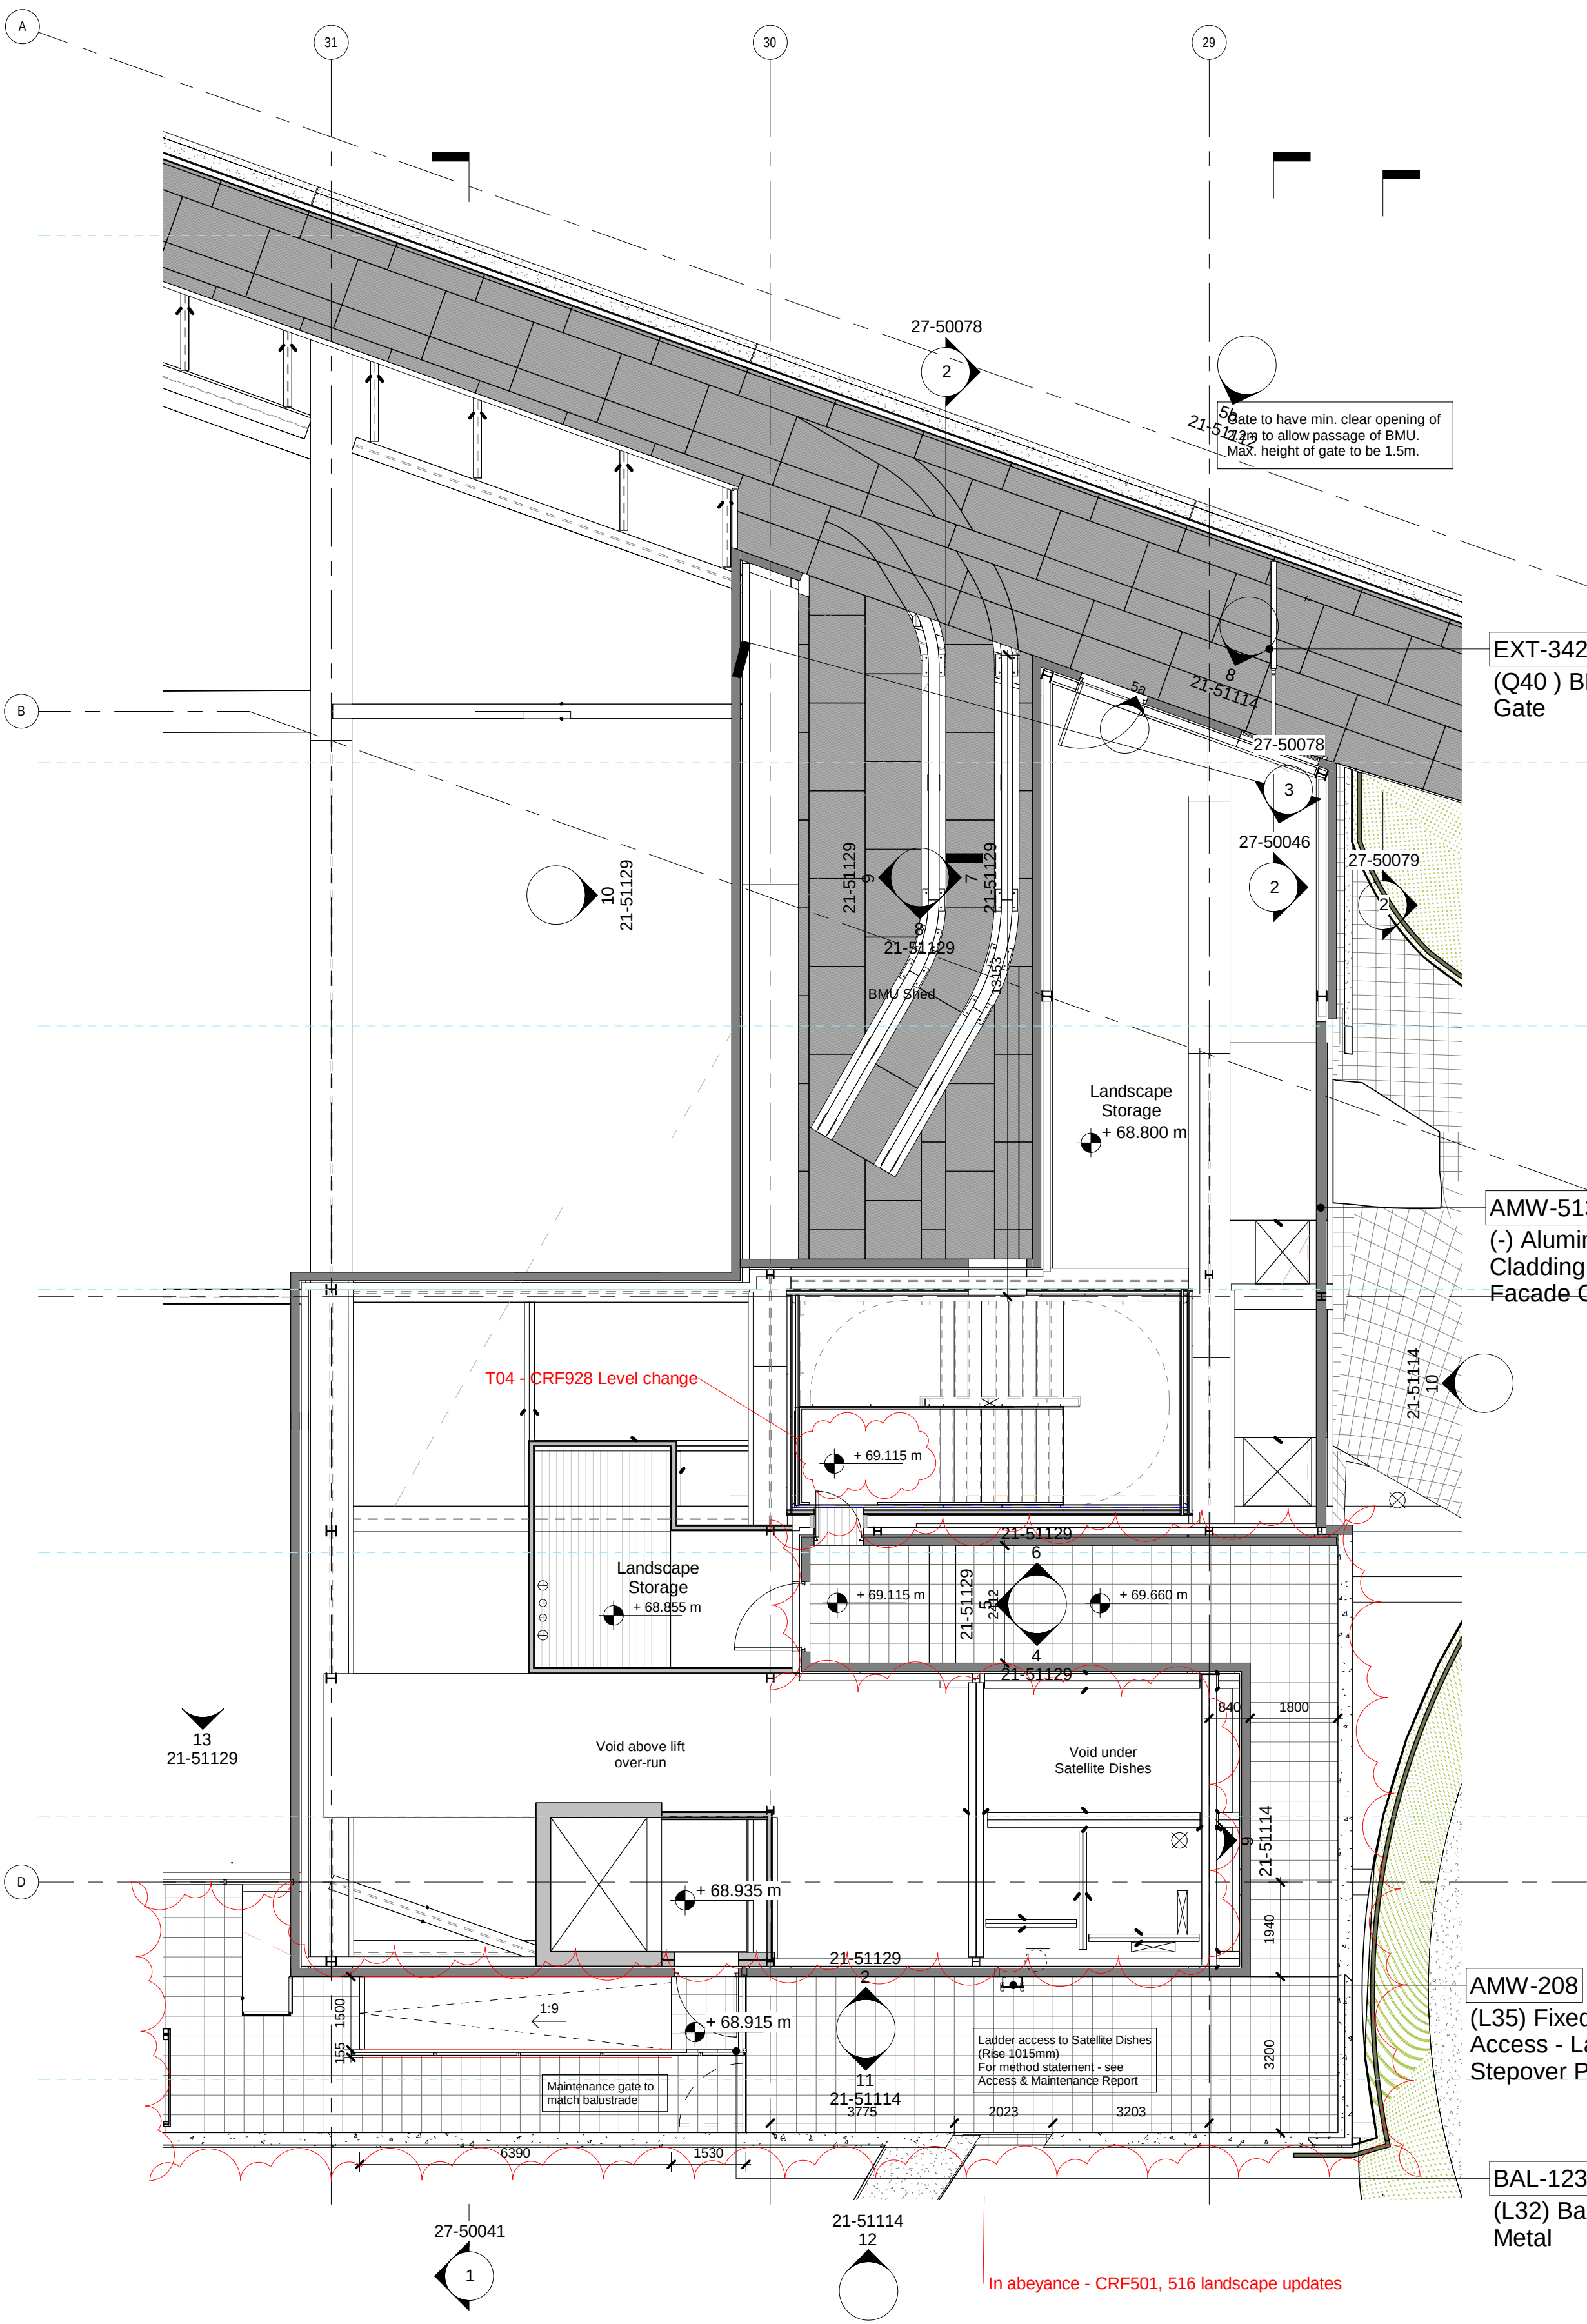

1 North Shed
1:100

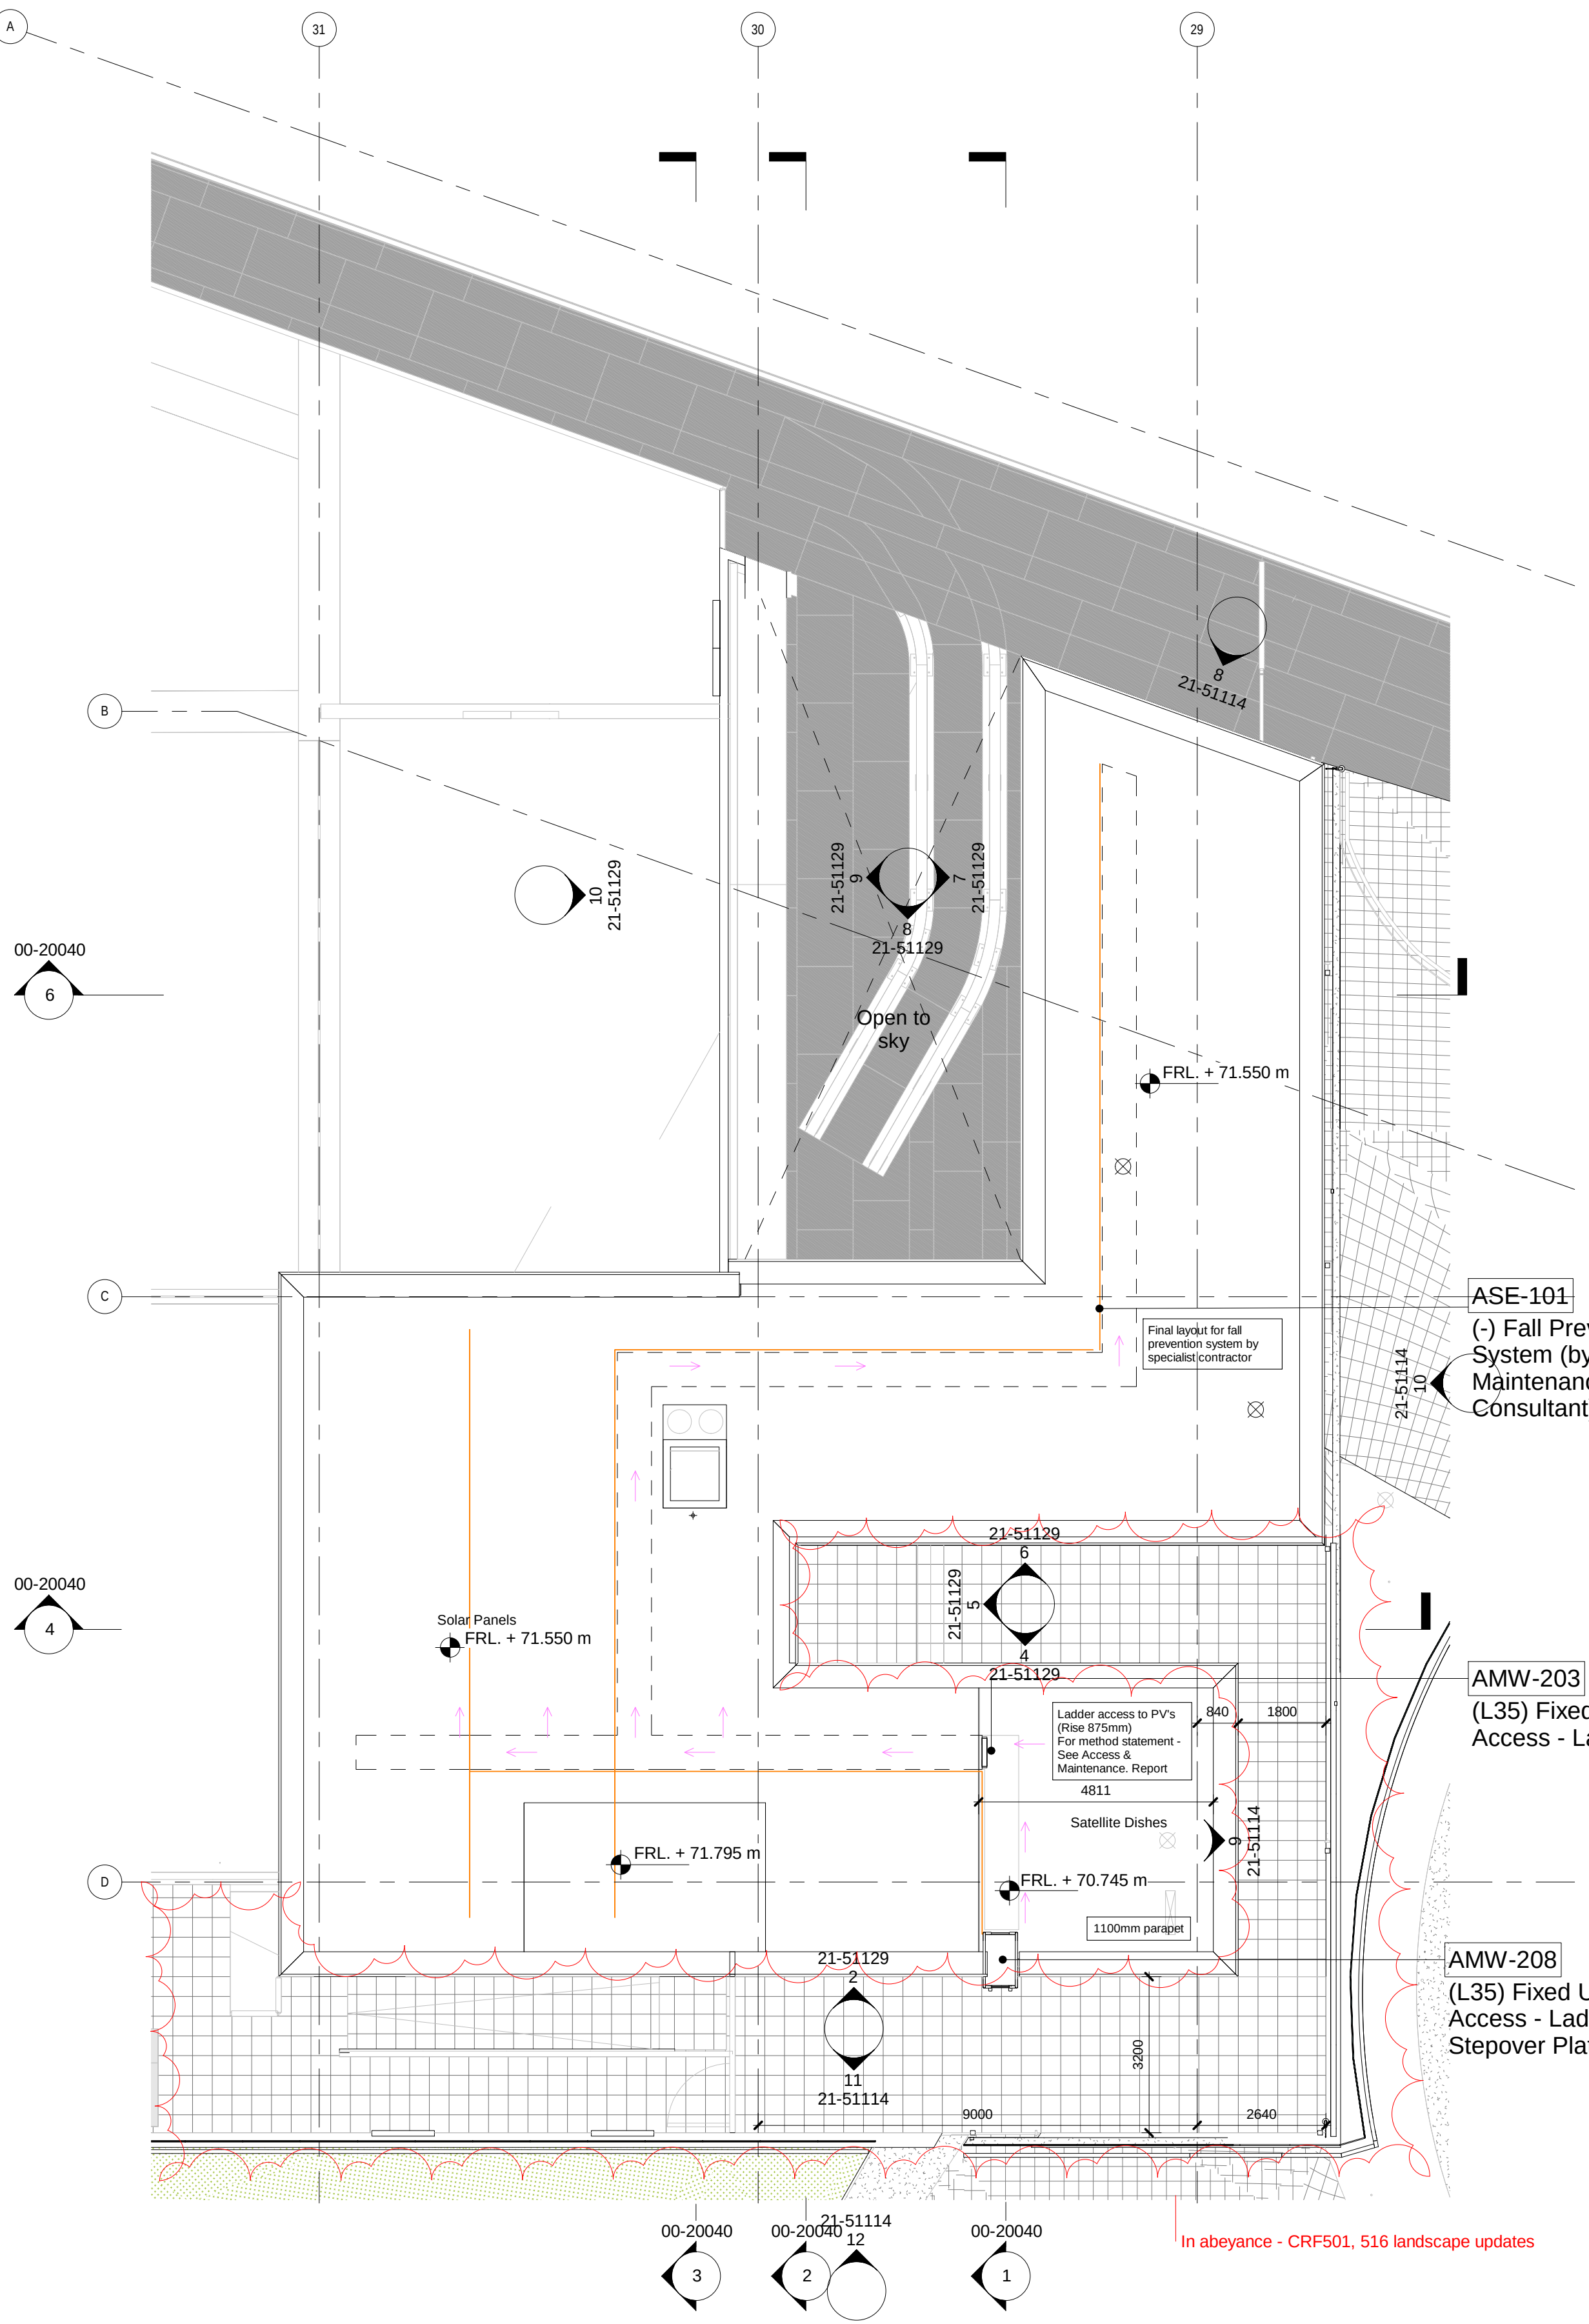

2 North Shed Roof
1:100