


LG FLOOR LIGHTING PLAN

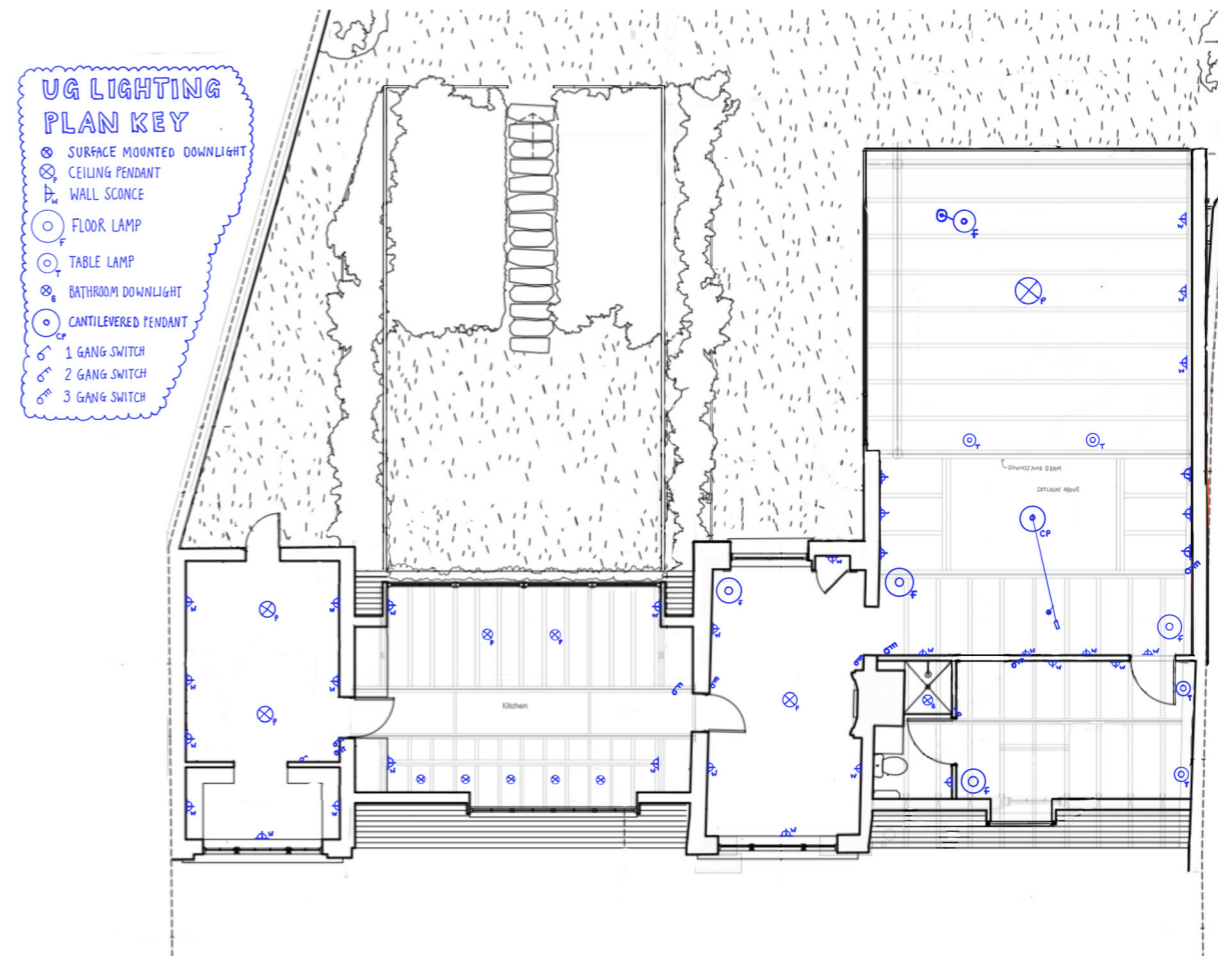

UG FLOOR LIGHTING PLAN

CHAN + EAYRS 111 Frognal, Hampstead NW3 6XR		2	
Zoe Chan Eayrs and Merlin Eayrs			
Project : 111 Frognal			
TITLE : LG LIGHTING PLAN : UG LIGHTING PLAN			
Date 21/01/21	Scale 1:50 @A0	Drawing No. LP	Rev.01