



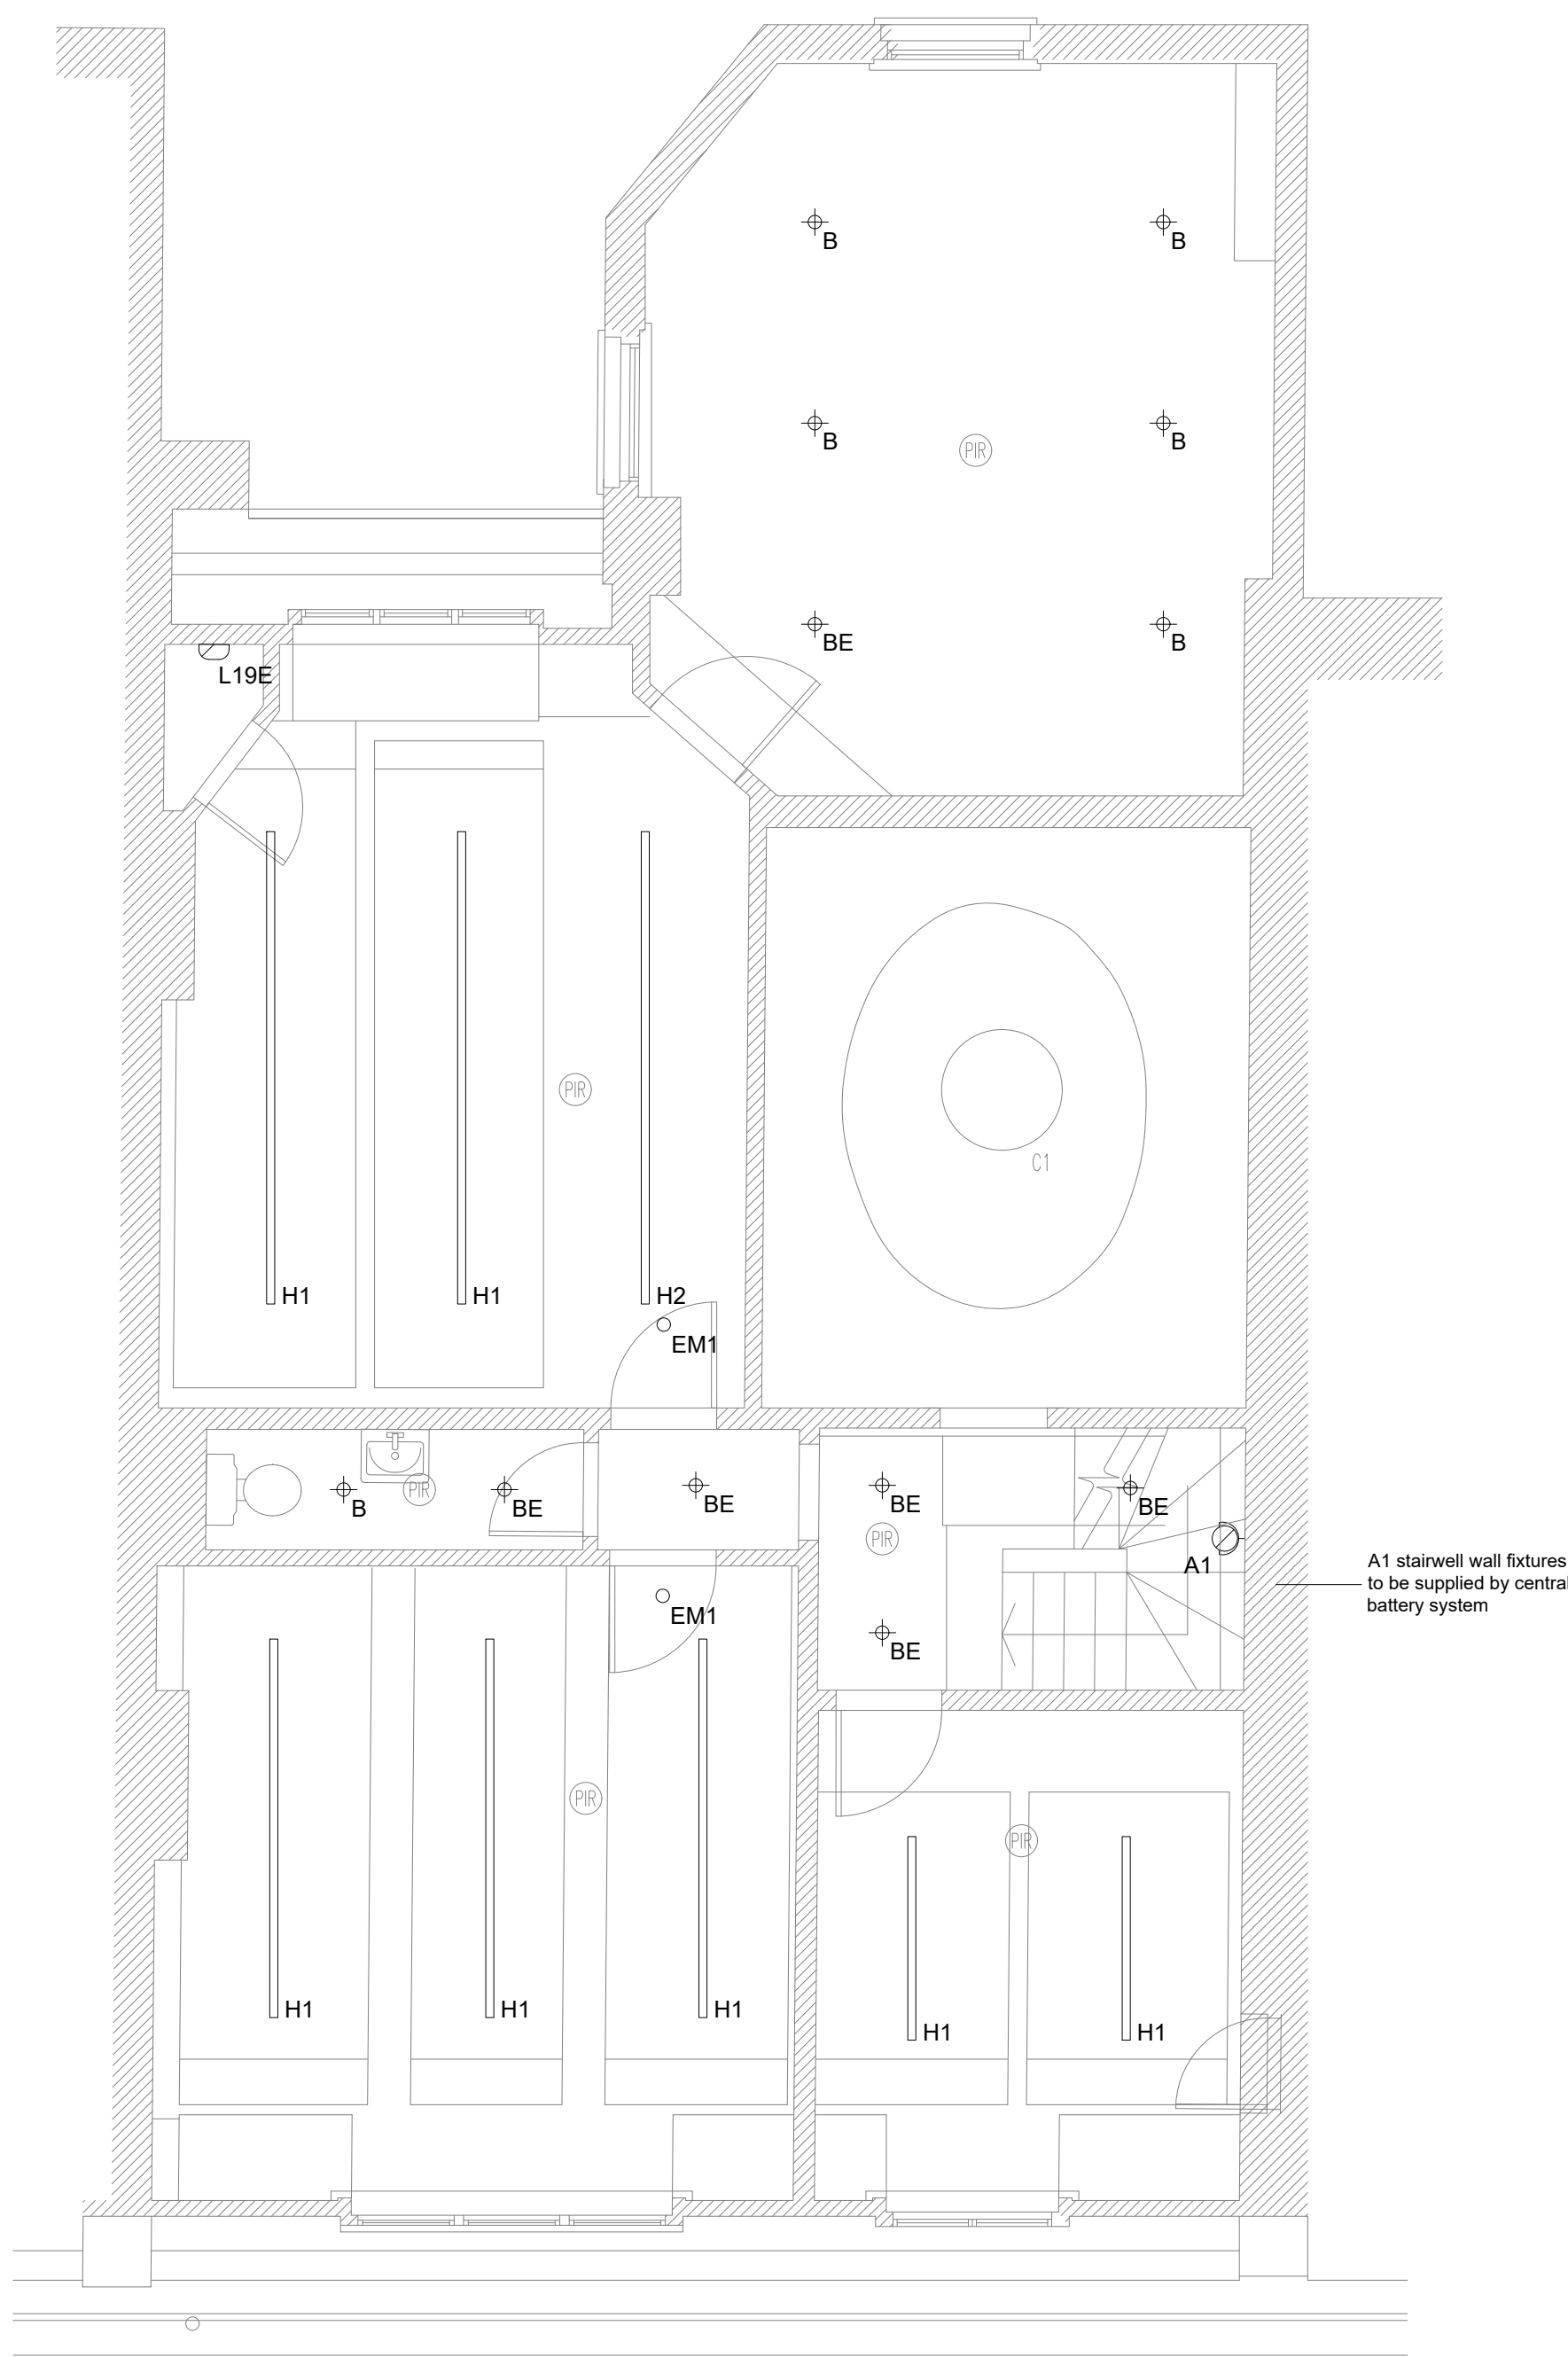

third

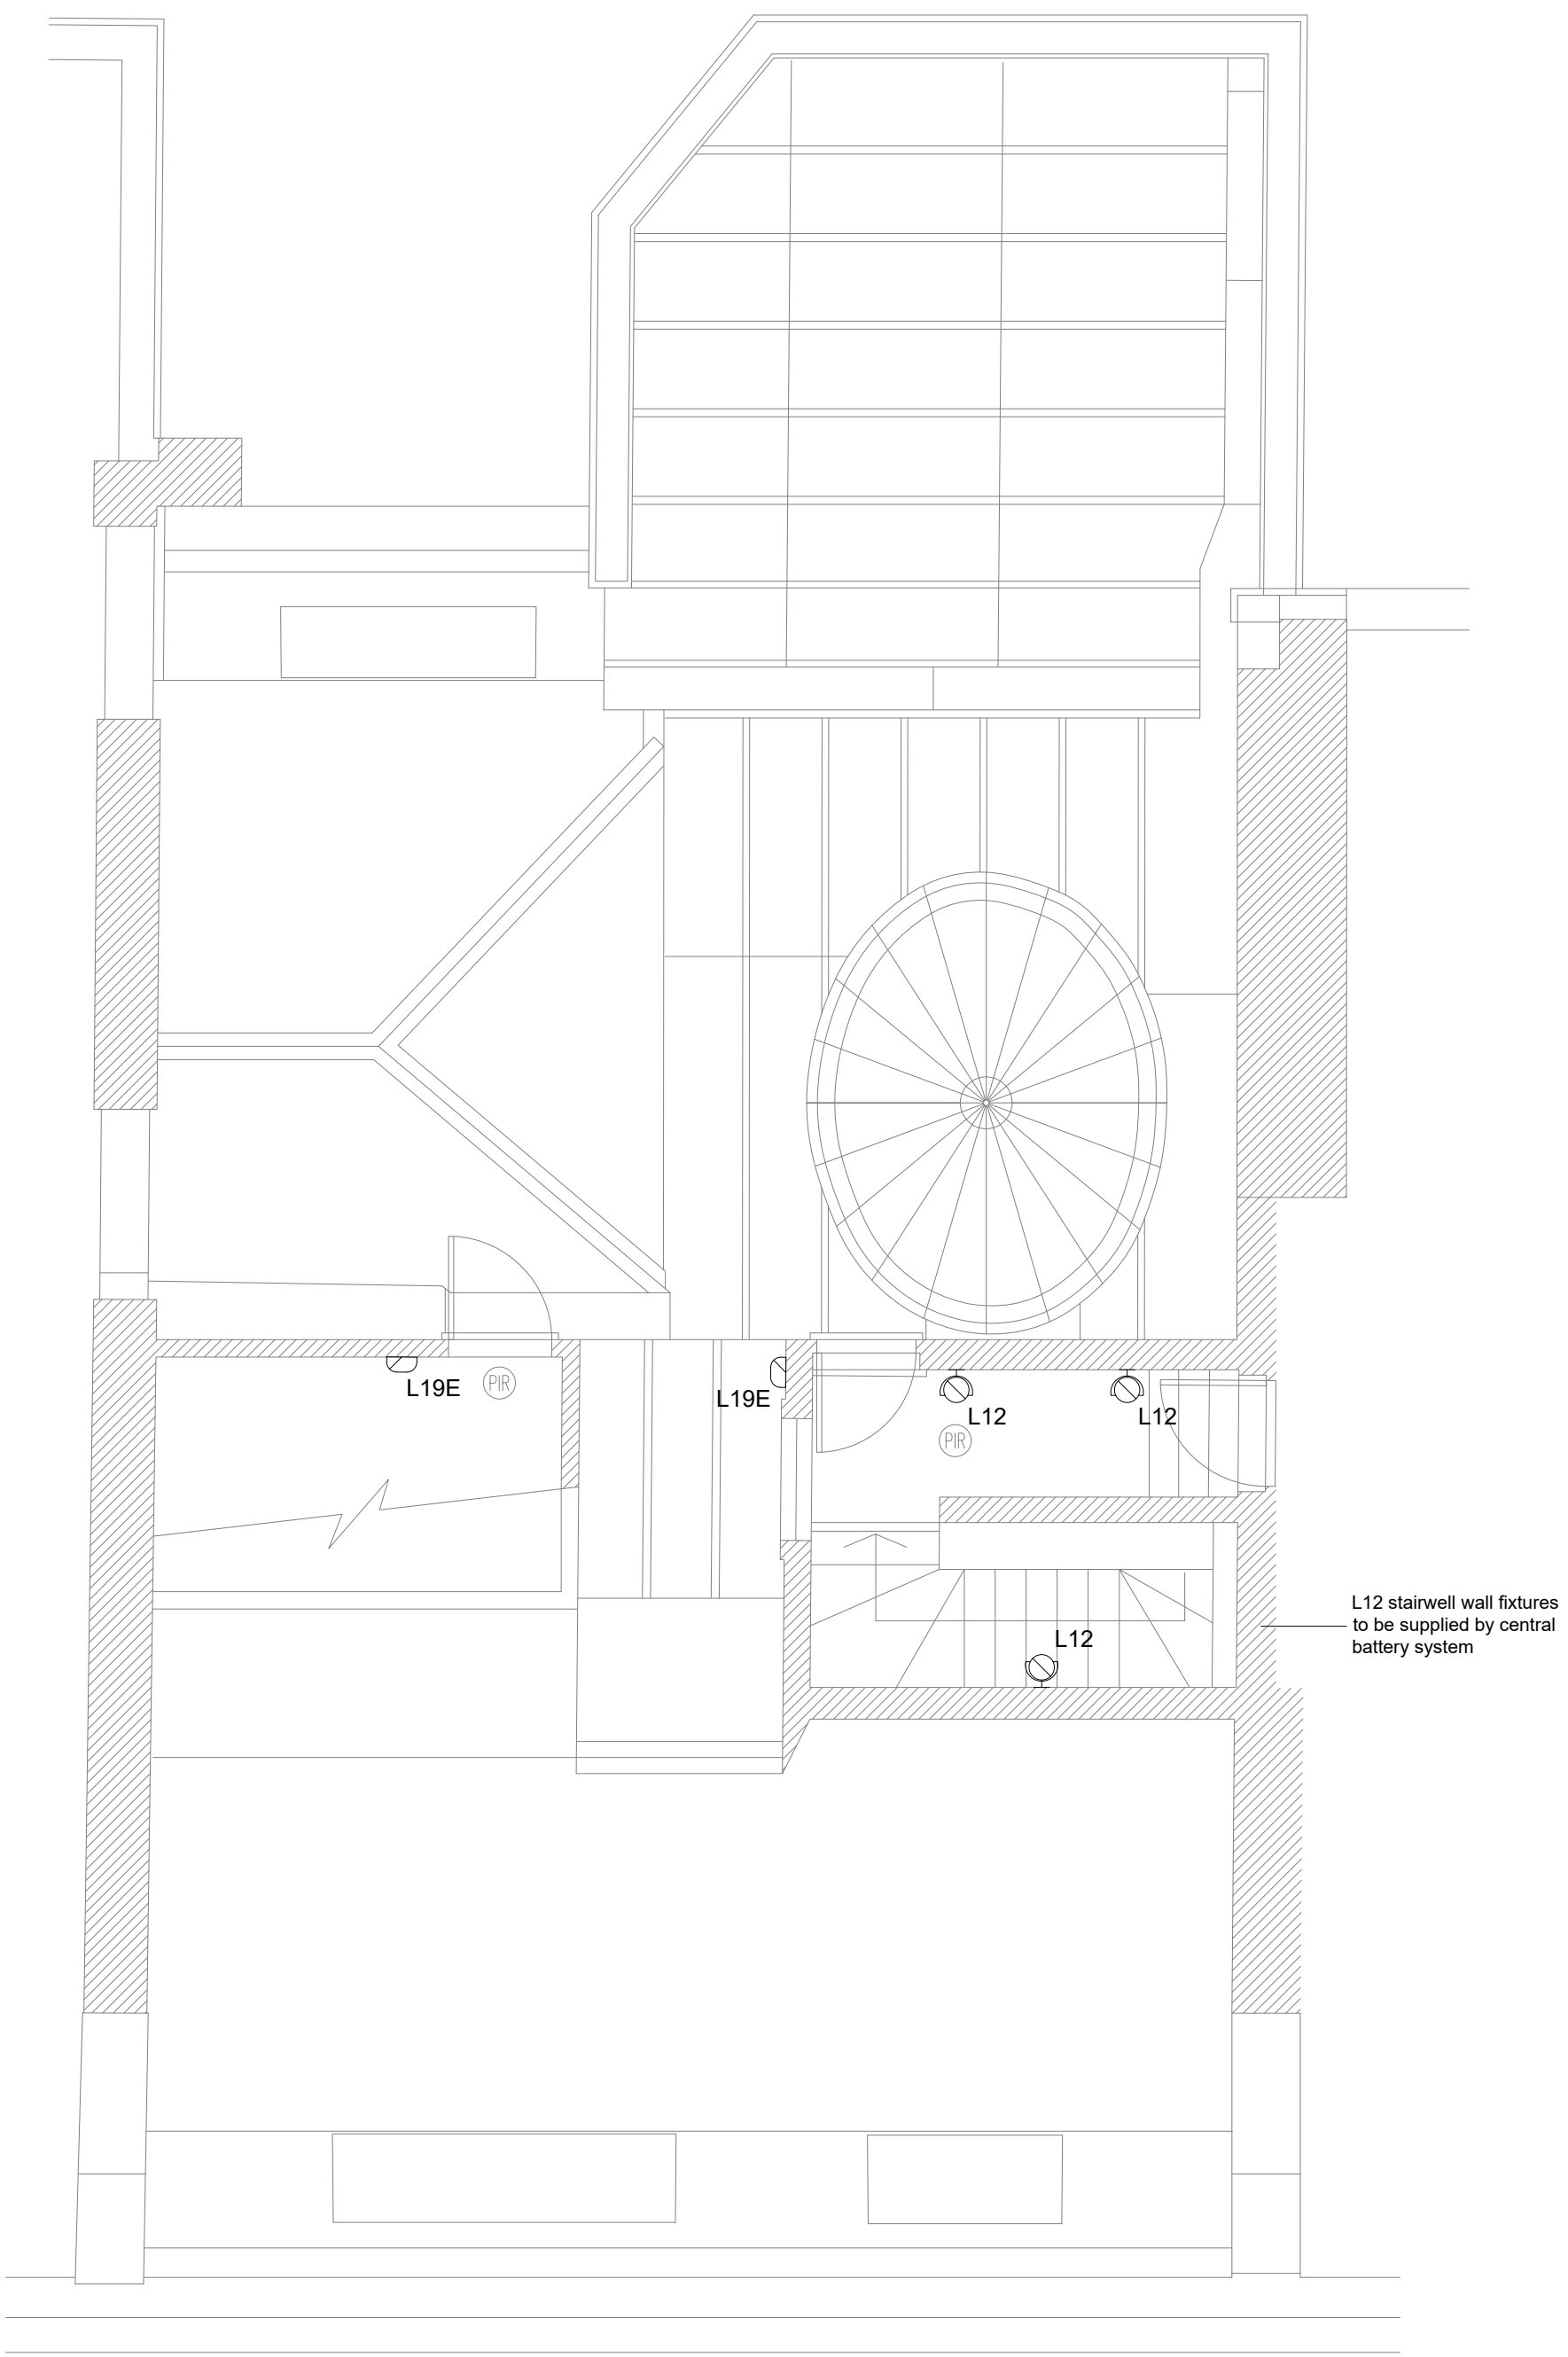

roof

LIGHTING KEY

Type	Description

B	L04 pendants amended	TB	15/01/21
A	layouts amended	TB	09/12/20
o	-	TB	26/11/20
Rev	Description	By	Date

lightworks

Cannon Park, Transerra Road, Paddock Wood, Kent TN12 6JF, UK
Tel: +44 (0) 1892 838311
Fax: +44 (0) 1892 838322
Web: www.lightworks.co.uk

Project

23 Bedford Square

3F + Roof Lighting Layouts

Designed By	Checked By
Thomas Burbage	-
REV	Sheet
B	03 of 03
Date	Scale
15/01/2021	1/50@A0
Drawing Number	Project Number
LW.23.21185.LL.03	21185