

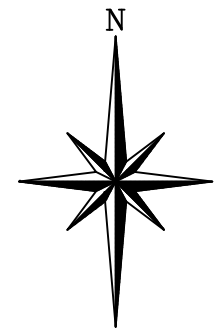


Site Plan
Scale 1:500

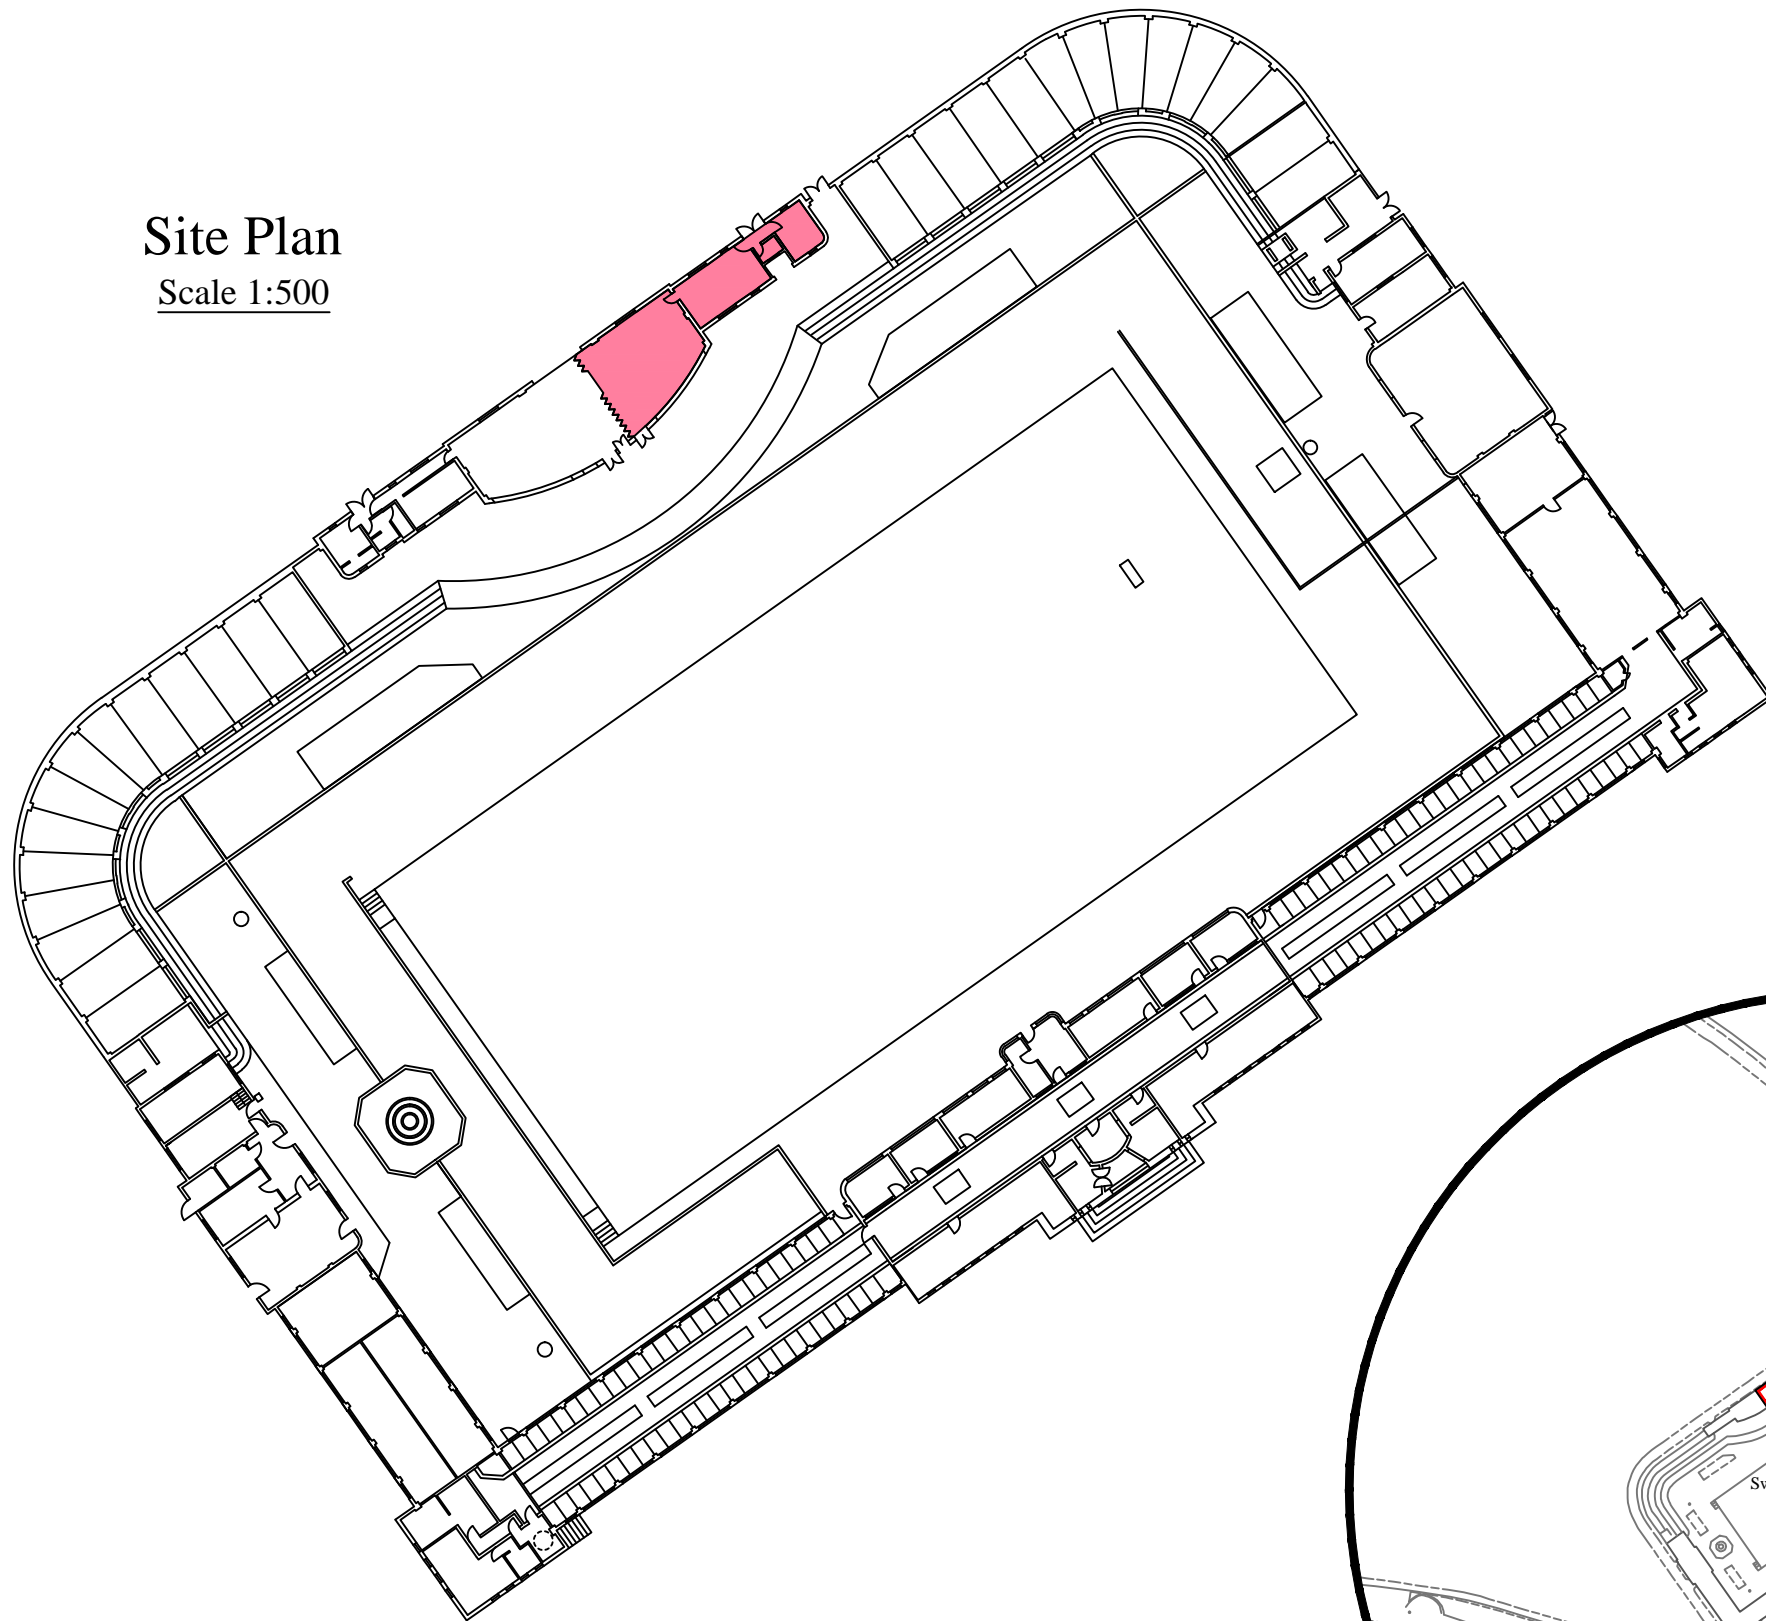

Location Plan
Scale 1:2500

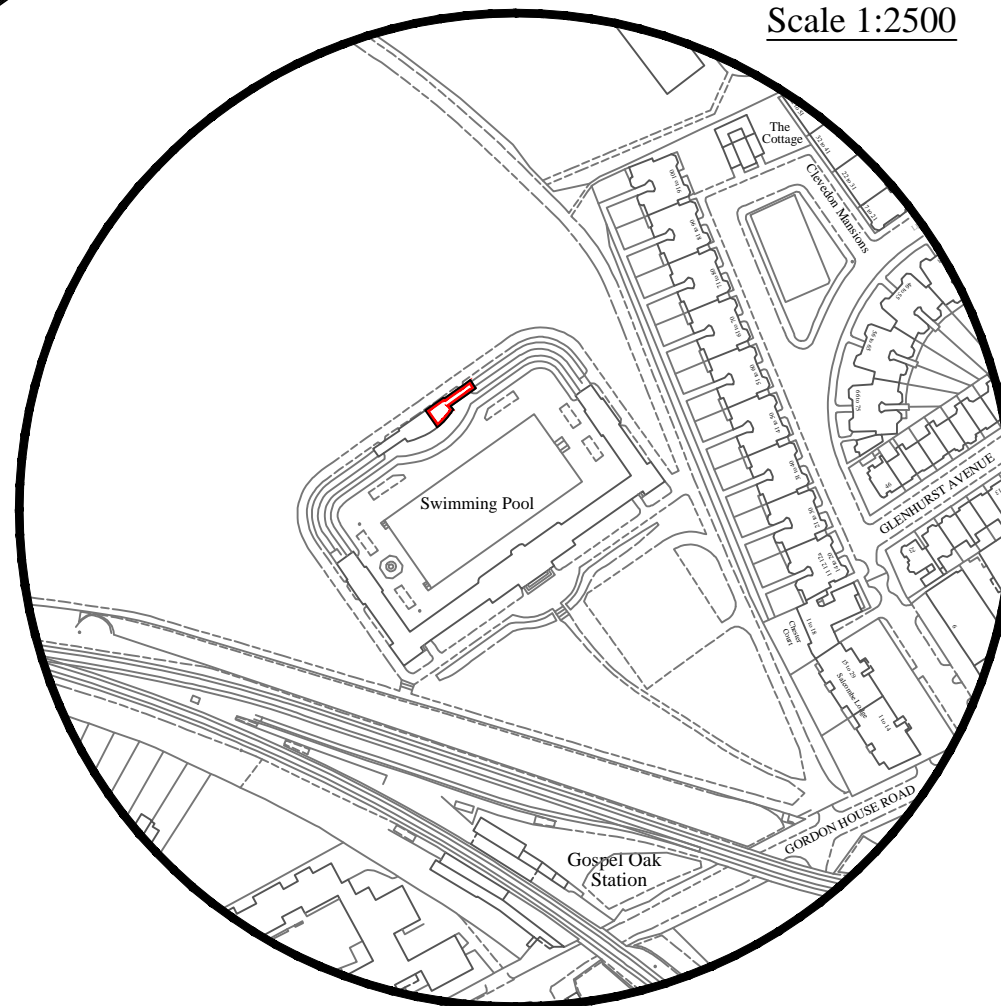

Rev		Drawn	Date
B	Layout & frame altered to meet H.M. land Registry requirements.	DTM	03/05
A	Hatching style amended.	SJC	05/00
Based upon a plan held on microfiche by D.o.T.S. Additional Information taken from the Ordnance Survey digital data plan No. TQ2885NW			



P.G.Bennett, MA (Cantab) FRICS
City Surveyor

CITY SURVEYOR'S DEPARTMENT
Corporate Property Group :
Cartographic Plans & Research Section

Address :
Lido Kiosk
Hampstead Heath
London N.W.5

Title :
Lease Plan

Print scale :	As Shown	Drawn by :	D.T.M.
Date :	MAY 1995	Pro code	UPRN
Drawing No :	3-C-0480		
Revision	A	B	

Based upon the Ordnance Survey mapping with the permission of the Controller of Her Majesty's Stationery Office © Crown Copyright. Unauthorised reproduction infringes Crown copyright and may lead to prosecution or civil proceedings. City of London 100023243 2006.