

© COPYRIGHT JKS DESIGN TEAM 2020
DO NOT SCALE FROM DRAWINGS.

CONTRACTOR/FABRICATOR IS RESPONSIBLE FOR CHECKING & COORDINATING ALL SITE DIMENSIONS PRIOR TO CONSTRUCTION. ALL DIMENSIONAL DISCREPANCIES ARE TO BE REPORTED TO JKS DESIGN. CONTRACTOR/FABRICATOR TO CHECK SITE ACCESS PRIOR TO CONSTRUCTION

DRAWINGS ARE INTENT DRAWINGS. CONTRACTOR/FABRICATOR IS RESPONSIBLE FOR CONSTRUCTION METHODS & STRUCTURAL INTEGRITY & PERFORMANCE OF ALL ELEMENTS.

DRAWINGS TO BE READ IN CONJUNCTION WITH MEP/STRUCTURAL ENGINEERS/LIGHTING DESIGNERS/KITCHEN DESIGNERS DRAWINGS. ANY CONFLICTS BETWEEN CONSULTANTS DRAWINGS AND JKS DESIGN DRAWINGS TO BE REPORTED TO JKS DESIGN PRIOR TO CONSTRUCTION.

SHOP DRAWINGS AND FINISH SAMPLES ARE REQUIRED FOR ALL JOINERY/CASE GOODS AND BESPOKE FF&E FABRICATIONS OR OTHER ELEMENTS PRIOR TO CONSTRUCTION.

NOTES:

- a. Licensable Activities may take place anywhere within the red line
- b. The locations of fire safety equipment are indicative only and subject to change following a fire risk assessment or on the advice of the LFB
- c. Any detail not required by the regulations is indicative only and subject to change without notice

MEANS OF ESCAPE DISTANCES	
ROUTE ID	DISTANCE (METRES)
1	25.6 m
2	14 m
3	28.7 m
4	13.8 m
5	14.5 m

<DRAWING STAGE>
DESIGN INTENT ONLY

B	08/03/2021	CONSTRUCTION ISSUE	SH
A	03/02/2021	CONSTRUCTION ISSUE	SH
-	12/10/2020	CONSTRUCTION ISSUE	CP
REV.NO	DATE	DESCRIPTION	BY

JKS DESIGN TEAM
67-69 George St,
Marylebone, London W1U
8LT

CLIENT
KITCHEN TABLE

PROJECT
KITCHEN TABLE
REFURBISHMENT

TITLE
FIRE STRATEGY AND
LICENSING PLANS


DATE 08/03/2021

SCALE 1:50@A1

CHECKED BY SH


PROJECT N°
KITCHEN TABLE

DRAWING N° A1900	REVISION B
---------------------	---------------

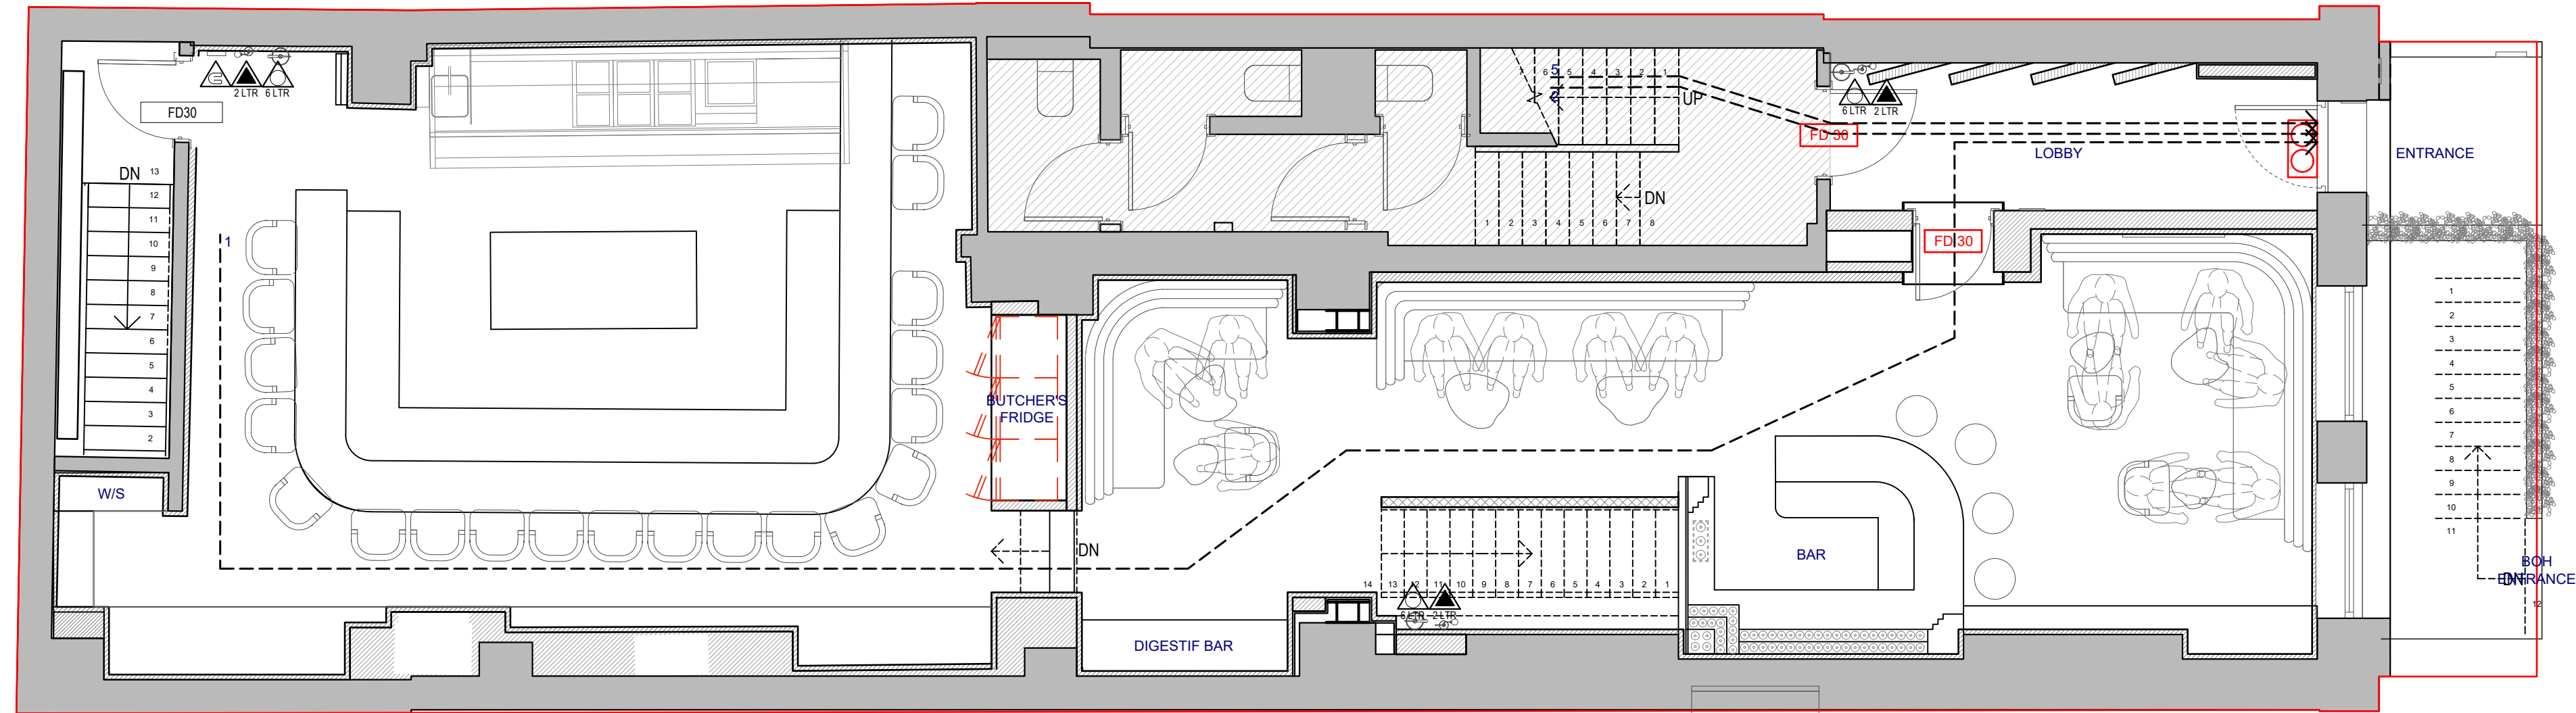

02 GA GROUND FLOOR PLAN




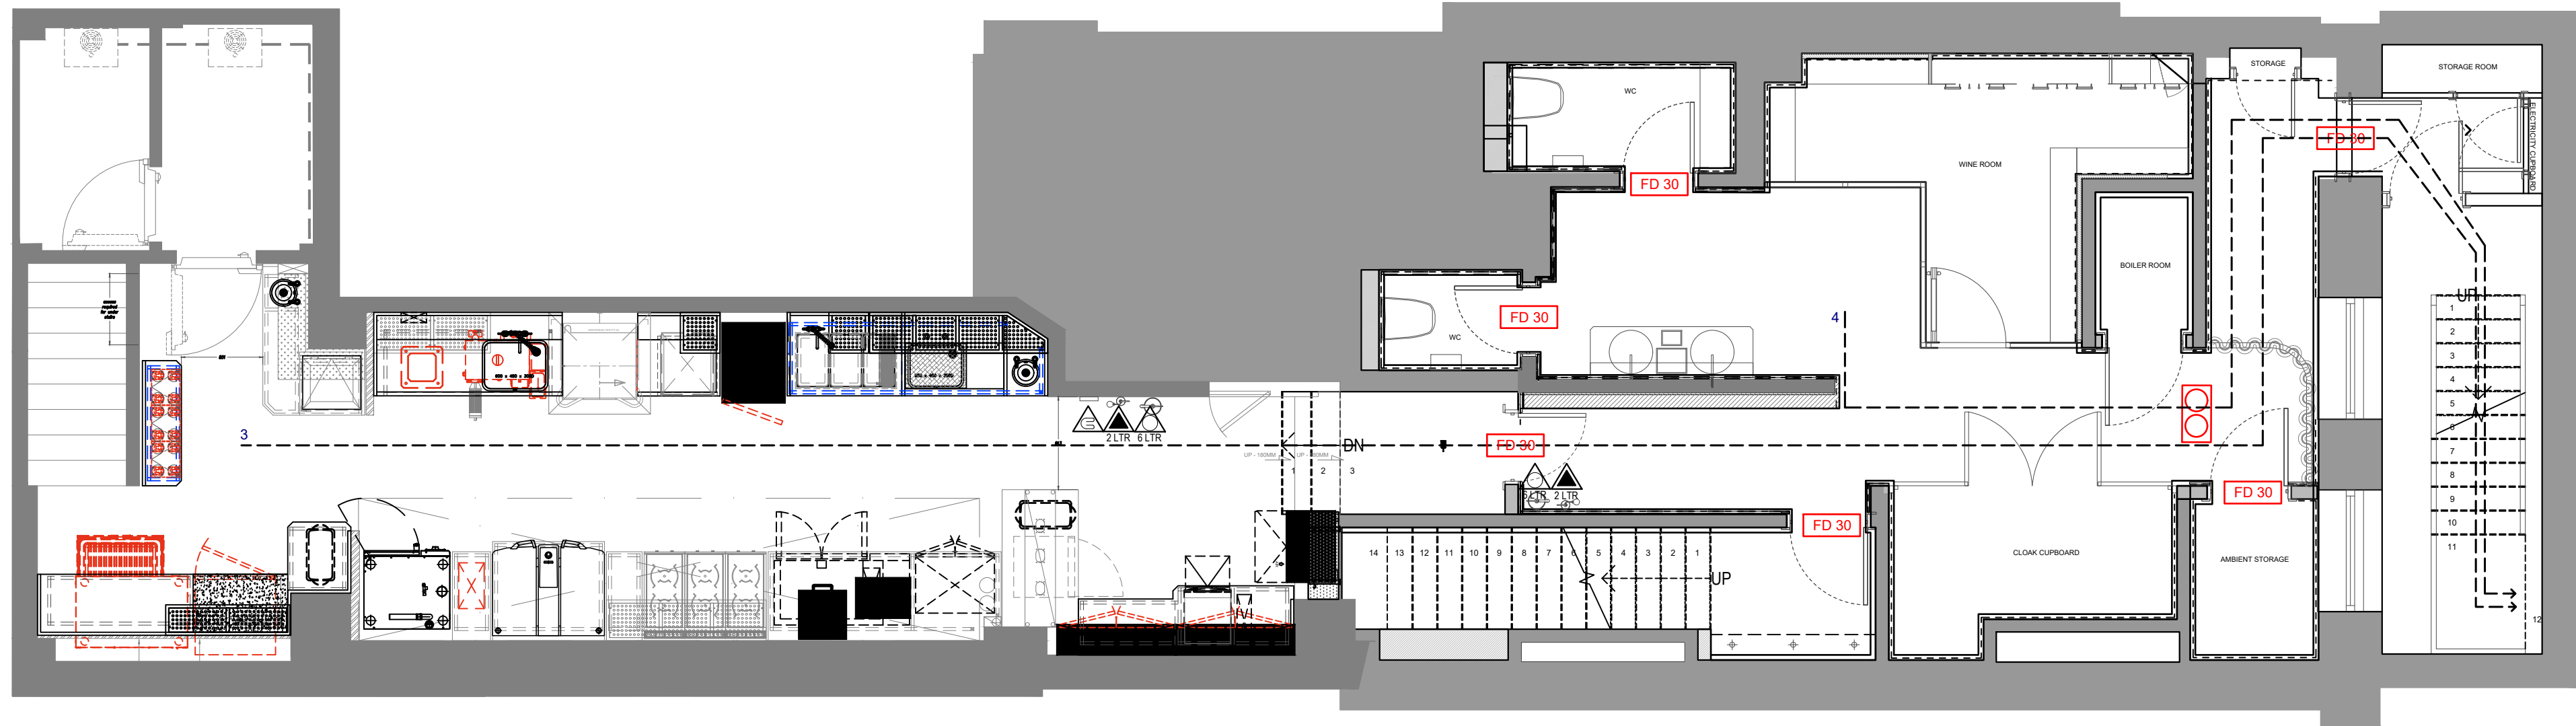


1:50 @ A1



02 GA BASEMENT PLAN

  1:50 @ A1

SYMBOL KEY:

-  FIRE BLANKET
-  FIRE EXTINGUISHER C02 - 2 LTR
-  FIRE EXTINGUISHER CHEMICAL - 6 LTR
-  ILLUMINATED EMERGENCY EXIT SIGN (DIRECTIONAL SIGN)
-  FIRE DOOR 30 MINUTE
-  POINT OF CHOICE