


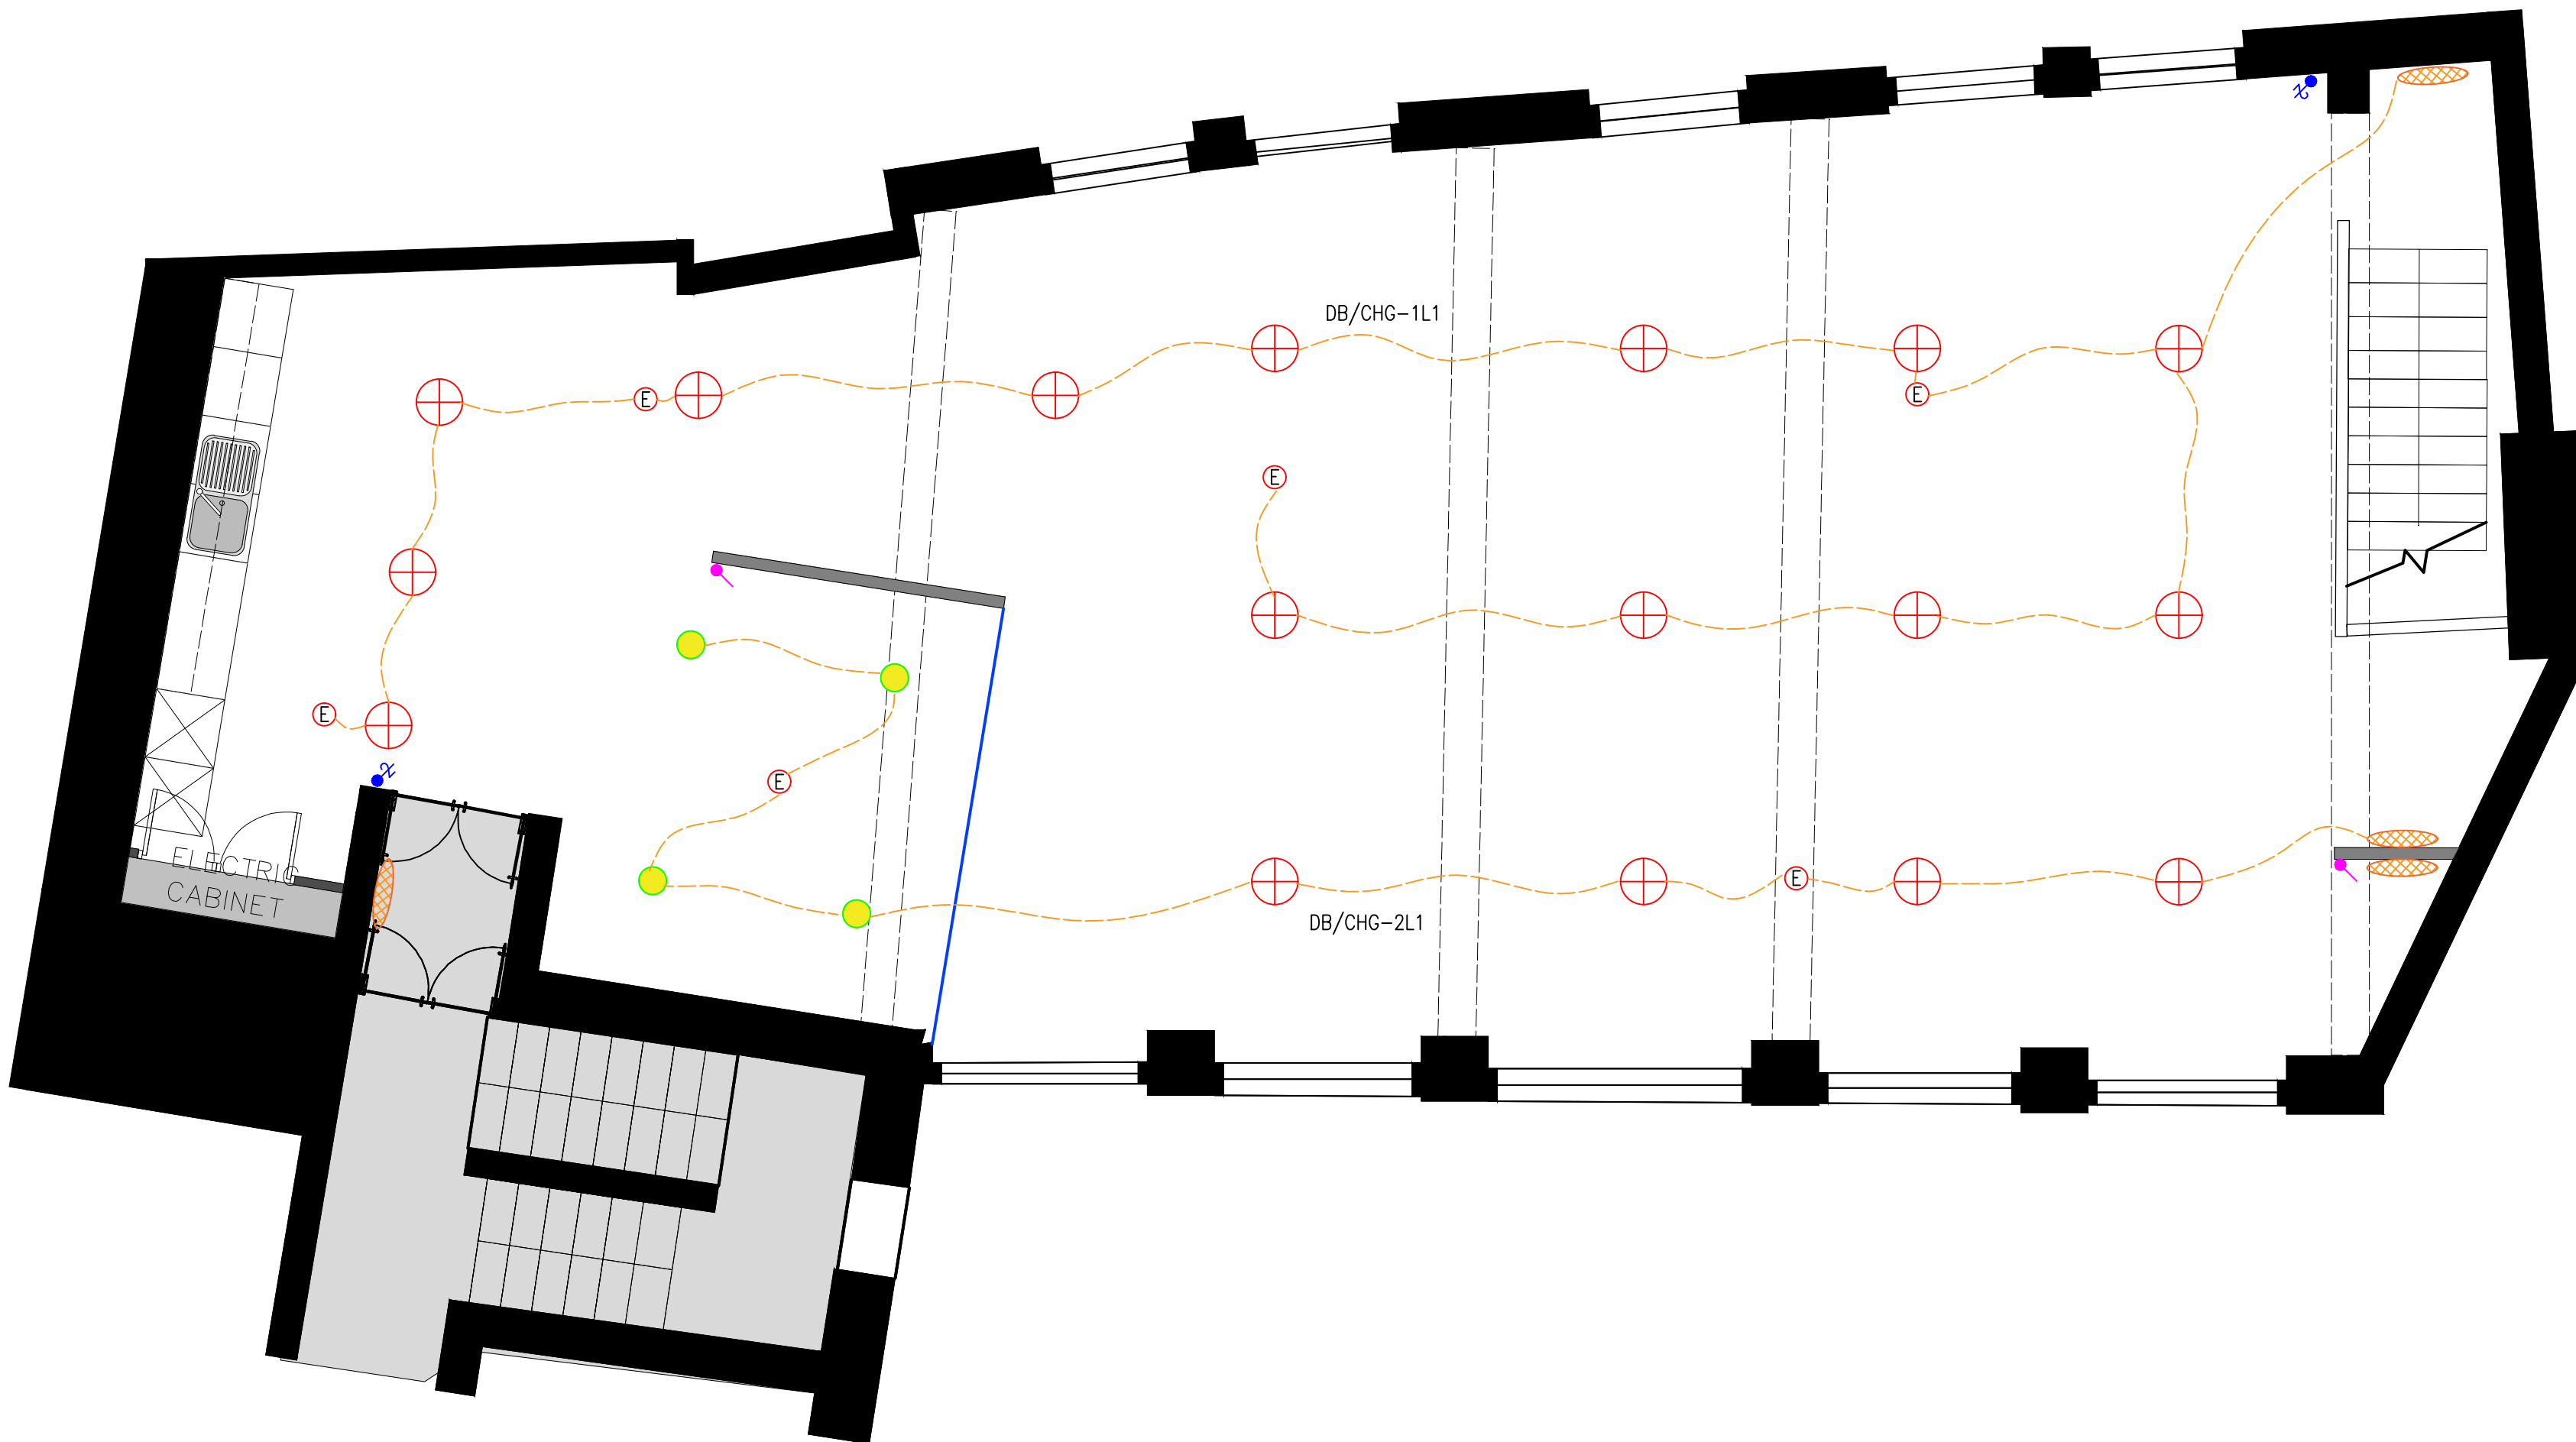

LEGEND:

- HAMILTON LED LINEAR LIGHT
- LED 162 UPLIGHTER
- BULKHEAD LIGHT C/W EMERGENCY & PIR
- EXISTING RELOCATED LIGHT FITTING
- SURFACE MOUNTED DOWNLIGHT
- EMERGENCY BUTTON LIGHT
- 1 WAY SWITCH
- 2 WAY SWITCH
- PIR SWITCH

This drawing may not be copied, reproduced or given to any Third parties for any reason whatsoever without the written permission of Portico Limited.  
Please note that this drawing is protected under Copyright and remains the property of Portico Limited at all times.

All dimensions must be checked on site and not scaled from this drawing.

Proposals are subject to approvals by statutory authorities.  
Drawings are subject to full dimensioned site surveys.  
Building parameters have been taken from drawings provided.  
All low level power symbols shown are indicative size only.

All space layout/plans are subject to full dimensional, structural and services surveys.

|     |      |             |
|-----|------|-------------|
|     |      |             |
|     |      |             |
|     |      |             |
|     |      |             |
|     |      |             |
| Rev | Date | Description |



THE OLD FORGE  
r/o 61 HIGH STREET  
GREEN STREET GREEN  
ORPINGTON, KENT  
BR6 6BQ

Tel : 01689 858899 Fax : 01689 858965  
E-mail : portico@porticoltd.co.uk

Project

COACH HOUSE  
8 ALFRED MEWS  
W1T 7AA

Title

FIRST FLOOR  
LIGHTING LAYOUT

Client

WHITEPAPER CO

|             |          |       |         |
|-------------|----------|-------|---------|
| Scale       | Date     | Drawn | Checked |
| 1:50@A1     | 29-01-20 | LD    | -       |
| Drawing No. | Revision |       |         |
| PC6484-E101 | -        |       |         |