


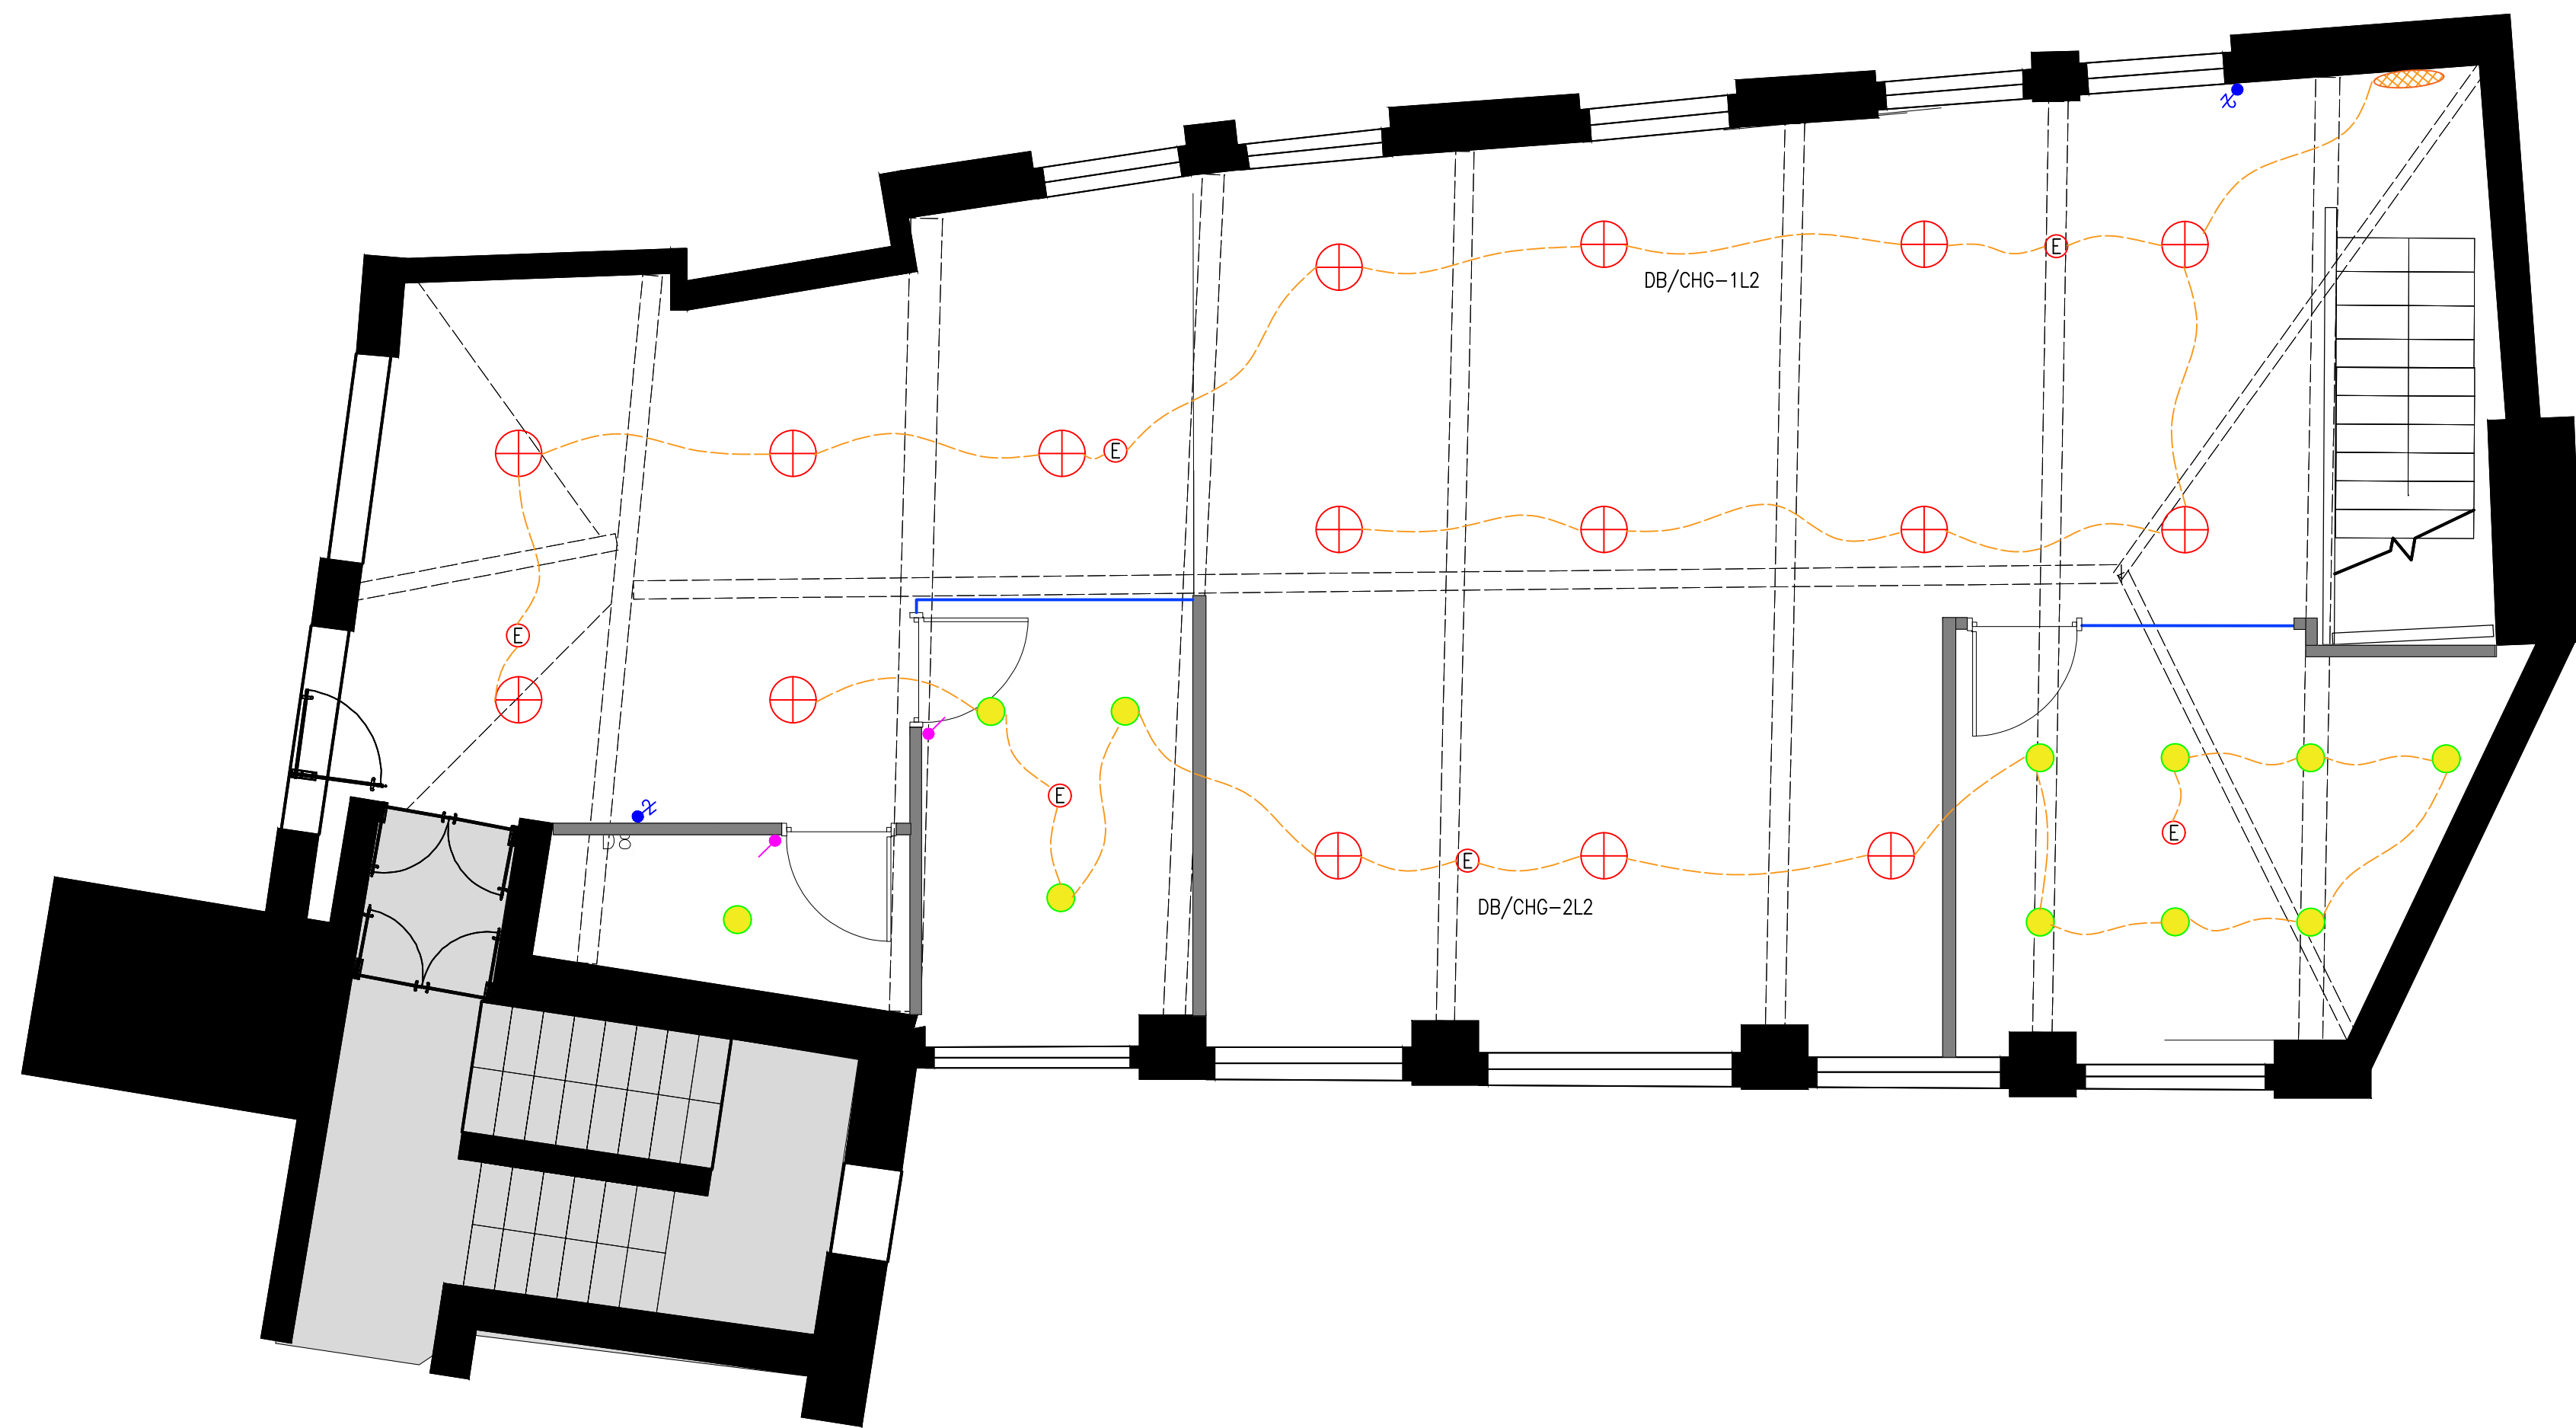

LEGEND:

- HAMILTON LED LINEAR LIGHT
- LED 162 UPLIGHTER
- BULKHEAD LIGHT C/W EMERGENCY & PIR
- EXISTING RELOCATED LIGHT FITTING
- SURFACE MOUNTED DOWNLIGHT
- EMERGENCY BUTTON LIGHT
- 1 WAY SWITCH
- 2 WAY SWITCH
- PIR SWITCH

This drawing may not be copied, reproduced or given to any Third parties for any reason whatsoever without the written permission of Portico Limited. Please note that this drawing is protected under Copyright and remains the property of Portico Limited at all times.

All dimensions must be checked on site and not scaled from this drawing.

Proposals are subject to approvals by statutory authorities. Drawings are subject to full dimensioned site surveys. Building parameters have been taken from drawings provided. All low level power symbols shown are indicative size only.

All space layout/plans are subject to full dimensional, structural and services surveys.

Rev	Date	Description



THE OLD FORGE
r/o 61 HIGH STREET
GREEN STREET GREEN
ORPINGTON, KENT
BR6 6BQ

Tel : 01689 858899 Fax : 01689 858965
E-mail : portico@porticoltd.co.uk

Project
COACH HOUSE
8 ALFRED MEWS
W1T 7AA

Title
SECOND FLOOR
LIGHTING LAYOUT

Client
WHITEPAPER CO

Scale 1:50@A1	Date 29-01-20	Drawn LD	Checked -
------------------	------------------	-------------	--------------

Drawing No. PC6484-E201	Revision -
----------------------------	---------------