
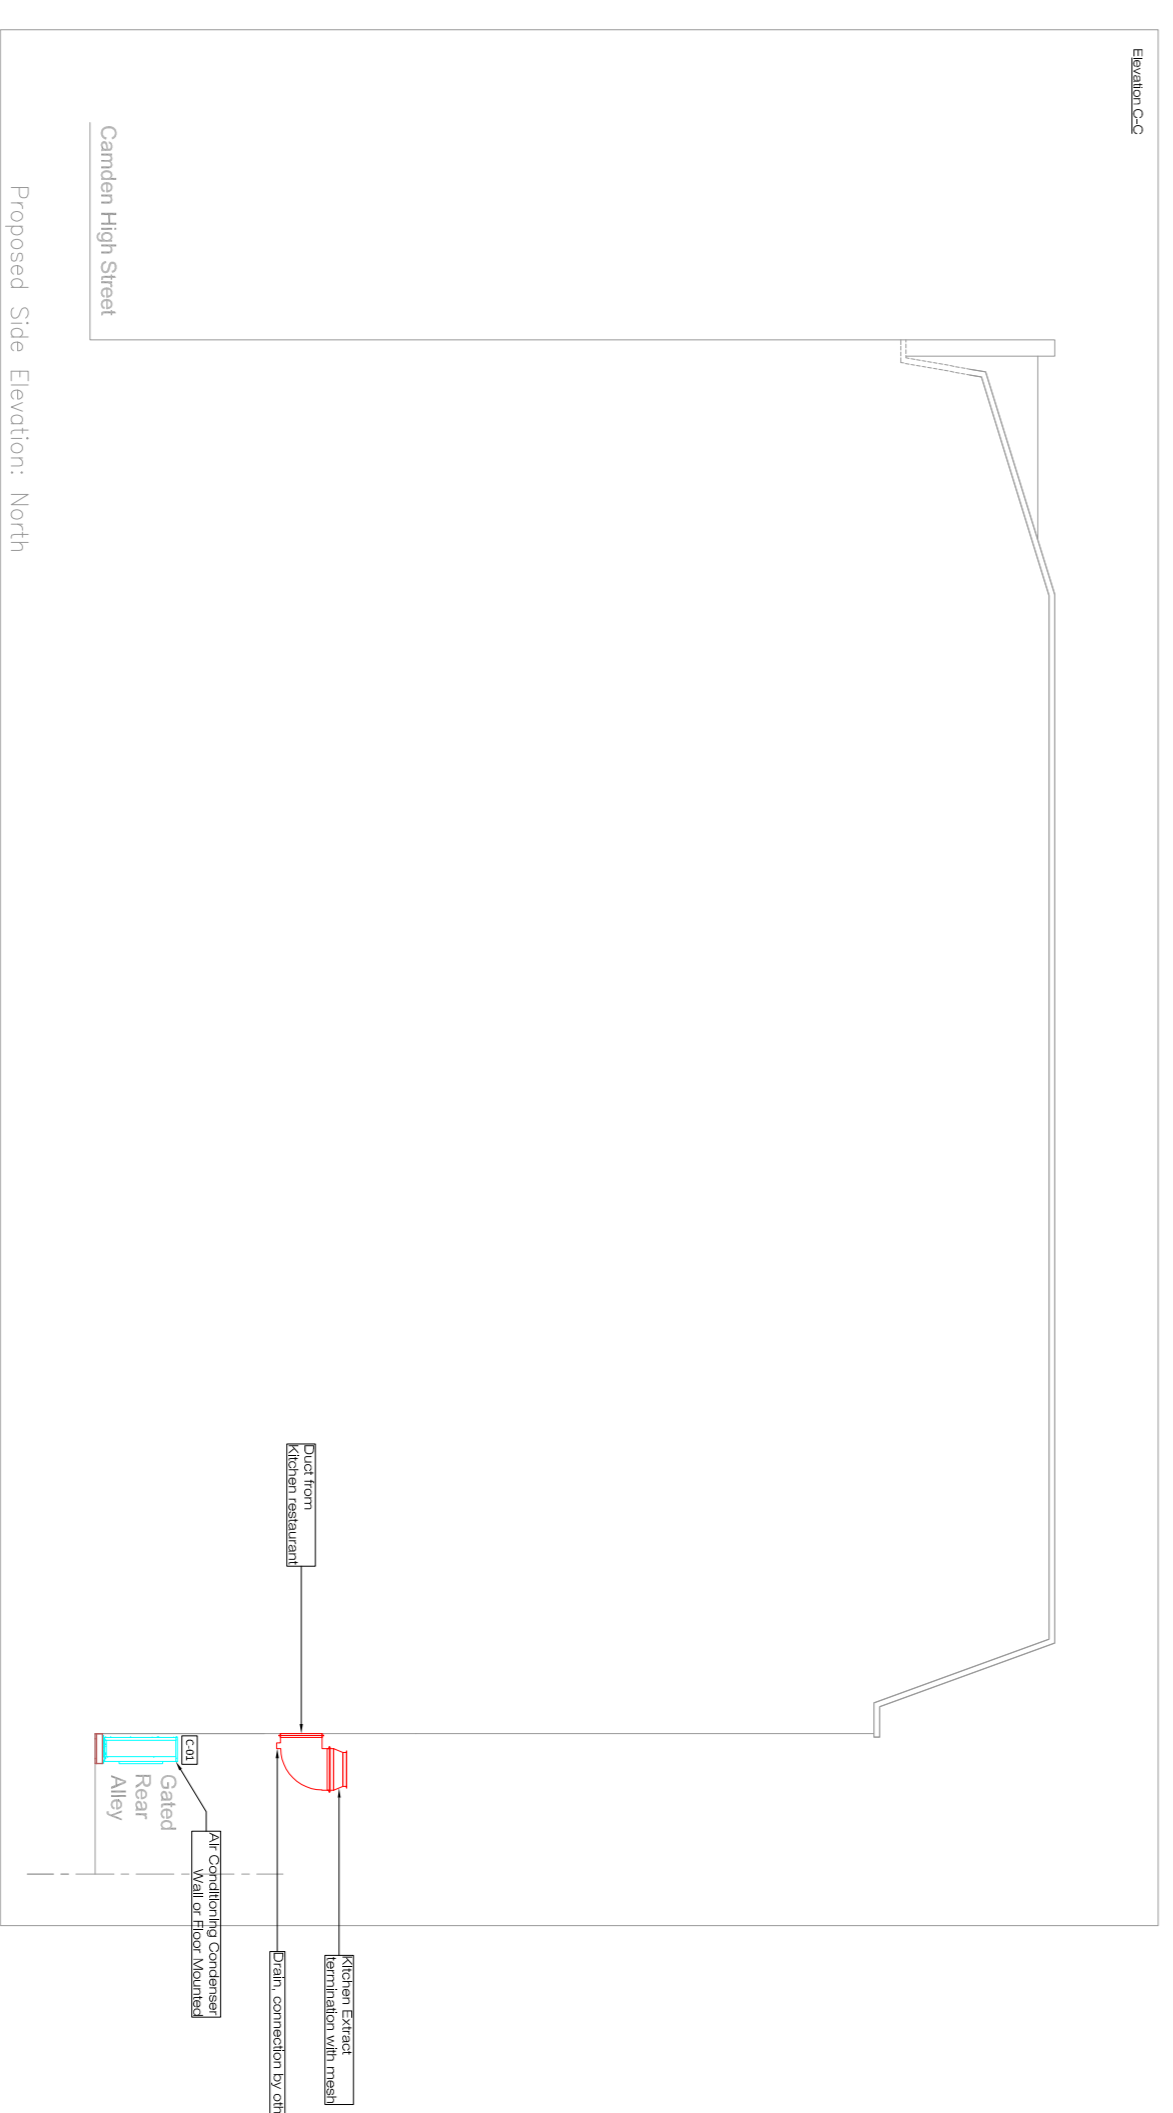
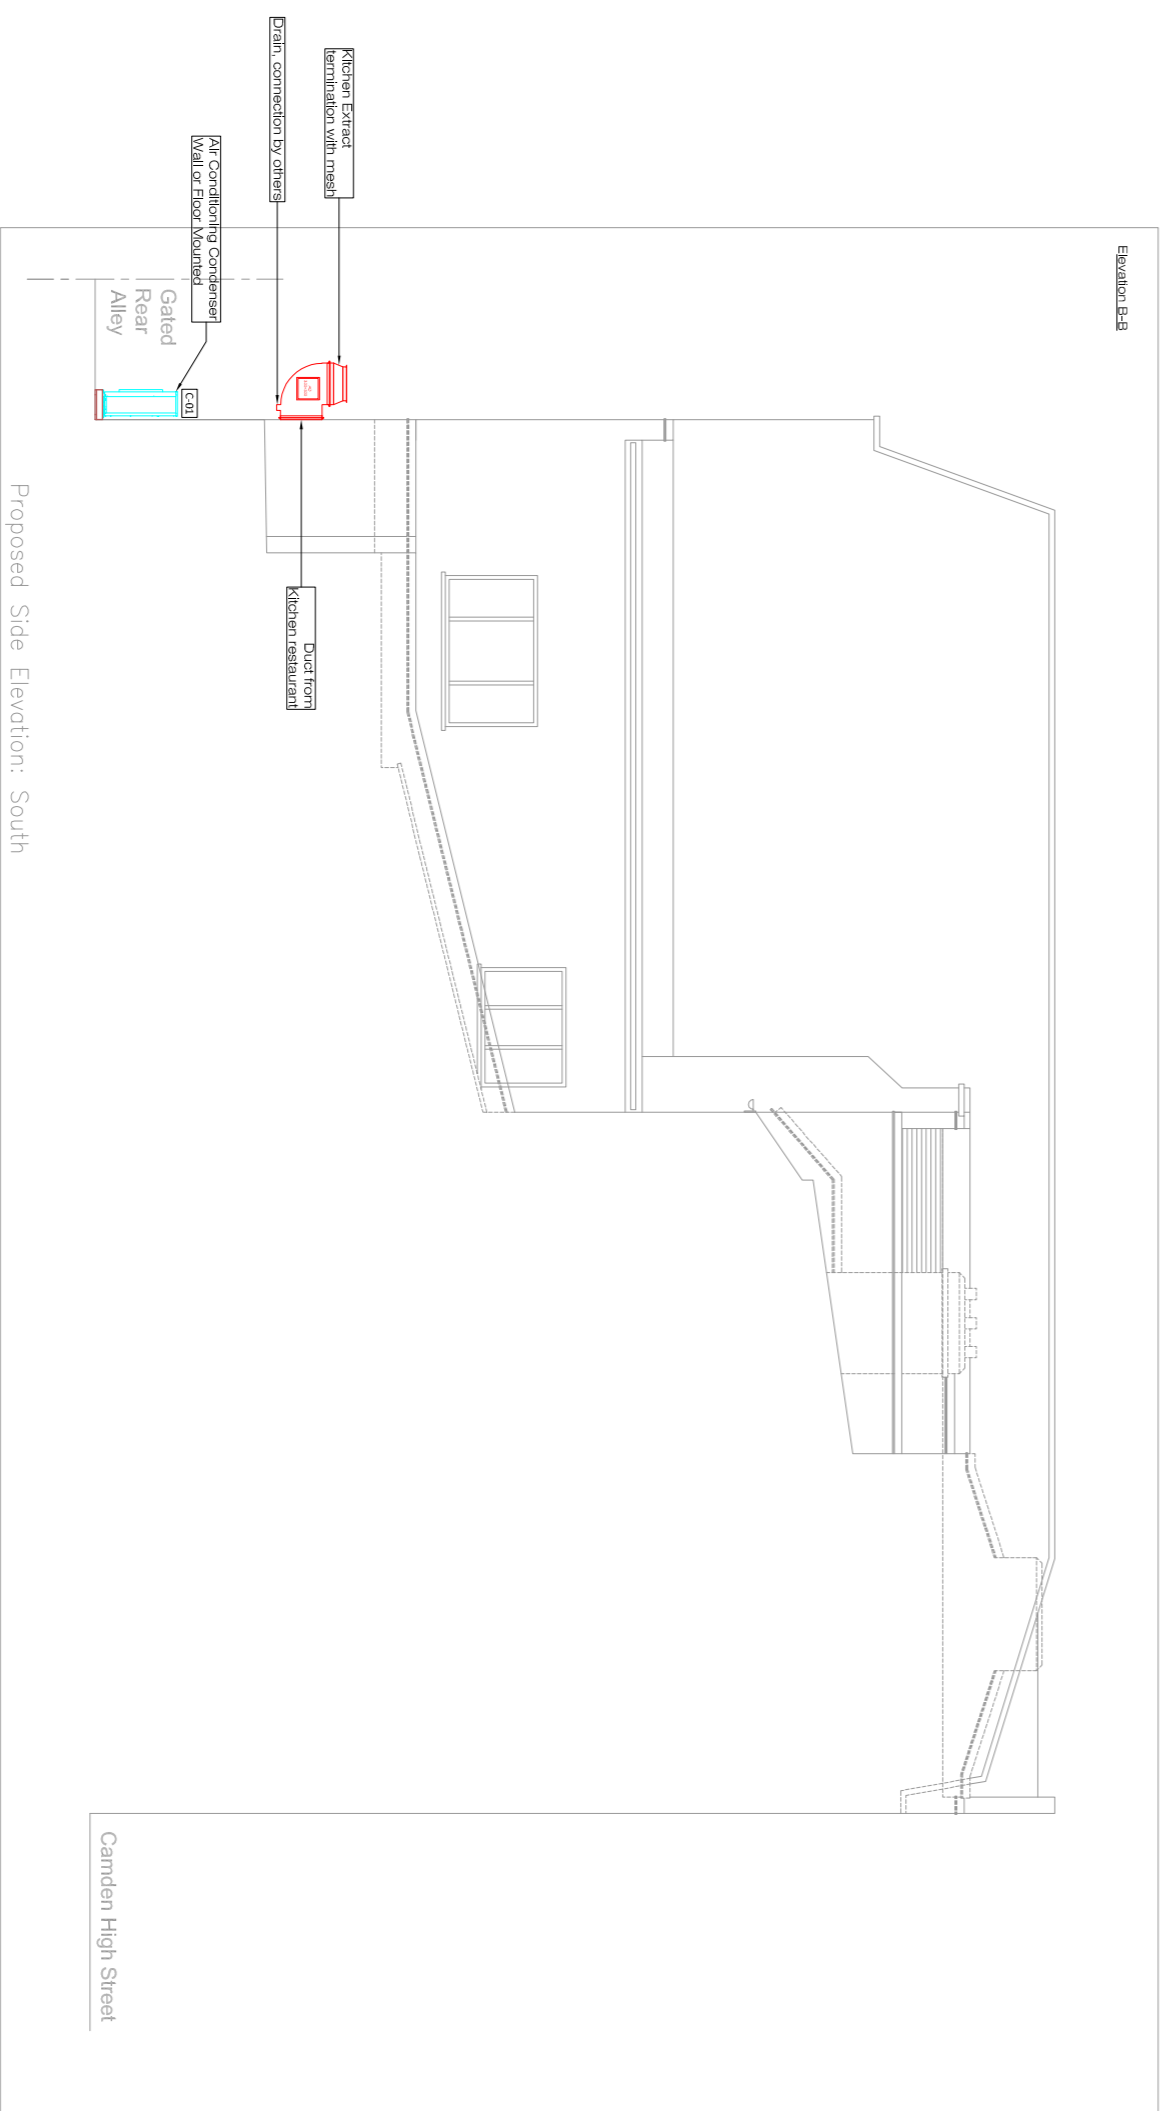
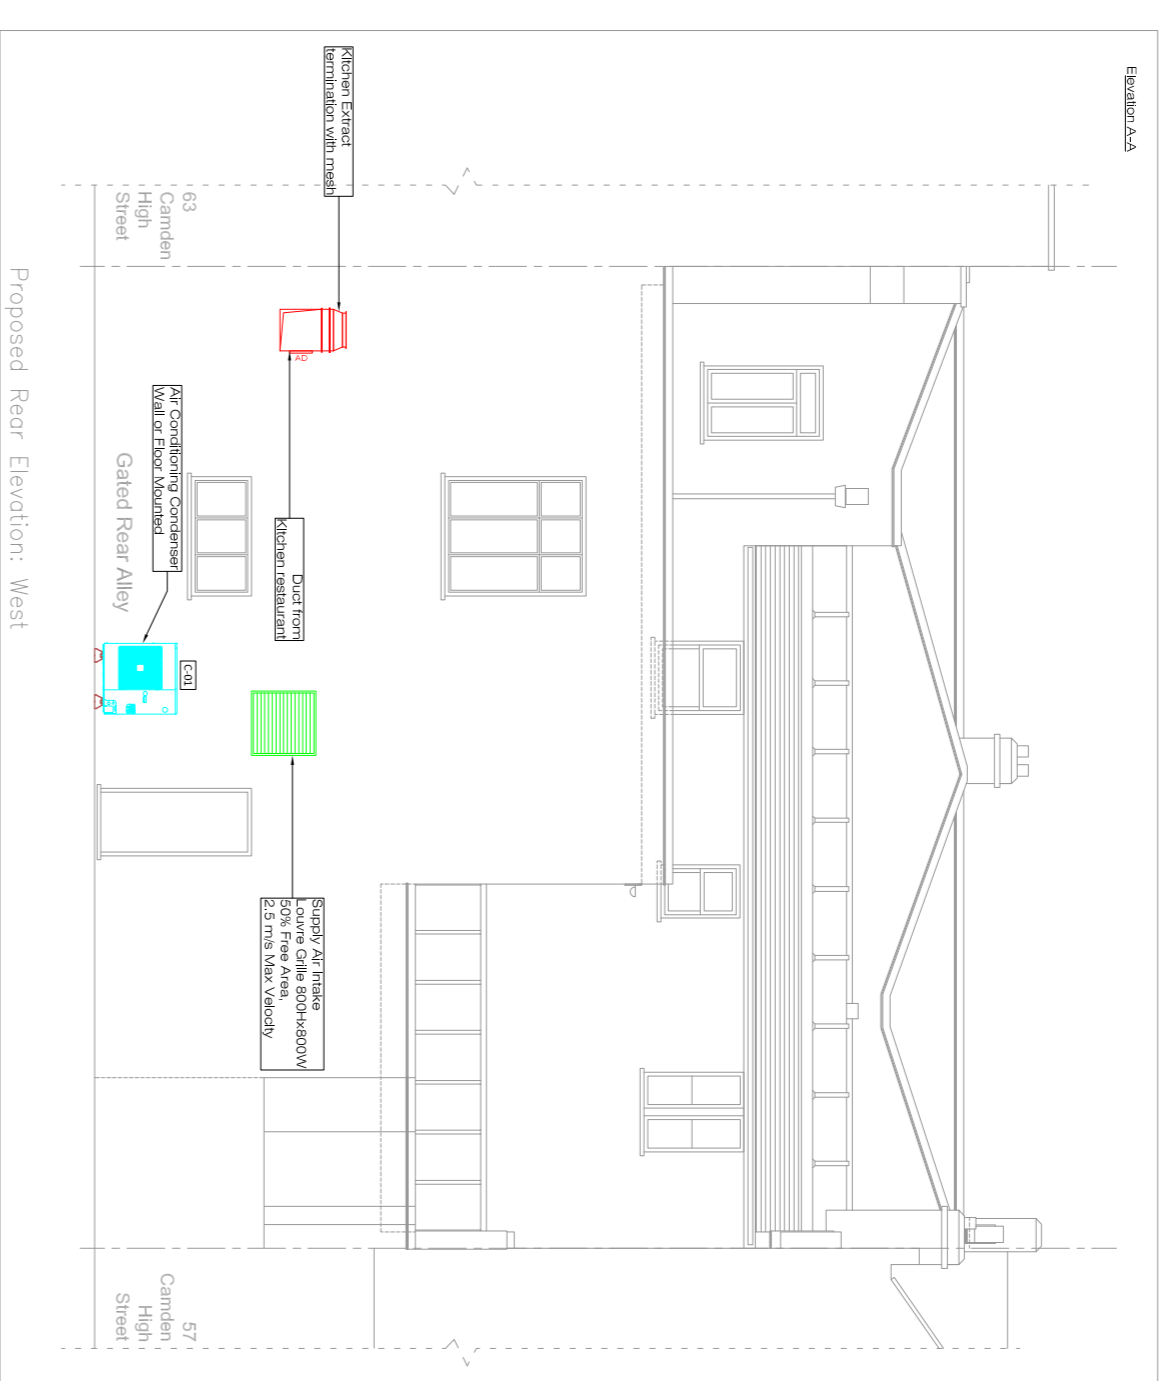


Proposed External Elevations and duct route

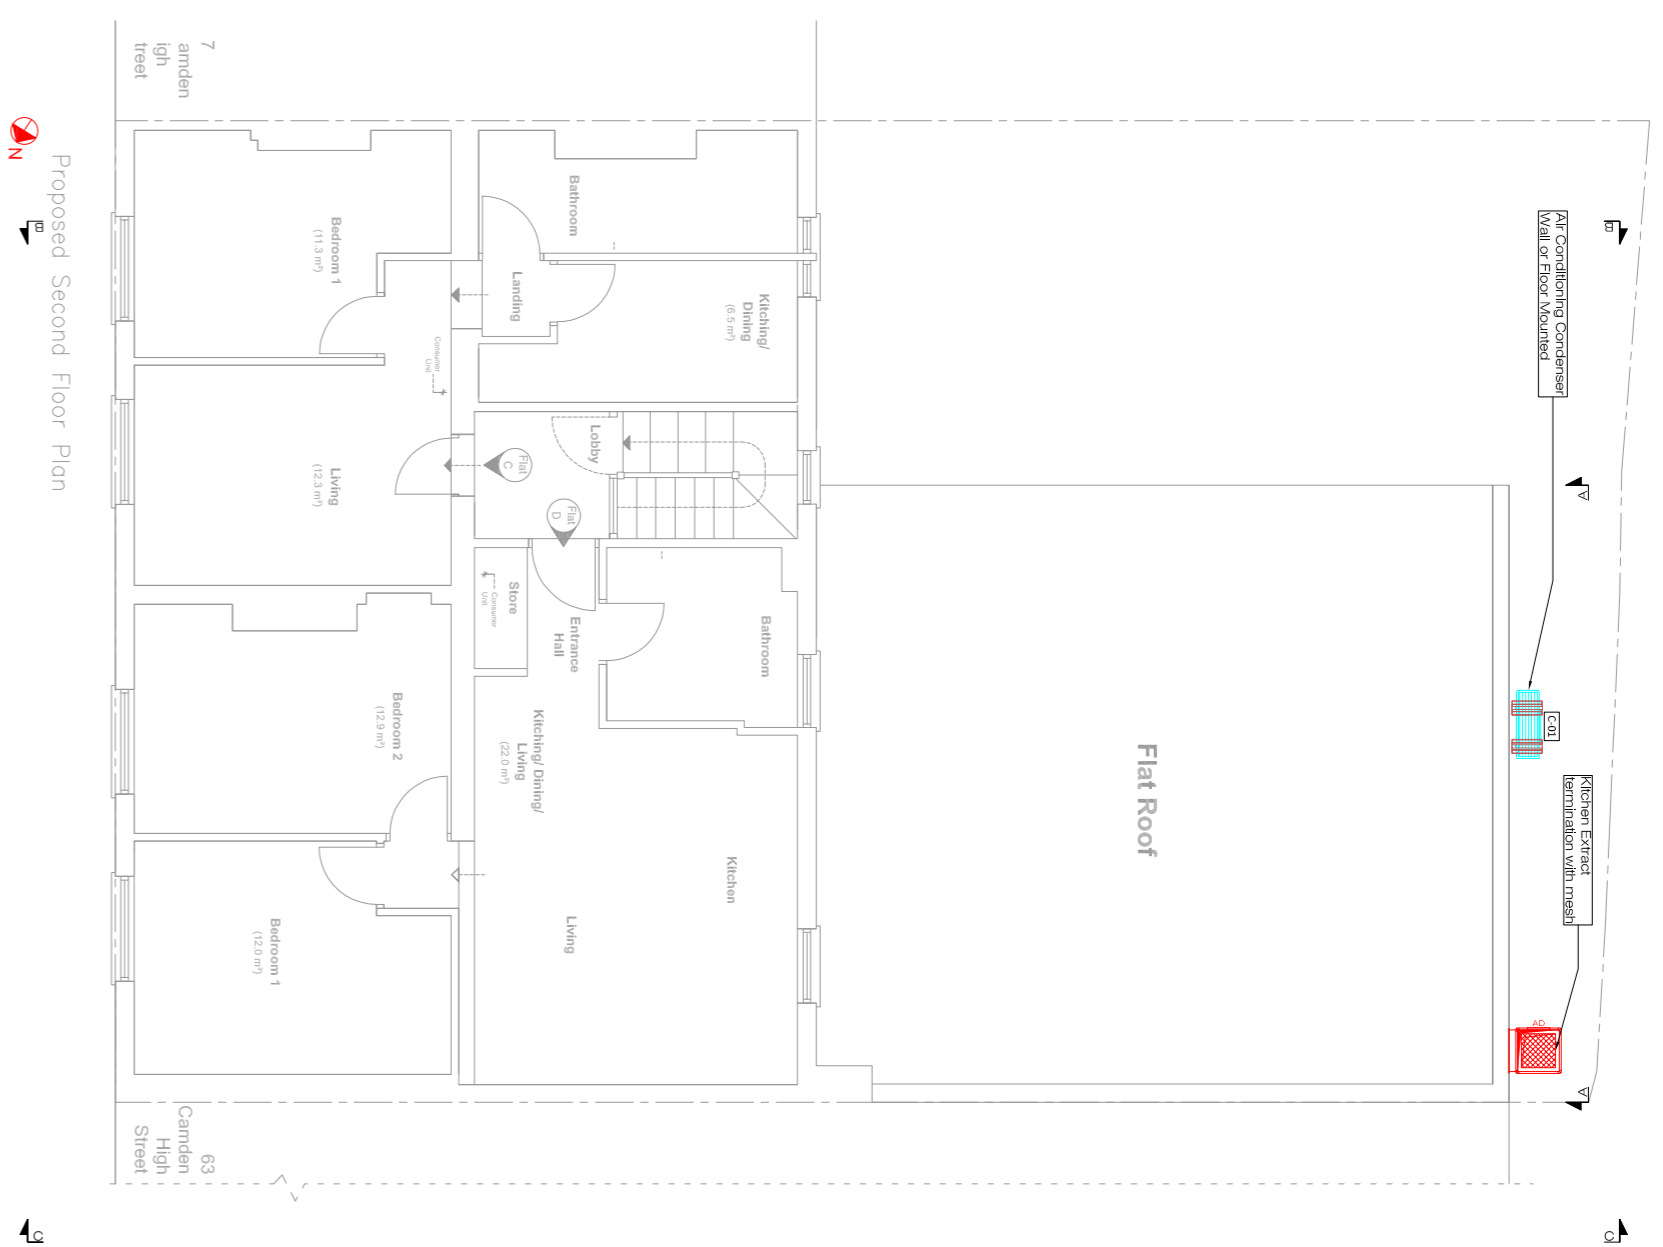

Legend - Demise

- Commercial
- Communal Emergency 'right of way' escape

NOTES:

HVAC LEGEND:

	Supply Air Duct		Volume Control Damper
	Extract Air Duct		Fire Damper
	Supply Air Grille		Supply Air Valve
	Extract Air Grille		Extract Air Valve
	A/C Ceiling Grille		Access Door
	A/C Pipe Work		Air Conditioning Unit

THIS DRAWING MUST NOT BE SCALED. ALL SETTING OUT MUST BE CHECKED ON SITE. ALL DIMENSIONS MUST BE TO FACE UNLESS SPECIFICALLY NOTED OTHERWISE. THE DRAWING MUST NOT BE REPRODUCED OR TRANSMITTED IN ANY FORM OR BY ANY MEANS, ELECTRONIC OR MECHANICAL, INCLUDING PHOTOCOPYING, RECORDING, OR BY ANY INFORMATION STORAGE AND RETRIEVAL SYSTEM, WITHOUT THE WRITTEN PERMISSION OF LEECH GROUP SERVICES. LEECH MECHANICAL SERVICES & PSYTRIVE CONSULTANTS LIMITED



Unit 17, Mapledean Works, Maldon Road, Latchingdon, Essex, CM3 6LG
 Tel: +44 (0)1621 742424
 Email: help@leechgroupservices.co.uk
www.leechgroupservices.co.uk

Rev	Rev by	Description	Date
A.	MS	Revised as per comments	19.06.2020
B.	MS	Discharge revised	24.06.2020
C.	DCC	Discharge revised	05.10.2020
D.	DCC	Discharge route revised	06.10.2020
E.	DCC	Discharge route revised	20.01.2021
F.	MS	Discharge revised	15.03.2021
G.			
H.			

PROJECT:
 Rooster Piri Piri
 61 Camden High Street
 London, NW1 7JL

TITLE:
 Proposed Ventilation & Air
 Conditioning External Layout

PROJECT NUMBER: Rooster Piri Piri Camden

DATE: 27/05/2020

DRAWN BY: MS

CHECKED BY: ML

DRAWING NO.: RPP/002 Rev F

SCALE: 1:100@A1