


 
 



### DESIGN NOTE

DRAWING ISSUE FOR DESIGN INTENT DEVELOPMENT. FINAL LOCATION OF AIR VALVES VENTILATION END POSITIONS, IN PARTICULAR ILLUSTRATED AT THE EXTERNAL FACADES AND ROOF TO BE AGREED WITH PROJECT DESIGN TEAM AND SUBJECT TO PLANNING.

### LEGEND

-  CEILING MOUNT IN-LINE EXTRACT FAN UNIT AS VECTAIRE'S MFL100T COMPLETE WITH ADJUSTABLE OVER-RUN TIMER FROM 3 & 15 MINUTES OR EQUAL WITH JONERY & REMOVABLE ACCESS PANEL
-  EXTRACT AIR VALVE
-  FRESH AIR SUPPLY VALVE
-  RECTANGULAR VENTILATION DUCTWORK
-  DUCTED COOKERHOOD
-  FIRE BREAK


### NOTES

1. FOR EXACT FLOOR FINISHES REFER TO INTERIOR DESIGNER/ARCHITECTS DRAWINGS.
2. FINAL LOCATIONS OF AIR VALVES TO BE AGREED WITH ARCHITECT.
3. FINAL LOCATION OF MVHR & MEV BOOST SWITCHES TO BE AGREED WITH ARCHITECT.
4. FIRE BREAK 2 HR AS SUPPLIED BY DOMUS OR EQUAL & APPROVED TO BE PROVIDED WHERE PASSING THROUGH FIRE RATED WALLS & FLOORS.
5. VENTILATION DUCTWORK SHALL BE INSTALLED WITH FIRE BREAK DUCT CONNECTOR WHERE PENETRATING THROUGH FLOORS & ROOF.

### BWIC NOTE

1. USE OF EXISTING NOTCHES AND JOISTS TO BE USED WHERE PRACTICAL. ANY NEW NOTCH AND HOLES WILL BE CARRIED OUT IN ACCORDANCE TO LISTED BUILDING REGULATIONS AND STRUCTURAL ENGINEER'S DETAILS.
2. ANY HOLES IN WALLS TO HAVE 'LETTER BOX' ARRANGEMENT TO BE AGREED WITH MBP.

**Note**  
ALL DIMENSIONS TO BE VERIFIED ON SITE BEFORE SETTING OUT OR MAKING ANY SHOP DRAWINGS. THIS DRAWING IS TO BE READ IN CONJUNCTION WITH THE CONSULTANT ENGINEER'S SPECIFICATION.

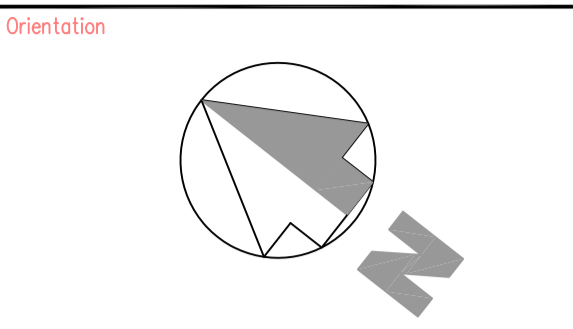


ref./date	REVISIONS
PT 23.12.20	PRE-TENDER ISSUE
PT1 03.02.21	PRE-TENDER ISSUE
T 22.02.21	TENDER ISSUE, GA's UPDATED
T1 15.03.21	TENDER ISSUE, GA's UPDATED

**WORK STAGE 2**

**KUT LLP**  
First Floor  
2E Berol House  
25 Ashley Road  
London  
N17 9LJ  
Tel: +44(0)20 8348 5171  
Fax: +44(0)20 8340 8926  
Email: ktp@kut.co.uk  
Web: www.kut.co.uk

## ROOF MECHANICAL SERVICES VENTILATION

**Project**  
55 CUMBERLAND TERRACE  
CAMDEN, LONDON  
NW1 4HJ

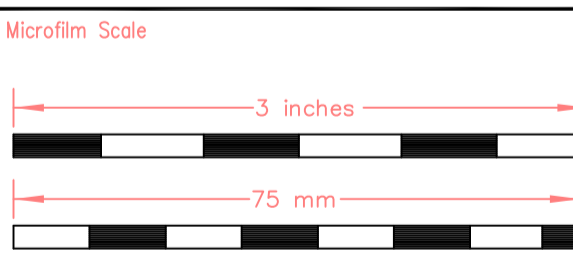


**Architect**  
COLLETT-ZARZYCKI Ltd  
Fernhead Studios, 2B  
Fernhead Road, London W9 3ET  
Tel: +44(0)20 8969 6967  
email: mail@czltd.co.uk

xref	55CT - GA (21-03-03)	
Scale	A1@1:50	Drawn SAS
Date	Nov 2020	Checked

### TENDER

Project No.	Services	Dwg No.	Rev.
6618	M	WS2-114	T1

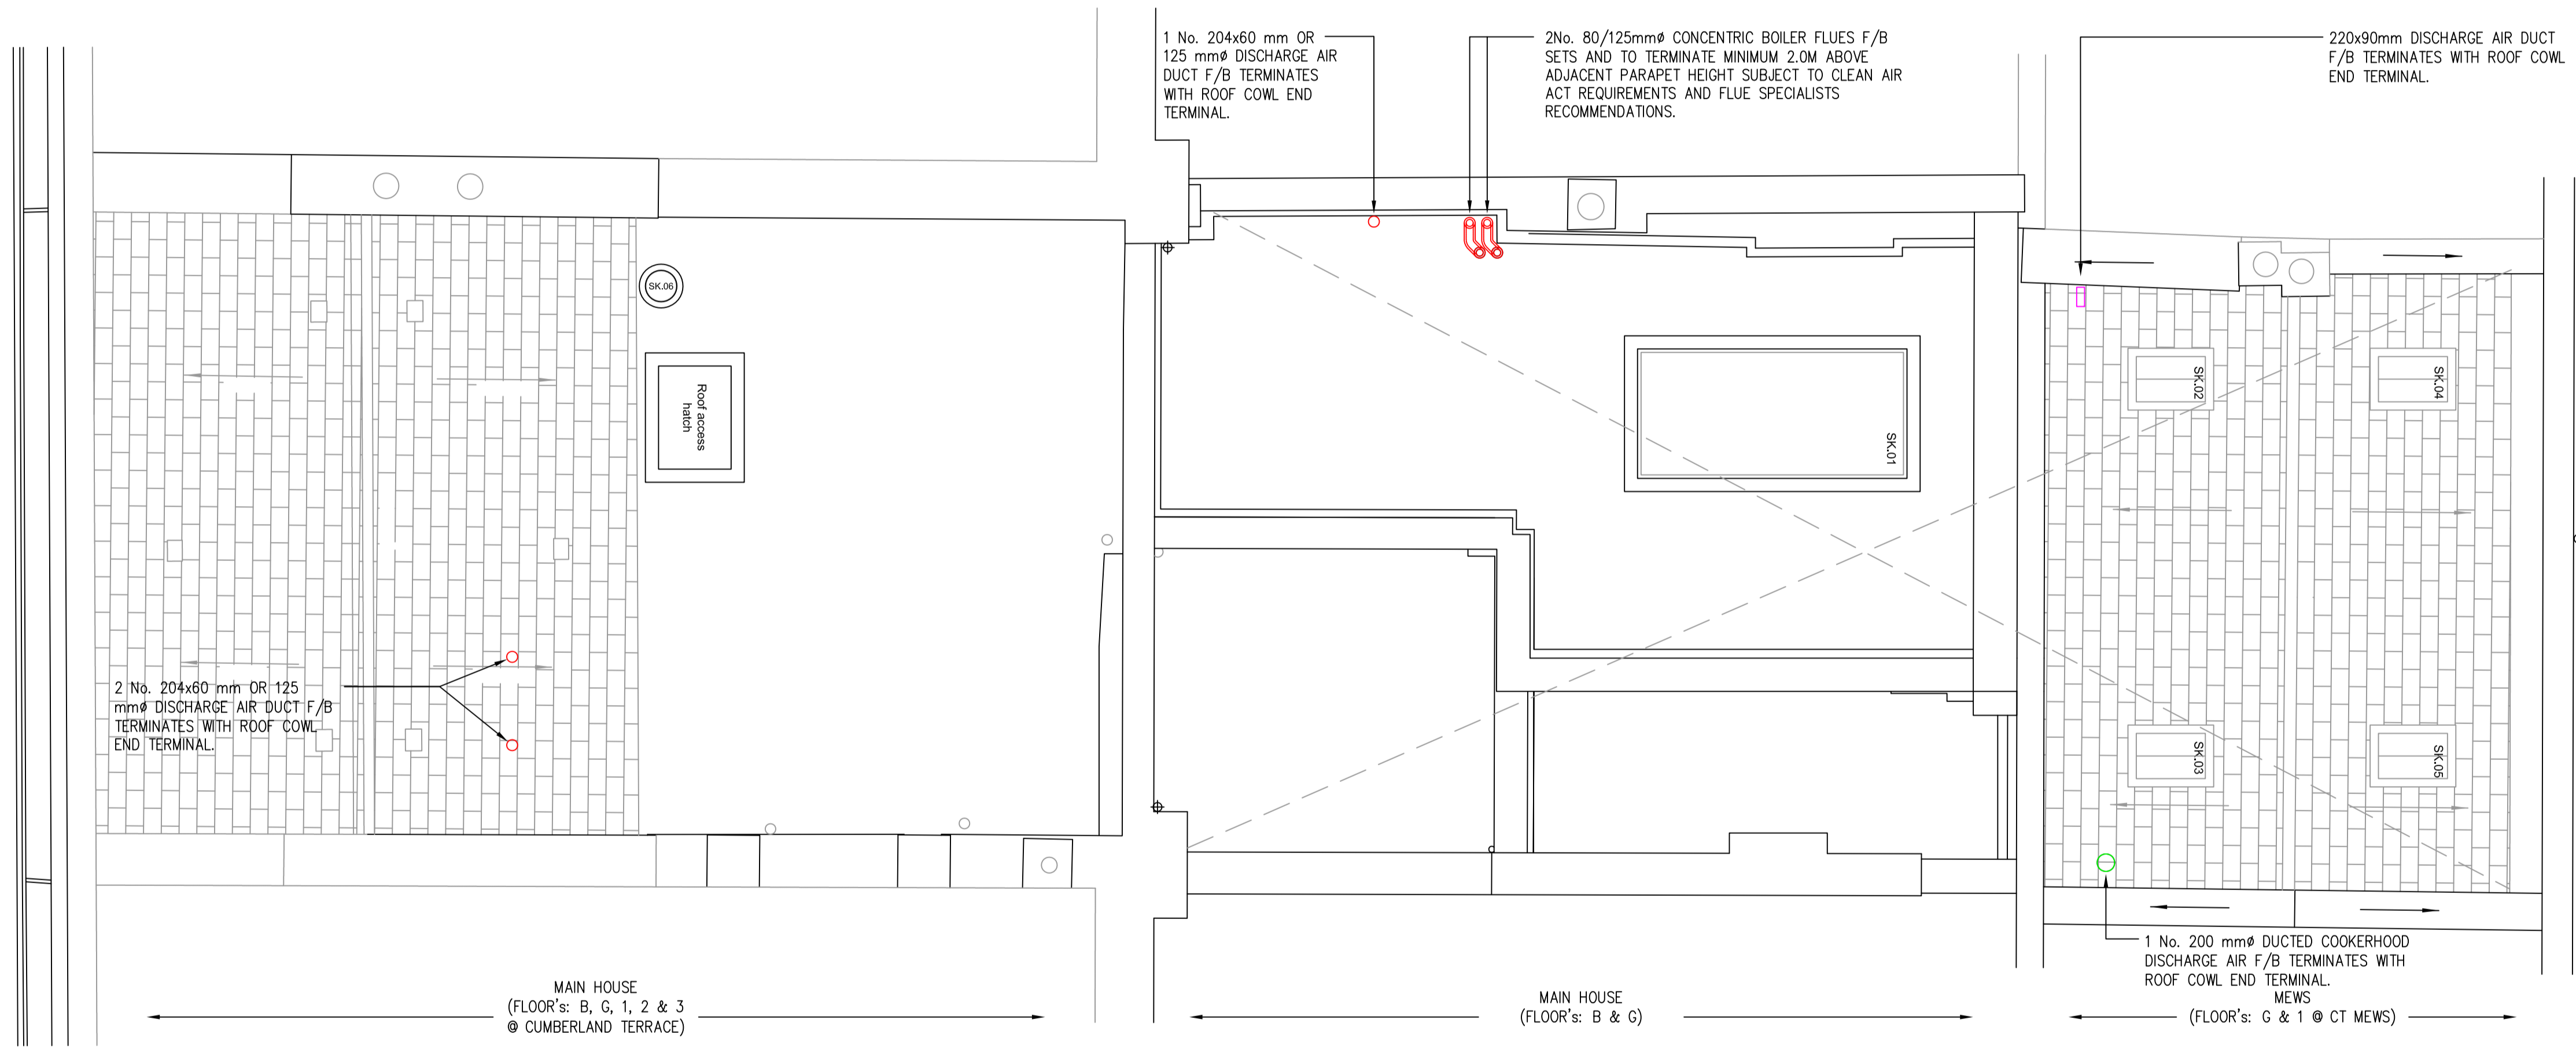

**ROOF PLAN**

# ROOF