

LISTED BUILDING
CONSENT

-	-	-	-	-
-	-	-	-	-
01	25.03.21	MGG	Planning Officer	Comments MGG
No	Date	By	Comments	Chk'd

Do not scale
All dimension to be checked on site

Job Title:
84 Heath Street
London NW3 1DN

Job Number:
JD/002/7057


Drawing Title:
LOWER GROUND FLOOR
DUCTLESS RECIRCULATING
CANOPY SYSTEM LAYOUT –
PROPOSED

Designed:	MGG	Drawn:	MGG
Scale:	1:50 @ A3	Date:	08.03.2021

García Consulting Eng Ltd

The South Quay
Building,
77 Marsh Wall
E14 9SH
Tel: +44 (0) 75 39 762838
Email: info@garcia-engineering.com
Website: www.garcia-engineering.com

Client	Drg. No.	Rev
NY	APL-105	1

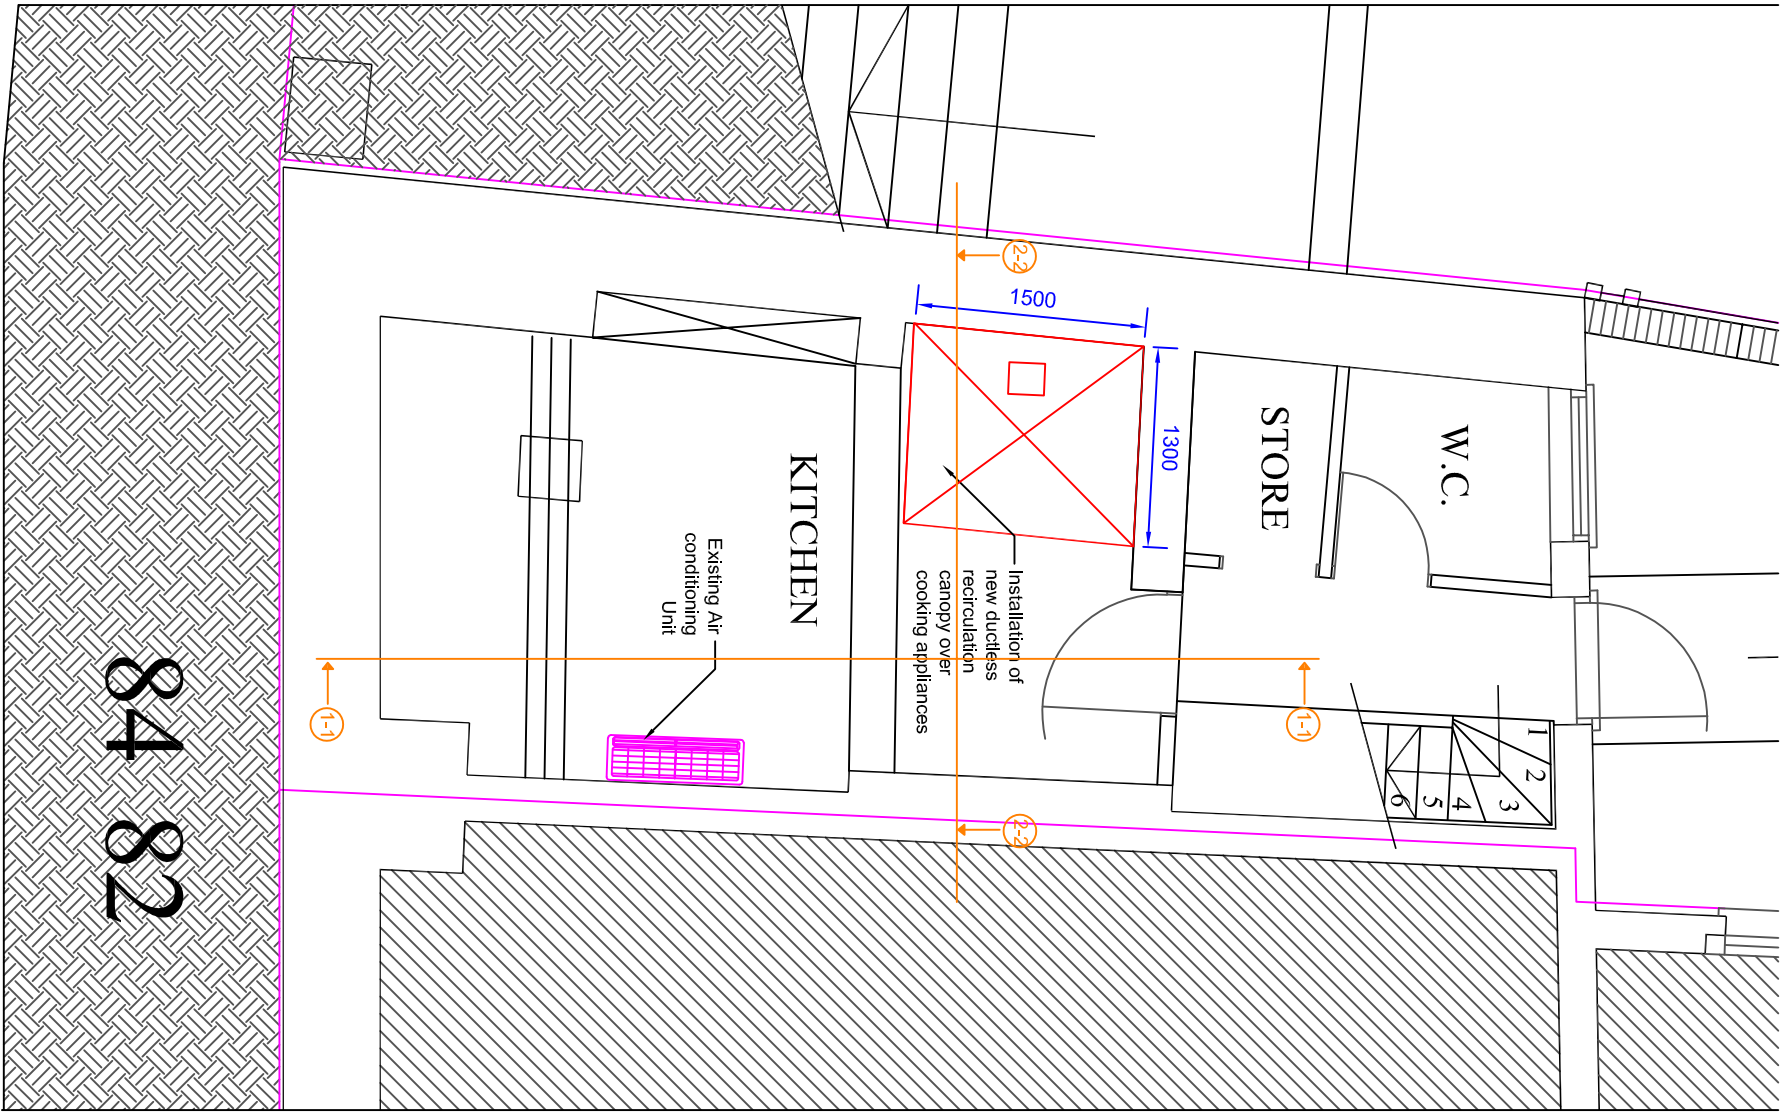

01 Lower Ground Floor Plan - Proposed

Scale 1:50

