


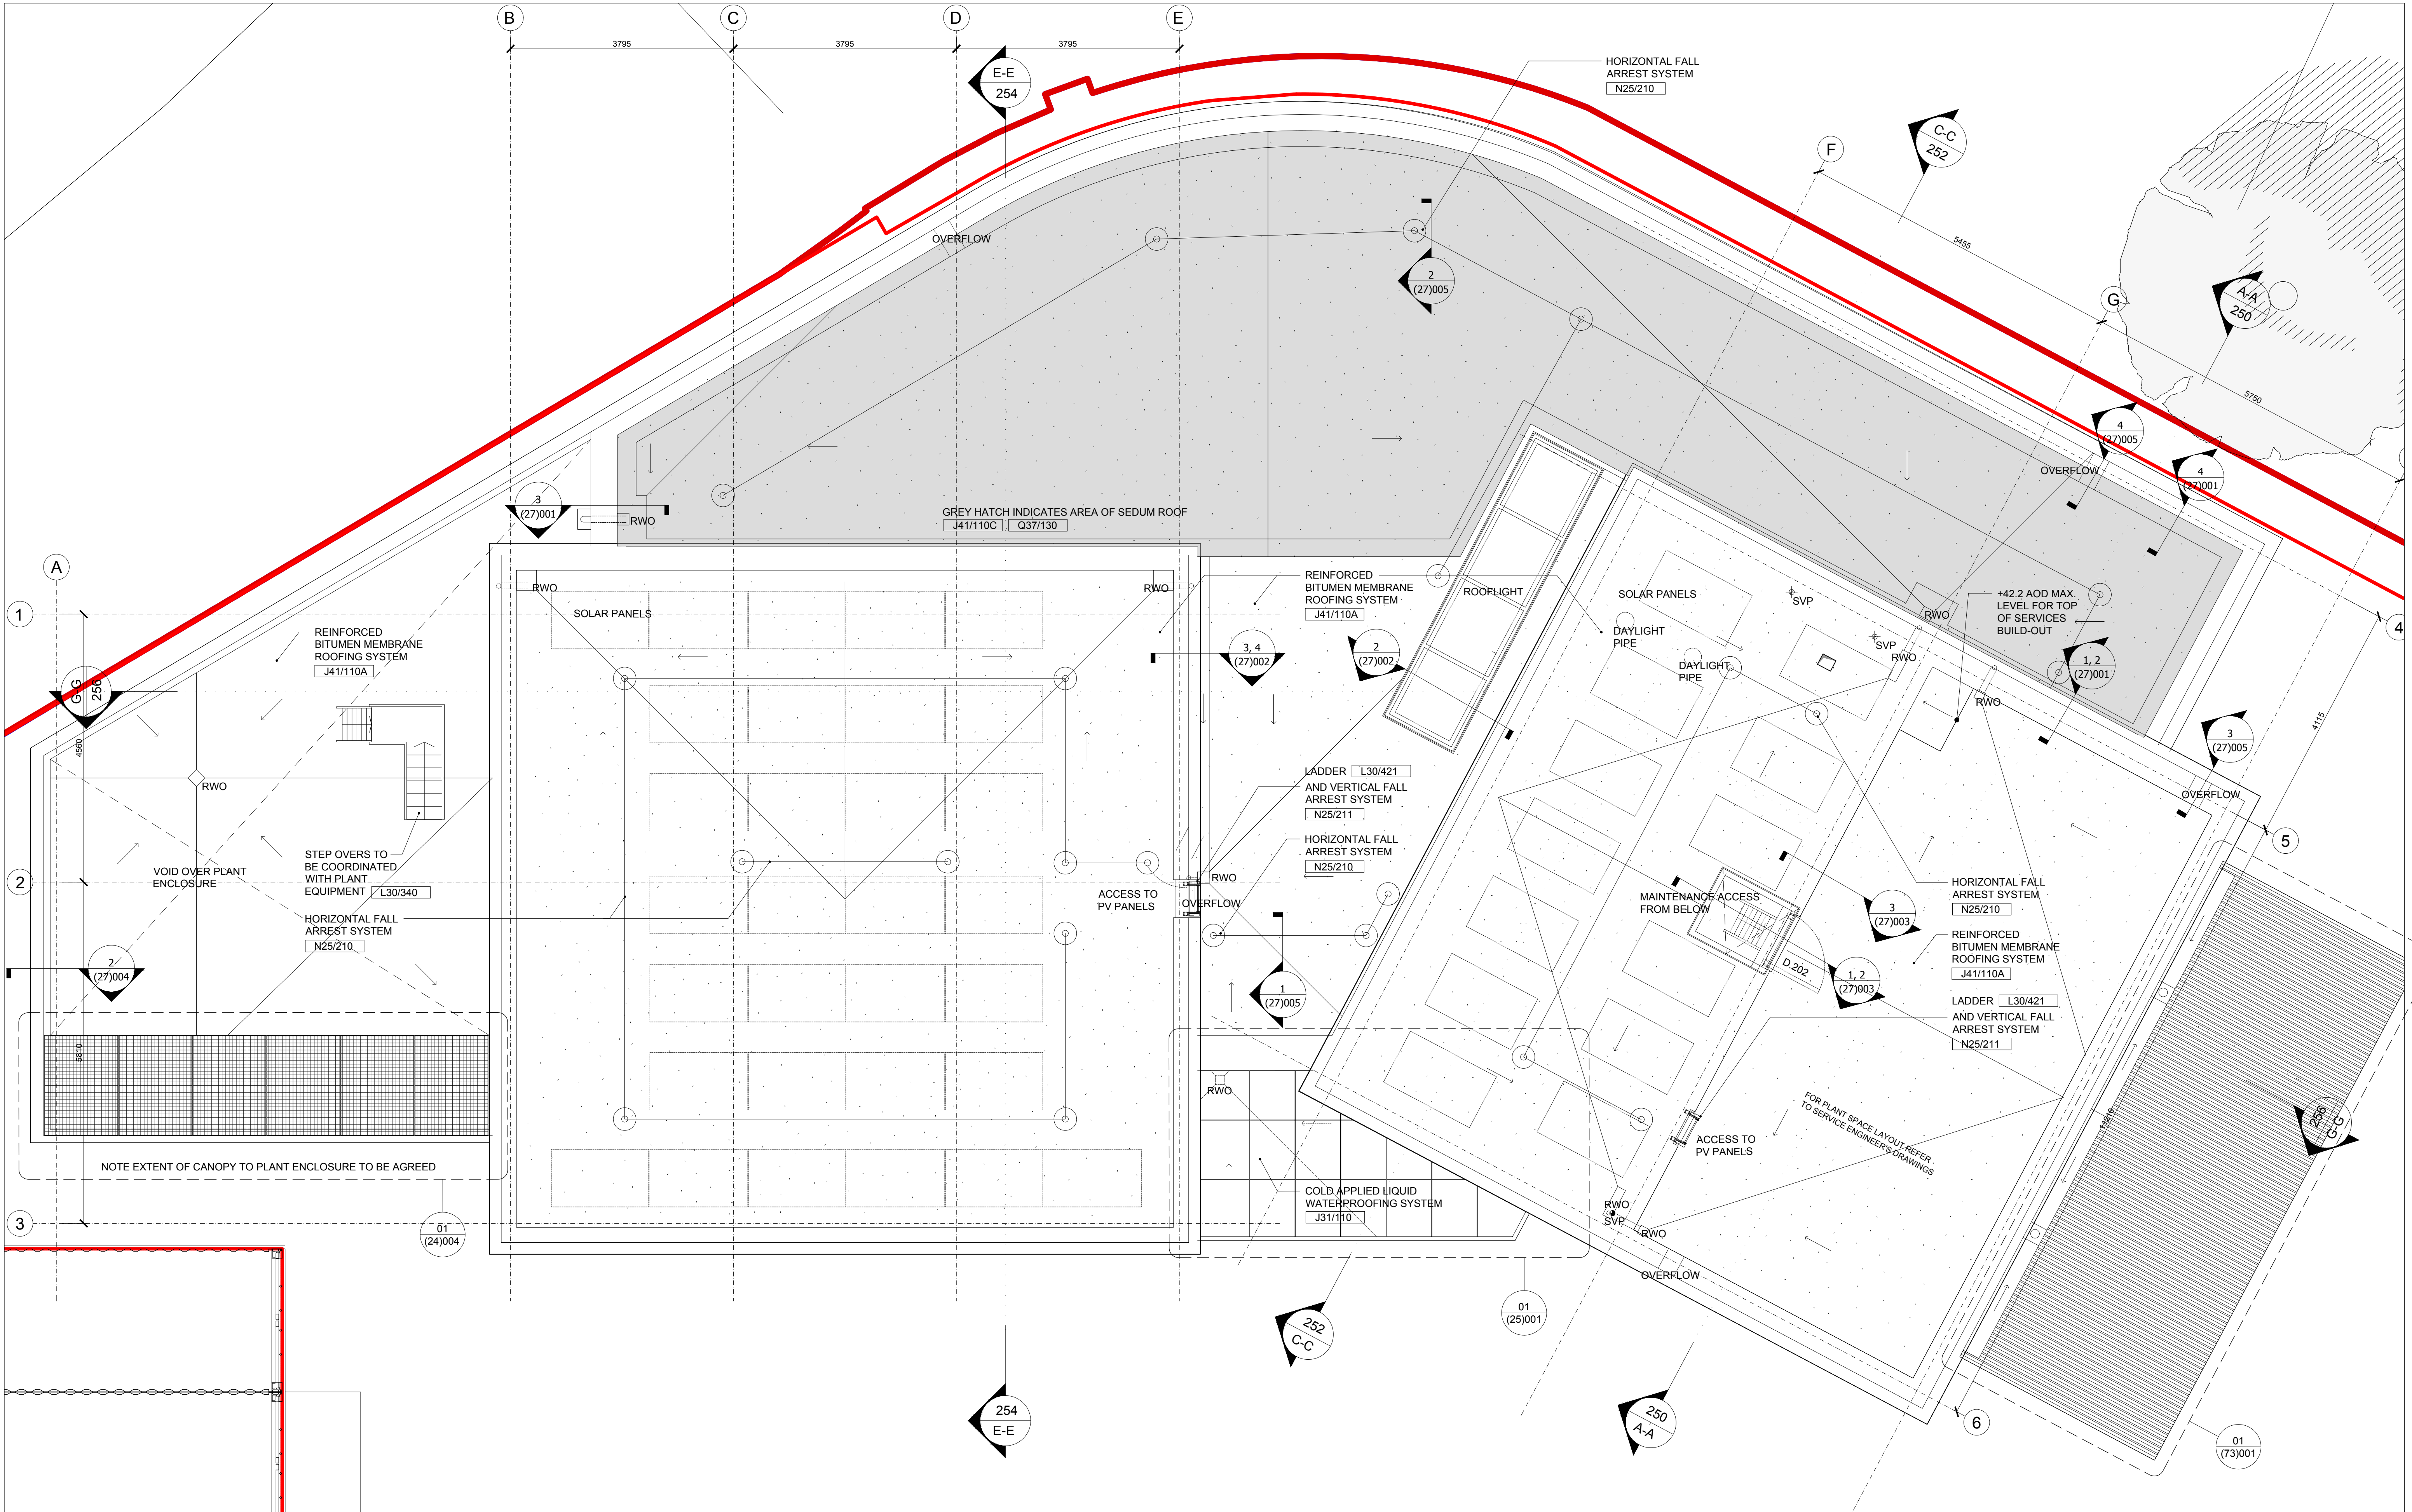

DO NOT SCALE

THE CONTRACTOR IS TO CHECK AND VERIFY ALL BUILDING AND SITE DIMENSIONS, LEVELS AND SEWER INVERT LEVELS AT CONNECTION POINTS BEFORE WORK STARTS.


THIS DRAWING IS TO BE READ AND CHECKED IN CONJUNCTION WITH ENGINEERS AND OTHER SPECIALIST DRAWINGS.

THE DRAWING AND THE WORKS DEPICTED ARE THE COPYRIGHT OF REED WATTS ARCHITECTS AND MAY NOT BE REPRODUCED EXCEPT BY WRITTEN PERMISSION.

REV	DATE	DESCRIPTION
A	23.09.19	STAGE 3 FOR COSTING
B	18.11.19	DRAFT - PRELIMINARY STAGE 4
C	23.12.19	STAGE 4 IN PROGRESS
D	20.01.20	GA LAYOUT FREEZE
E	17.02.20	STAGE 4 DRAFT FOR AI / FIRE CONSULTANT CO-ORDINATION
F	17.03.20	DRAFT TENDER ISSUE FOR CO-ORDINATION
G	17.04.20	TENDER
H	22.01.21	TENDER UPDATED

NOTES

NOT FOR CONSTRUCTION
ALL LEVELS ABOVE ORDINANCE DATUM
LIGHTNING PROTECTION SYSTEM TO BE DESIGNED AND CO-ORDINATED TO ARCHITECT'S APPROVAL.

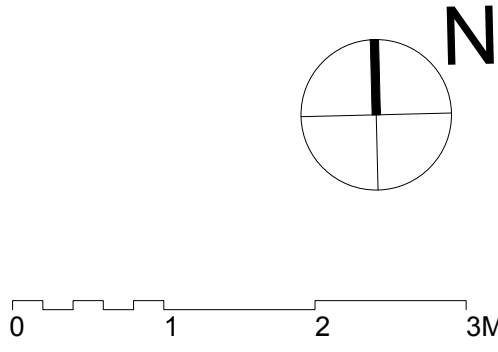

DRAWING	
PROPOSED ROOF PLAN	
DRAWING NO	REVISION
1906(0)154	H
SCALE	DATE
1:50 @ A1 1:100 @ A3	11.07.19
STATUS	
TENDER	

www.reedwatts.com
studio@reedwatts.com

**REED
WATTS**

PROJECT 1906 ROUNDHOUSE CAMPUS