


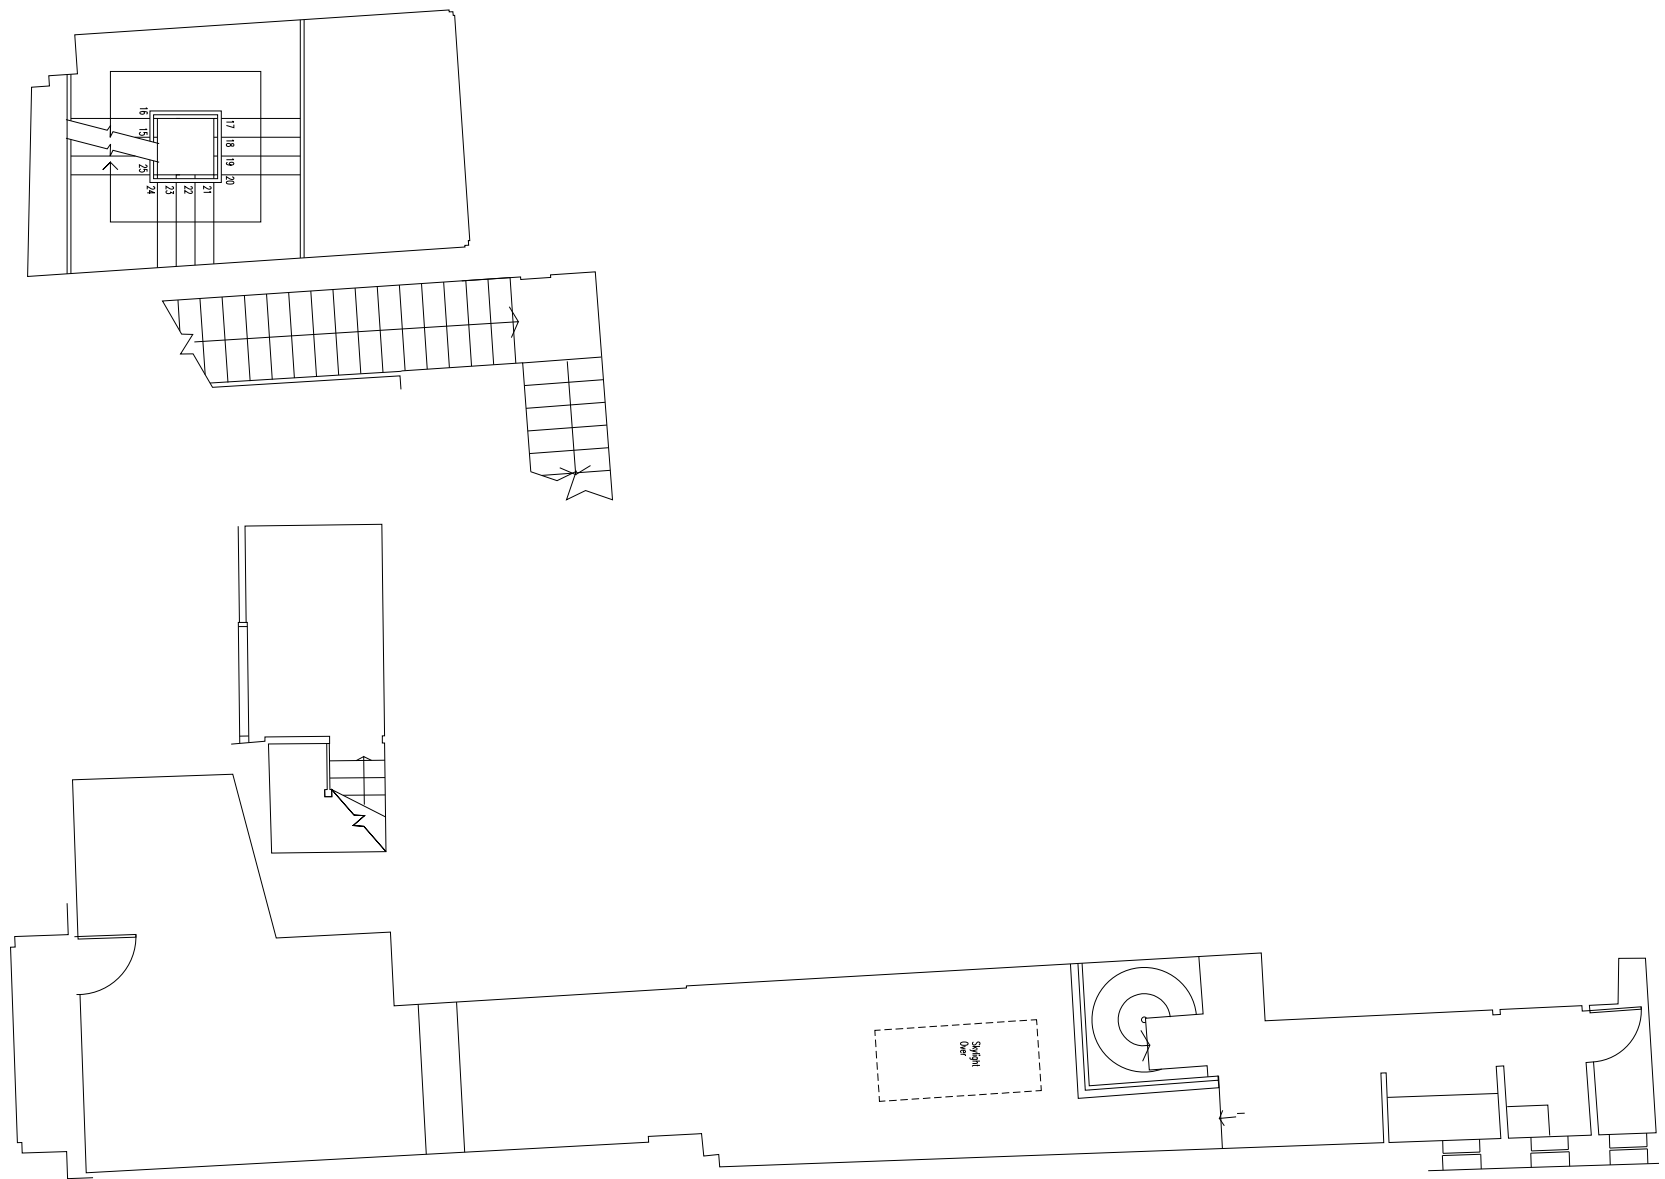


Rev	Date	Description

**Fluent**[®]
ARCHITECTURAL DESIGN SERVICES

FLUENT
ARCHITECTURAL DESIGN SERVICES
69-71 WINDMILL ROAD, SUNBURY,
MIDDLESEX, TW16 7DT
TEL: 0800 0438838
E-MAIL: INFO@FLUENT-ADS.CO.UK
WEB: FLUENT-ADS.CO.UK

31-33 High Holburn

 Proposed Ground Mezzanine
Floor Plan



Scale 1:100 @ A3	Dwg No. FLU.1427.15
Date 23.01.21	Rev
Drawn N.Millin	