


GROUND FLOOR PLAN

Fire alarm system to comply with BS 5839 Part 1
Fire alarm system to comply with BS 5839 Part 2
Fire alarm system to comply with BS 5839 Part 3
Fire alarm system to comply with BS 5839 Part 100

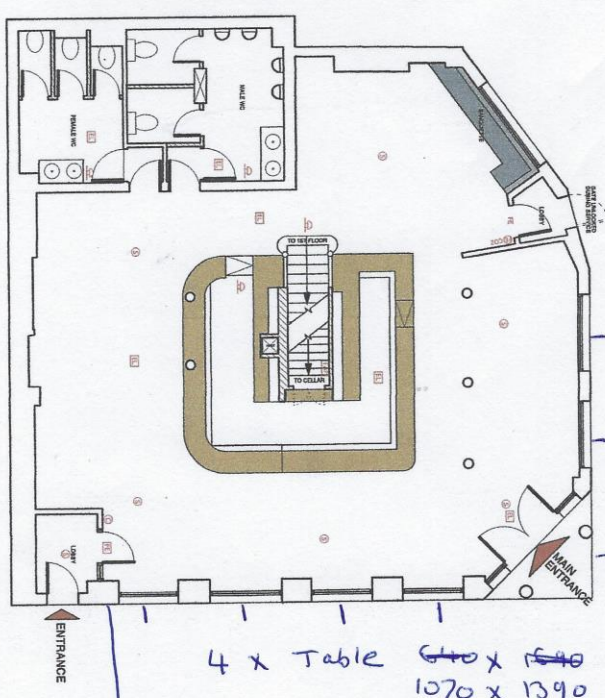

2 x Table 640 x 1640
 Gratton Road
 4.11 metres building to road
 3 metres end of table to road

4 x Table 640 x 1640
 1070 x 1390
 Prince of Wales Road
 3.5 metres building to road
 2.4 metres end of table to road

<p>NAOMI DORAN 125 GARDON GARDENS LONDON, N16 7RH 07789 708 484 RELU@INTERIORS.LONDON@GMAIL.COM</p>	<p>CLIENT PARTNERSHIP PUBS</p>	<p>DRAWING TITLE: GROUND FLOOR PLAN DRAWING REF: 0301</p>
<p>PLEASE NOTE: The works indicated on this drawing are subject to a design risk assessment which is to be re-assessed on each revision. All dimensions to be verified on site. Do not scale off this drawing. This drawing is the copyright of Naomi Doran. All copyright is reserved by her and any information contained may not be copied, reprinted or disclosed without their prior consent in writing.</p>	<p>JOB TITLE THE GRAFTON, 20 PRINCE OF WALES ROAD, LONDON, NW5 3LG</p>	<p>REV: - SCALE: 1:100 @ A3</p>