



1 EXISTING ROOF PLAN
1:100 @ A3

Air Conditioning Condenser installed tight behind chimney breast
H 734mm, W 958mm, D 820mm

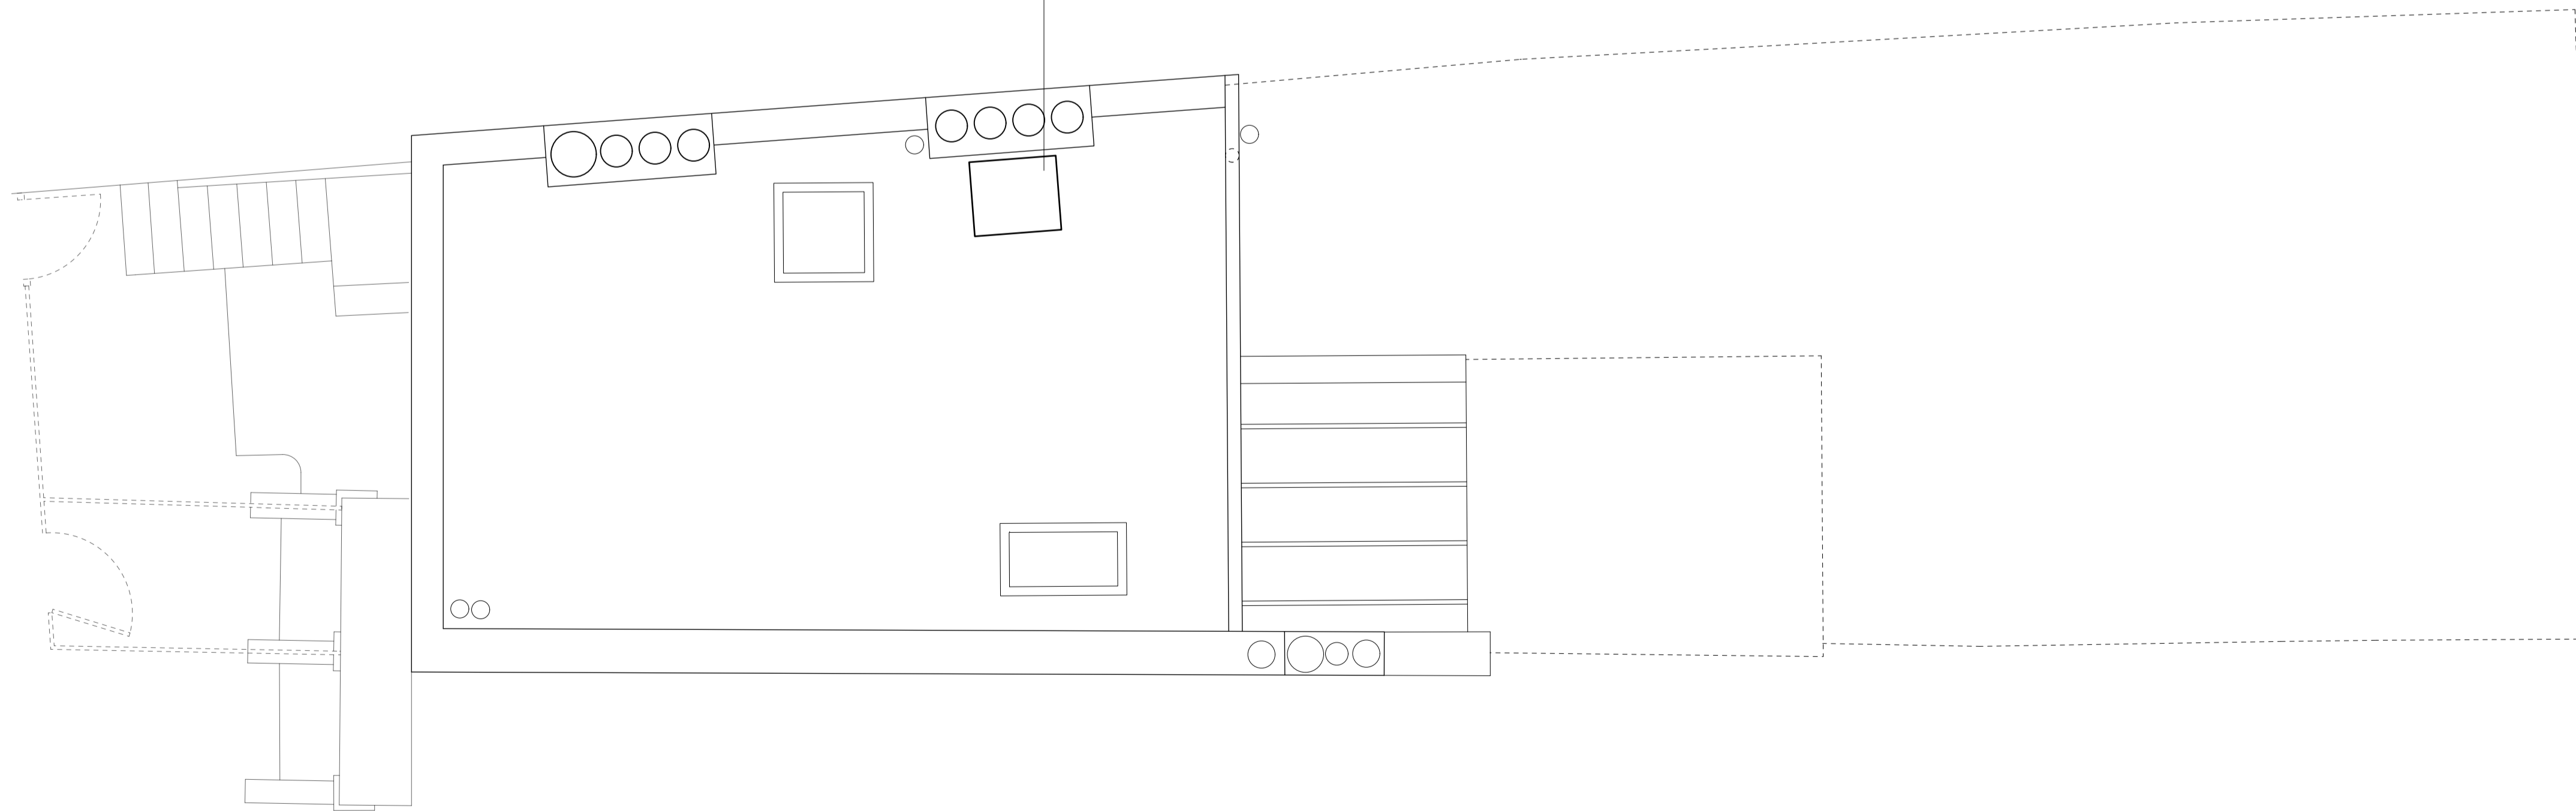

2 PROPOSED ROOF PLAN
1:100 @ A3

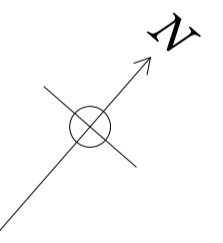

Ben Pentreath		3 Lamp Office Court Lambs Conduit Street London WC1N 3NF T+44 (0) 20 7430 2424 benpentreath.com	
PROJECT: BERKLEY ROAD		TITLE: PROPOSED & EXISTING ROOF PLANS	
DRAWING NO: A-104	REV. NO: P5.A	SCALE: 1:50 @ A1 1:100 @ A3	DRAWN BY: MH
DATE: MAY 2021	CHECKED BY: BP	All dimensions to be checked on site. All designs © Ben Pentreath Ltd 2016. Not to be reproduced without permission	