 


SITE LOCATION




Reproduced by permission of Ordnance Survey on behalf of the Controller of Her Majesty's Stationary Office  
All rights reserved. © Crown Copyright licence no. 100035093

SITE AREA PLAN




SITE PHOTOGRAPH

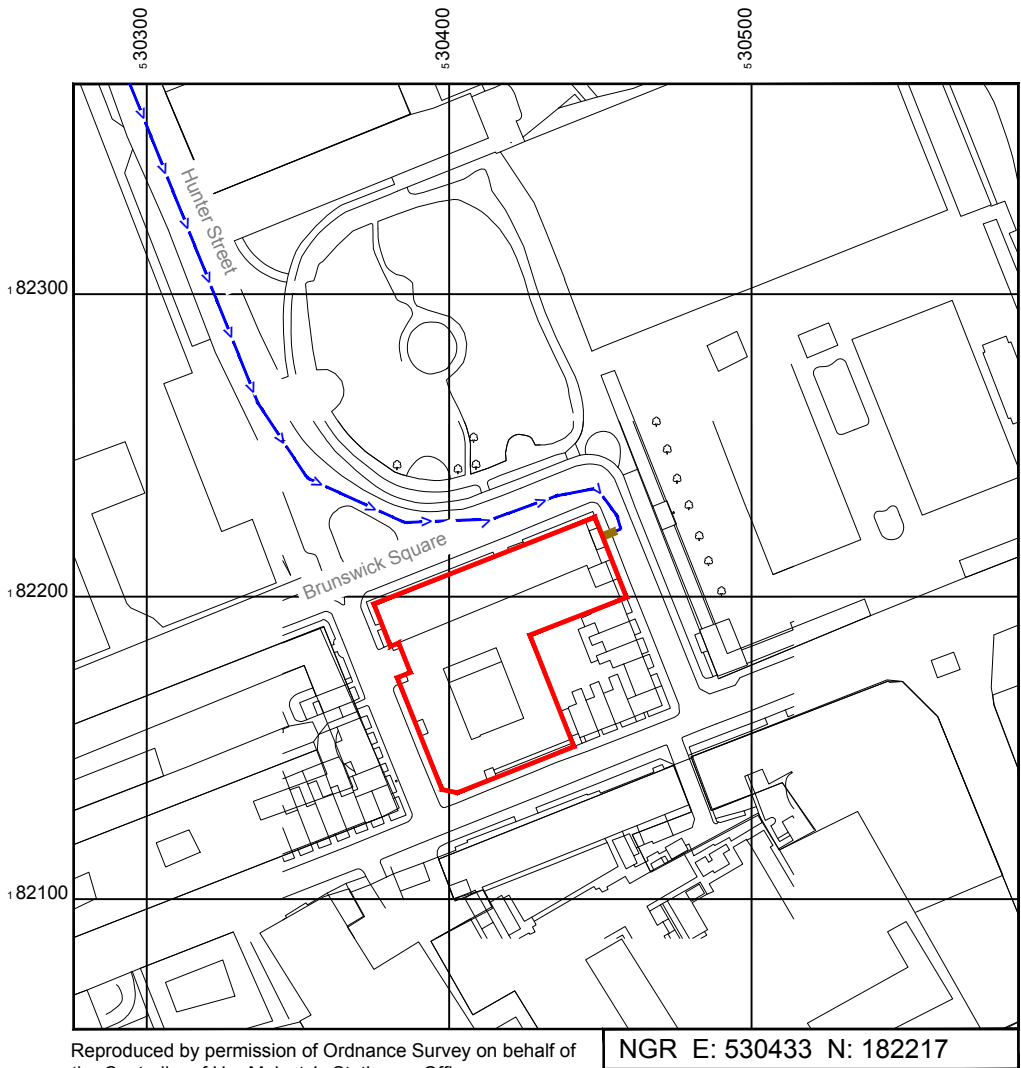

Reproduced by permission of Ordnance Survey on behalf of the Controller of Her Majesty's Stationary Office  
All rights reserved. © Crown Copyright licence no. 100035093

NGR E: 530433 N: 182217

 SITE LOCATION PLAN



GOOGLE MAPS QR CODE

GOOGLE MAPS - <https://goo.gl/maps/4anCkh4uHSurxgNR8>

GOOGLE STREETVIEW - <https://goo.gl/maps/1QHbC6RabFrNm7Lr8>

NOTES:

1. ALL DIMENSIONS IN MM UNLESS OTHERWISE NOTED.

DIRECTIONS TO SITE:  
From Euston Road turn right onto Woburn Place towards Russel Square. Turn left into Guildford Street opposite Russel Square Gardens. Take 2nd left into Grenville Street and follow into Brunswick Square.

Site Provider's  
Property Boundary:



Access Route To Site:



Access Route:



Master:	MBNL / EE / H3G:	Project:	Purpose of Issue:	Issue:
M006	MBNL	T&A Strategic	Planning	F
Date:	27/05/2021	Revision / Upgrade Description:		
Drawn:	J.Alexander	Triage/ ProX-5 Approved		
Checked:	J.Alexander			
Approved:	S.D.Gilroy			
Master:	MBNL / EE / H3G:	Project:	Purpose of Issue:	Issue:
M005	MBNL	T&A Strategic	Planning	E
Date:	14/05/2021	Revision / Upgrade Description:		
Drawn:	J.Alexander	Bearings Adjusted back to baseline bearings, triage required		
Checked:	J.Alexander			
Approved:	S.D.Gilroy			
Master:	MBNL / EE / H3G:	Project:	Purpose of Issue:	Issue:
M004	MBNL	T&A Strategic	Planning	D
Date:	28/04/2021	Revision / Upgrade Description:		
Drawn:	J.Alexander	VF antenna information added		
Checked:	J.Alexander			
Approved:	S.D.Gilroy			
Master:	MBNL / EE / H3G:	Project:	Purpose of Issue:	Issue:
M003	MBNL	T&A Strategic	Planning	C
Date:	11/03/2021	Revision / Upgrade Description:		
Drawn:	H.Cameron	Design adjusted with antennas on plantroom roof, configuration changed to H3A		
Checked:	J.Alexander			
Approved:	S.D.Gilroy			
Master:	MBNL / EE / H3G:	Project:	Purpose of Issue:	Issue:
M002	MBNL	T&A Strategic	Planning	B
Date:	27/01/21	Revision / Upgrade Description:		
Drawn:	SM	Drawing taken over by Sitec		
Checked:	J.Alexander			
Approved:	S.D.Gilroy			



Hutchison 3G UK Limited  
Star House, 20 Grenfell Road  
Maidenhead, SL6 1EH  
Tel: 01628 765 000  
Fax: 01628 765 001



Hatfield Business Park  
Hatfield  
Hertfordshire  
AL10 9BW  
Tel: 01707 315000  
Fax: 01707 319001



Mobile Broadband Network Limited  
Sixth Floor, Thames Tower, Station Road, Reading, RG1 1LX

Design Consultant & Principal Contractor:



sitec  
Infrastructure Services Ltd

Site Name:  
INTERNATIONAL HALL

Site ID:  
719816

Address:  
UNIVERSITY OF LONDON  
HALLS OF RESIDENCE  
BRUNSWICK SQUARE CAMDEN  
LONDON  
WC1N 1AX

Title:  
002 SITE LOCATION PLAN


Project:  
T&A STRATEGIC

Purpose of Issue:  
PLANNING

EE Cell ID: 98466	MBNL Cell ID: CMN038	3UK Cell ID: WC0034
----------------------	-------------------------	------------------------

Master Drawing No: 719816_CMN038_98466_WC0034_M006	Issue: F
---	-------------



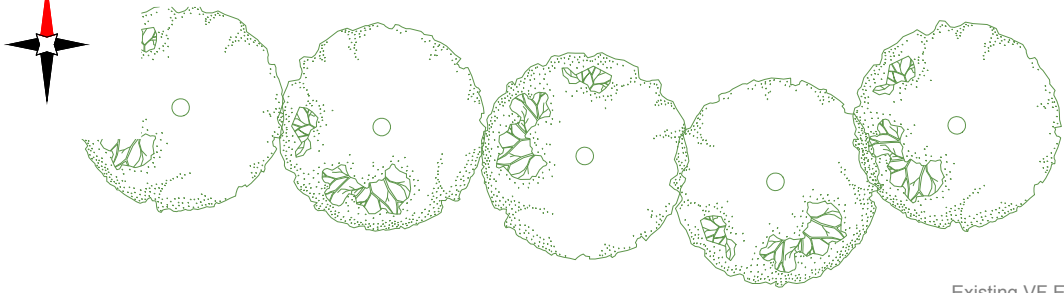

Brunswick Square

ELEVATION A



Existing VF Equipment Cabin mounted on steel grillage spanning between rooftop plinths

Existing shared AQU4518R0 antenna mounted on climbable pole on wall mounted steelwork

Existing EE 1No. BOB mounted on existing steelwork

Existing Rooftop Access Door onto walkway. Safe walking zone fully handrailed around rooftop

Existing shared cable management running through plantroom

Existing boarded walkway around rooftop

Existing VF cable tray mounted on rooftop

Existing 300mm wide cable tray running on roof then up plantroom wall

Existing wall mounted flag pole

Existing 1.1m high Freestanding Handrailing

Existing 3No. VF Antennas on wall mounted single poles @ 330°, 21.31m height on antenna top with G900, UI2100, L800, L2600, GU09, U09 & U21 technologies

Roof Level +19.0m AGL

Roof Level +16.5m AGL

Roof Level +20.0m AGL

Roof Level +16.5m AGL

Existing Flue

Existing 3No. VF Antennas on wall mounted single poles @ 140°, 21.31m height on antenna top with G900, UI2100, L800, L2600, GU09, U09 & U21 technologies

Existing EE 1No. BOB & 1No. RRU mounted on handrail

Existing shared AQU4518R0 antenna mounted on climbable pole on wall mounted steelwork

Existing hooped access ladder

Glass Atrium roof

Ground Level Datum +0.0m AGL

 


100mm

50mm

10mm

EXISTING SITE PLAN



3G / 4G Antenna ID	Existing 3G Bearing
A1	0°
B1	120°
C1	240°

NOTES:

1. ALL DIMENSIONS IN MM UNLESS OTHERWISE NOTED.

Master:	MBNL / EE / H3G:	Project:	T&A Strategic	Purpose of Issue:	Planning	Issue:	F
M006	MBNL	Revision / Upgrade Description: Triage/ ProX-5 Approved					
Date:	27/05/2021						
Drawn:	J.Alexander						
Checked:	J.Alexander						
Approved:	S.D.Gilroy						
Master:	MBNL / EE / H3G:	Project:	T&A Strategic	Purpose of Issue:	Planning	Issue:	E
M005	MBNL	Revision / Upgrade Description: Bearings Adjusted back to baseline bearings, triage required					
Date:	14/05/2021						
Drawn:	J.Alexander						
Checked:	J.Alexander						
Approved:	S.D.Gilroy						
Master:	MBNL / EE / H3G:	Project:	T&A Strategic	Purpose of Issue:	Planning	Issue:	D
M004	MBNL	Revision / Upgrade Description: VF antenna information added					
Date:	28/04/2021						
Drawn:	J.Alexander						
Checked:	J.Alexander						
Approved:	S.D.Gilroy						
Master:	MBNL / EE / H3G:	Project:	T&A Strategic	Purpose of Issue:	Planning	Issue:	C
M003	MBNL	Revision / Upgrade Description: Design adjusted with antennas on plantroom roof, configuration changed to H3A					
Date:	11/03/2021						
Drawn:	H.Cameron						
Checked:	J.Alexander						
Approved:	S.D.Gilroy						
Master:	MBNL / EE / H3G:	Project:	T&A Strategic	Purpose of Issue:	Planning	Issue:	B
M002	MBNL	Revision / Upgrade Description: Drawing taken over by Sitec					
Date:	27/01/21						
Drawn:	SM						
Checked:	J.Alexander						
Approved:	S.D.Gilroy						



Hutchison 3G UK Limited  
Star House, 20 Grenfell Road  
Maidenhead, SL6 1EH  
Tel: 01628 765 000  
Fax: 01628 765 001



Hatfield Business Park  
Hatfield  
Hertfordshire  
AL10 9BW  
Tel: 01707 315000  
Fax: 01707 319001



Mobile Broadband Network Limited  
Sixth Floor, Thames Tower, Station Road, Reading, RG1 1LX

Design Consultant & Principal Contractor:



sitec  
Infrastructure Services Ltd

Site Name:  
INTERNATIONAL HALL

Site ID:  
719816

Address:  
UNIVERSITY OF LONDON  
HALLS OF RESIDENCE  
BRUNSWICK SQUARE CAMDEN  
LONDON  
WC1N 1AX

Title:  
100 EXISTING SITE PLAN

Project:  
T&A STRATEGIC

Purpose of Issue:  
PLANNING


EE Cell ID: 98466	MBNL Cell ID: CMN038	3UK Cell ID: WC0034
----------------------	-------------------------	------------------------

Master Drawing No: 719816_CMN038_98466_WC0034_M006	Issue: F
---	-------------


100mm

50mm

10mm

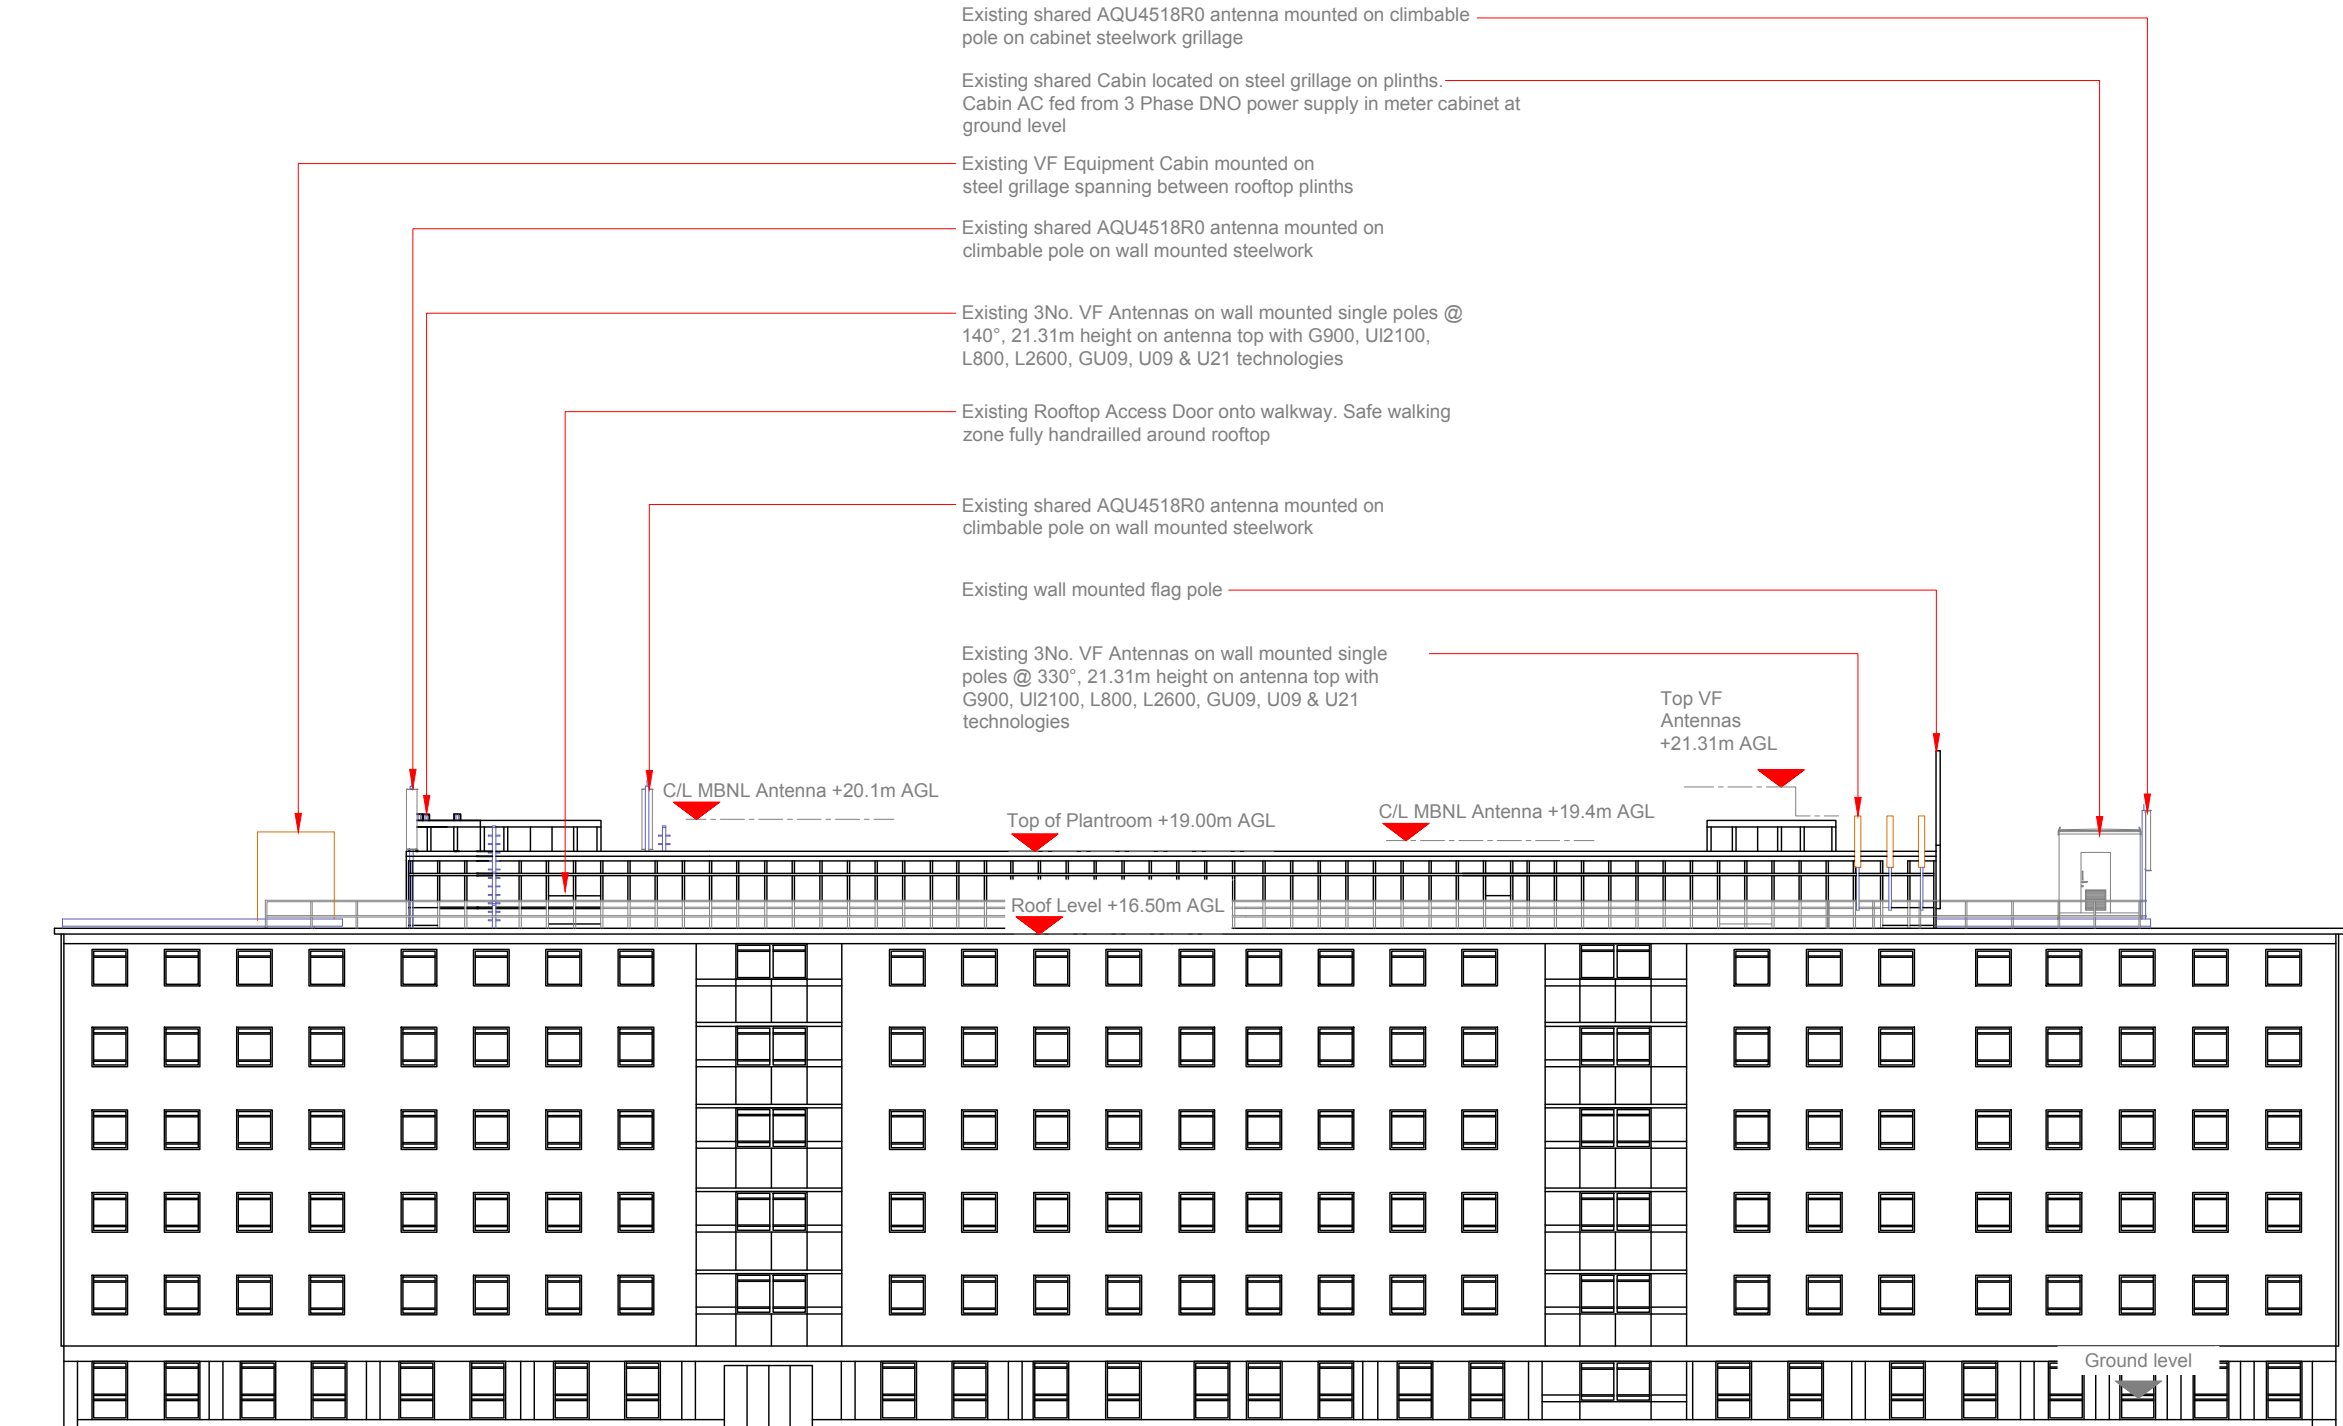

EXISTING ELEVATION A

 

3G / 4G Antenna ID	Existing 3G Bearing
A1	0°
B1	120°
C1	240°

NOTES:  
1. ALL DIMENSIONS IN MM UNLESS OTHERWISE NOTED.

Master:	MBNL / EE / H3G:	Project:	Purpose of Issue:	Issue:
M006	MBNL	T&A Strategic	Planning	F
Date:	27/05/2021	Revision / Upgrade Description: Triage/ ProX-5 Approved		
Drawn:	J.Alexander			
Checked:	J.Alexander			
Approved:	S.D.Gilroy			
Master:	MBNL / EE / H3G:	Project:	Purpose of Issue:	Issue:
M005	MBNL	T&A Strategic	Planning	E
Date:	14/05/2021	Revision / Upgrade Description: Bearings Adjusted back to baseline bearings, triage required		
Drawn:	J.Alexander			
Checked:	J.Alexander			
Approved:	S.D.Gilroy			
Master:	MBNL / EE / H3G:	Project:	Purpose of Issue:	Issue:
M004	MBNL	T&A Strategic	Planning	D
Date:	28/04/2021	Revision / Upgrade Description: VF antenna information added		
Drawn:	J.Alexander			
Checked:	J.Alexander			
Approved:	S.D.Gilroy			
Master:	MBNL / EE / H3G:	Project:	Purpose of Issue:	Issue:
M003	MBNL	T&A Strategic	Planning	C
Date:	11/03/2021	Revision / Upgrade Description: Design adjusted with antennas on plantroom roof, configuration changed to H3A		
Drawn:	H.Cameron			
Checked:	J.Alexander			
Approved:	S.D.Gilroy			
Master:	MBNL / EE / H3G:	Project:	Purpose of Issue:	Issue:
M002	MBNL	T&A Strategic	Planning	B
Date:	27/01/21	Revision / Upgrade Description: Drawing taken over by Sitec		
Drawn:	SM			
Checked:	J.Alexander			
Approved:	S.D.Gilroy			



Hutchison 3G UK Limited  
Star House, 20 Grenfell Road  
Maidenhead, SL6 1EH  
Tel: 01628 765 000  
Fax: 01628 765 001  
H3G Base Station Information line:  
0845 6043000  
Available 8am-8pm Monday to Friday



Hatfield Business Park  
Hatfield  
Hertfordshire  
AL10 9BW  
Tel: 01707 315000  
Fax: 01707 319001



Mobile Broadband Network Limited  
Sixth Floor, Thames Tower, Station Road, Reading, RG1 1LX

Design Consultant & Principal Contractor:



Site Name:  
INTERNATIONAL HALL

Site ID:  
719816

Address:  
UNIVERSITY OF LONDON  
HALLS OF RESIDENCE  
BRUNSWICK SQUARE CAMDEN  
LONDON  
WC1N 1AX


Title:  
150 EXISTING ELEVATION A

Project:  
T&A STRATEGIC

Purpose of Issue:  
PLANNING

EE Cell ID: 98466	MBNL Cell ID: CMN038	3UK Cell ID: WC0034
----------------------	-------------------------	------------------------

Master Drawing No: 719816_CMN038_98466_WC0034_M006	Issue: F
---	-------------

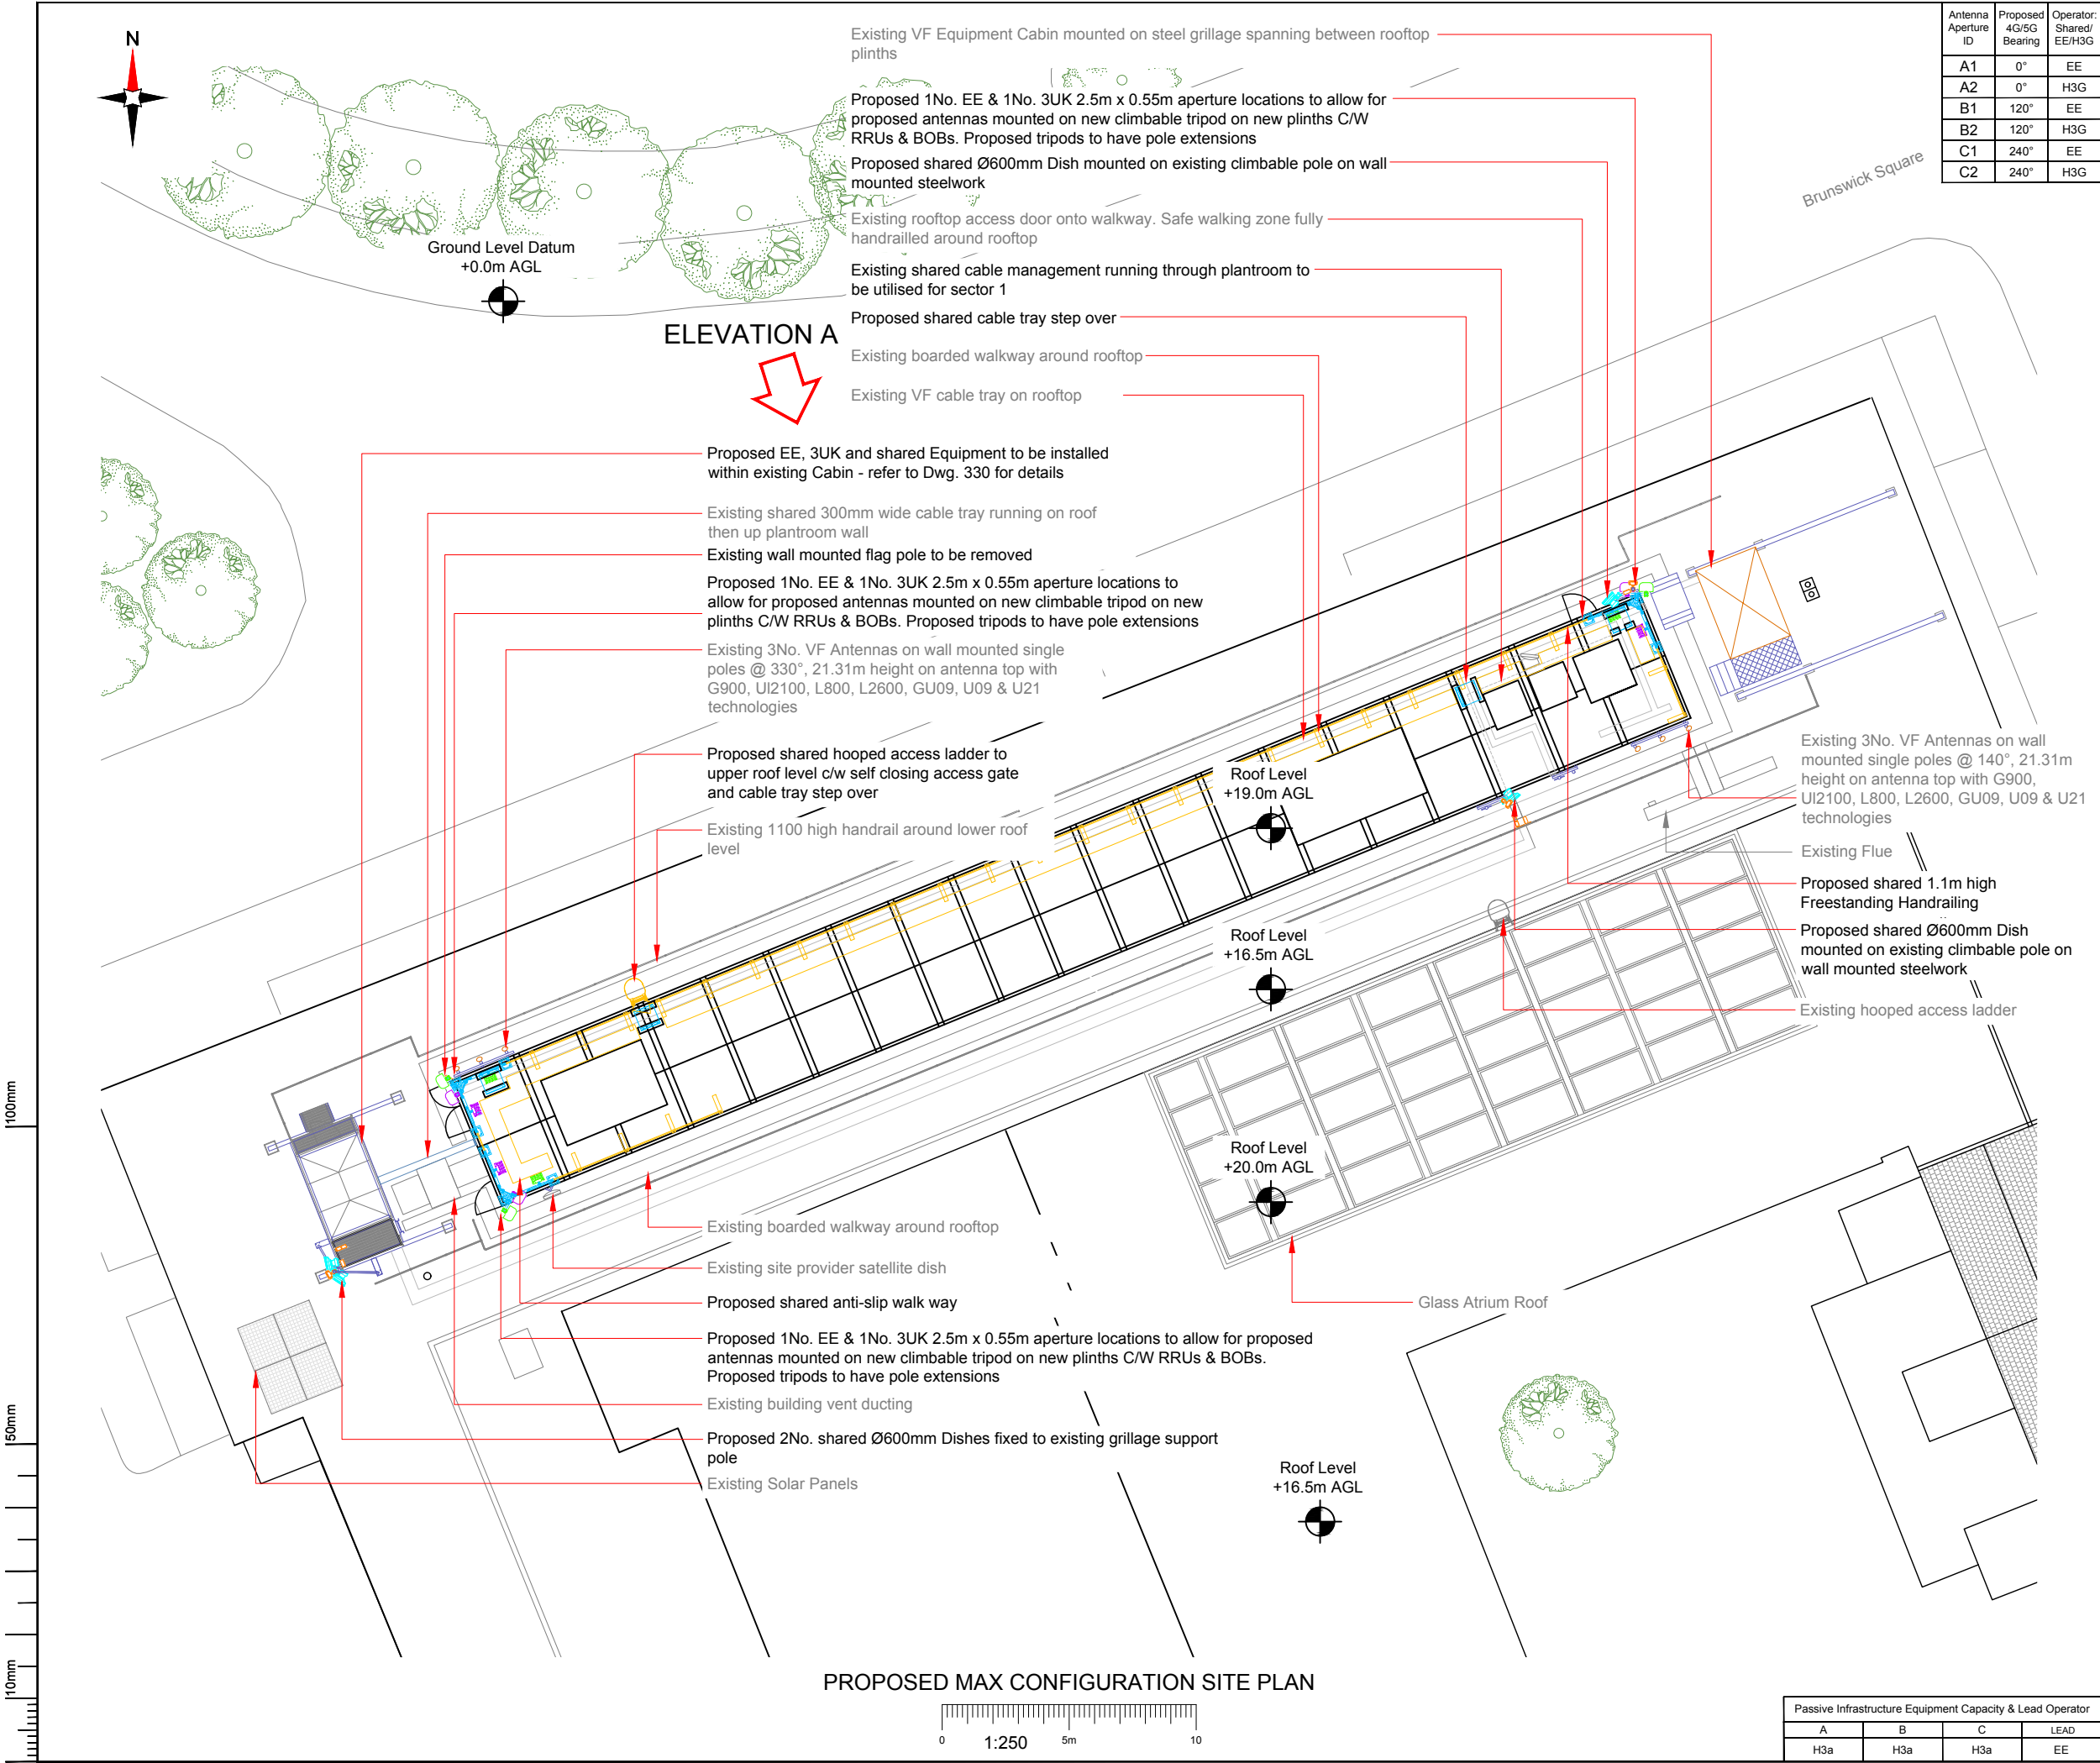

Antenna Aperture ID	Proposed 4G/5G Bearing	Operator: Shared/ EE/H3G
A1	0°	EE
A2	0°	H3G
B1	120°	EE
B2	120°	H3G
C1	240°	EE
C2	240°	H3G

NOTES:

1. ALL DIMENSIONS IN MM UNLESS OTHERWISE NOTED.

Master: M006	MBNL / EE / H3G	Project: T&A Strategic	Purpose of Issue: Planning	Issue: F
Date: 27/05/2021	Revision / Upgrade Description: Triage/ ProX-5 Approved			
Drawn: J.Alexander				
Checked: J.Alexander				
Approved: S.D.Gilroy				
Master: M005	MBNL	Project: T&A Strategic	Purpose of Issue: Planning	Issue: E
Date: 14/05/2021	Revision / Upgrade Description: Bearings Adjusted back to baseline bearings, triage required			
Drawn: J.Alexander				
Checked: J.Alexander				
Approved: S.D.Gilroy				
Master: M004	MBNL	Project: T&A Strategic	Purpose of Issue: Planning	Issue: D
Date: 28/04/2021	Revision / Upgrade Description: VF antenna information added			
Drawn: J.Alexander				
Checked: J.Alexander				
Approved: S.D.Gilroy				
Master: M003	MBNL	Project: T&A Strategic	Purpose of Issue: Planning	Issue: C
Date: 11/03/2021	Revision / Upgrade Description: Design adjusted with antennas on plantroom roof, configuration changed to H3A			
Drawn: H.Cameron				
Checked: J.Alexander				
Approved: S.D.Gilroy				
Master: M002	MBNL	Project: T&A Strategic	Purpose of Issue: Planning	Issue: B
Date: 27/01/21	Revision / Upgrade Description: Drawing taken over by Sitec			
Drawn: SM				
Checked: J.Alexander				
Approved: S.D.Gilroy				

Hutchison 3G UK Limited  
Star House, 20 Grenfell Road  
Maidenhead, SL6 1EH  
Tel: 01628 765 500  
Fax: 01628 765 501

H3G Base Station Information line:  
0845 6043000  
Available from 9pm Monday to Friday

Hatfield Business Park  
Hatfield  
Hertfordshire  
AL10 9BW

Tel: 01707 315000  
Fax: 01707 319001

Design Consultant & Principal Contractor:

Site Name: INTERNATIONAL HALL

Site ID: 719816

Address: UNIVERSITY OF LONDON  
HALLS OF RESIDENCE  
BRUNSWICK SQUARE CAMDEN  
LONDON  
WC1N 1AX

Title: 215 MAX CONFIGURATION SITE PLAN

Project: T&A STRATEGIC

Purpose of Issue: PLANNING

EE Cell ID: 98466	MBNL Cell ID: CMN038	3UK Cell ID: WC0034
-------------------	----------------------	---------------------

Master Drawing No: 719816\_CMN038\_98466\_WC0034\_M006

Issue: F


Passive Infrastructure Equipment Capacity & Lead Operator			
A	B	C	LEAD
H3a	H3a	H3a	EE




100mm

50mm

10mm

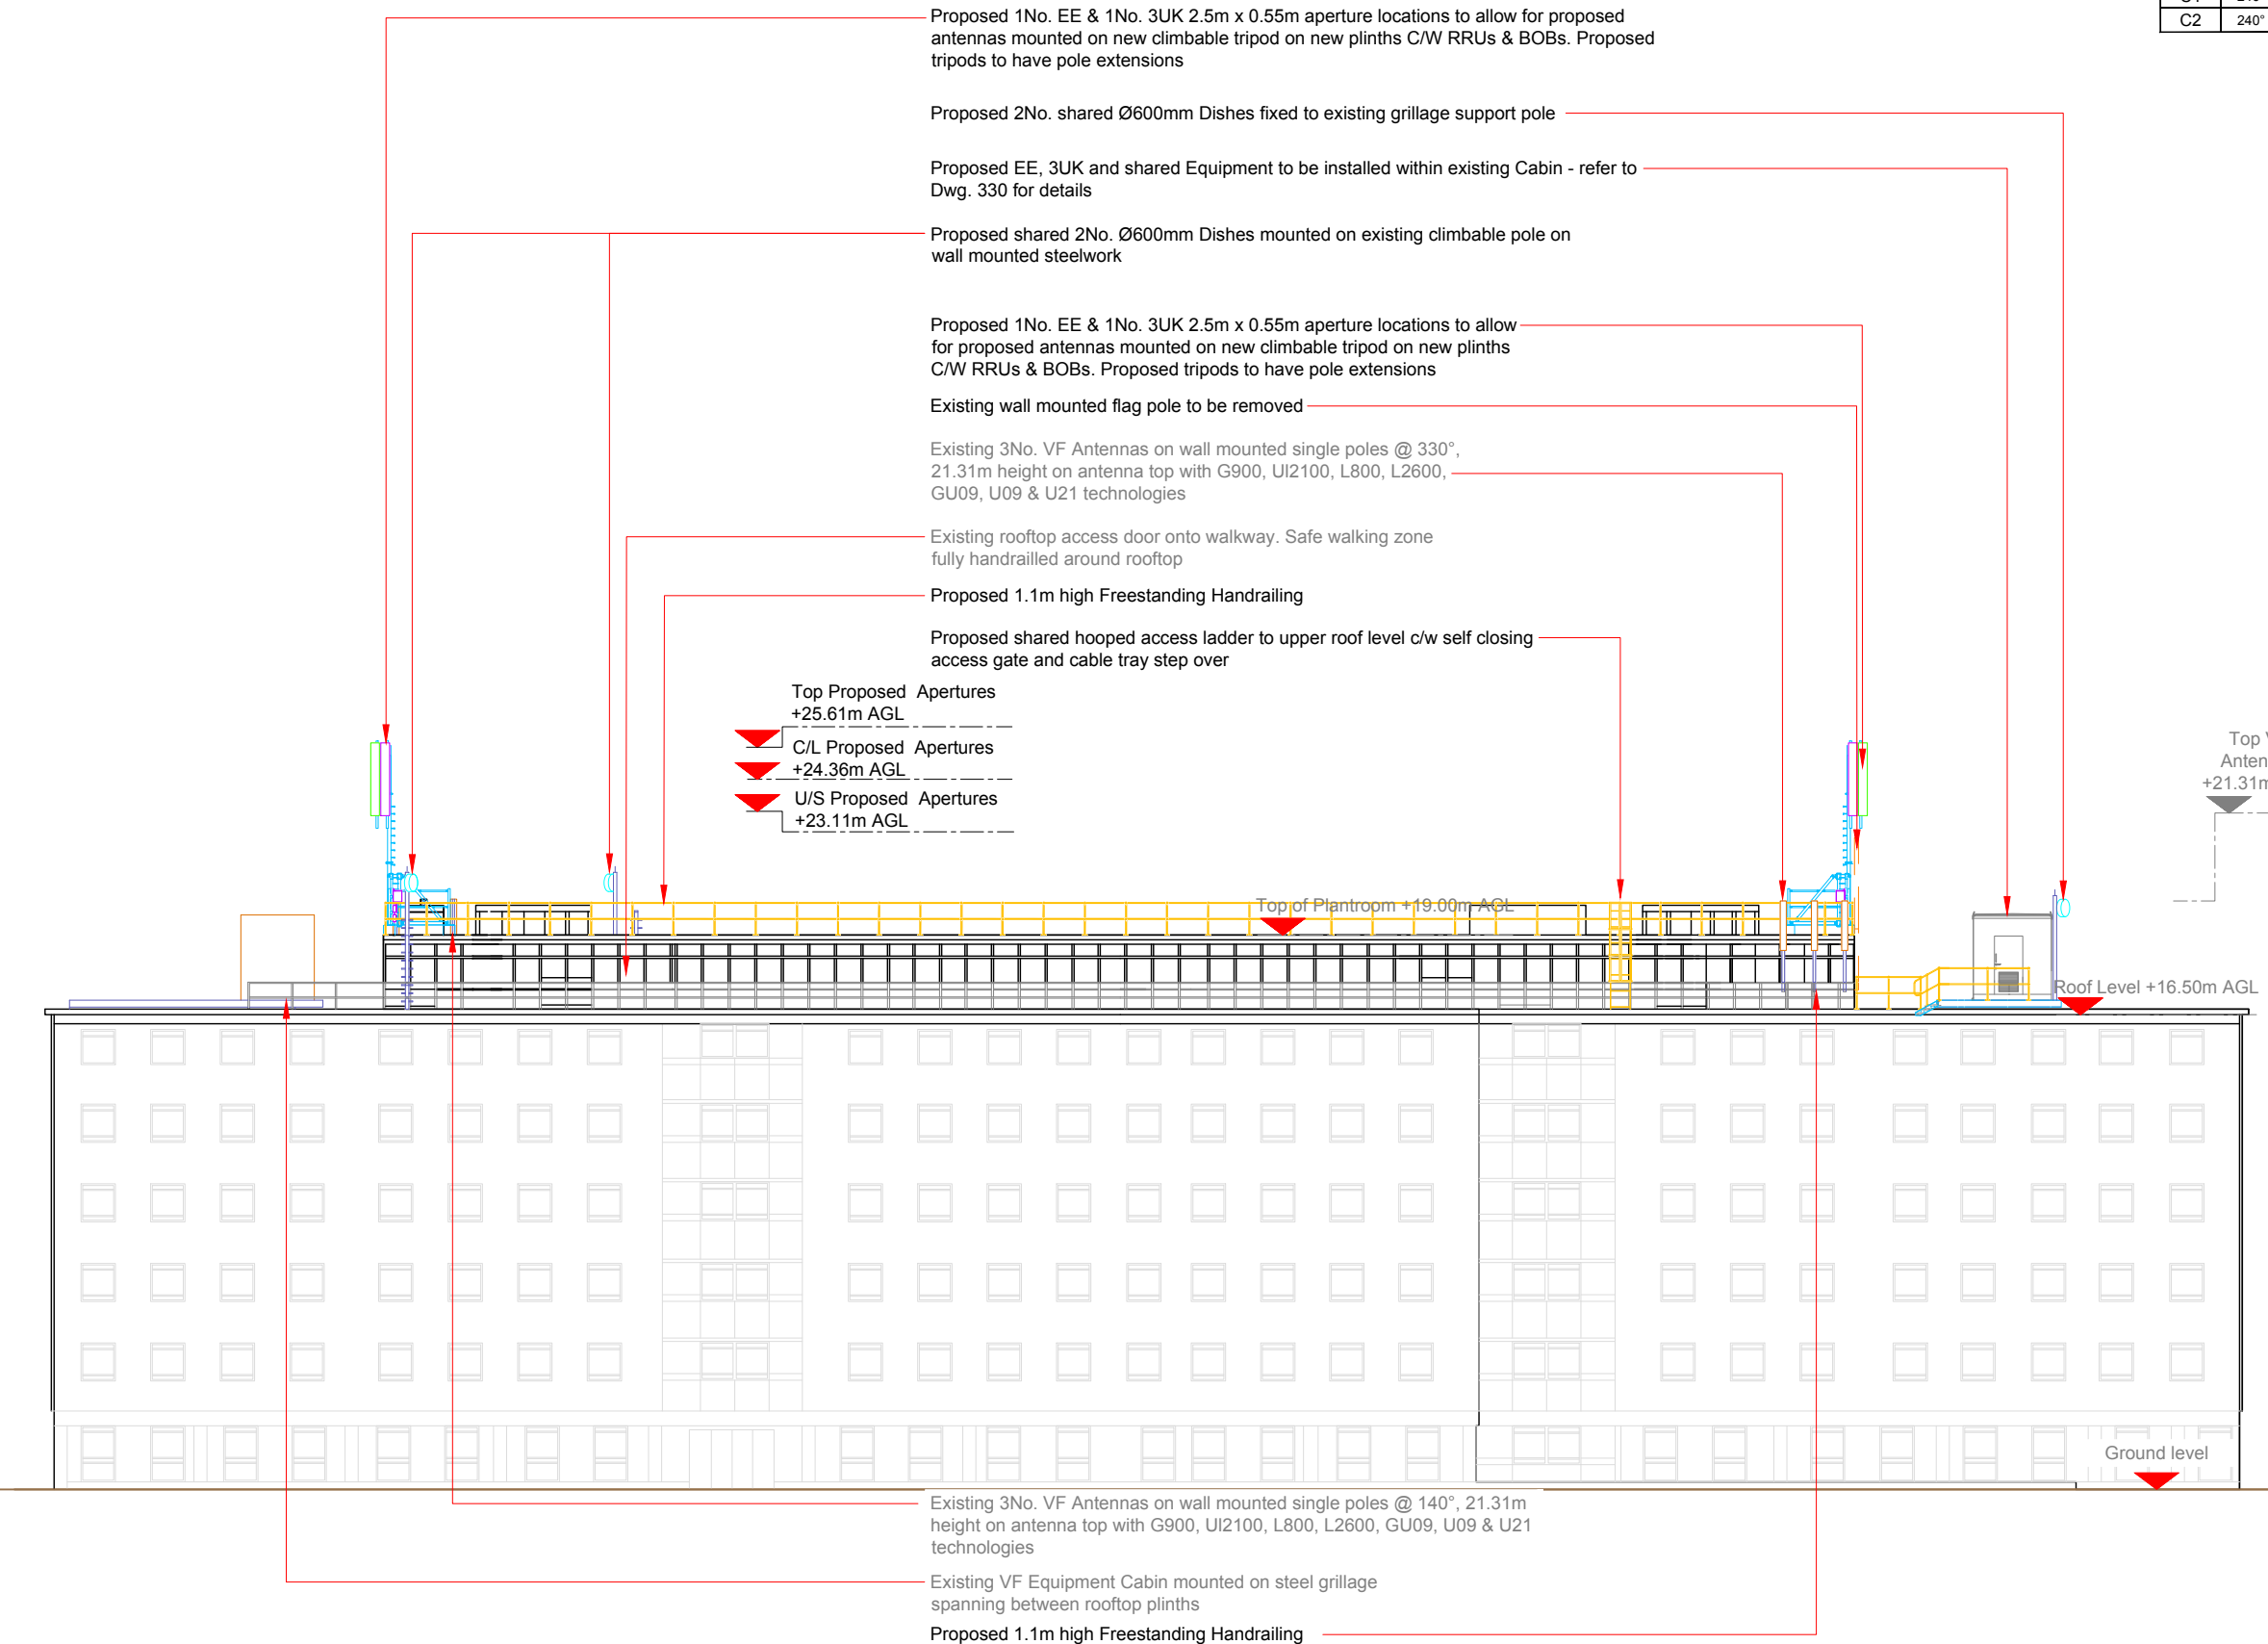

PROPOSED MAX CONFIGURATION ELEVATION

 

Antenna Aperture ID	Proposed 4G/5G Bearing	Operator: Shared/ EE/H3G
A1	0°	EE
A2	0°	H3G
B1	120°	EE
B2	120°	H3G
C1	240°	EE
C2	240°	H3G

NOTES:  
1. ALL DIMENSIONS IN MM UNLESS OTHERWISE NOTED.

Master:	MBNL / EE / H3G:	Project:	Purpose of Issue:	Issue:
M006	MBNL	T&A Strategic	Planning	F
Date:	27/05/2021	Revision / Upgrade Description: Triage/ ProX-5 Approved		
Drawn:	J.Alexander			
Checked:	J.Alexander			
Approved:	S.D.Gilroy			
Master:	MBNL / EE / H3G:	Project:	Purpose of Issue:	Issue:
M005	MBNL	T&A Strategic	Planning	E
Date:	14/05/2021	Revision / Upgrade Description: Bearings Adjusted back to baseline bearings, triage required		
Drawn:	J.Alexander			
Checked:	J.Alexander			
Approved:	S.D.Gilroy			
Master:	MBNL / EE / H3G:	Project:	Purpose of Issue:	Issue:
M004	MBNL	T&A Strategic	Planning	D
Date:	28/04/2021	Revision / Upgrade Description: VF antenna information added		
Drawn:	J.Alexander			
Checked:	J.Alexander			
Approved:	S.D.Gilroy			
Master:	MBNL / EE / H3G:	Project:	Purpose of Issue:	Issue:
M003	MBNL	T&A Strategic	Planning	C
Date:	11/03/2021	Revision / Upgrade Description: Design adjusted with antennas on plantroom roof, configuration changed to H3A		
Drawn:	H.Cameron			
Checked:	J.Alexander			
Approved:	S.D.Gilroy			
Master:	MBNL / EE / H3G:	Project:	Purpose of Issue:	Issue:
M002	MBNL	T&A Strategic	Planning	B
Date:	27/01/21	Revision / Upgrade Description: Drawing taken over by Sitec		
Drawn:	SM			
Checked:	J.Alexander			
Approved:	S.D.Gilroy			



Hutchison 3G UK Limited  
Star House, 20 Grenfell Road  
Maidenhead, SL6 1EH  
Tel: 01628 765 000  
Fax: 01628 765 001  
  
H3G Base Station Information line:  
0845 6043000  
Available 8am-8pm Monday to Friday



Hatfield Business Park  
Hatfield  
Hertfordshire  
AL10 9BW  
  
Tel: 01707 315000  
Fax: 01707 319001



Mobile Broadband Network Limited  
Sixth Floor, Thames Tower, Station Road, Reading, RG1 1LX

Design Consultant & Principal Contractor:



Site Name: INTERNATIONAL HALL

Site ID: 719816

Address: UNIVERSITY OF LONDON  
HALLS OF RESIDENCE  
BRUNSWICK SQUARE CAMDEN  
LONDON  
WC1N 1AX

Title: 265 MAX CONFIGURATION ELEVATION

Project: T&A STRATEGIC

Purpose of Issue: PLANNING

EE Cell ID: 98466	MBNL Cell ID: CMN038	3UK Cell ID: WC0034
----------------------	-------------------------	------------------------

Master Drawing No: 719816_CMN038_98466_WC0034_M006	Issue: F
---	-------------

Passive Infrastructure Equipment Capacity & Lead Operator			
A	B	C	LEAD
H3a	H3a	H3a	EE