


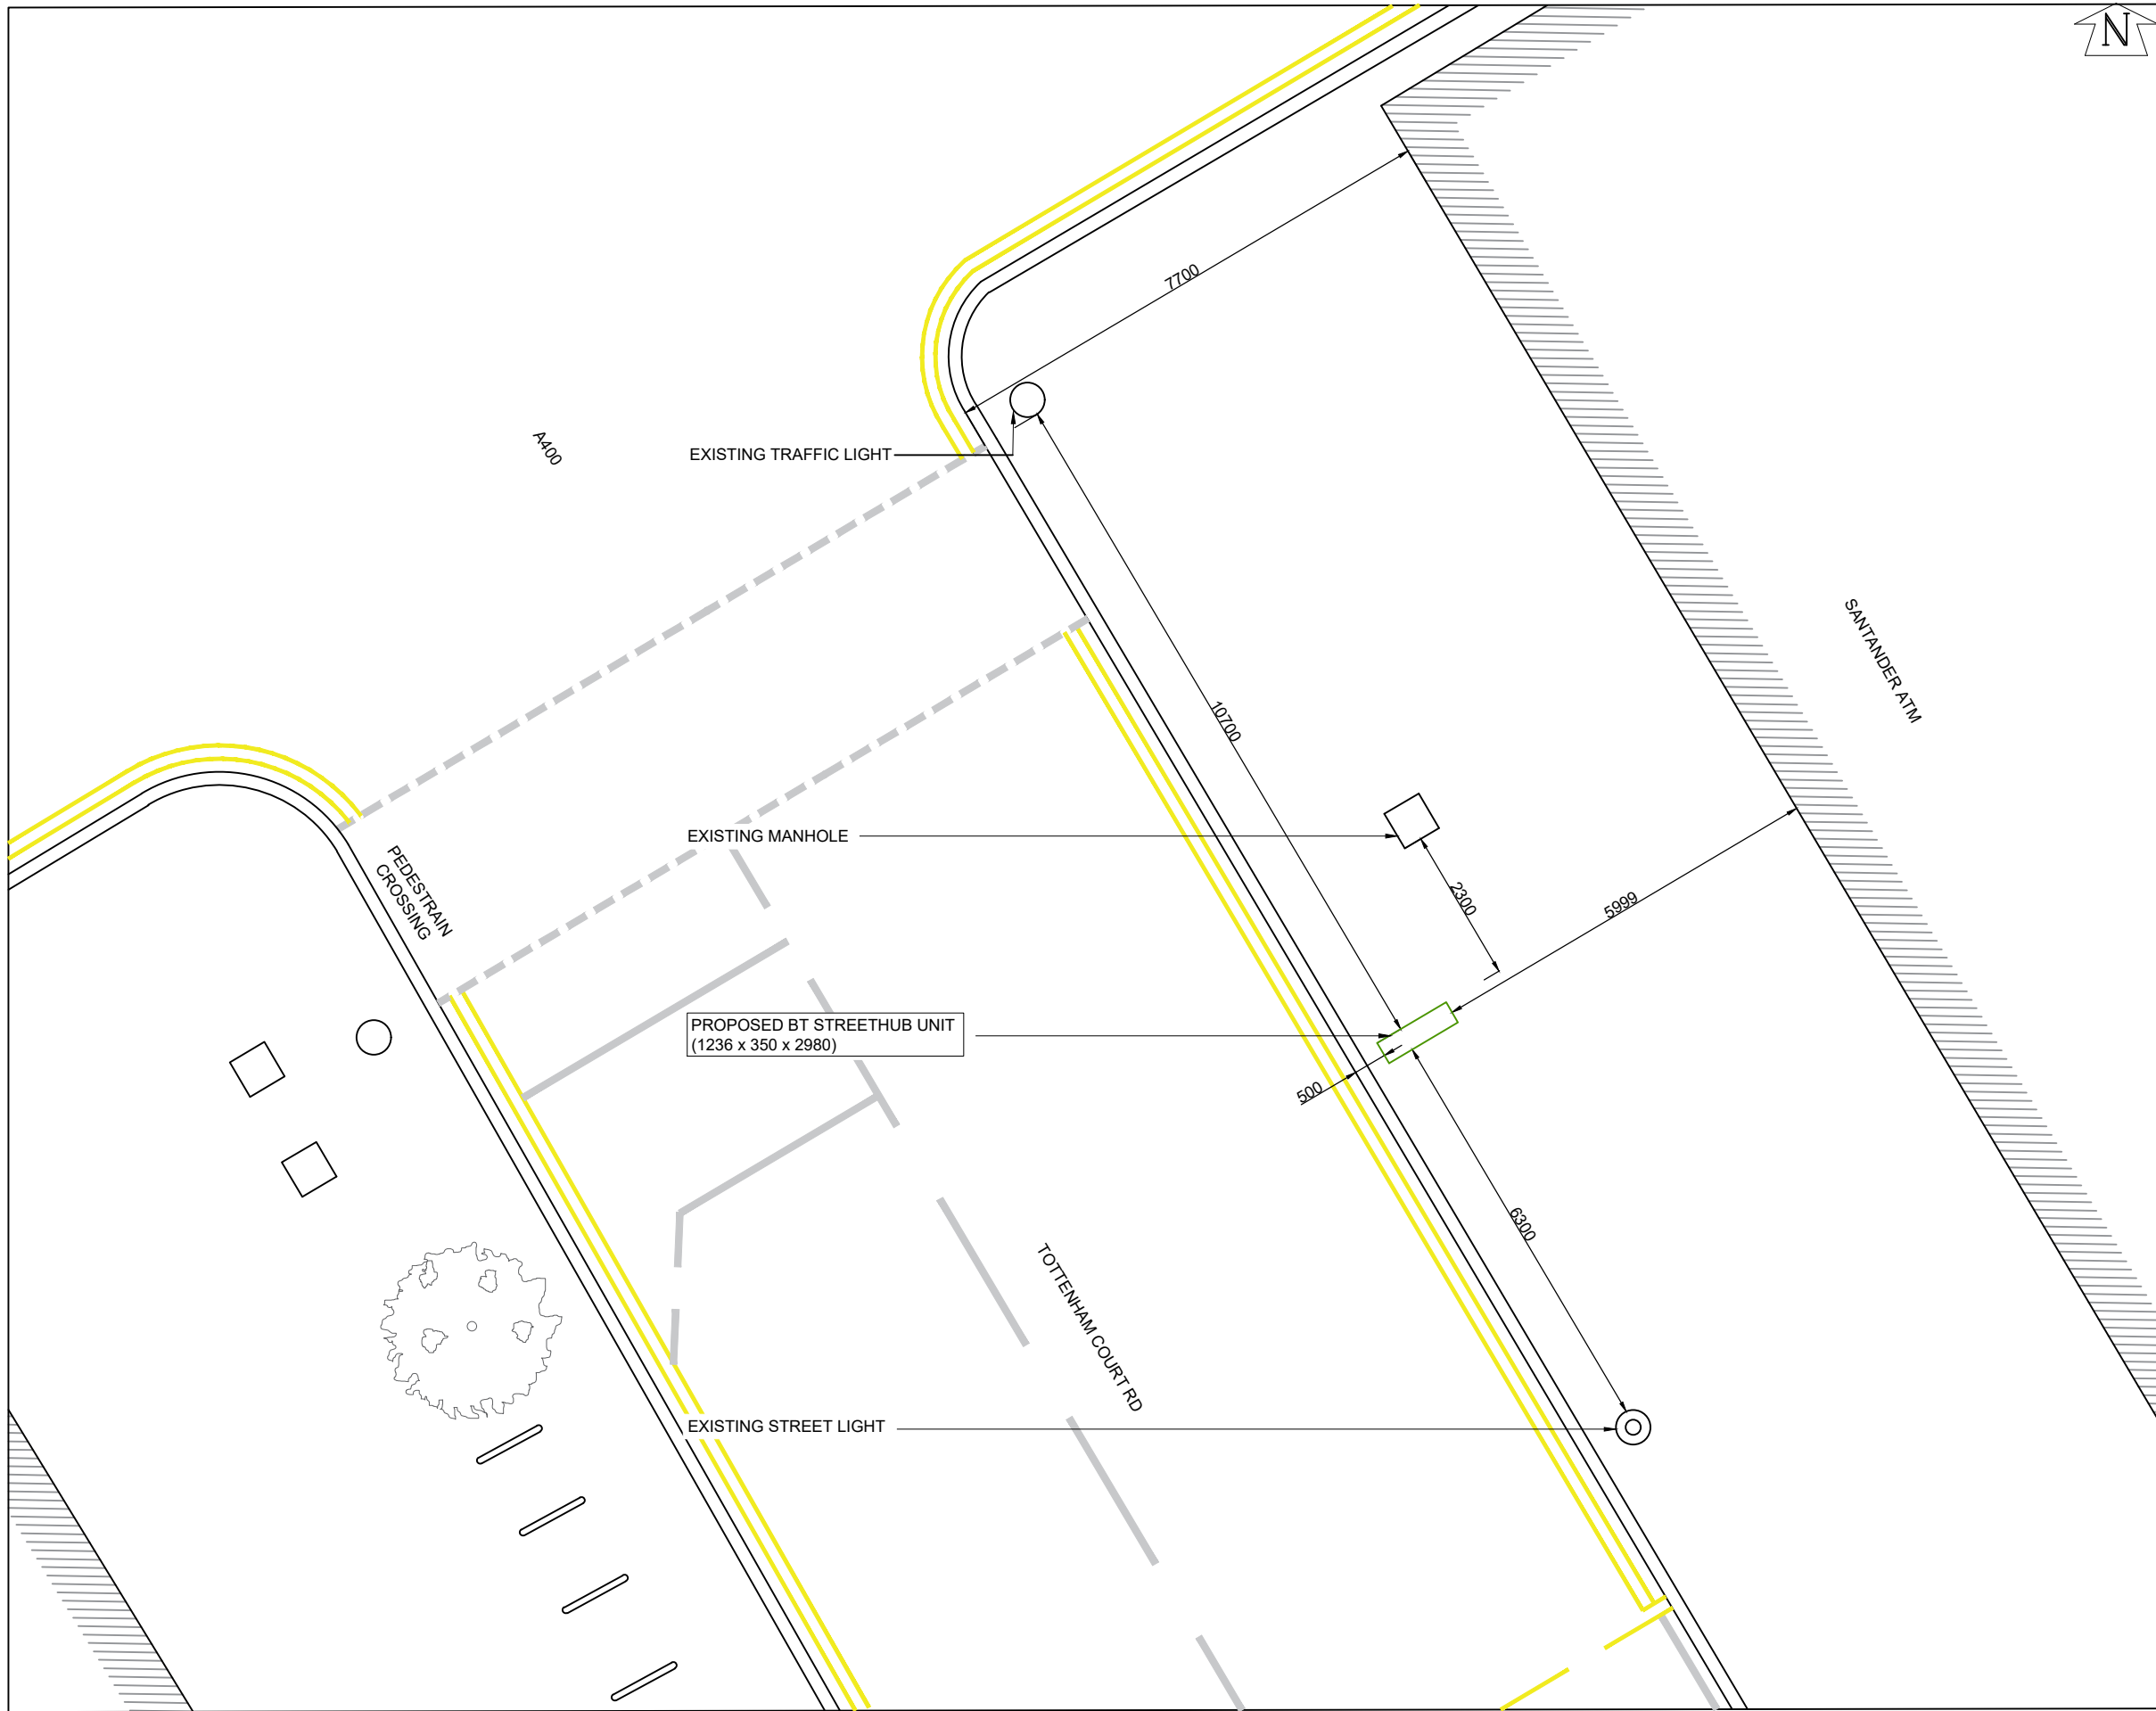

PROPOSED SITE PLAN
SCALE 1:100



GENERAL NOTES

Use written dimensions only, do not scale from drawing. Use latest revision of all referenced information.

Rev	Date	Description	Drawn	Chkd
A	19.07.21	New BT Streethub Structure	MD	JE

mono  MONO CONSULTANTS LIMITED
70-76 Steam Packet House
Cross Street
Manchester, M2 4JG
t. 44 (0)161 839 8839
www.monoconsultants.com



Drg Status
PLANNING

Cell No. & Name

CAM007

Site Name & Address

Pavement o/s 164-167
Tottenham Court Rd, London
W1T 7JE

Drawing Title
PROPOSED SITE PLAN

Scale 1:100 Date 19.07.21

Drawn By MD Checked By JE

Drawing Number 002 Revision A