


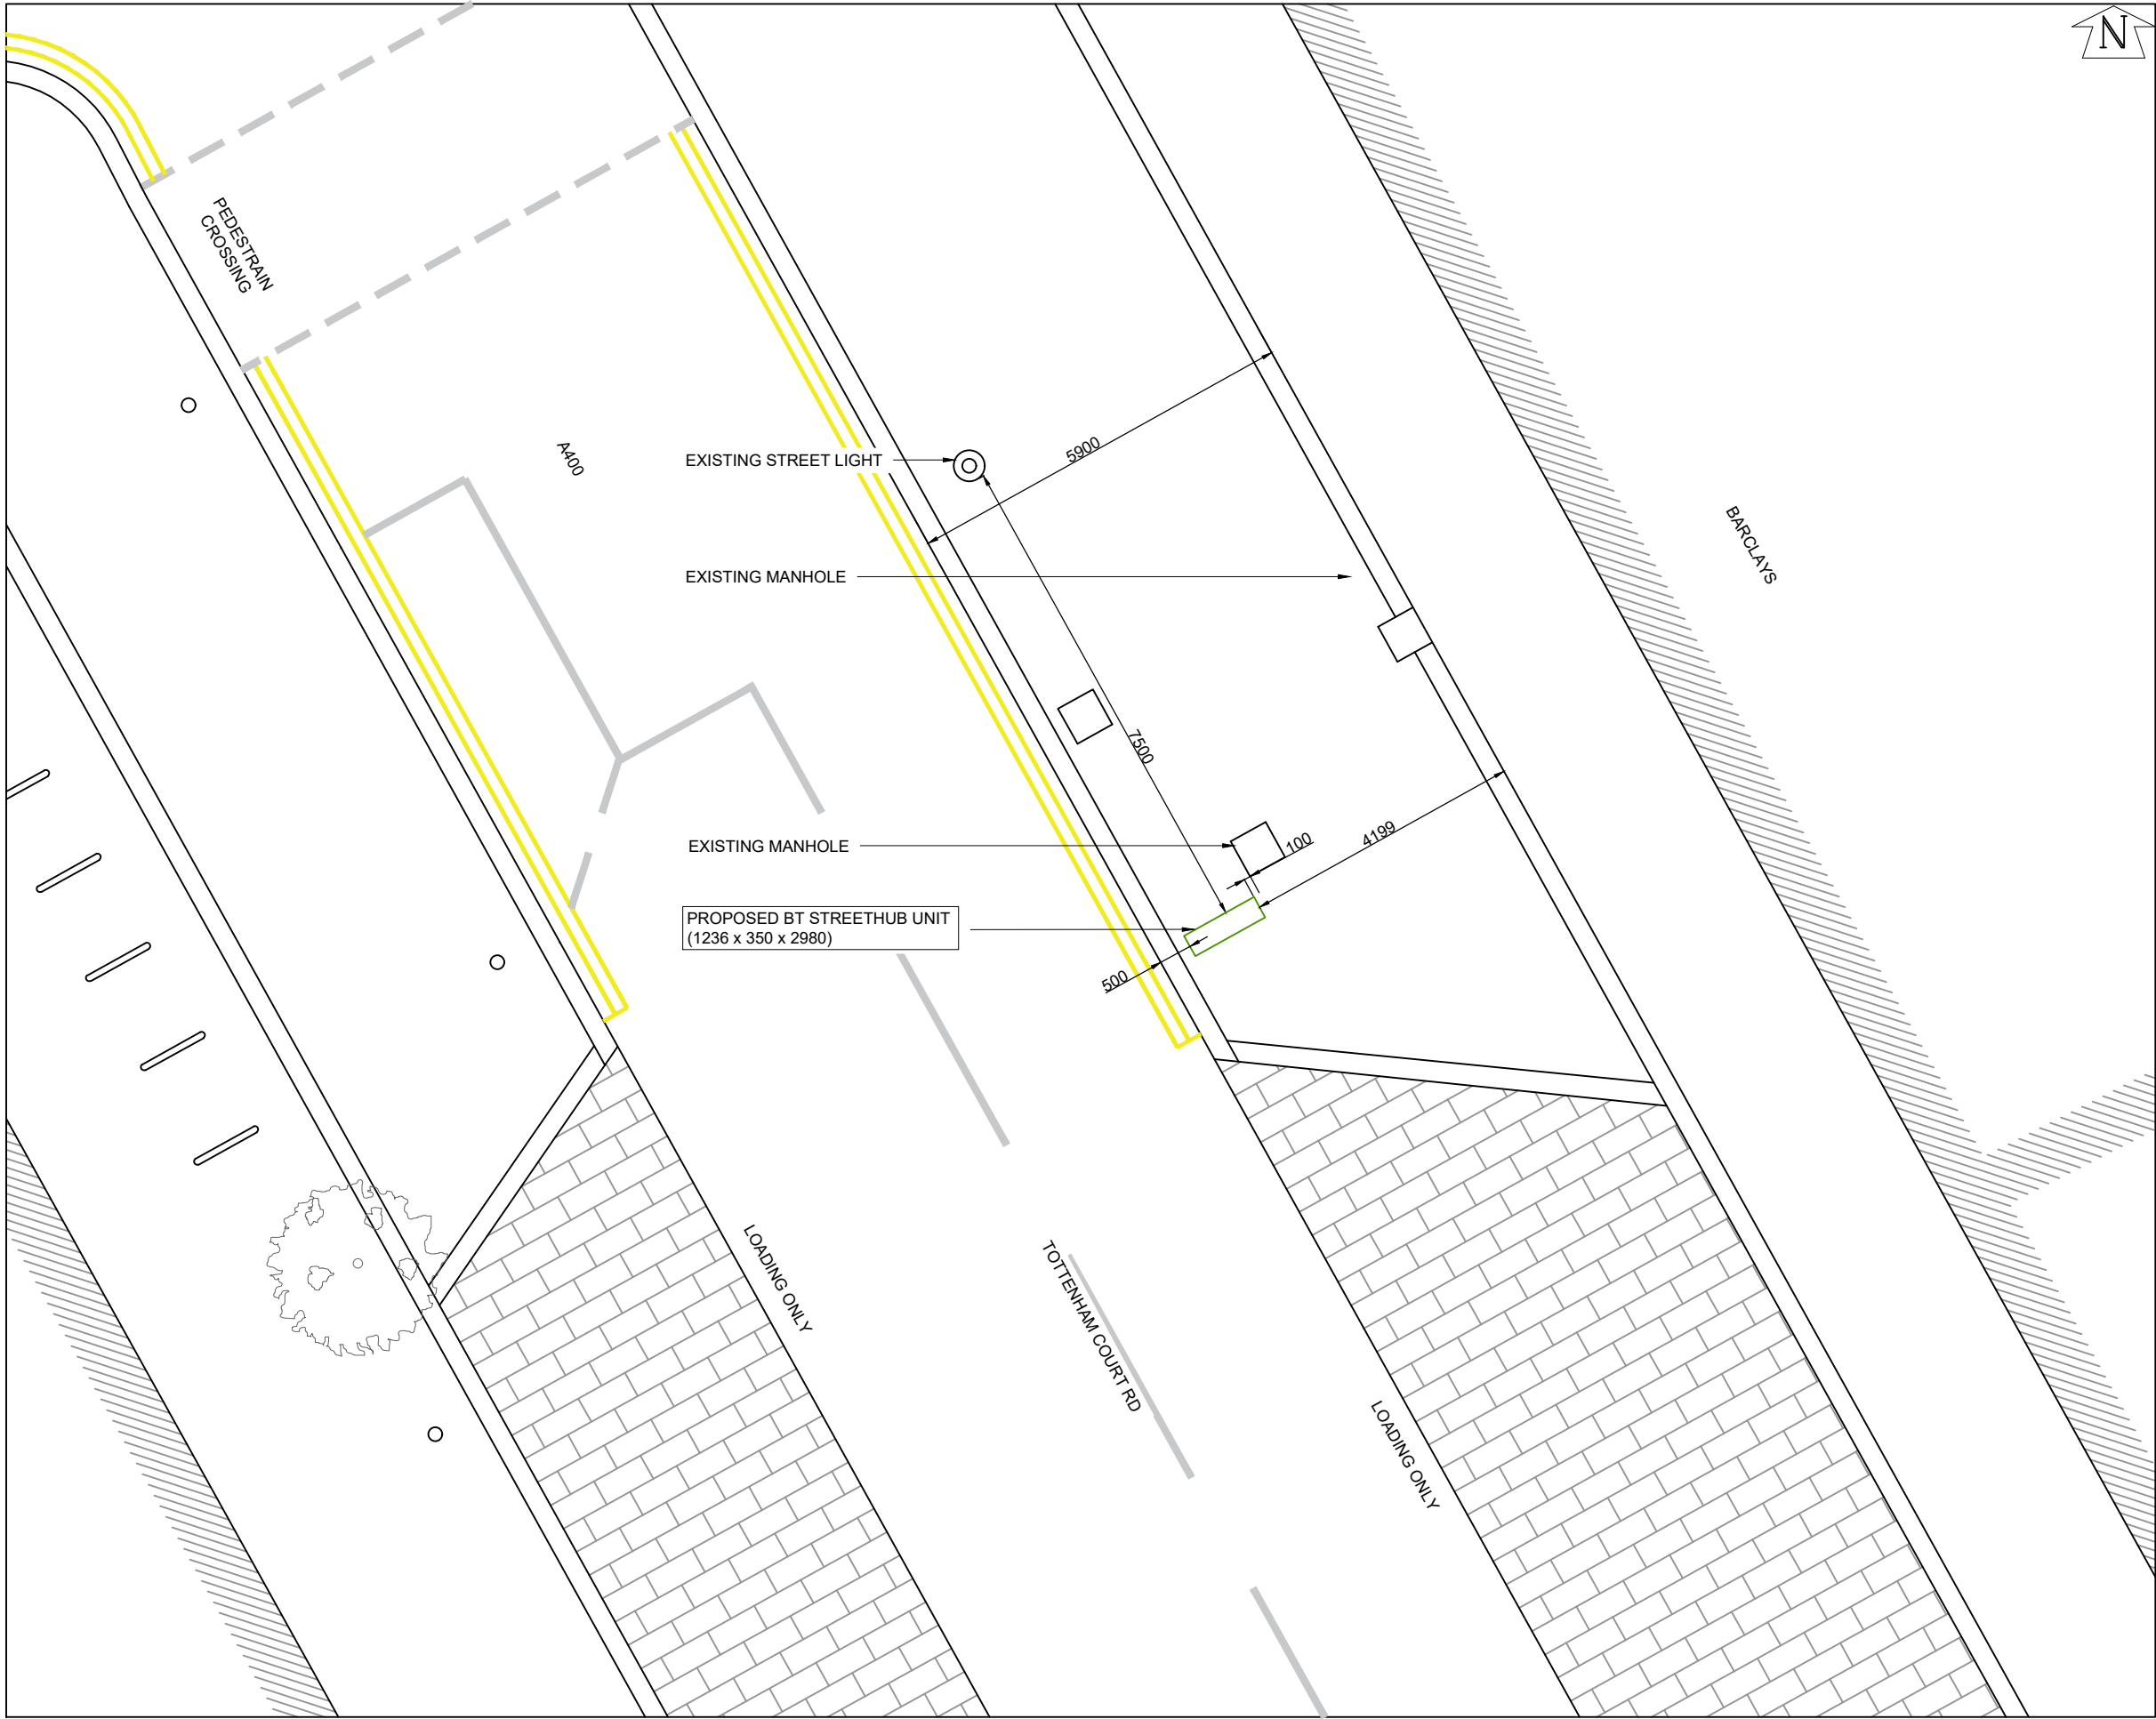

GENERAL NOTES

Use written dimensions only, do not scale from drawing. Use latest revision of all referenced information.

A	20.07.21	New BT Streethub Structure	MD	JE
Rev	Date	Description	Drawn	Chkd



MONO CONSULTANTS LIMITED
70-76 Steam Packet House
Cross Street
Manchester, M2 4JG
t. 44 (0)161 839 8839
www.monoconsultants.com



Drg Status
PLANNING

Cell No. & Name

CAM008

Site Name & Address

Pavement outside 155 Tottenham Court Rd, London W1T 1BH

Drawing Title
PROPOSED SITE PLAN

Scale	1:100	Date	20.07.21
Drawn By	MD	Checked By	JE
Drawing Number	002	Revision	A